


AUBURN RIDGE ROAD

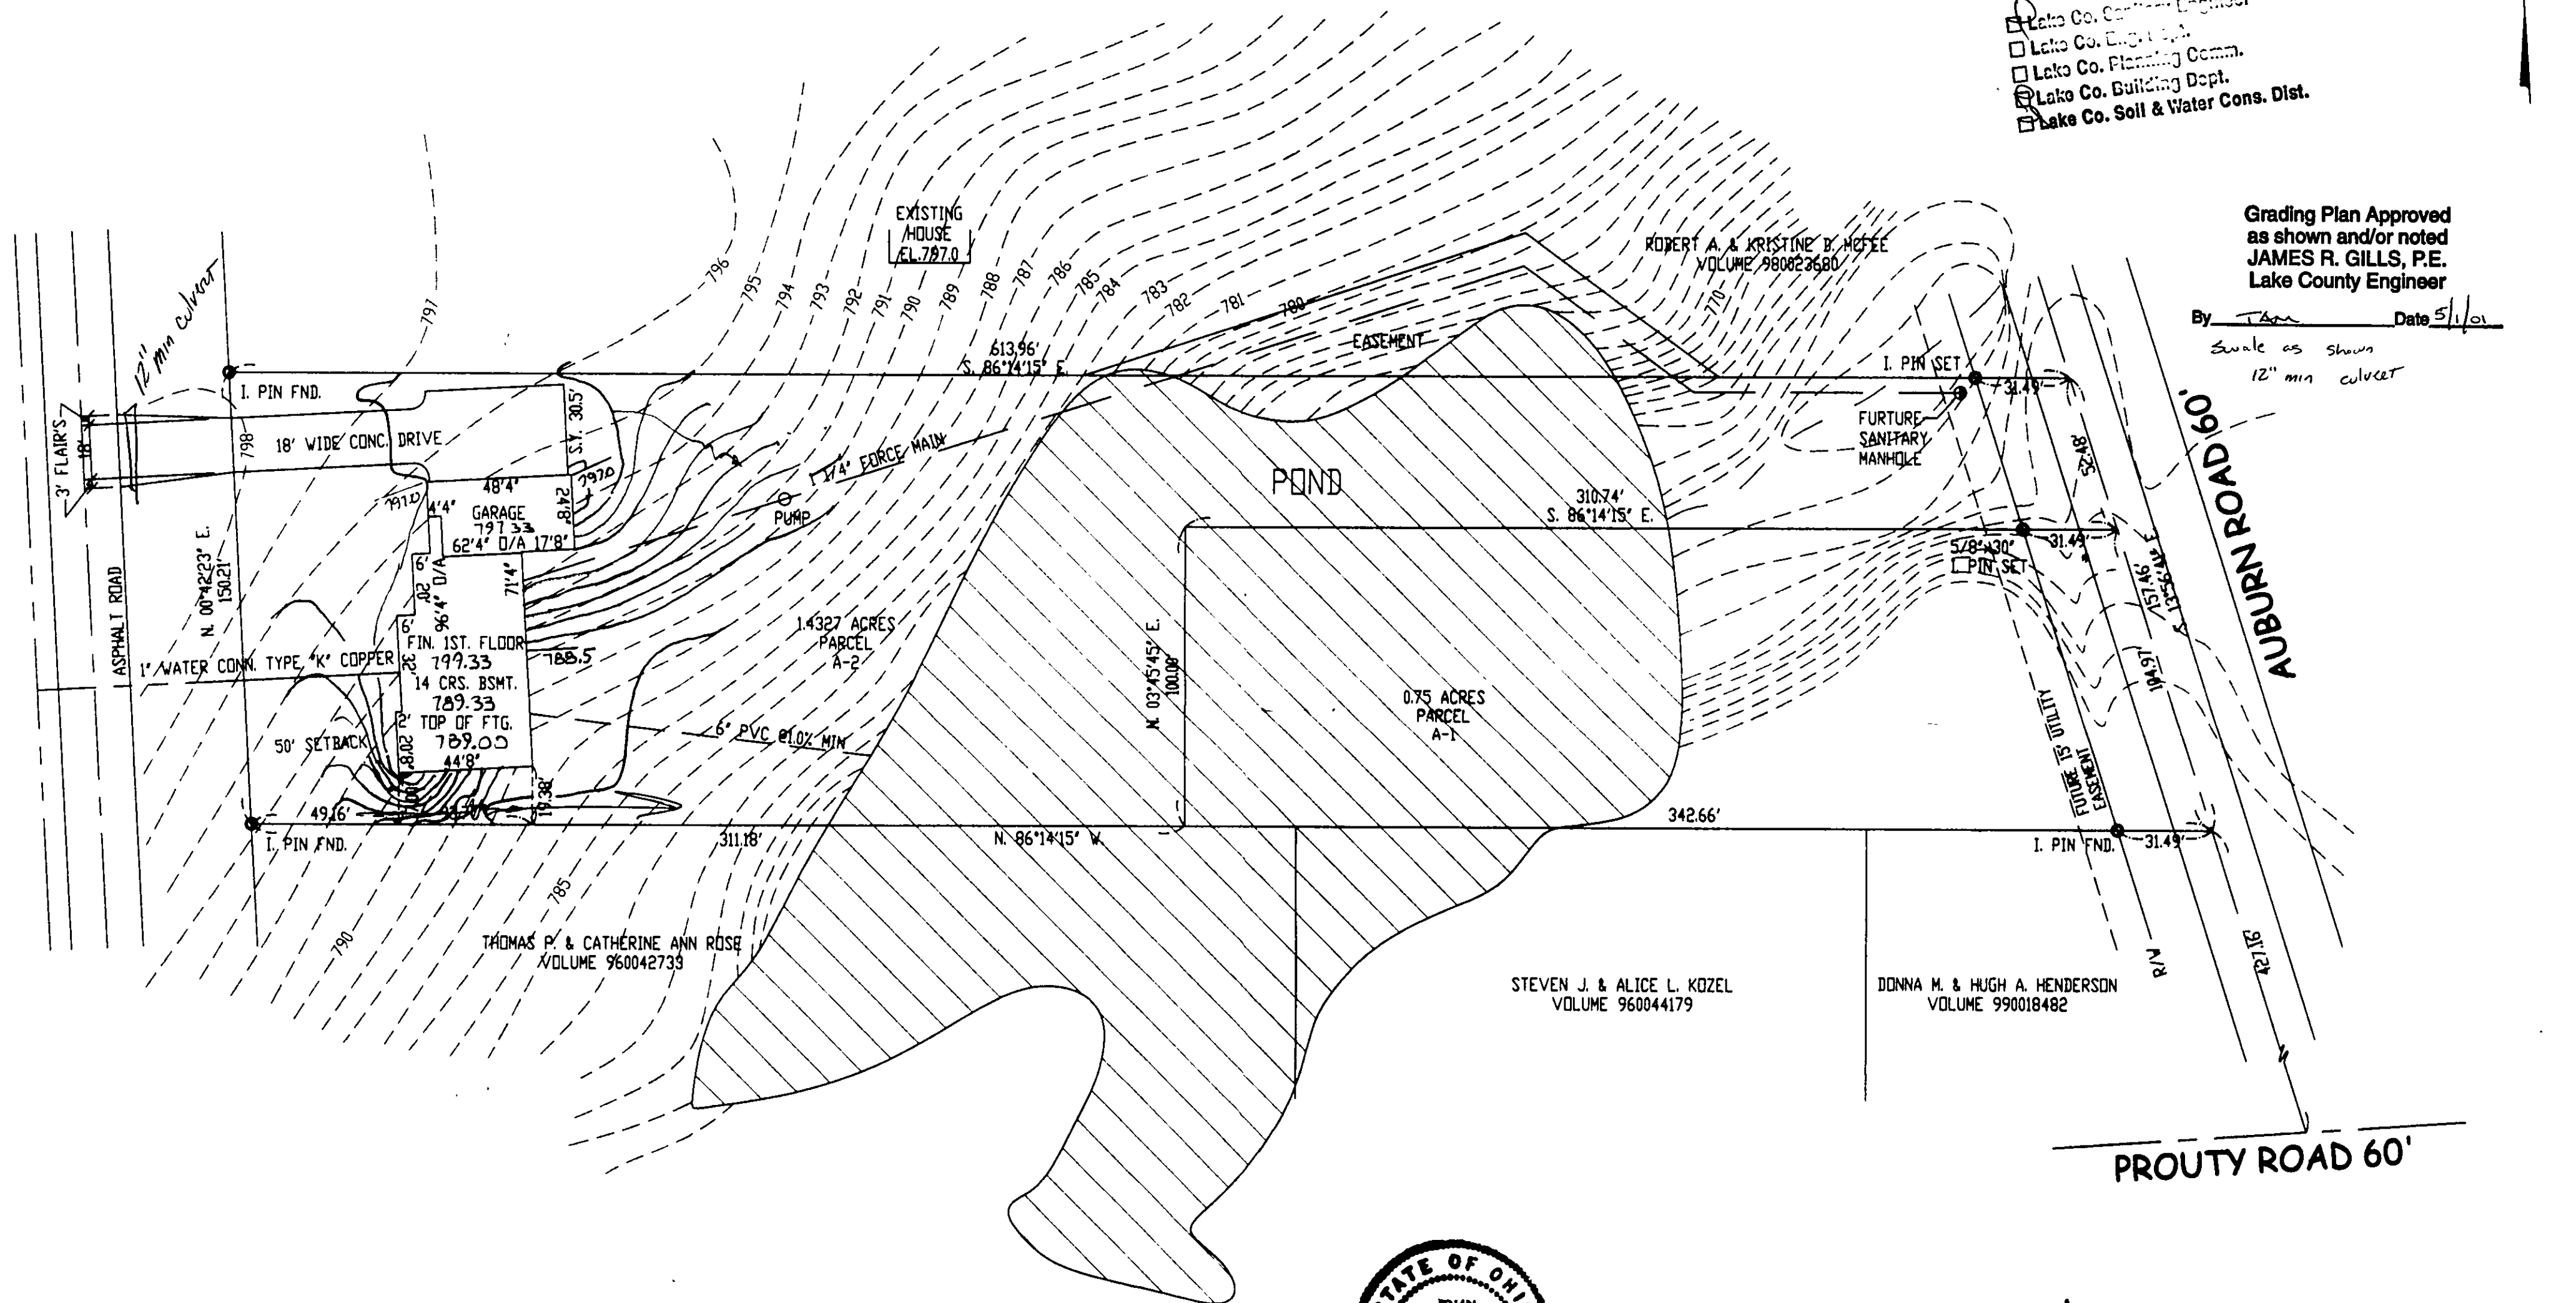

CONCORD TOWNSHIP ZONING OFFICE
ZONING PERMIT # 0401-1013
ISSUED 4-27-01
SUBJECT TO APPROVAL BY:
☒ Lake Co. Sanitary Engineer
☐ Lake Co. Eng. Dept.
☐ Lake Co. Planning Comm.
☒ Lake Co. Building Dept.
☐ Lake Co. Soil & Water Cons. Dist.

Grading Plan Approved
as shown and/or noted
JAMES R. GILLS, P.E.
Lake County Engineer

By TAM Date 5/1/01
Scale as shown
12" min. culvert




I CERTIFY THAT THIS PLAN
WAS PREPARED BY ME AND
IS CORRECT TO THE BEST OF
MY KNOWLEDGE AND BELIEF

John C. Skonieczny
REG. SURVEYOR #8356

JOHN C. SKONIECZNY
7739 VIEWMOUNT DR.
PAINESVILLE, OHIO 44077
PH. 352-7742

GRAPHIC SCALE

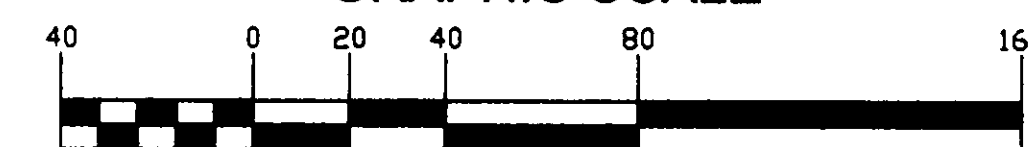

1 inch = 40 ft.

SITE PLAN FOR:
HAL & GAYLE SIKULA

SCALE: 1" = 40'	APPROVED	DRAWN BY: SWC
DATE: DEC. 00		REVISED
BEING P.P.#08A-018-00-059 RECORDED IN DDC. #200021574 L.C.R.D.		
TOWNSHIP OF CONCORD - COUNTY OF LAKE - STATE OF OHIO		
JOB# 00-3000	DRAWING NUMBER 00-1887	

NOTE 1
EXCAVATING CONTRACTOR TO FIELD VERIFY
SERVICE CONNECTION LOCATION AND ELEVATIONS
PRIOR TO BASEMENT EXCAVATION.

--- EXISTING GRADES
--- PROPOSED GRADES

--- SWALE



2 WORKING DAYS
BEFORE YOU DIG

CALL TOLL FREE 800-362-2764
OHIO UTILITIES PROTECTION SERVICE