




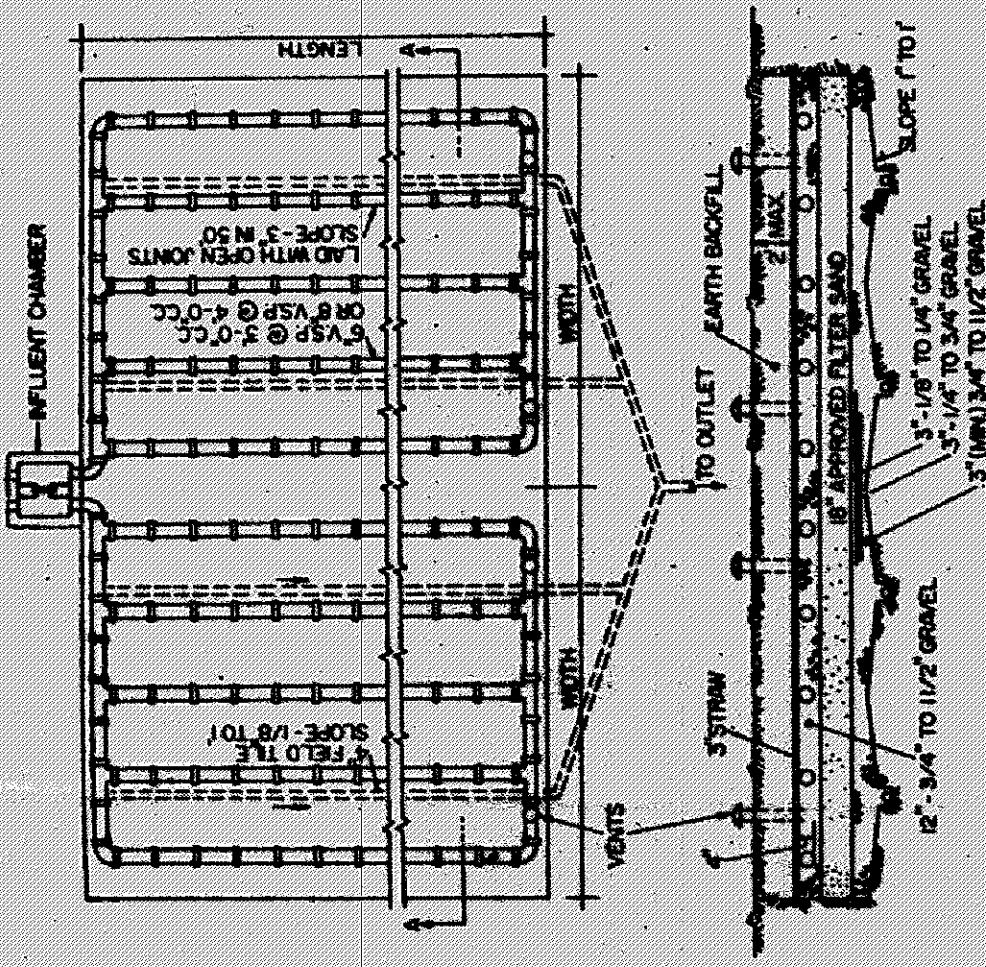

SECTION A-A

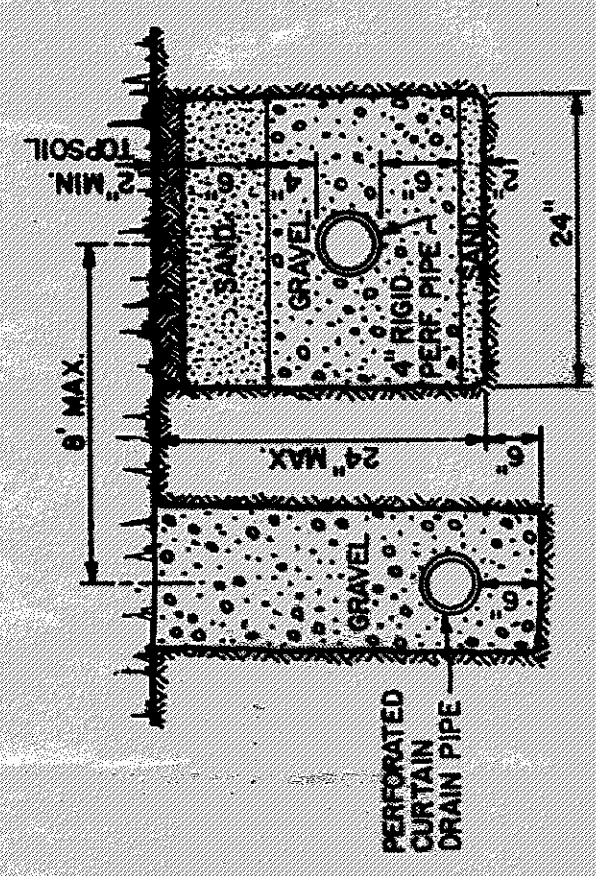

TRENCH DETAIL

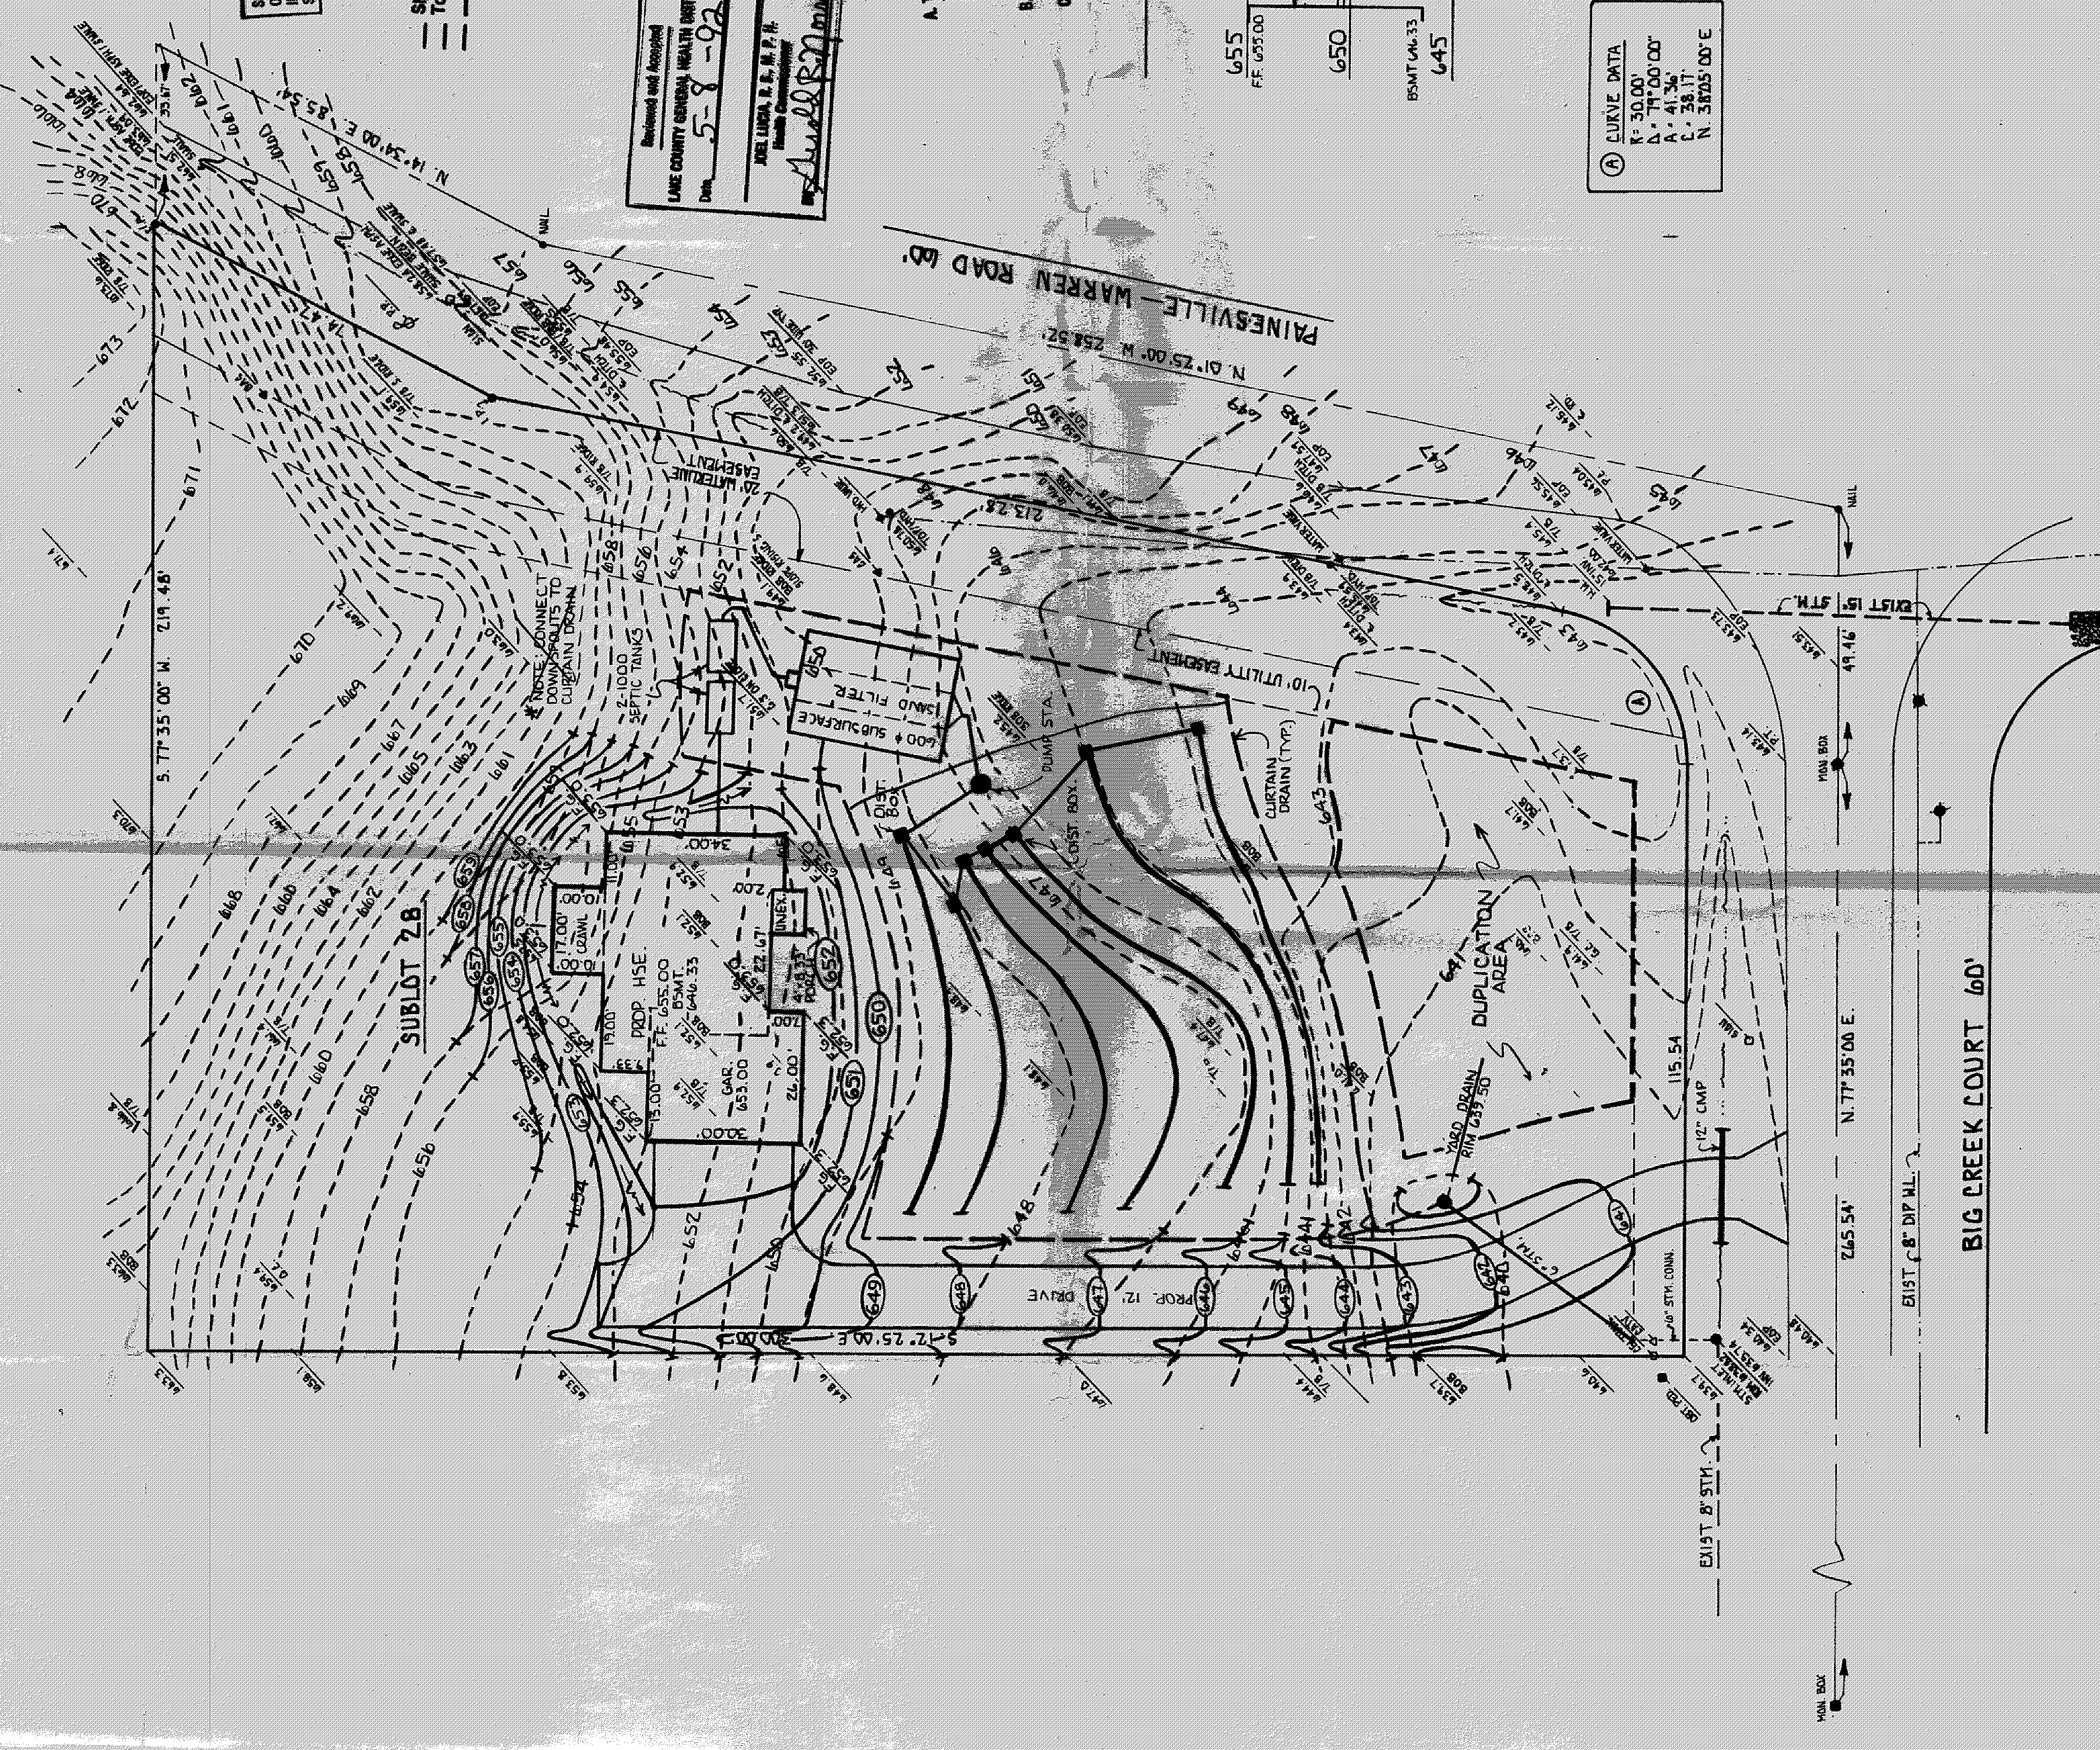


SEWAGE DISPOSAL PERMIT MUST BE OBTAINED BY A LAKE COUNTY LICENSED INSTALLER BEFORE INSTALLATION IS STARTED.

LOW YIELD WATER FIXTURES REQUIRED ON ALL Shower Head Toilet

Reviewed and Accepted
LAKE COUNTY GENERAL HEALTH DISTRICT
Date: 5-8-92
JANEL LINDA, R.E., M.P.E.
Health Commissioner

- A. To be brought to finished grade:
1. Septic tank manhole covers
2. Splitter box cover
3. Distribution box cover
B. No fewer drains of manholes to be discharged into septic tanks
C. All waste water to be discharged into septic tanks

SCALE = 1" = 20'

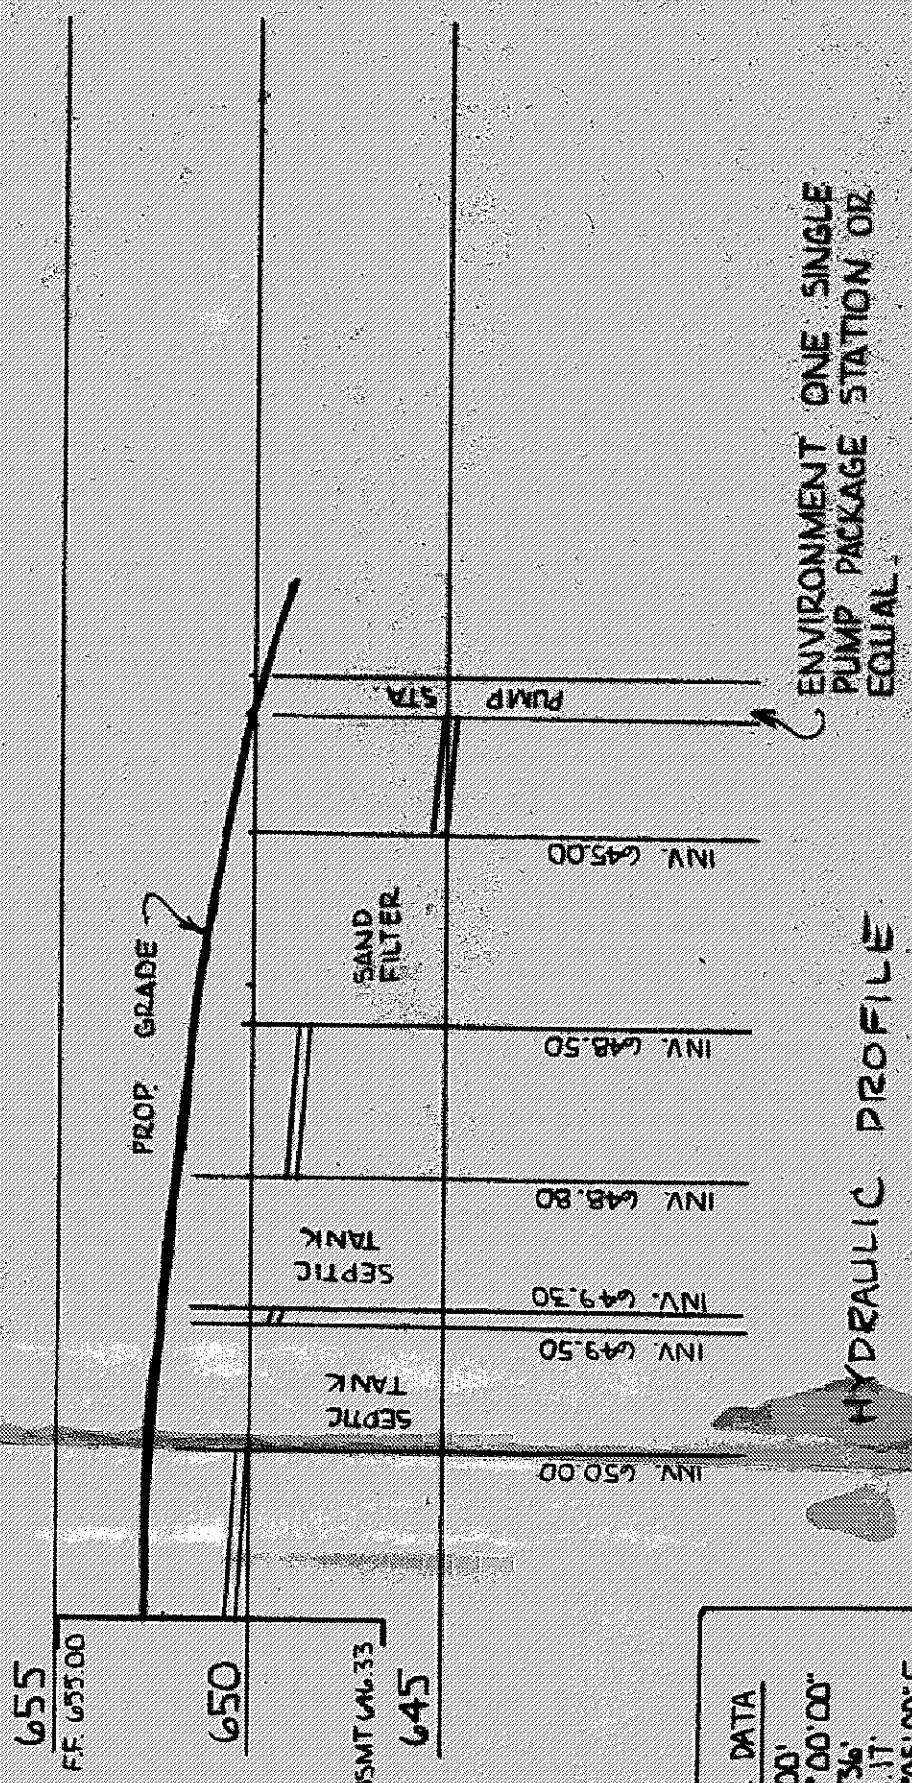

① CURVE DATA
R = 50.00'
P = 100.00'
A = 41.34°
C = 38.17'
N 37.05 00° E

Grading Plan Approved as shown and/or noted
THOMAS P. GILLES, P.E.
Lake County Engineer

BY: [Signature]
DOWNSPOUS SHALL BE SPASH BLOCKED

ZONING PERMIT
ISSUED 5-11-92

SUBJECT TO APPROVAL BY:
Lake County Sanitary Eng. ☐
Lake County Eng. Dept. ☒
Lake County Planning Comm. ☐
Lake County Bldg. Dept. ☒

for: JOHNSON & SON BUILDERS

28 BIG CREEK SUBDIVISION

LAKE TOWNSHIP CONCORD

Land Design Consultants
Civil Engineers and Surveyors
10000 E. 12th Ave., Suite 200, Denver, CO 80231
Tel: 303-751-1200

DESIGN CERTIFICATION
THIS PLAN WAS PREPARED BY ME AND IS CORRECT TO THE BEST OF MY KNOWLEDGE AND BELIEF

CERTIFICATE
I, [Signature], a duly Licensed Professional Engineer, do hereby certify that the above described work was done by me or under my direct supervision and that I am a duly Licensed Professional Engineer in the State of Ohio.

STATE OF OHIO
DIVISION OF SURVEYING
REGISTERED PROFESSIONAL ENGINEER
No. 10592