


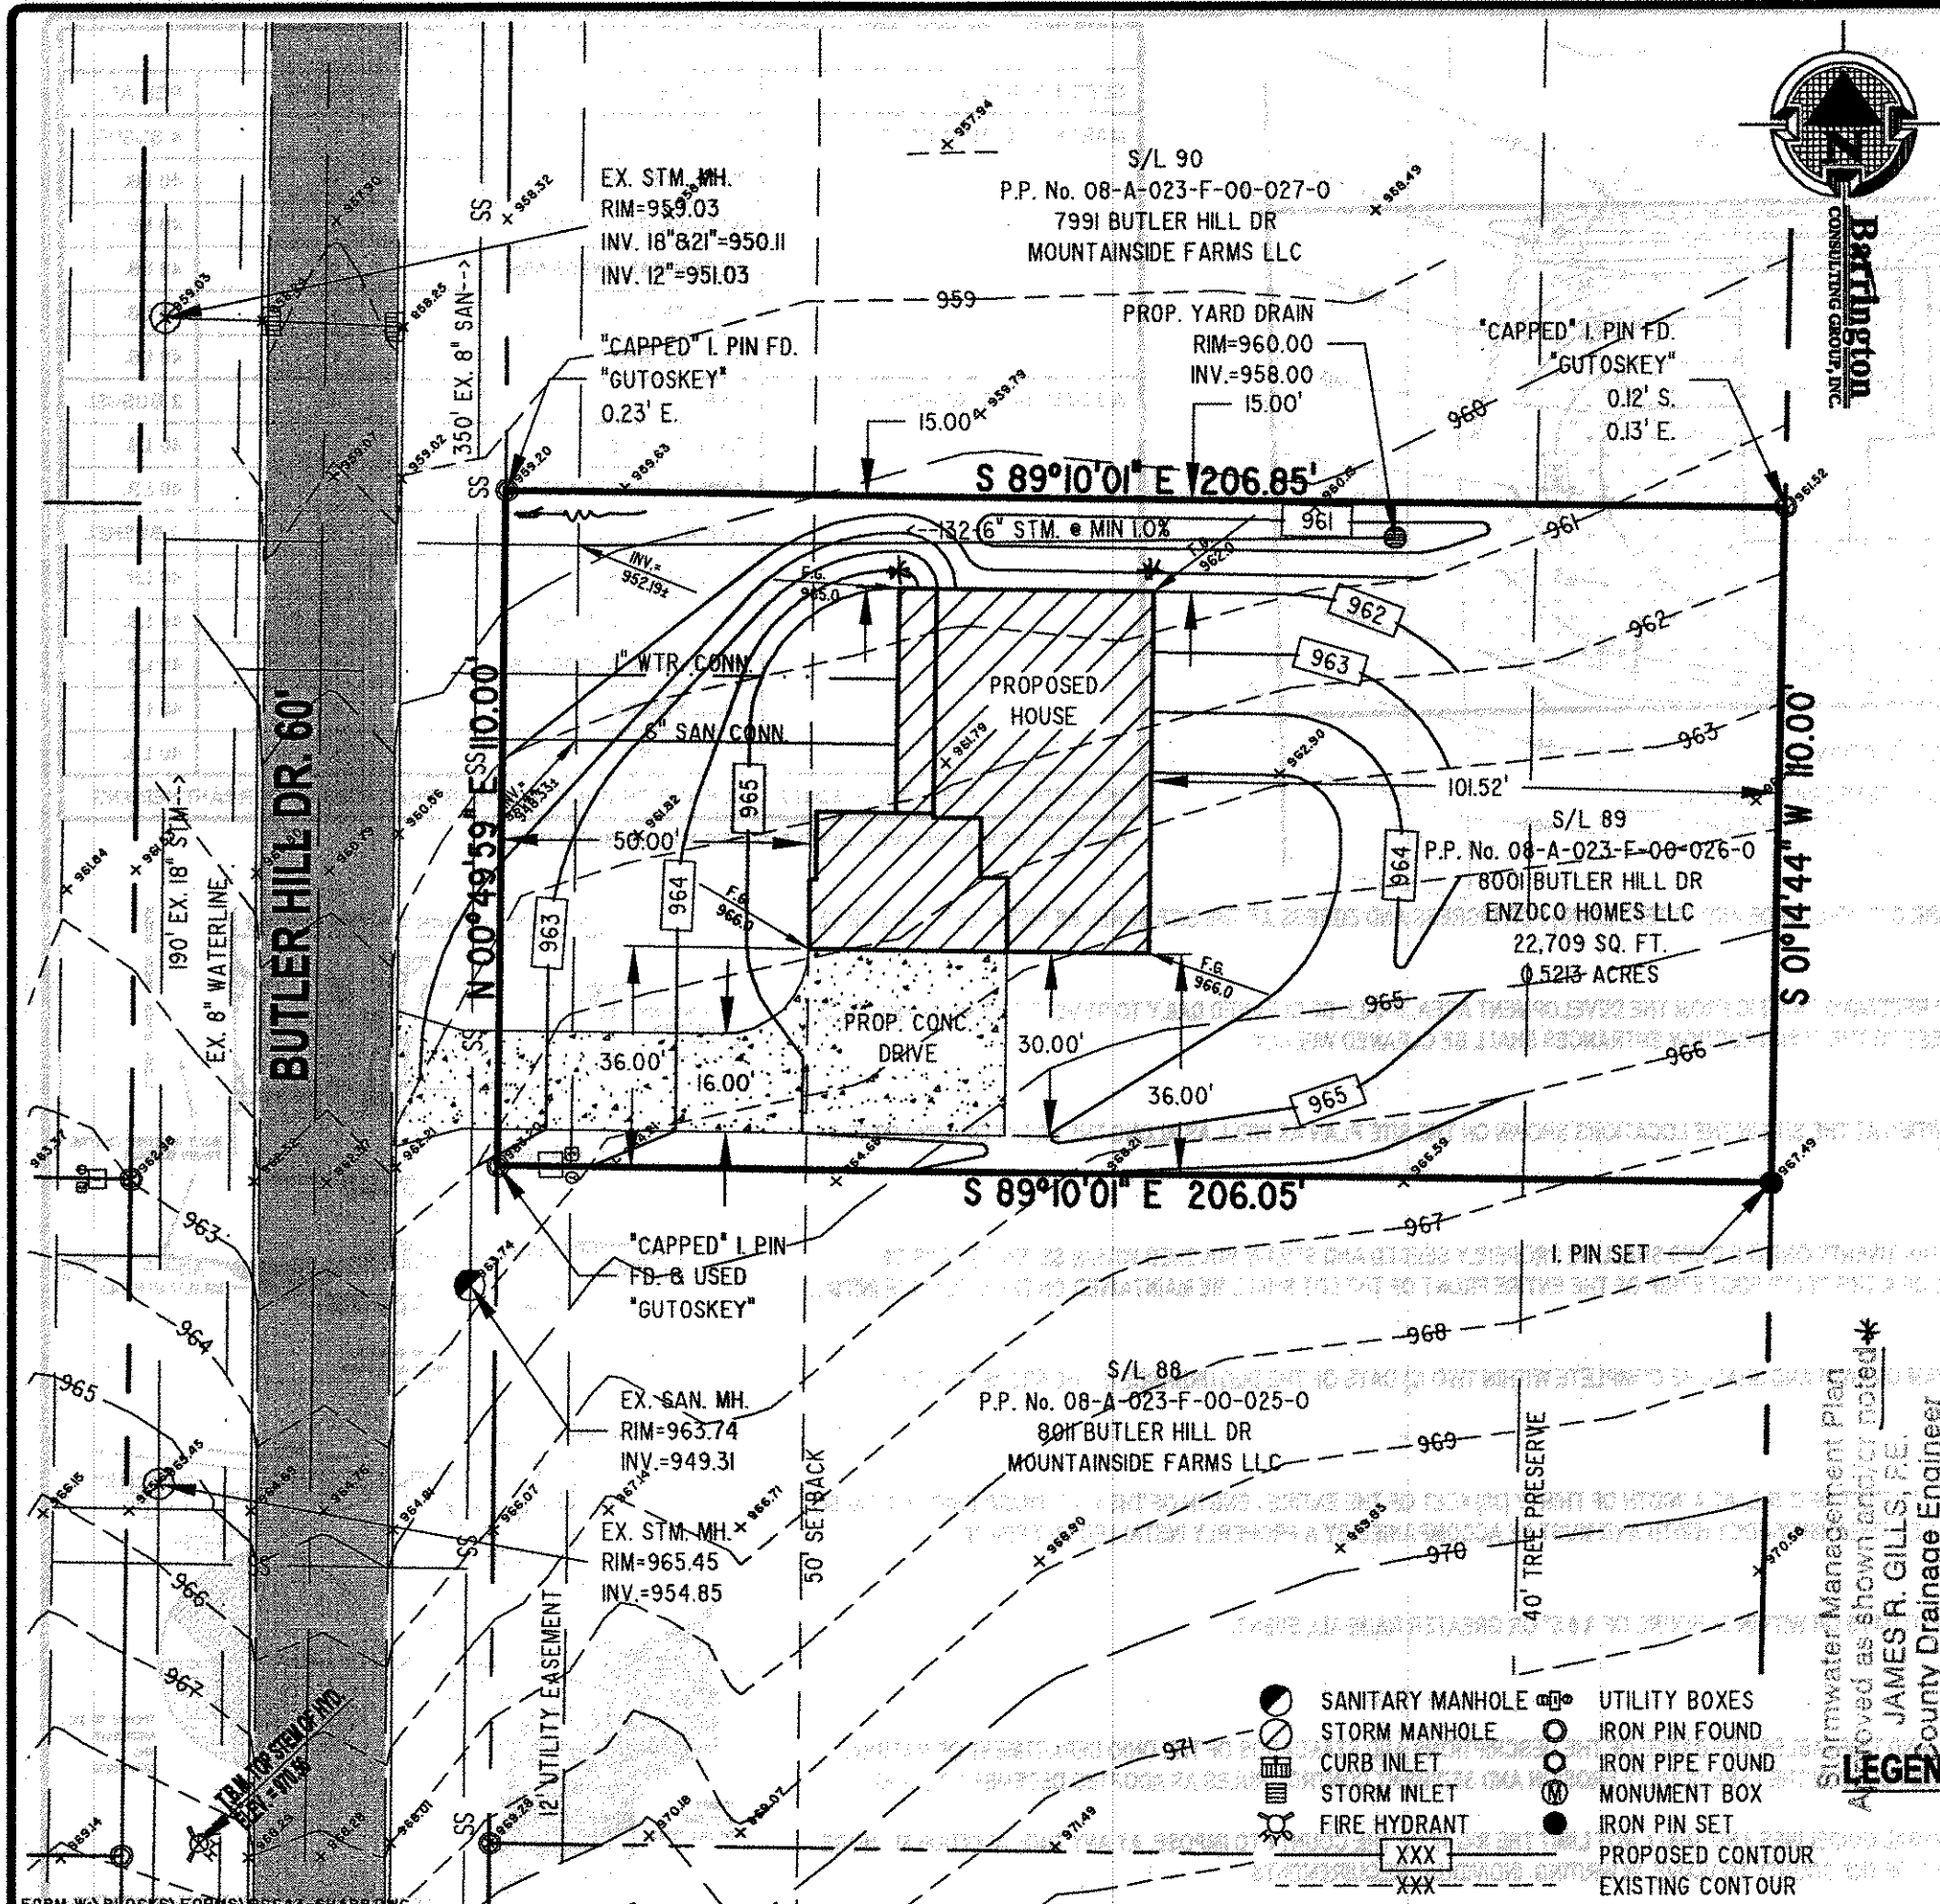

GENERAL NOTES:

1. BENCHMARK - TOP STEM OF EXISTING FIRE HYDRANT LOCATED IN FRONT SUBLT 73, ELEVATION = 970.56.
2. DRIVEWAY APRON TO BE 6\"/>


CERTIFICATION :

"I THE UNDERSIGNED HEREBY CERTIFIES THAT THIS TOPOGRAPHY INDICATED BY 1 FOOT CONTOURS AND ELEVATION SHOWN HEREON REPRESENTS AN ACTUAL SURVEY MADE BY ME ON THE 6th DAY OF JULY, 2012 AND THE ELEVATIONS WERE TAKEN AT AN APPROPRIATE INTERVAL AND AS OF THAT DAY THEY EXISTED AS INDICATED HEREON.

"I HEREBY CERTIFY THAT THIS PLAN WAS PREPARED BY ME AND IS CORRECT TO THE BEST OF MY KNOWLEDGE AND BELIEF"


David W. Novak
DAVID W. NOVAK, P.S. No. 7507

GRAPHIC SCALE

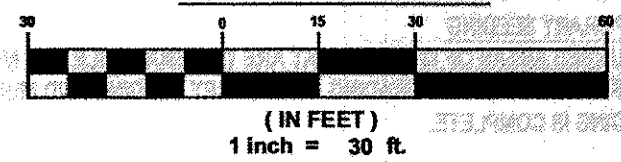

Stormwater Management Plan
Approved as shown and/or noted *
JAMES R. GILLS, P.E.
County Drainage Engineer
Date 7/11/2012


- | | |
|--|--|
| <ul style="list-style-type: none"> SANITARY MANHOLE STORM MANHOLE CURB INLET STORM INLET FIRE HYDRANT | <ul style="list-style-type: none"> UTILITY BOXES IRON PIN FOUND IRON PIPE FOUND MONUMENT BOX IRON PIN SET PROPOSED CONTOUR EXISTING CONTOUR |
|--|--|

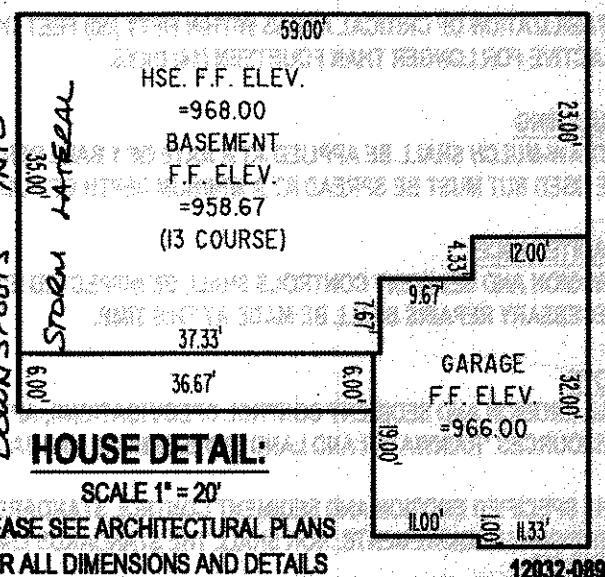

HOUSE DETAIL:
SCALE 1\"/>

REVISIONS	BY

Barrington
CONSULTING GROUP, INC.
9114 TYLER BLVD., MENTOR, OHIO 44060
PHONE 440.285.1260 FAX 440.285.1262
www.BarringtonCGI.com

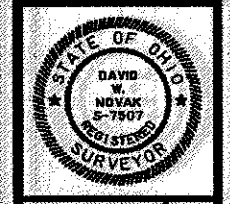

SITE PLAN
8001 BUTLER HILL DR., CONCORD TWP., OHIO 44077
S/L 88 MOUNTAINSIDE FARMS SUBDIVISION PH. 3A VOL. 61 PG. 7
ENZOCO HOMES

DRAWN VSO CHECKED DWN DATE JULY 09, 2012 SCALE 1\"/>	SHEET 112 OF SHEETS
---	------------------------------