


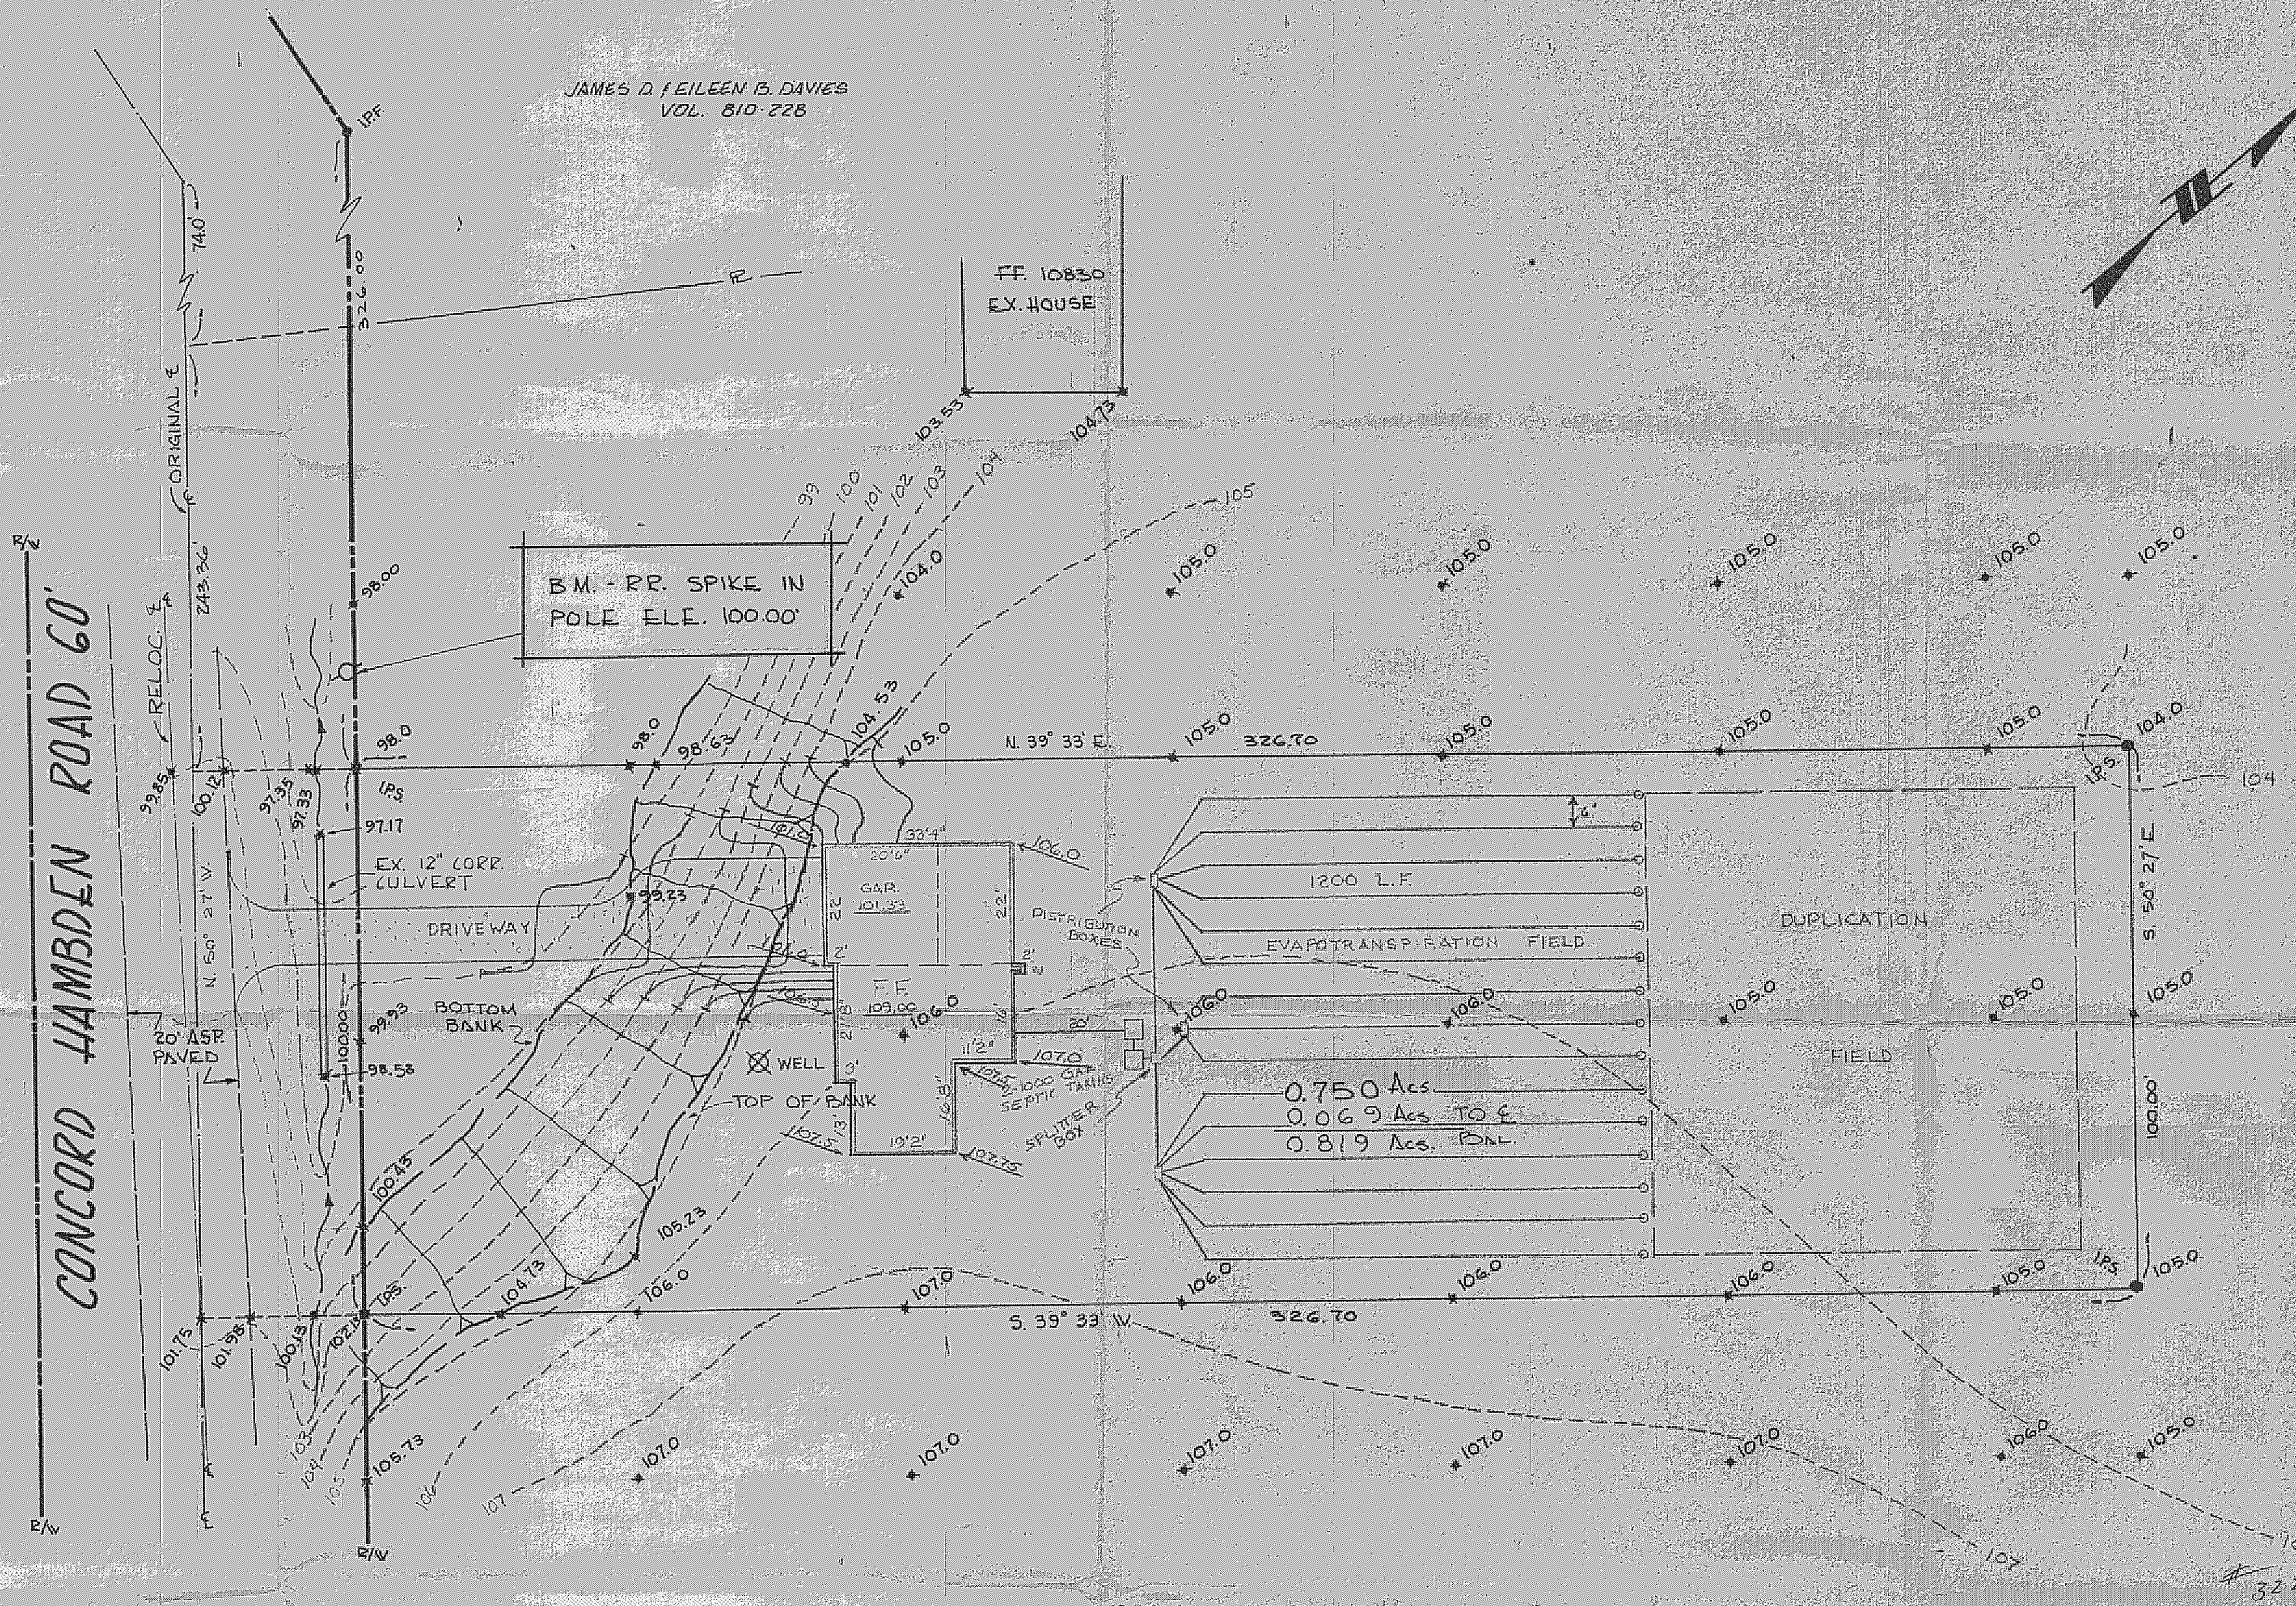

JAMES D. FEILEEN B. DAVIES
VOL. 810-228

BM - RR. SPIKE IN
POLE ELE. 100.00'

FF 108350
EX. HOUSE

EX. 12" CORR.
CULVERT

DRIVEWAY

BOTTOM BANK

WELL

TOP OF BANK

GAP
N 101.33'

FF 109.00

12" 1000 GAL.
SEPTIC TANK

SPLITTER
BOX

107.75'

1200 L.F.

EVAPOTRANSPIRATION FIELD

0.750 Acs.

0.069 Acs. TO F.

0.819 Acs. FNL.

DUPLICATION


FIELD

Grading Plan Approved
as shown and/or noted
THOMAS P. GILLES, P.E.
Lake County Engineer
By ATG Date 4/10/77

**ZONING
PERMIT**

Approved 4-21-77
W. Paul West

BEULAH A. ROBEY
V413-429, V440-406

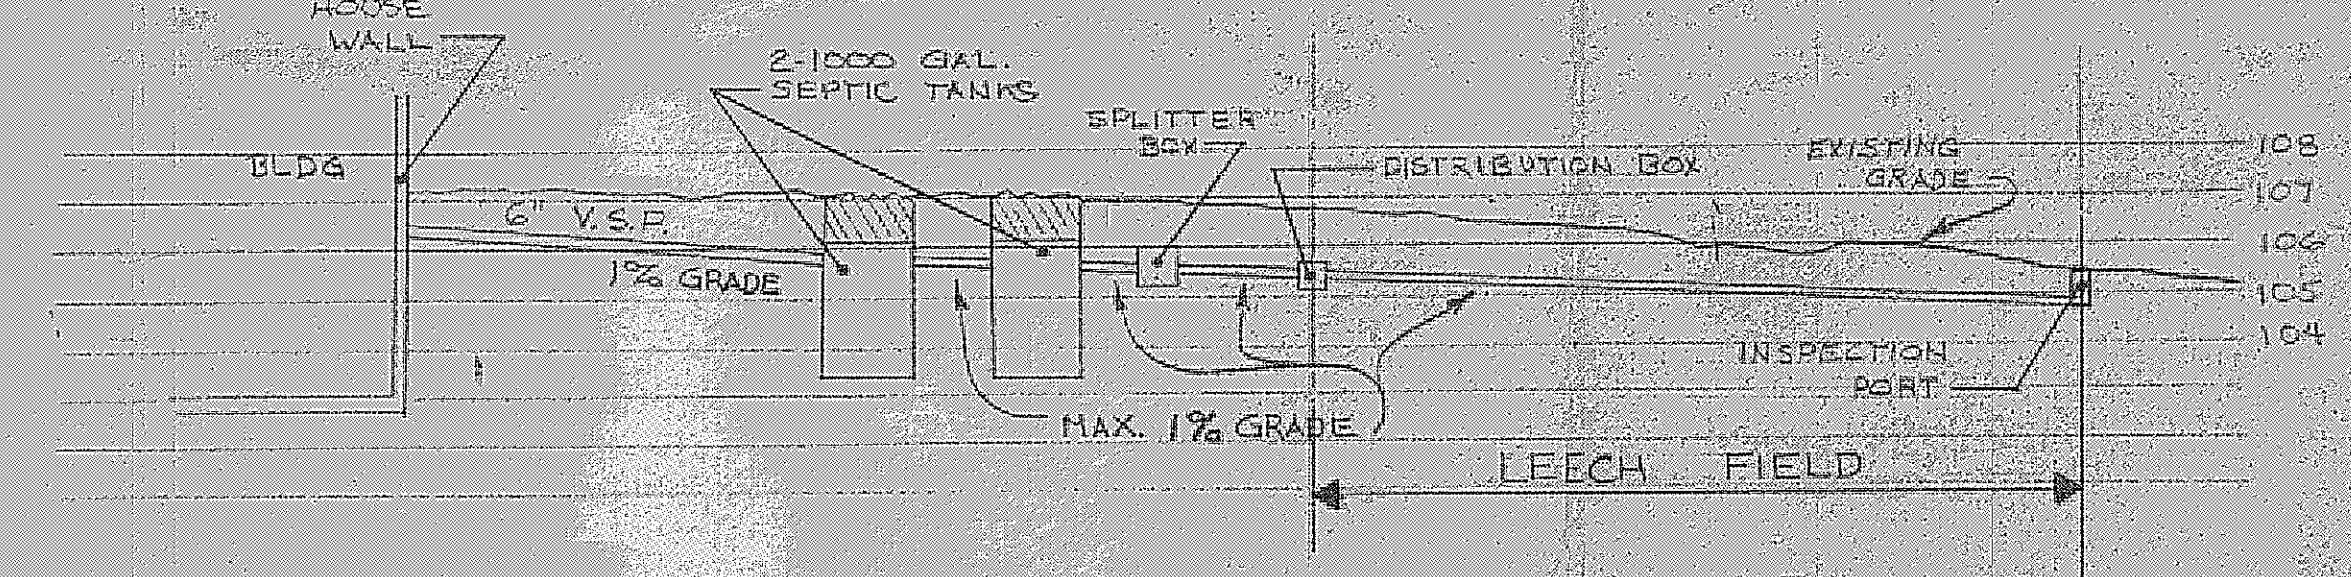

SEPTIC SYSTEM M PROFILE
NO SCALE

NOTE: UNDERLINED ELEVATIONS ARE PROPOSED GRADES
REVISION: ADDED HOUSE AND SEPTIC SYSTEM 4-15-77 BY ATG.

DESIGN CERTIFICATION
THIS PLAN WAS PREPARED BY ME
AND IS CORRECT TO THE BEST OF
MY KNOWLEDGE AND BELIEF
William Reil
REG. SURVEYOR # 4783
"AS BUILT" CERTIFICATION
I HEREBY CERTIFY THAT THE GRADED GRADES
ARE EXACTLY AS SHOWN ON THE PLAN AND THAT THIS
SURVEY IS CORRECT TO THE BEST OF MY
KNOWLEDGE AND BELIEF
REG. SURVEYOR #

SURVEY AND TOPO FOR WILLIAM REIL CONCORD TWP, LAKE COUNTY, OHIO		DATE <u>Nov 1976</u> SCALE <u>1"=20'</u> DRAWN BY <u>WJC</u> CHK'D BY P.B.# <u>222-M-113</u>
Colpetzer • Woods Consultants, Inc. CONSULTING ENGINEERS AND SURVEYORS PAINESVILLE, OHIO 44077		