

Reviewed and Accepted

LAKE COUNTY GENERAL HEALTH DISTRICT

Date April 2, 1987

JOEL LUCIA, R. S., M. P. H.
Health Commissioner


By David H. Quinn

- A. To be brought to finished grade
1. Septic tank manhole covers
 2. Splitter box cover
 3. Distribution box cover
 4. Vent Pipes
- B. No footer drains or downspouts to be discharged into septic tanks
- C. All waste water to be discharged into septic tanks

LOW YIELD WATER
FIXTURES REQUIRED
ON ALL:

— Snow
— Head
— Toilet

SEWAGE DISPOSAL PERMIT MUST BE
OBTAINED BY A LAKE COUNTY LICENSED
INSTALLER BEFORE INSTALLATION IS
STARTED.

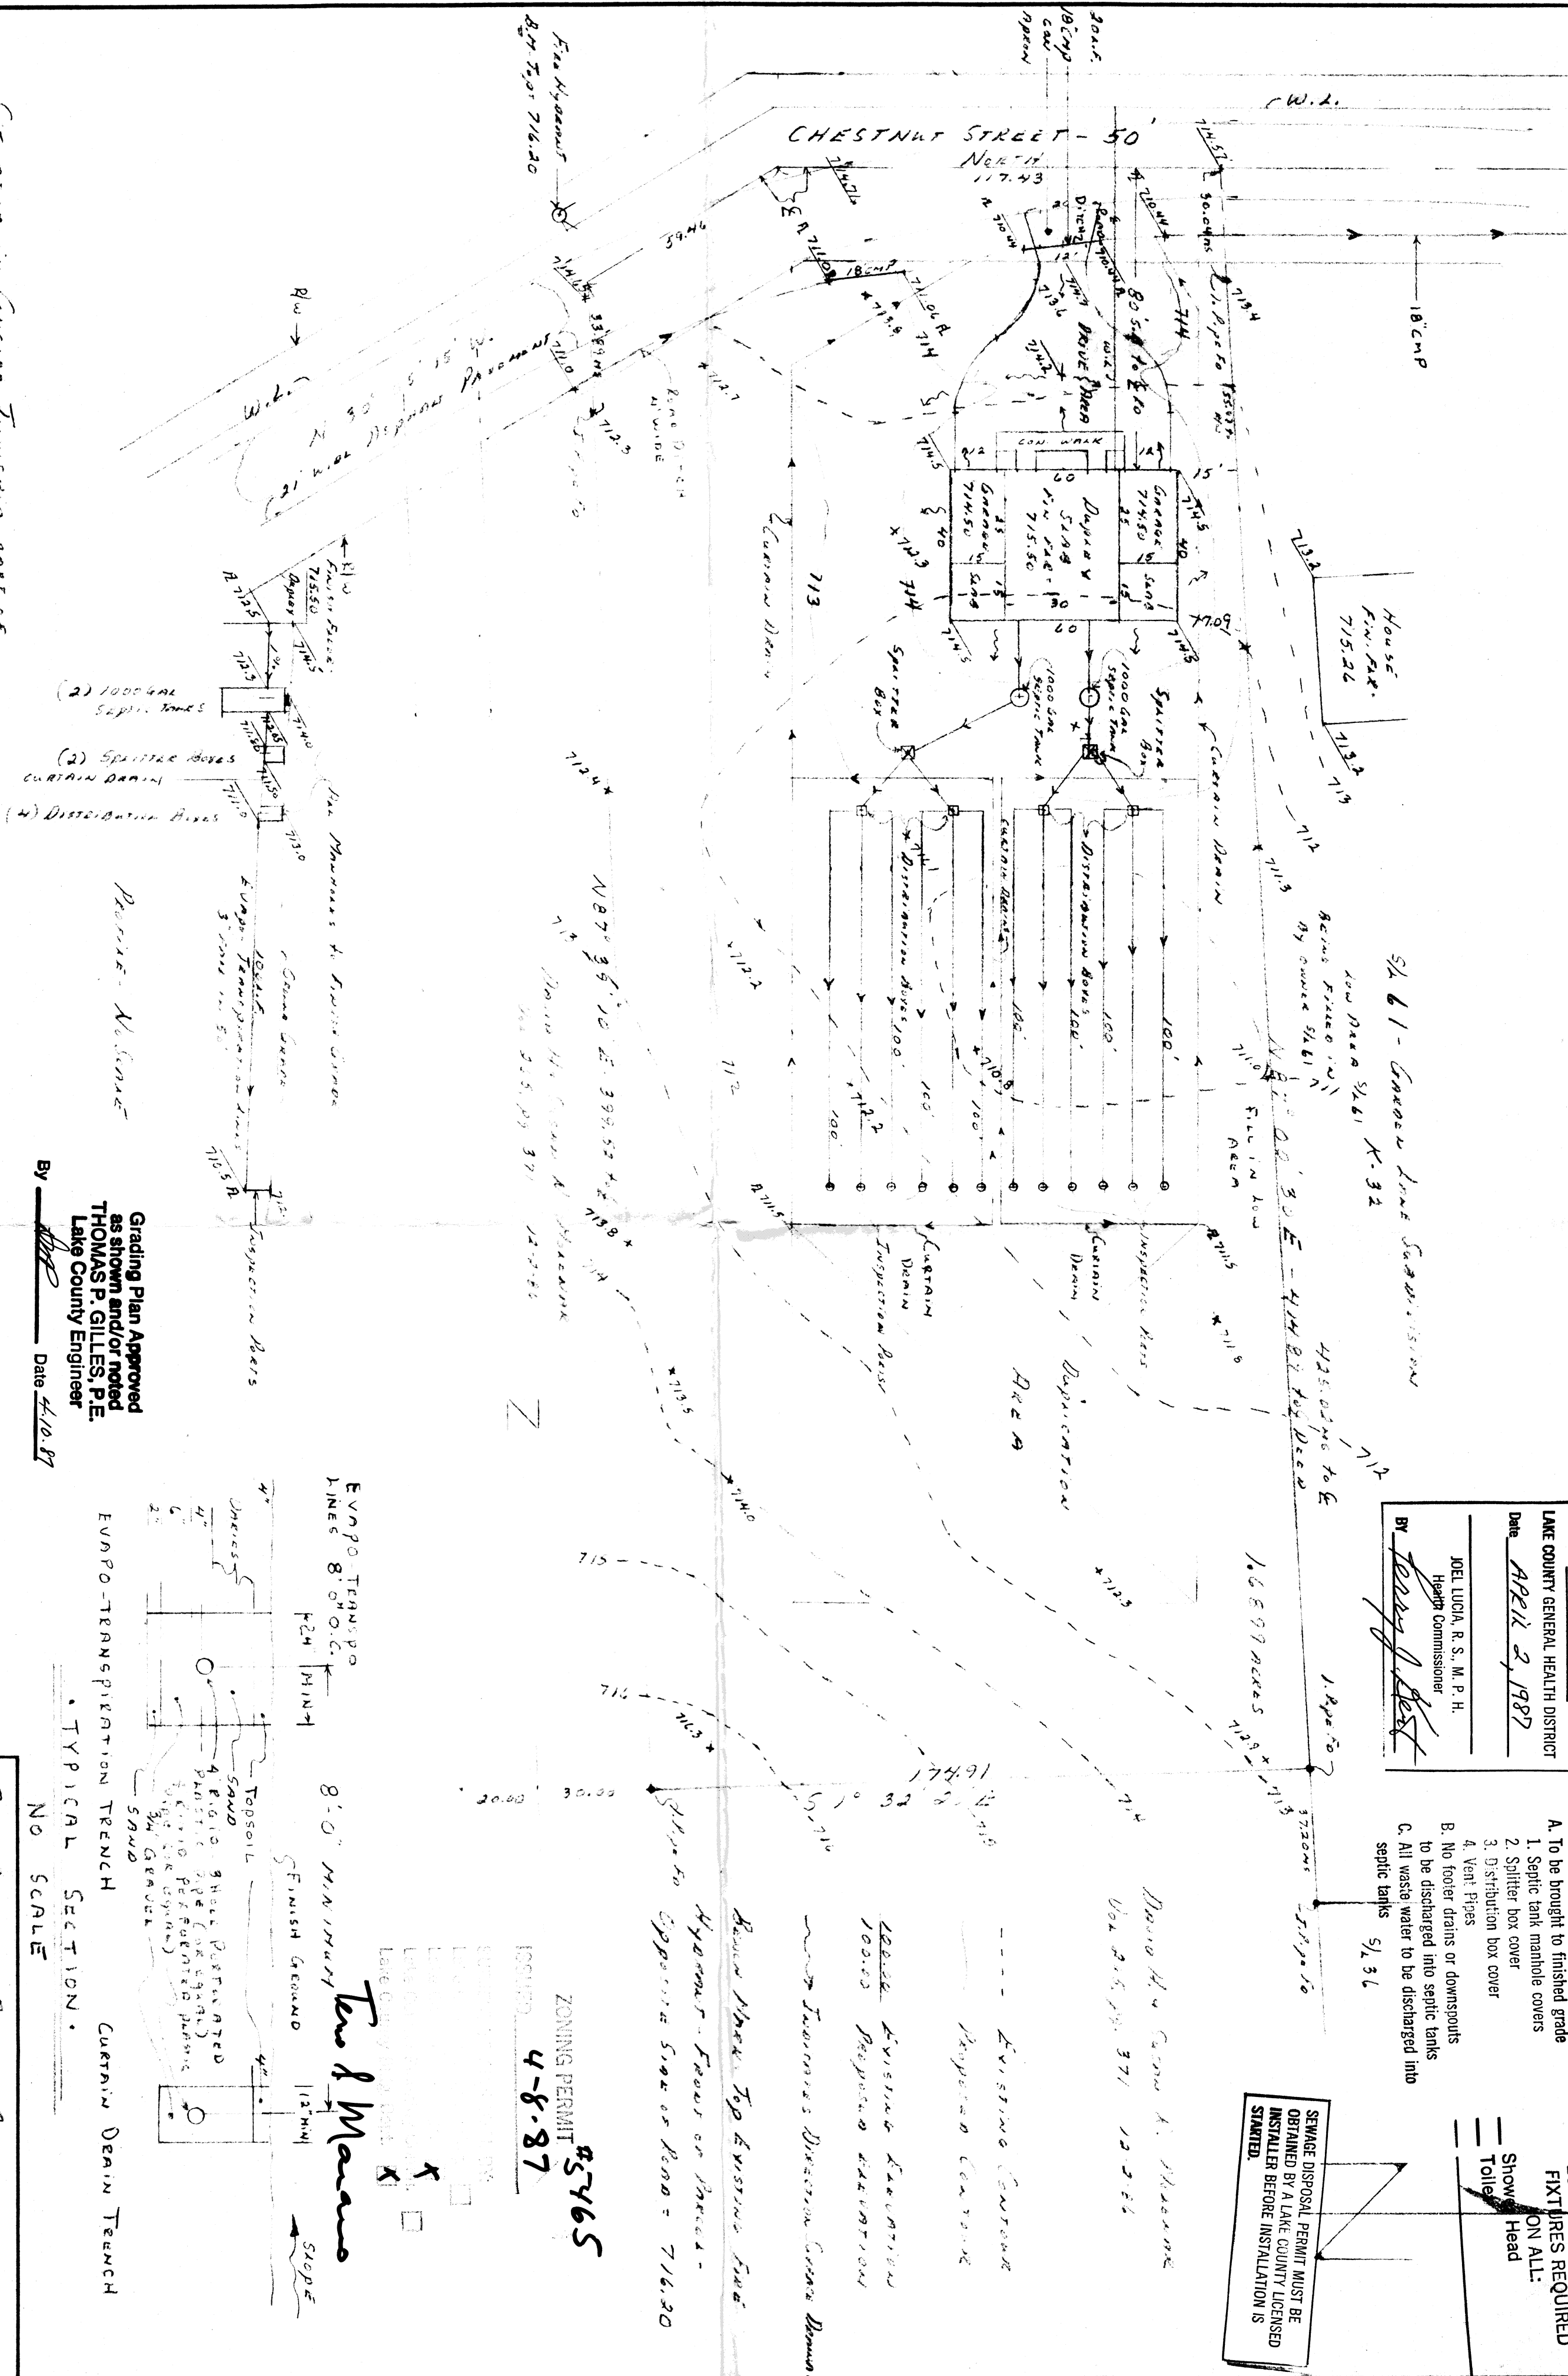

Grading Plan Approved
as shown and/or noted
THOMAS P. GILLES, P.E.
Lake County Engineer


By David H. Quinn Date 4/10/87

8'-0" MINIMUM
FINISH GRADE
CURTAIN DRAIN TRENCH
TYPICAL SECTION
NO SCALE

SITUATED IN LANCELOT TOWNSHIP, PART OF
LOT NO. 54, TOWN 4

This plan was prepared by me and is correct
to the best of my knowledge.

David H. Quinn, P.E. 4/10/87

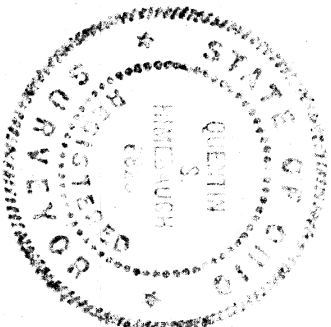

SITE PLAN FOR GREEN LINE	
6257 CHESTNUT STREET - LANCELOT TOWNSHIP	
SCALE: 1"=30'	APPROVED BY
DATE: 3-30-87	2/10/87
Drawn by David H. Quinn	
Drawing Number	87-045