



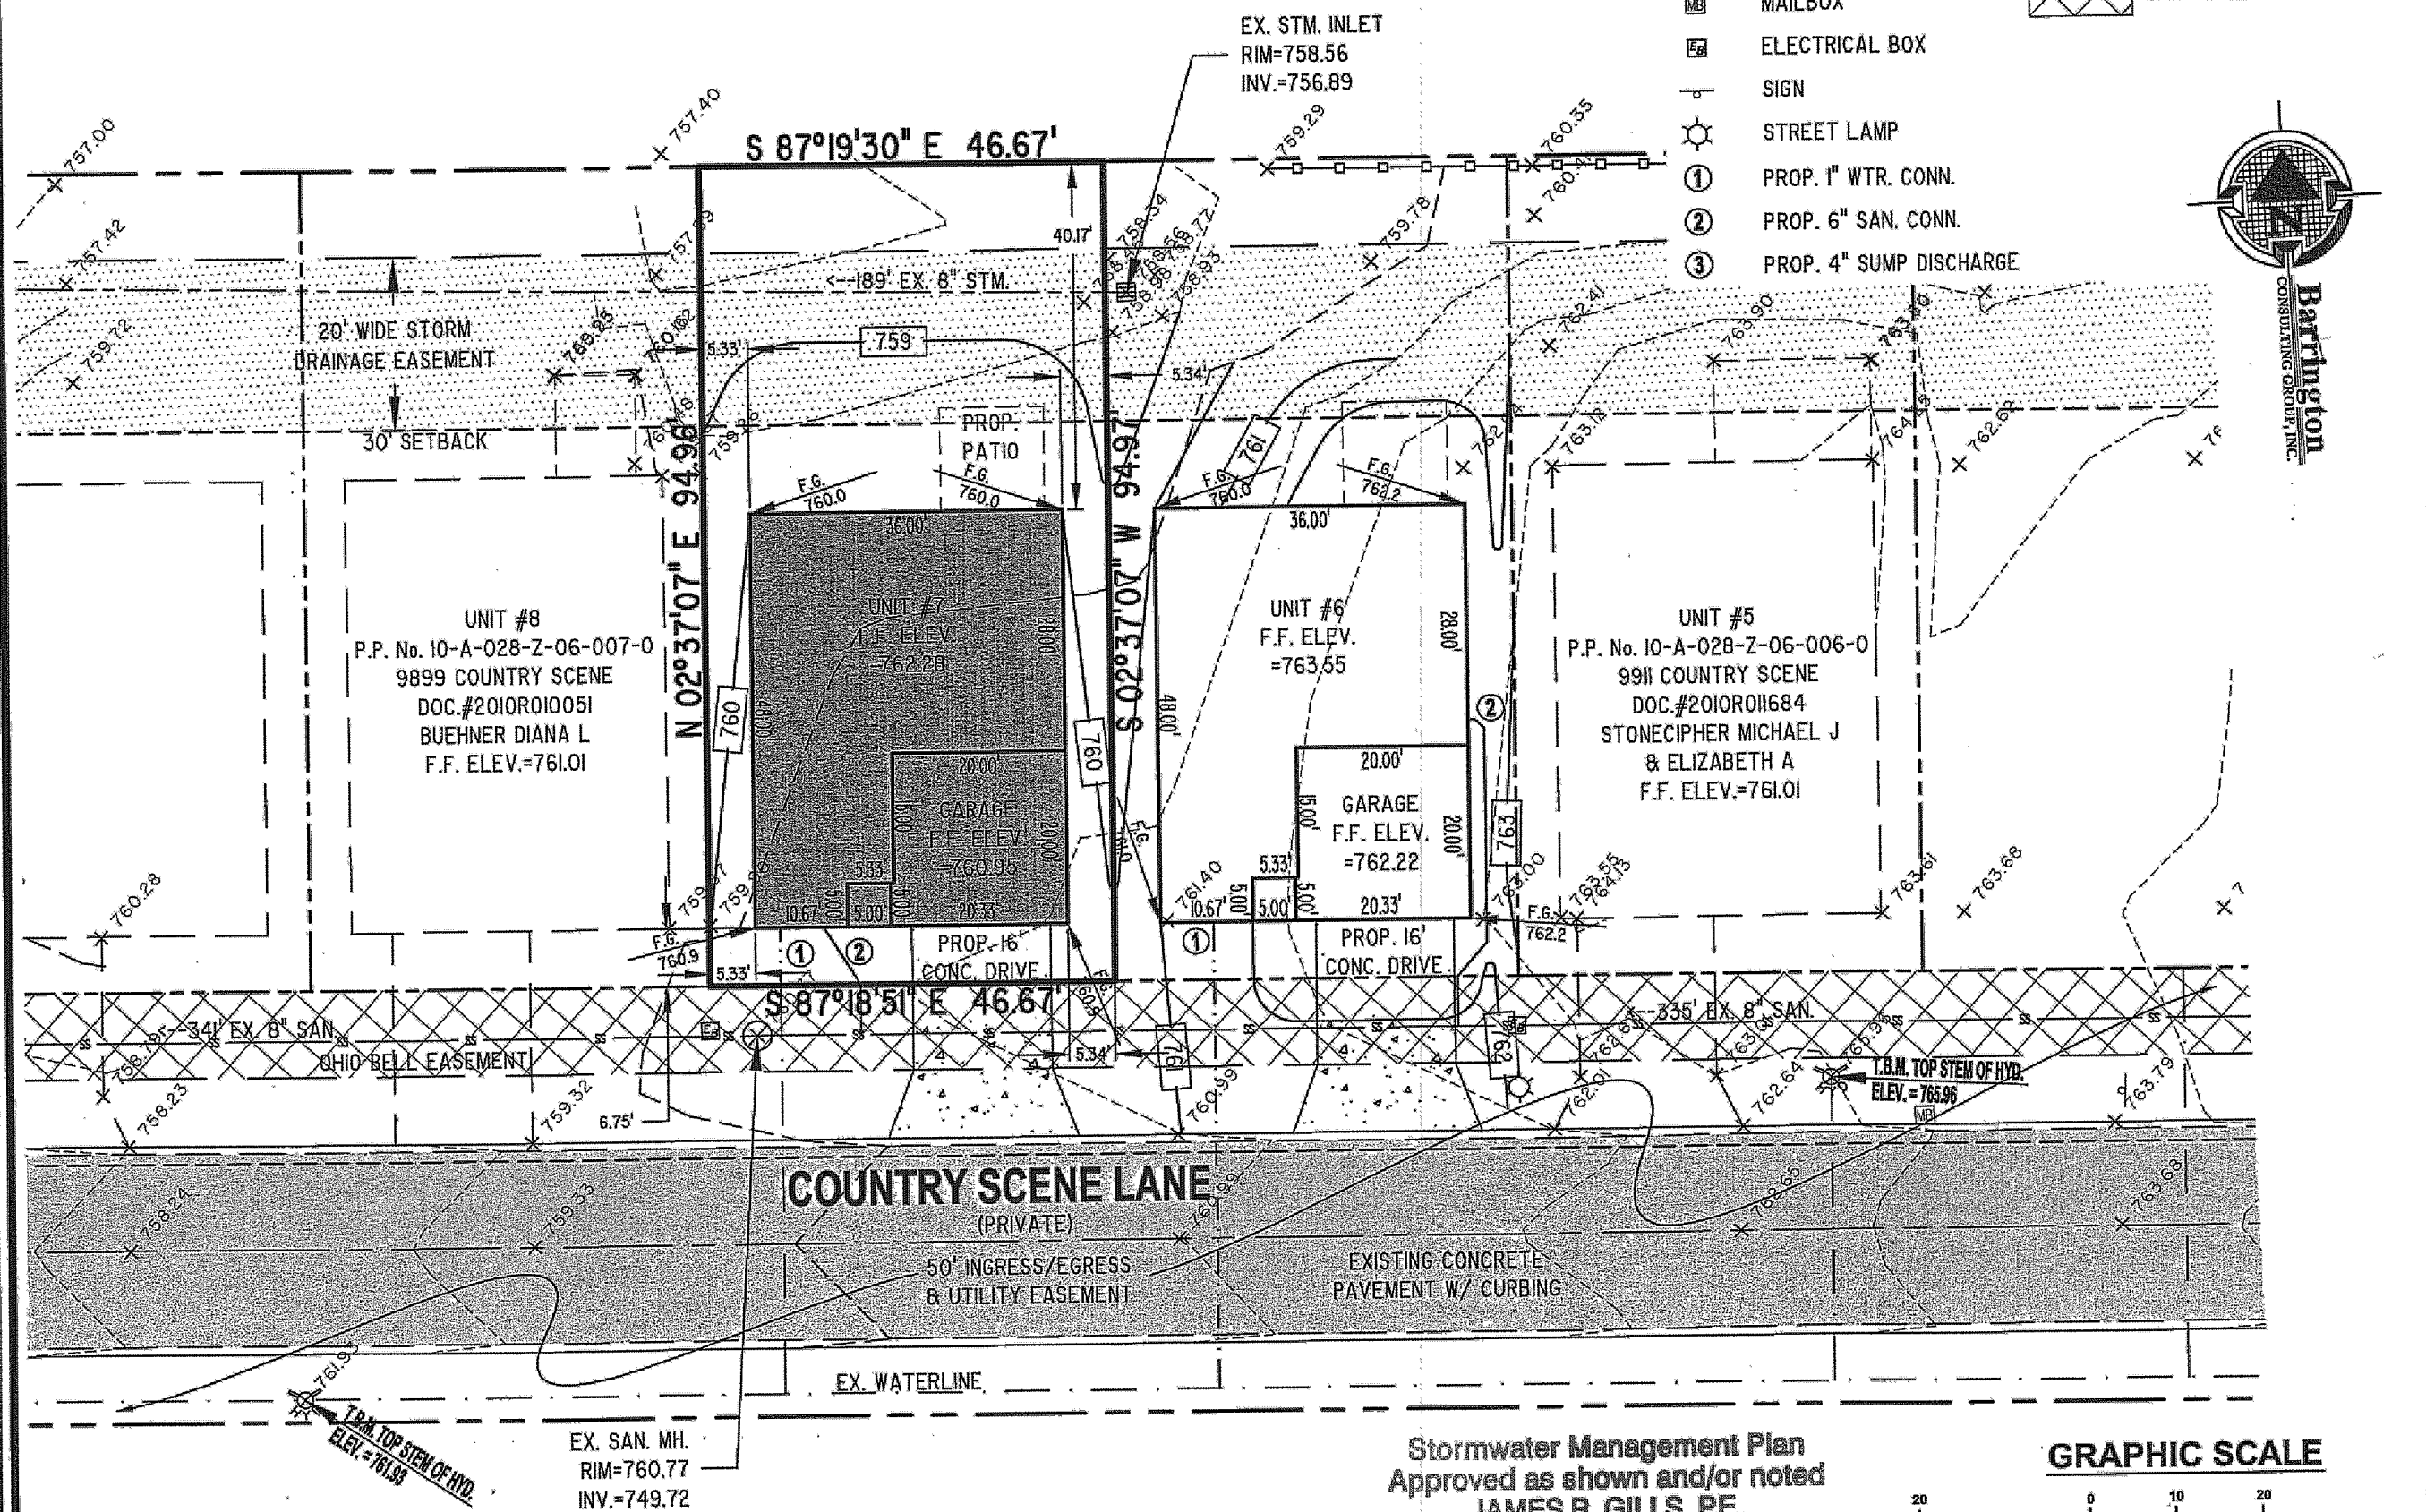

Stormwater Management Plan
Approved as shown and/or noted
JAMES R. GILLS, P.E.
County Drainage Engineer
By J.S. Date 8/25/14


GRAPHIC SCALE

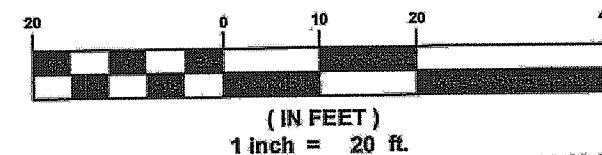

14028-007

REVISIONS	BY

Barrington
CONSULTING GROUP, INC.
9114 TYLER BLVD., MENTOR, OHIO 44060
PHONE 440.205.1260 FAX 440.205.1262
www.BarringtonCGI.com

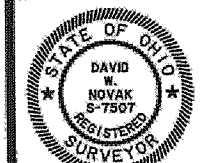

SITE PLAN
9903 COUNTRY SCENE LN., CONCORD TWP., OHIO 44077
UNIT #7 GABRIEL'S EDGE SINGLE DETACHED CLUSTER DEVELOPMENT VOL. 58 PG. 17

PROBUILT HOMES, INC.

DRAWN
WSO
CHECKED
DWN
DATE
AUG. 18, 2014
SCALE
1" = 20'
JOB NO.
14028-007
SHEET

3/3

OF SHEETS