


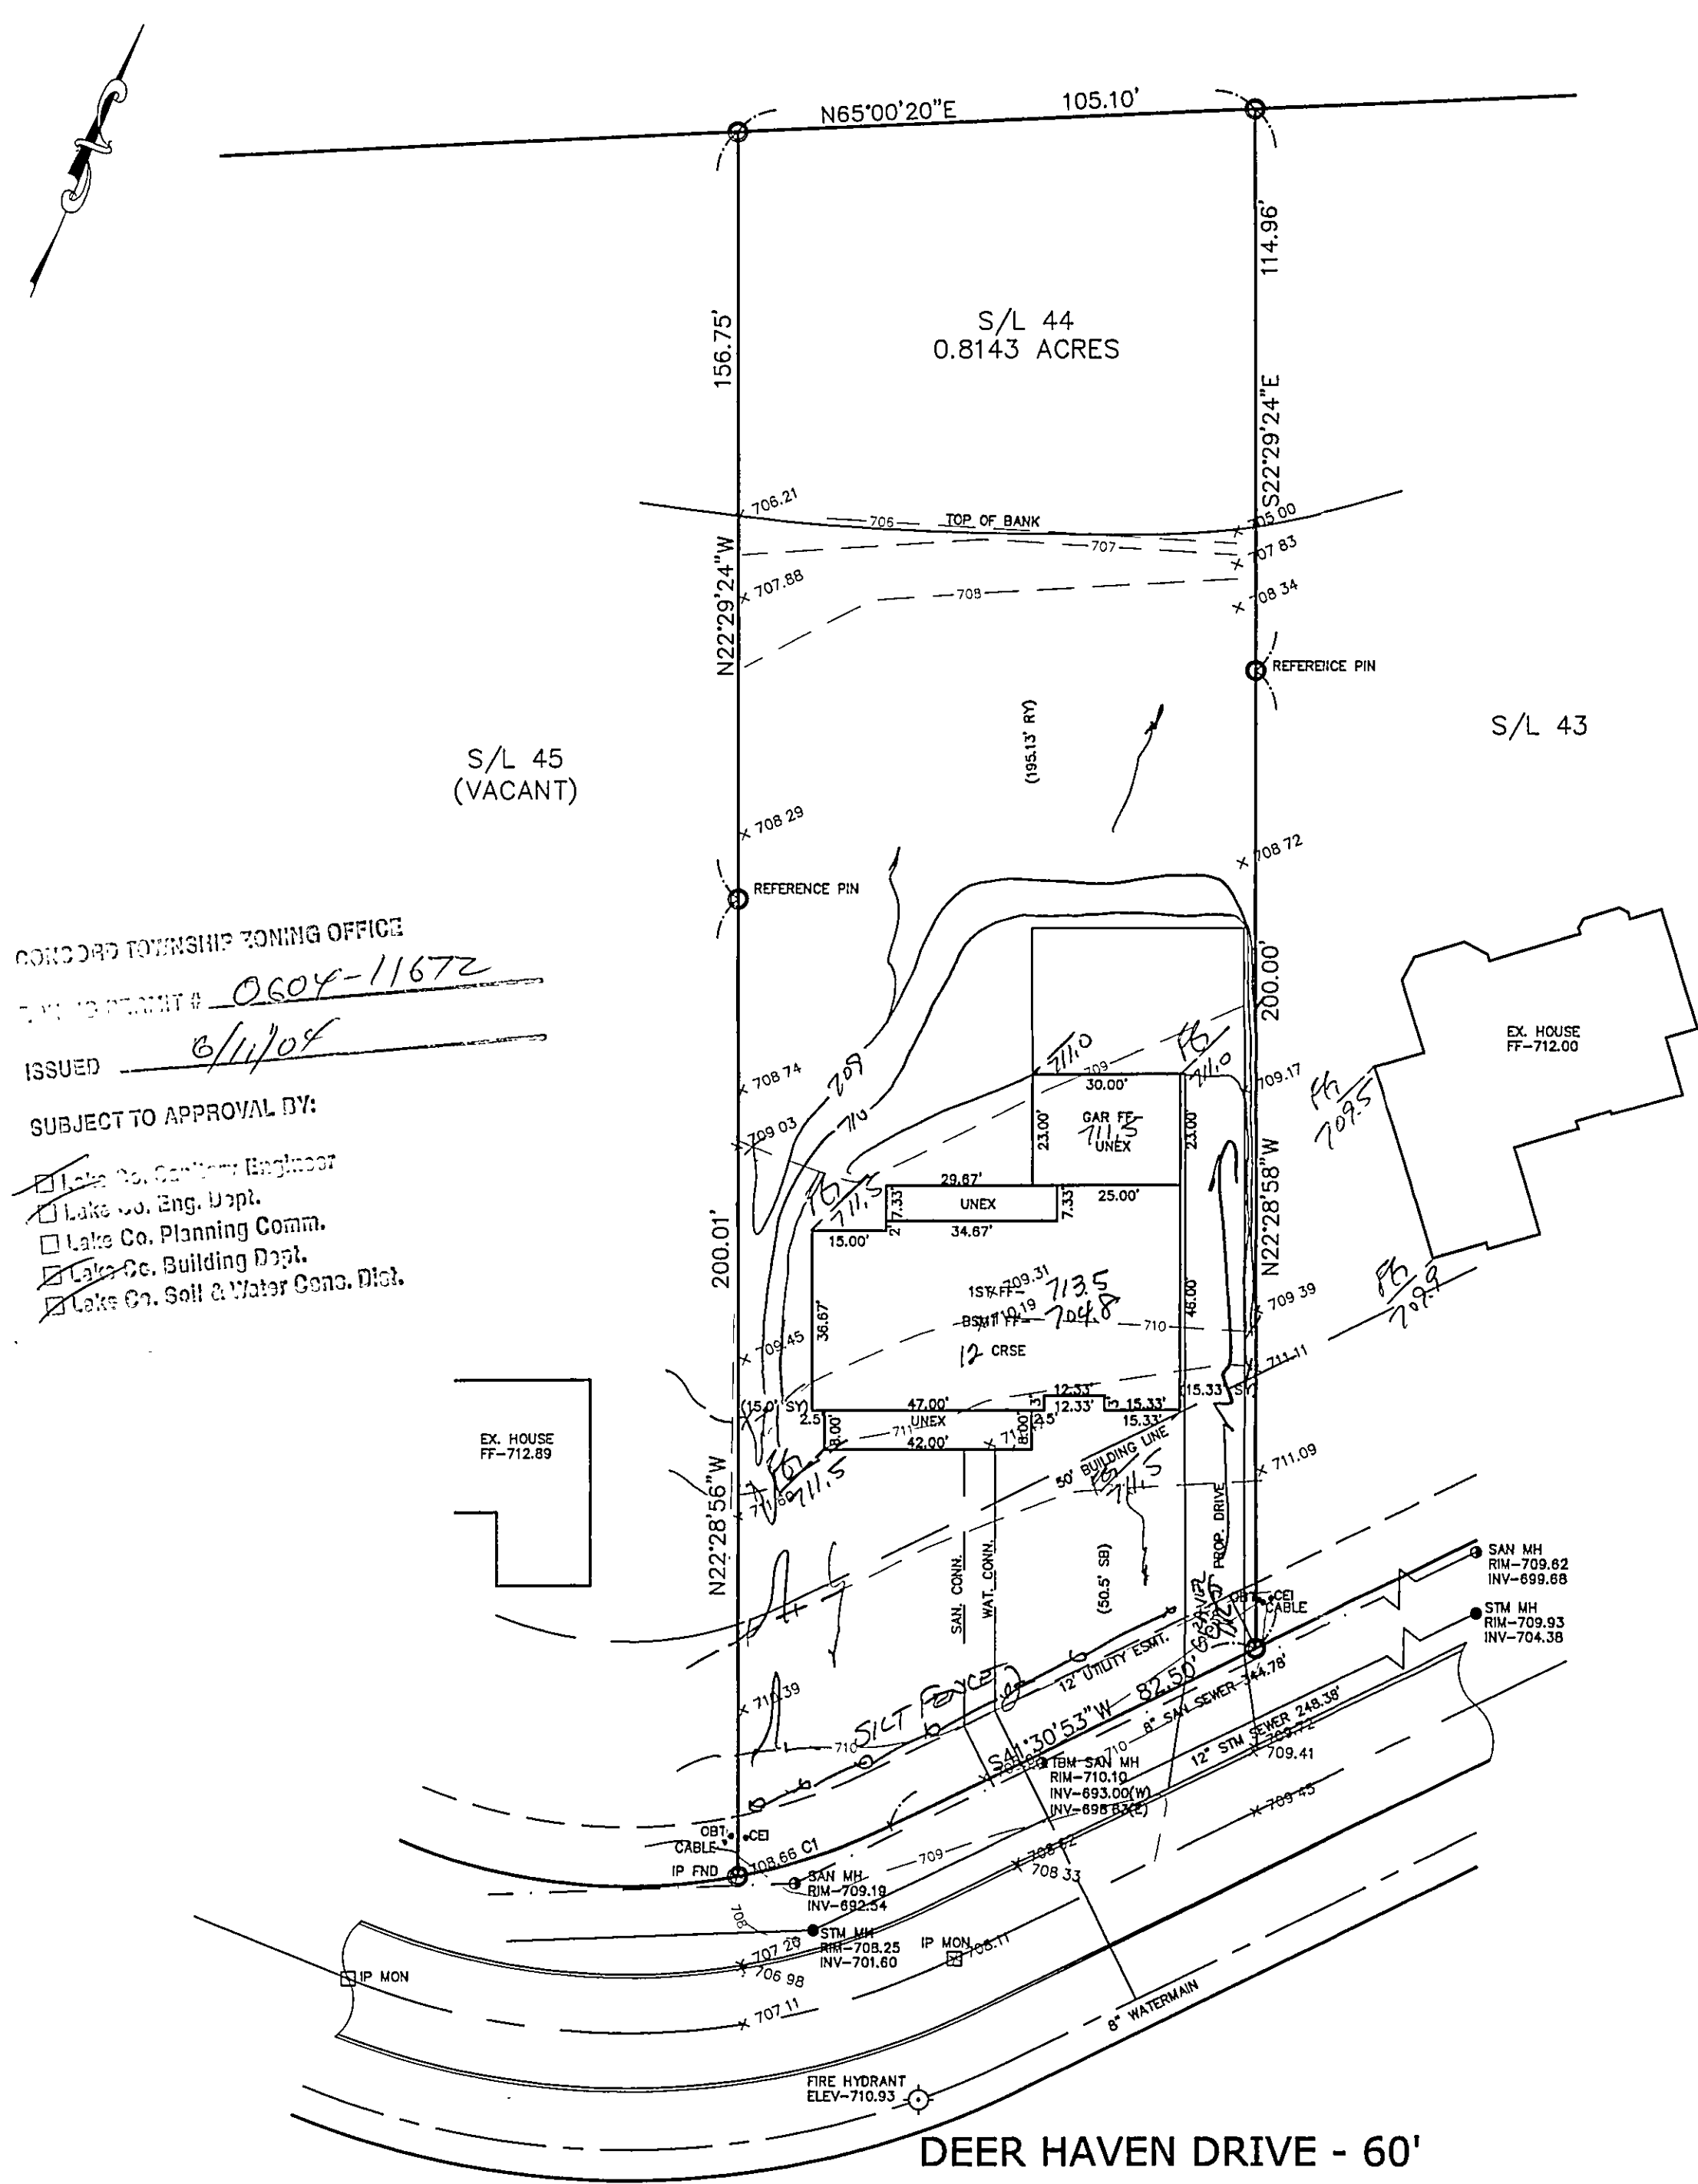

CONCORD TOWNSHIP ZONING OFFICE
ZONING PERMIT # 0604-11672
ISSUED 6/11/04
SUBJECT TO APPROVAL BY:
☒ Lake Co. Engineer
☒ Lake Co. Eng. Dept.
☒ Lake Co. Planning Comm.
☒ Lake Co. Building Dept.
☒ Lake Co. Soil & Water Cons. Dist.

1/2

SITE PLAN

CONCORD TOWNSHIP, LAKE COUNTY, OHIO

for: CANTERBILT
CLIENT OWNER

ADDRESS STREET CITY ZIP

ELLISON CREEK
SUBDIVISION 42-29 NAME TRACT
44 VOL-PG. DEER HAVEN DRIVE LOT STREET
SUBLOT NO. STREET VOL-PG. PERM. PARCEL NO.

LEGEND

SANITARY MANHOLE ---●---
STORM MANHOLE ---●---
INLET OR CATCH BASIN ---●---
HYDRANT ---●---
EXISTING CONTOURS ---●---
PROPOSED CONTOURS ---●---
EXIST. ELEV. ---100.0---
PROP. ELEV. ---100.0---
AS BUILT ELEVATION
INDICATES DIRECTION OF SURFACE DRAINAGE

REMARKS

ALL BOUNDARY DATA SHOWN WAS OBTAINED FROM (DEEDS, RECORDED SUBDIVISION PLAT OR OTHER PUBLIC RECORDS)
LOCATIONS AS SHOWN OF ADJACENT WELLS AND SEPTIC TANKS OBTAINED FROM LAKE COUNTY HEALTH DEPARTMENT

DESIGN CERTIFICATION

THIS PLAT WAS PREPARED BY ME, AND IS CORRECT TO THE BEST OF MY KNOWLEDGE AND BELIEF.

NAME SURVEYOR REGISTRATION NO.

CHECK LIST

NO. OF BEDROOMS
DIMENSIONS
BEARINGS
TIE TO NEAREST STREET
SUBLOT NO. PARCEL NO.
SURROUNDING OWNERS
BLDG. DIMENSIONS FIN GR.
BLDG. TIES FL'R. GRADES
APRON TYPE WIDTH THICKNESS
SIDEWALK TYPE WIDTH THICKNESS
CULVERT TYPE DIA., LENGTH
ROCK OUTCROPPINGS
WATER MAIN SIZE, LOCATION
SAN. SEWER SIZE & GR. LOC.
SAN. MH. CAST. ELEV. INV. ELEV.
SAN. CONN. SIZE, LOC. DEPTH
STORM SEWER SIZE & GR. LOC.
STORM MH. CAST. ELEV. INV. ELEV.
PAV'T TYPE GRADE CURBS
GAS LINE LOC. SIZE PRESSURE
SEPTIC TANK LOCATION & DUPLICATION AREA
WELL LOCATION
ISOLATION RADIUS FROM WELL

REVISIONS			PLAN PREPARED BY:		
NO.	DATE	BY	BABCOCK · JONES & ASSOCIATES, INC.		
1			PAINESVILLE, OHIO		
2			DRAWN BY NS	SCALE 1"=30'	PHONE NO. 440-357-1811
3			CHR'D. HJ	DATE 08/26/02	DRAWING NO. 00-265-44
4			CREW WB	APP'D HJ	
5			CHIEF		

"AS BUILT" CERTIFICATION

I, HEREBY CERTIFY THAT THE CIRCLED GRADES ARE EXISTING FINISH GRADES CHECKED IN THE FIELD ON _____, 20____ AND ARE CORRECT TO THE BEST OF MY KNOWLEDGE AND BELIEF.

REGISTERED SURVEYOR REG. NO.

Site and/or Management Plan
Approved as shown and/or noted
JAMES R. GILLO, P.E.
County Drainage Engineer
By 6/11 Date 06/11/04

ROOF DRAINS
SHALL DISCHARGE
TO SPLASH BLOCKS.

CURVE	LENGTH	RADIUS	TANGENT	CHORD	BEARING	DELTA
C1	32.55	120.00	16.38	32.45	N49°15'24"E	15°32'28"

EXISTING UTILITIES NOTE:
THE SIZE AND LOCATION, BOTH HORIZONTAL AND VERTICAL OF THE UNDERGROUND UTILITIES SHOWN HEREON, HAVE BEEN OBTAINED BY A SEARCH OF AVAILABLE RECORDS. VERIFICATION BY FIELD OBSERVATION HAS BEEN CONDUCTED WHERE PRACTICAL, HOWEVER, BABCOCK, JONES AND ASSOCIATES INC. DOES NOT GUARANTEE THE COMPLETENESS NOR ACCURACY THEREOF.

TBM SANITARY MANHOLE
ELEV-710.10

