


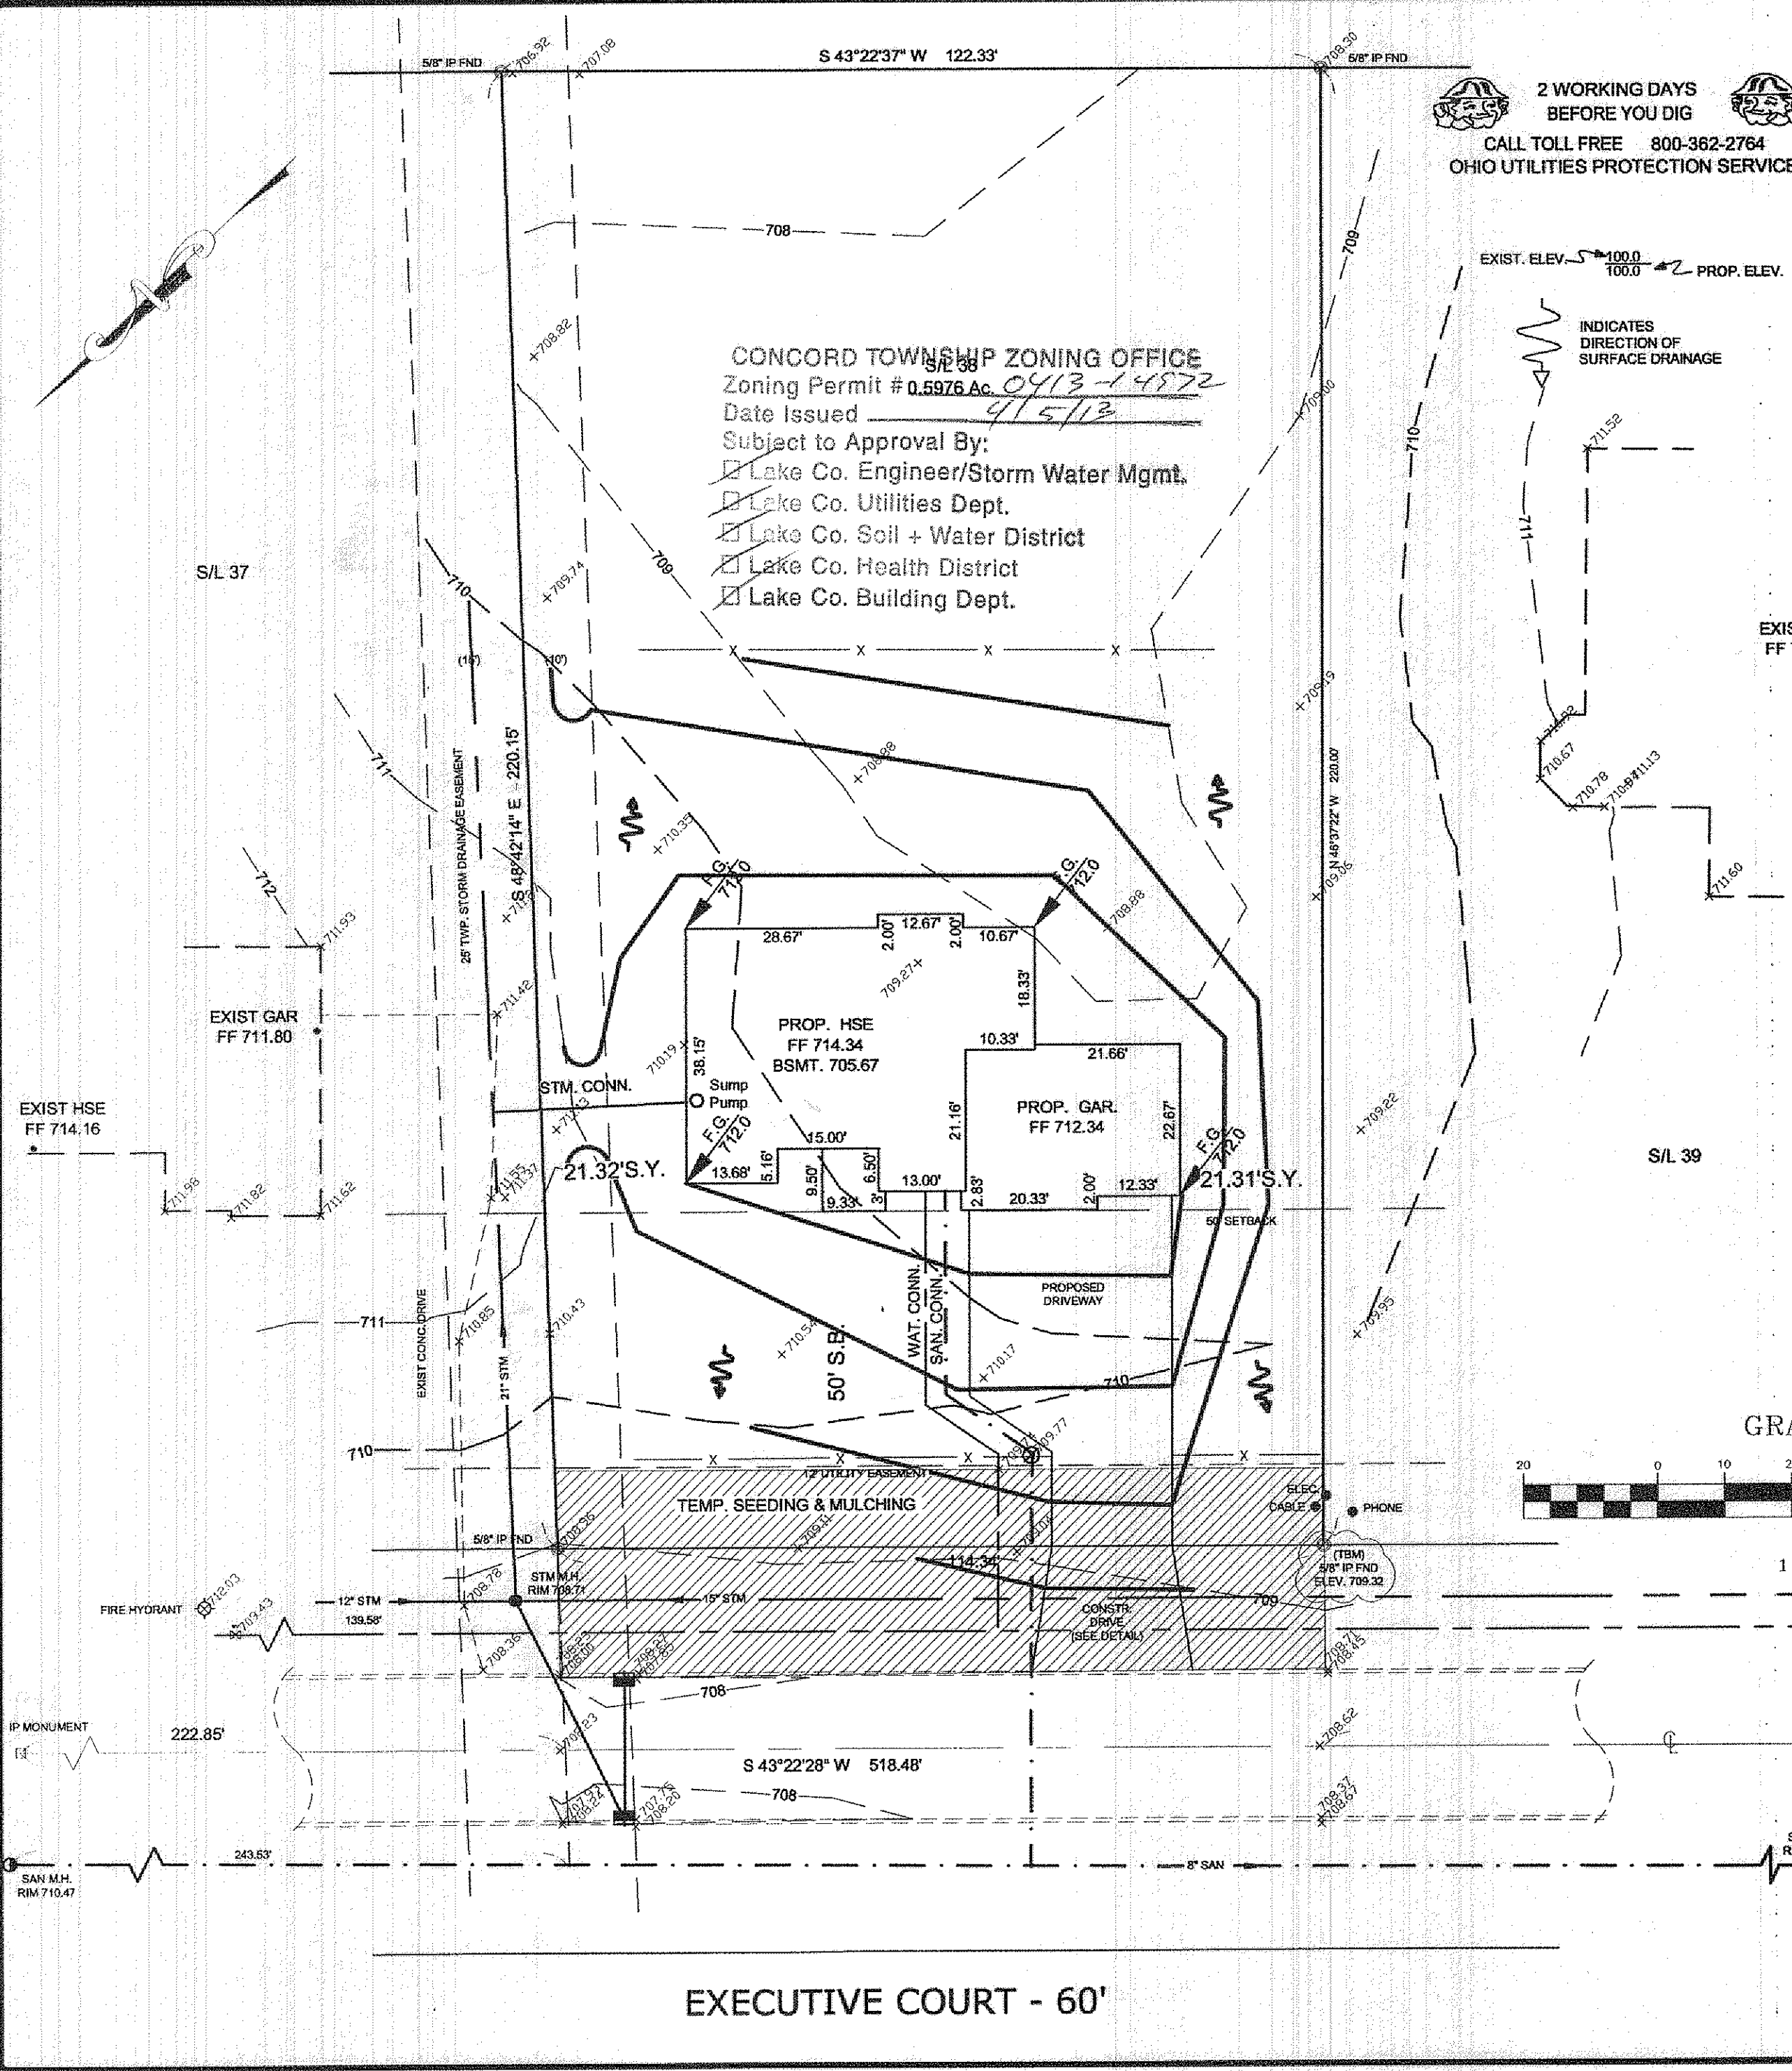

2 WORKING DAYS
BEFORE YOU DIG
CALL TOLL FREE 800-362-2764
OHIO UTILITIES PROTECTION SERVICE

SITE PLAN 1/2

CONCORD TWP., LAKE County, Ohio

for: **HANDCRAFTED HOMES**

CLIENT		OWNER	
ADDRESS	STREET	CITY	ZIP
CHAIRMAN'S COVE			
SUBDIVISION	41-36	NAME	TRACT
VOL-PG	91-71	EXECUTIVE COURT	LOT
SUBLOT NO.	38	STREET	VOL-PG
PERM. PARCEL NO.		STREET	

DESIGN CERTIFICATION

THIS PLAN WAS PREPARED BY ME AND IS CORRECT TO THE BEST OF MY KNOWLEDGE AND BELIEF.

[Signature] 46343
HARRY S. JONES, JR. SURVEYOR REGISTRATION NO. 6343

AS-BUILT PROP. 712.0	FRONT	AS-BUILT PROP. 712.0	FB
PROPOSED	AS-BUILT		
714.34	FF		
705.67	BSMT		
712.34	GAR		
AS-BUILT PROP. 712.0	REAR	AS-BUILT PROP. 712.0	FB



"This plan has been prepared solely for the purpose of establishing grading, drainage, location of utility connections, and compliance with local zoning regulations and is based upon plans approved by agencies having jurisdiction. Jones Surveying, LLC does not warrant or guarantee structural components of the structure or the underlying soils".

EXISTING UNDERGROUND UTILITIES NOTE:
"The size and location, both horizontal and vertical, of the underground utilities shown hereon, have been obtained by a diligent and comprehensive search of available records. Verification by field observation has been conducted where practical. However, Jones Surveying, LLC does not guarantee the completeness nor accuracy thereof." Contractor to verify location and depth of all utility laterals.

I, the undersigned, hereby certify that this topography, indicated by 1' contours, and elevations shown hereon, represent an actual field survey made by me on the 13th day of April, 2013, and that the elevations were taken at appropriate intervals and that as of that date they existed as indicated hereon.

[Signature] 46343
Harry S. Jones, Jr. P.S. #6343

GRAPHIC SCALE

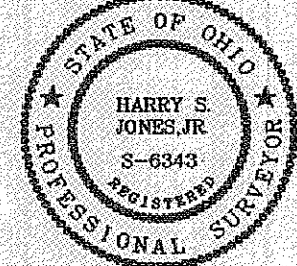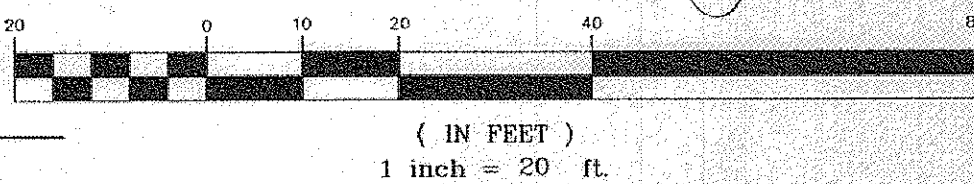

REVISIONS			Jones Surveying, LLC		
NO.	DATE	BY			
1		CAD	ENGINEERS - SURVEYORS - PLANNERS 1924 MENTOR AVE., PAINESVILLE, OHIO 440-357-1811 440-357-9173 (FAX) hjonessurveying@yahoo.com		
2		CAD			
3			DRAWN BY	SCALE 1"=20'	PHONE NO. 440-357-1811
4			CHKD.	DATE 4/02/13	DRAWING NO.
5			CREW CHIEF	APPD	99-185-38

Stormwater Management Plan
Approved as shown and/or noted
JAMES R. GILLS, P.E.
County Drainage Engineer
By *[Signature]* Date 4/2/13