


1080	F.F. 1080.53	SEPTIC TANK	1080
1075	F.L. 1075.11	SEPTIC TANK	1075
1070	BEAMT 1071.90	PUMP CHAMBER	1070
1065	4" WATER PUMP BEAMT 1071.90 BEAMT 1071.90	DISTRIBUTION BOX	1065
		DISTRIBUTION BOX	


ZONING PERMIT #5143
ISSUED 1-15-86

SUBJECT TO APPROVAL BY:
Lake County Board of Health
Lake County Board of Health
Lake County Board of Health
Lake County Board of Health


Teno A. Marano

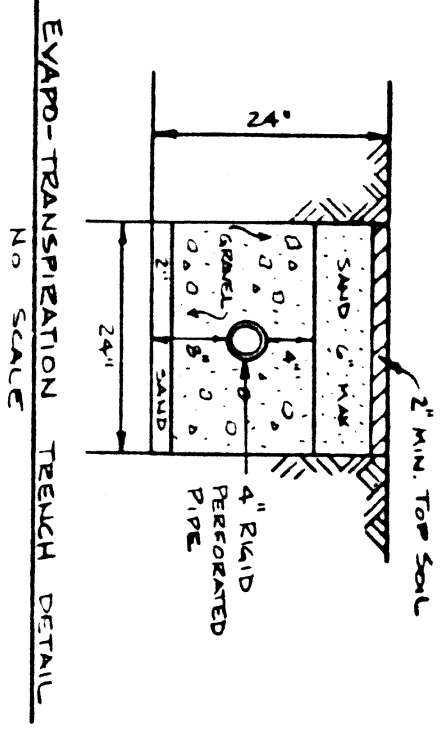

EVAPOTRANSPIRATION TRENCH DETAIL
NO SCALE

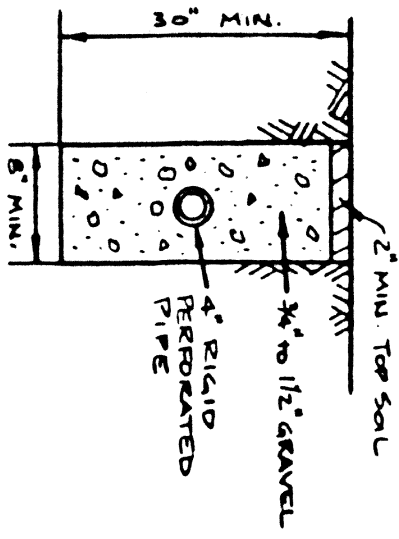

CURTAIN DRAIN TRENCH DETAIL
NO SCALE

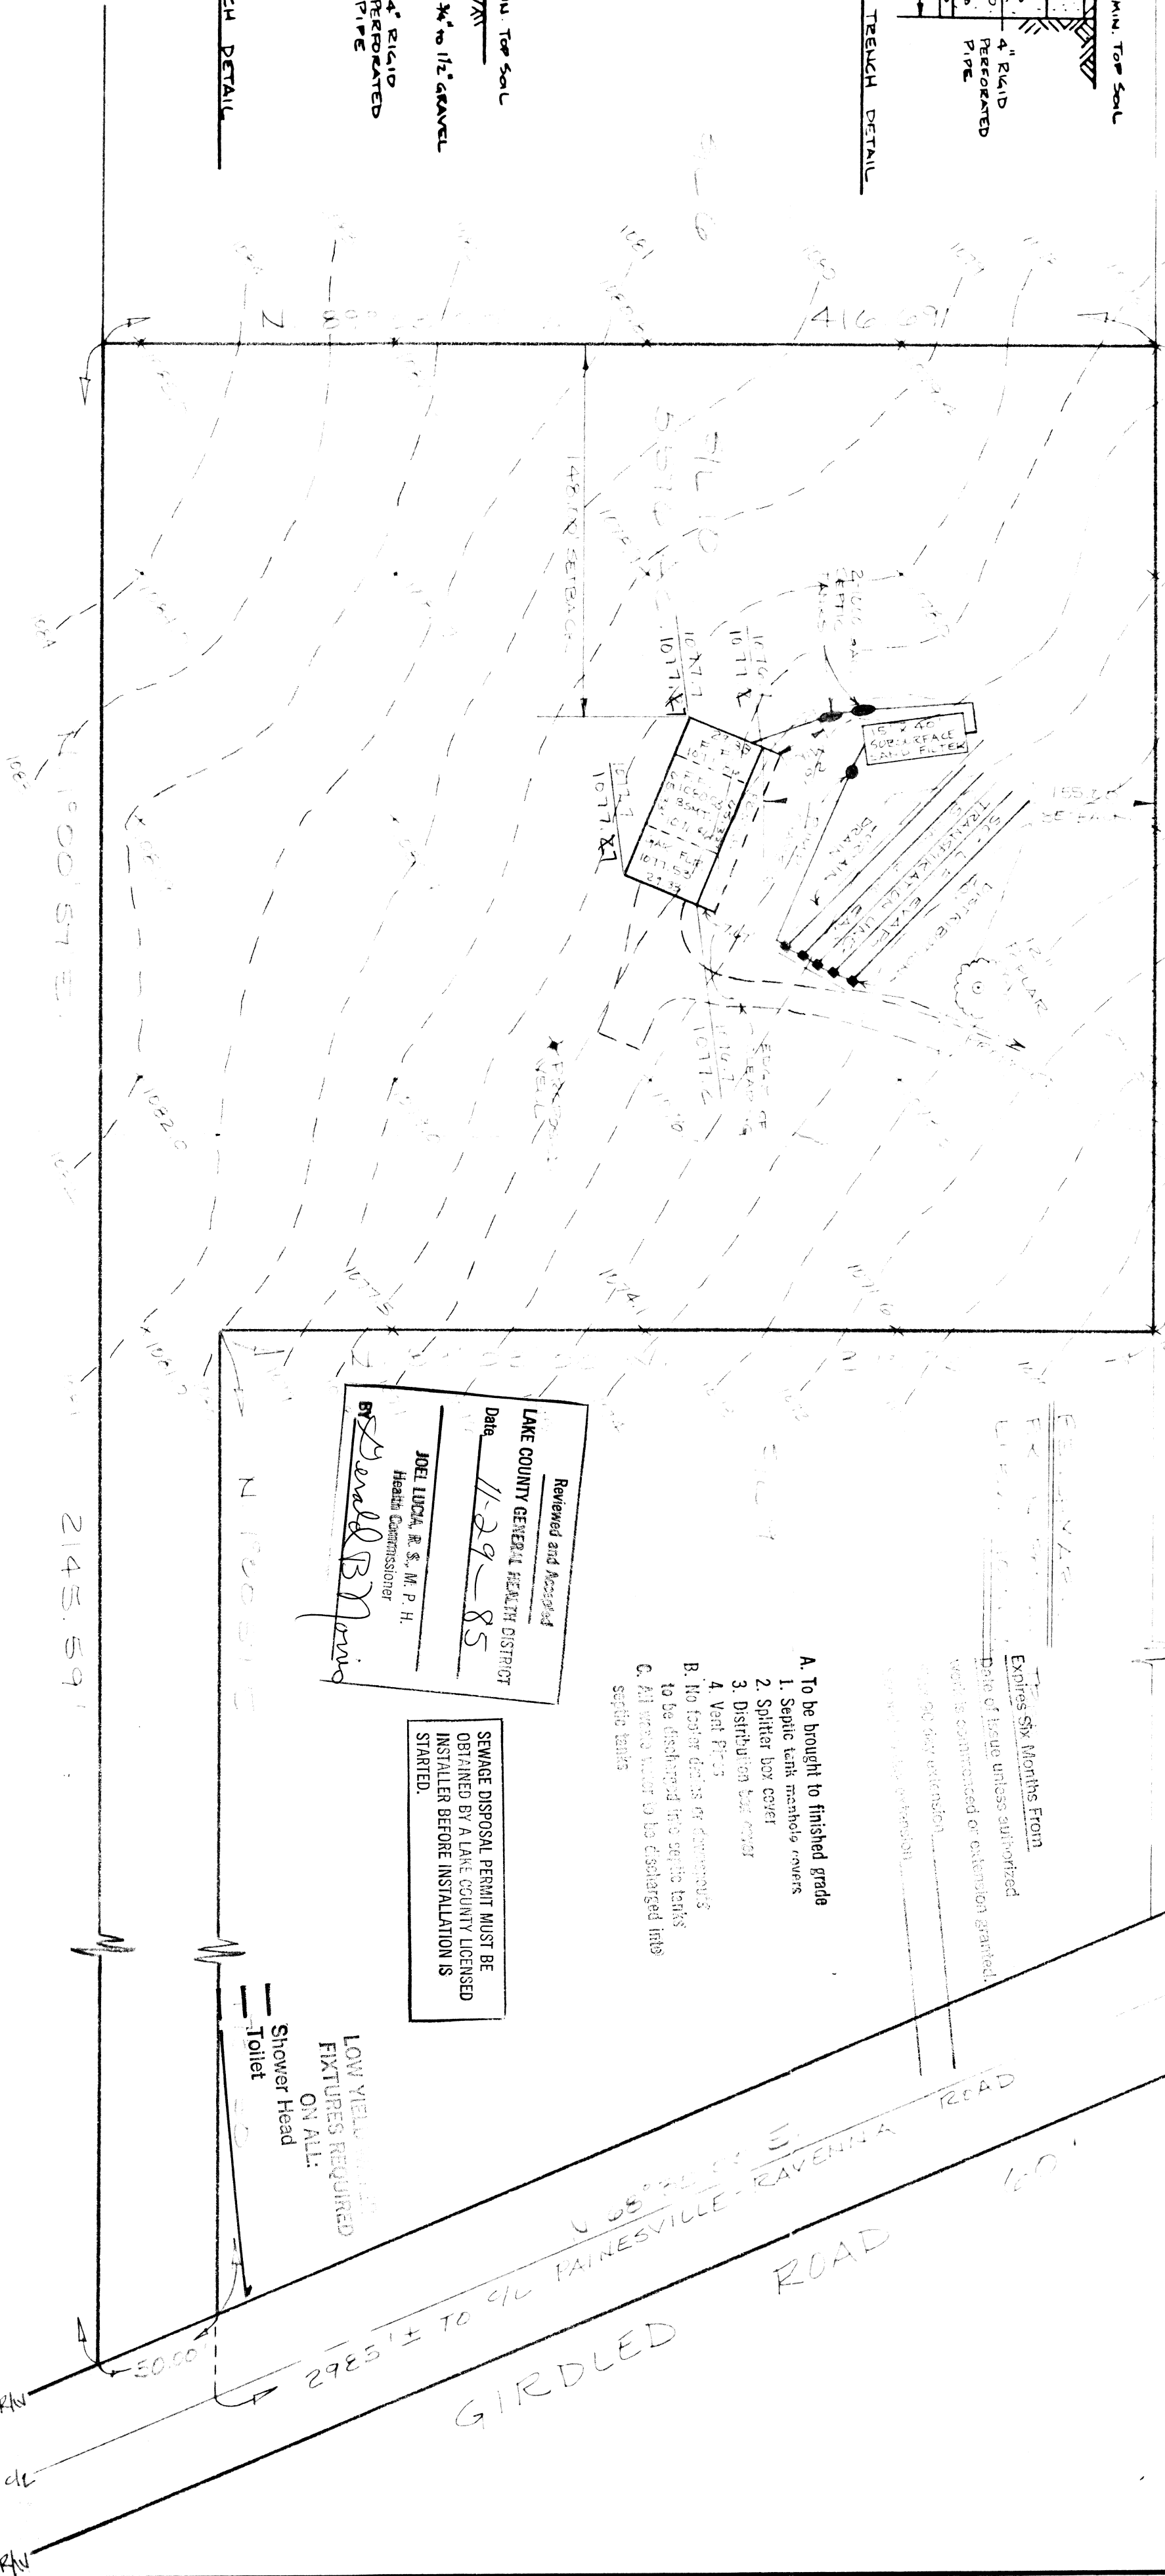

Reviewed and Accepted
LAKE COUNTY GENERAL HEALTH DISTRICT
Date 11-29-85
JOEL LUCKA, R. S. M. P. H.
Health Commissioner
by Donald B. Jones

SEWAGE DISPOSAL PERMIT MUST BE
OBTAINED BY A LAKE COUNTY LICENSED
INSTALLER BEFORE INSTALLATION IS
STARTED.

- A. To be brought to finished grade
1. Septic tank manhole covers
 2. Splitter box cover
 3. Distribution box cover
 4. Vent Pits
- B. No foot or dirt is to be discharged into septic tanks
- C. All waste water is to be discharged into septic tanks

LOW VIEWS REQUIRED
ON ALL:
Shower Head
Toilet

KATHERYN S. BECK, et al.
Vol. 550 Pg. 332

Grading Plan Approved
as shown and/or noted
THOMAS P. GILLES, P.E.
Lake County Engineer

1/15/86 DMP

CERTIFICATION

THIS PLAN WAS PREPARED BY ME
MY KNOWLEDGE AND BELIEF

REGISTRATION NO. 5244

DATE FOR		DRAWN BY	
11-4-85		RLS	
APPROVED BY		DRAWING NUMBER	
COLPETZER-THOMAS, INC.		86-095	