

SITE PLAN

CONCORD TOWNSHIP LAKE COUNTY, OHIO

for: DON & ROSEMARIE MYERS

6217 COLLEEN DRIVE CONCORD 44077

SUBDIVISION	NAME	LOT	TRACED
16	GRANDRIDGE POINT		
SUBLOT NO.	STREET	VOLUME	PAGE

LEGEND			
SANITARY MANHOLE	---○---	WATER VALVE (GAS)	---◇---
STORM MANHOLE	---●---	WATER METER (GAS)	---◇---
INLET OR CATCH BASIN	---○---	AS BUILT ELEVATION	---○---
HYDRANT	---○---	INDICATES DIRECTION OF SURFACE DRAINAGE	---○---
EXISTING CONTOURS	---○---		
PROPOSED CONTOURS	---○---		
EXIST. ELEV.	100.0	PROP. ELEV.	100.0


REMARKS

ALL BOUNDARY DATA SHOWN WAS OBTAINED FROM (DEEDS, RECORDED SUBDIVISION PLAT OR OTHER PUBLIC RECORDS)
LOCATIONS AS SHOWN OF ADJACENT WELLS AND SEPTIC TANKS OBTAINED FROM LAKE COUNTY HEALTH DEPARTMENT



DESIGN CERTIFICATION

THIS PLAT WAS PREPARED BY ME, AND IS CORRECT TO THE BEST OF MY KNOWLEDGE AND BELIEF.

NAME SURVEYOR REGISTRATION NO.

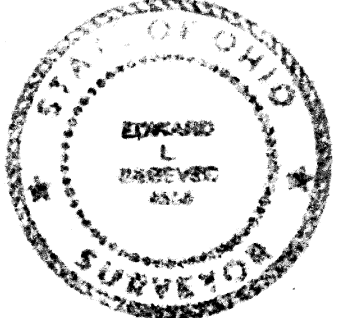


Grading Plan Approved as shown under seal of THOMAS P. SALO, P.E. Lake County Engineer By *hmp* Date 2-21-86

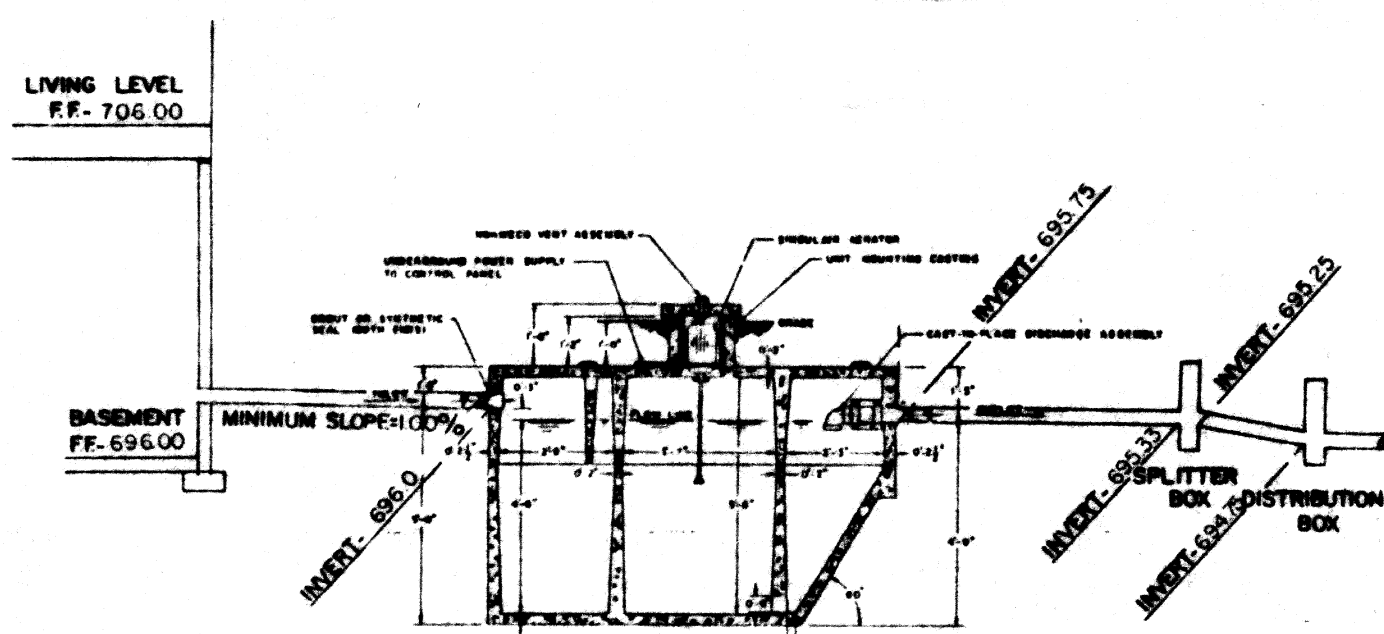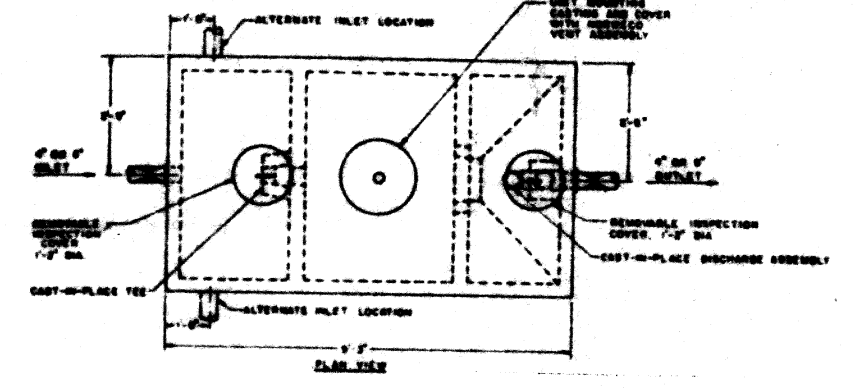

HYDRAULIC PROFILE

TYPICAL AERATION SYSTEM NORWECO OR EQUAL

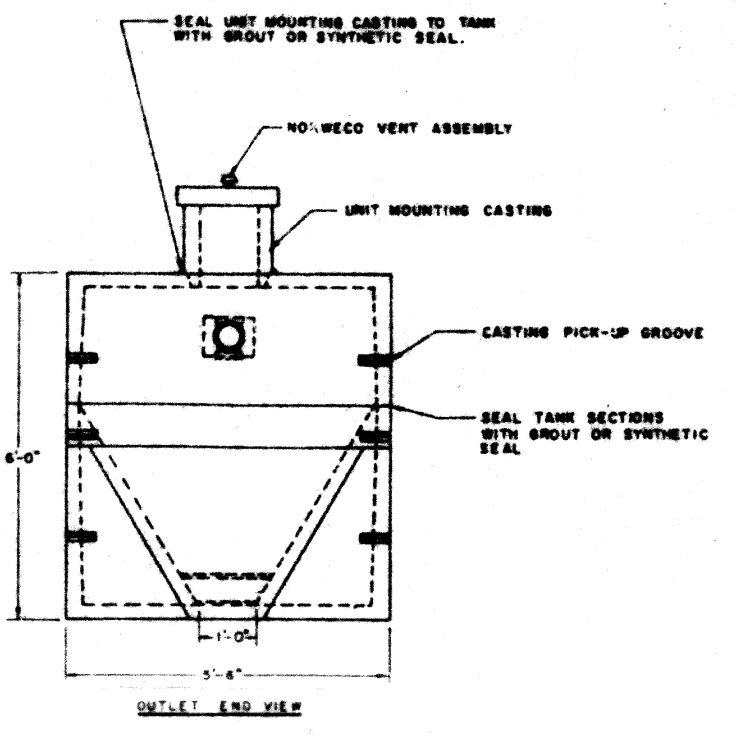

ZONING PERMIT #5299
7-21-86

SHOWN BY: [Signature]
Lake County Health Department
Tenn. J. Maran

LOW YIELD WATER FIXTURES REQUIRED ON ALL:
Shower Head
Toilet

CURVE DATA

R	128.29'
Δ	39°01'08"
A	87.37'
T	45.45'
C	85.69'
B	N 56°59'25" W

Reviewed and Accepted
LAKE COUNTY GENERAL HEALTH DISTRICT
Date 7-18-86
JUEL LUCIA, R. S., M. P. H.
Health Commissioner
BY *David B. Jones*

- A. To be brought to finished grade
1. Septic tank manhole access
2. Splitter box access
3. Distribution box access
4. Vent pipe
B. No further grading required
C. All inlets and outlets to be installed and into septic tank

SEWAGE DISPOSAL PERMIT MUST BE OBTAINED BY A LAKE COUNTY LICENSED INSTALLER BEFORE INSTALLATION IS STARTED.

REVISIONS			PLAN PREPARED BY:		
NO.	DATE	BY	DEBEVEC • SALO & ASSOCIATES, INC.		
1			125 E. ERIE ST. PAINESVILLE, OHIO		
2					
3			DRAWN BY	SCALE 1" = 20'	PHONE NO. 352-9250
4			CHK'D.	DATE 5/86	DRAWING NO.
5			CHIEF	APP'D.	6488-16

S 38°24'04"E

192.66'

S / L 16

WILDERNESS AREA

N 24°03'49"E

TOP OF BANK

DUPLICATION AREA

640' L.F. LEACH FIELD

AERATION PLANT

EXIST. HOUSE


GRANDRIDGE

POINTE DRIVE

60'

BENCHMARK - NAIL SET IN ROOT OF OAK TREE IN CUL-DE-SAC EL - 709.29

- NOTES
- FALL THROUGH PLANT FROM INLET TO OUTLET IS THREE INCHES. INLET INVERT IS TWELVE INCHES BELOW TANK TOP.
 - PRECAST RISERS MUST BE USED TO EXTEND UNIT MOUNTING CASTING TO GRADE.
 - ON DEEPER INSTALLATIONS INSPECTION COVER ON PRETREATMENT CHAMBER MUST BE DEVELOPED TO WITHIN TWELVE INCHES OF GRADE.
 - TANK REINFORCED PER A.C. STANDARD SB-71.
 - REMOVABLE COVER ON RISER WEIGHS IN EXCESS OF SEVENTY FIVE POUNDS.
 - CONTACT LOCAL DISTRIBUTOR FOR ELECTRICAL REQUIREMENTS.

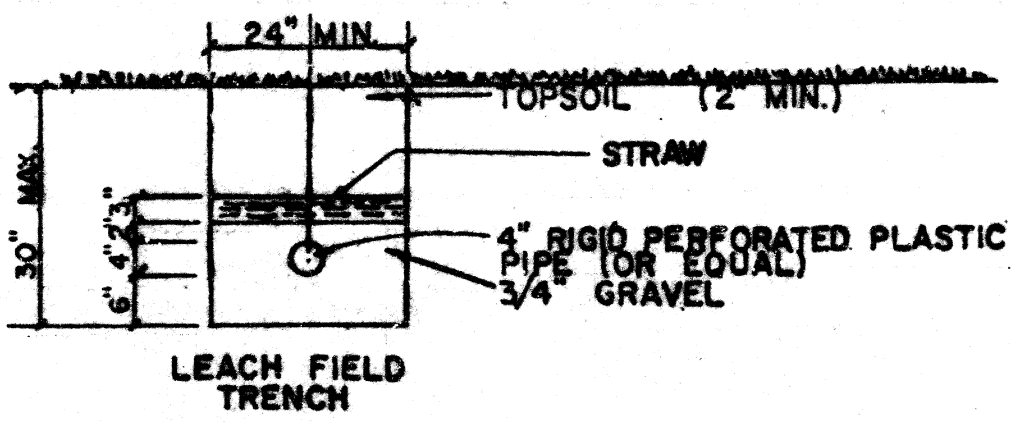

LEACH FIELD TRENCH