

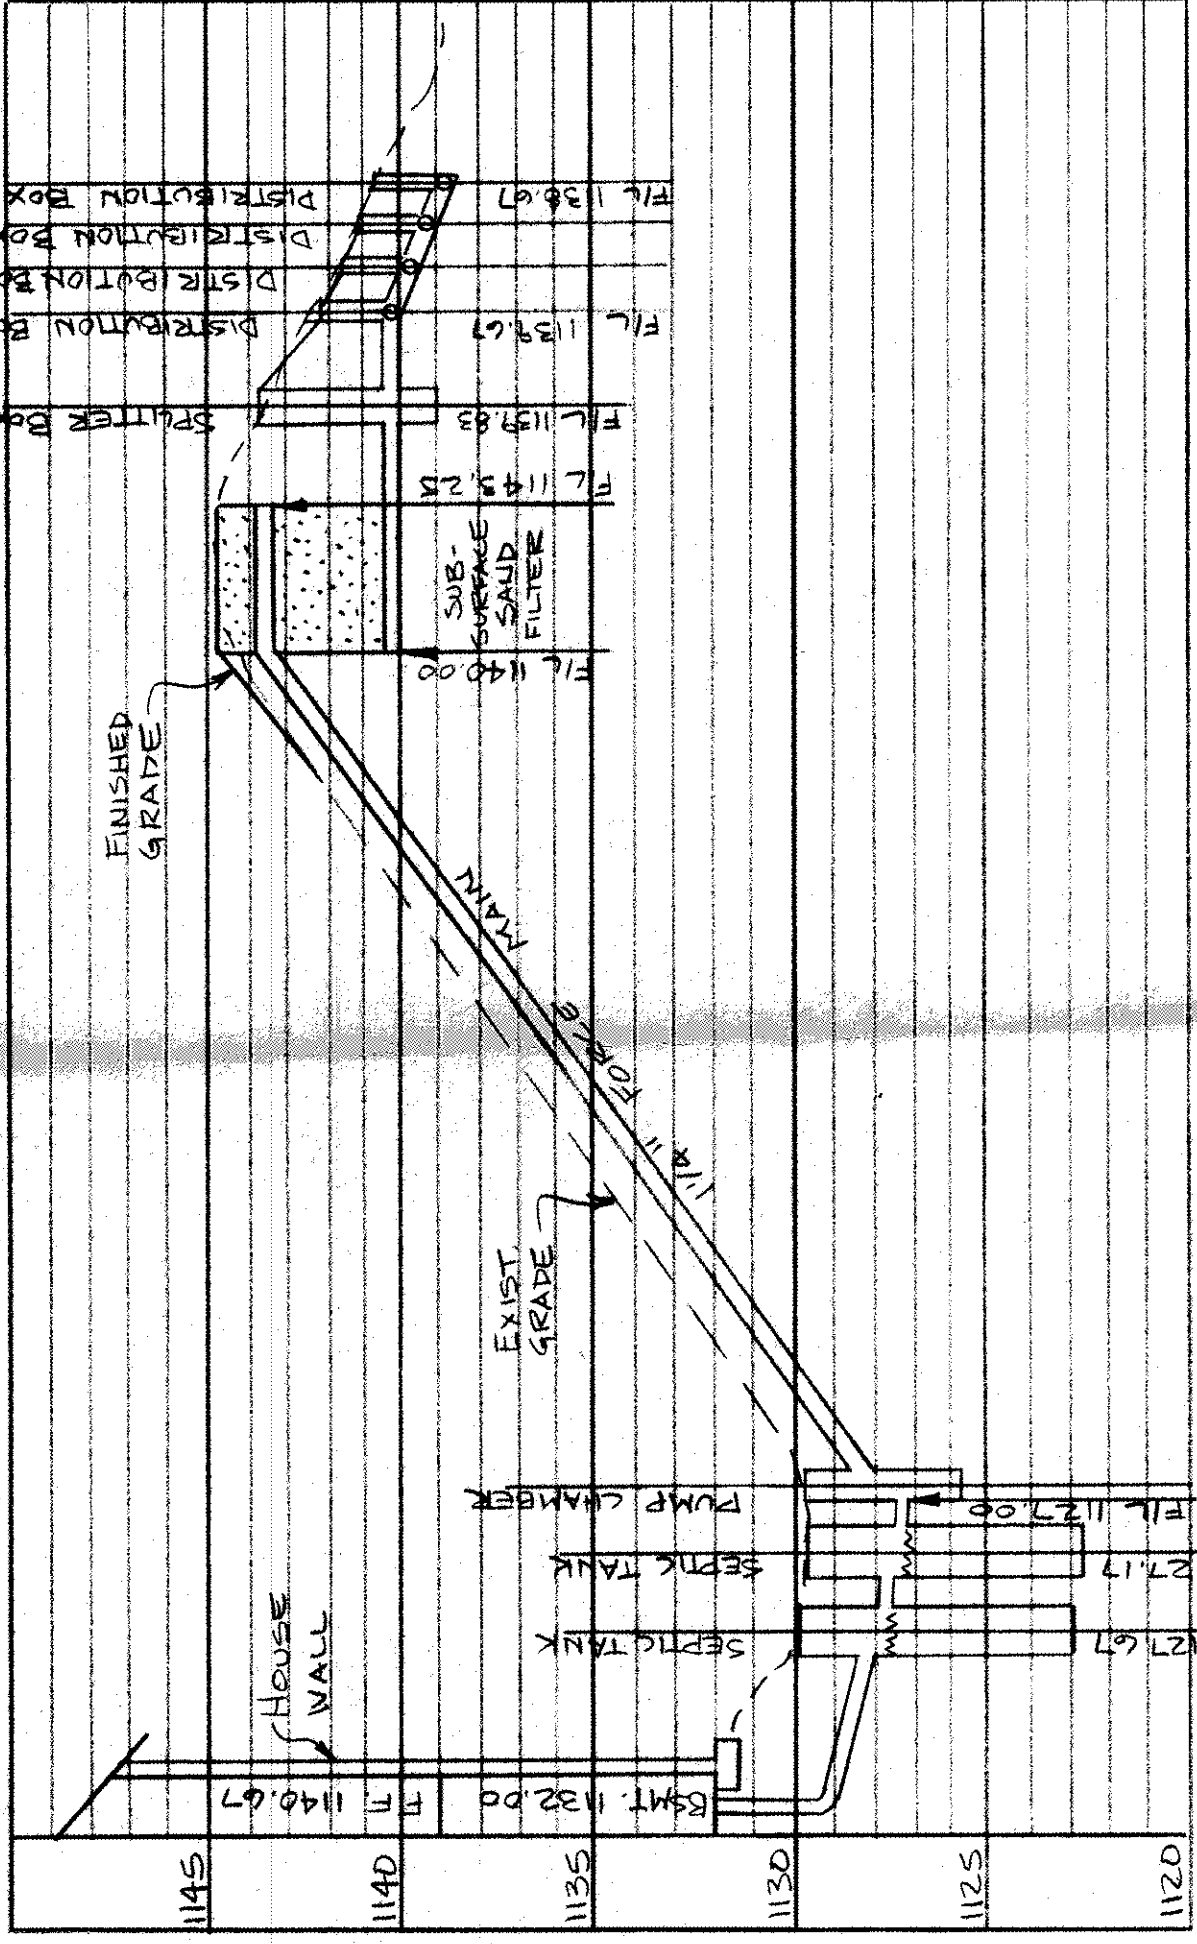



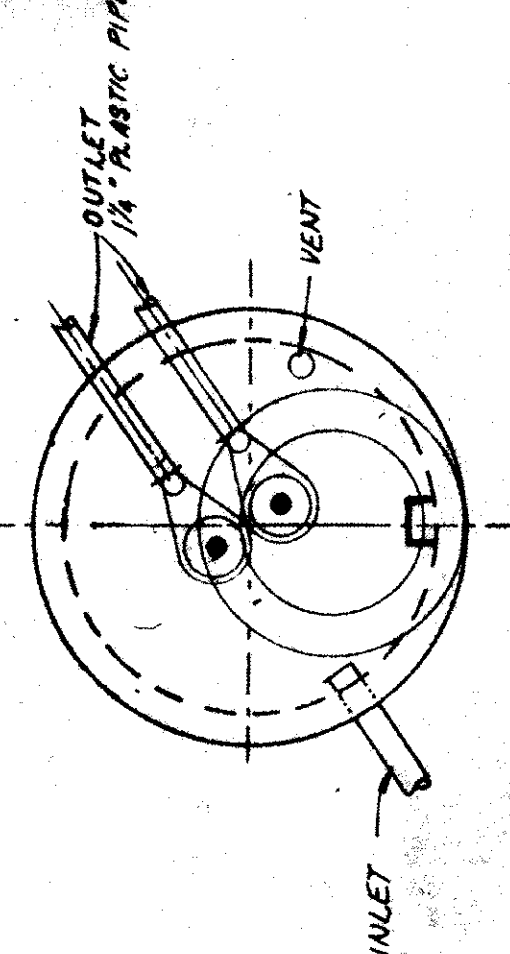


HYDRAULIC PROFILE
SCALE: 1" = 40' HORIZ.
1" = 5' VERT.


- CONTROLS:** WATERGUARD TPL-1 PUMP (AUTOMATIC INTERMITTENT PUMP)
MODEL DPL WITH NEARBY ENCLOSURE
MOUNTED INSIDE OF BUILDING
5-PORT SYSTEM WITH MANUAL TO ACTIVATE
WHEN AT SECOND PUMP LINE.
- 2. PROVIDE GAS-VENT WATER TIGHT FLEXIBLE CONNECTION.**
PROVIDE 1/2" DIA. RIGID ON EACH PUMP FOR REMOVAL.
PRICES FOR ABOVE PUMPS AND CONTROLS MAY BE
OBTAINED FROM GELBER PUMPS, INC.

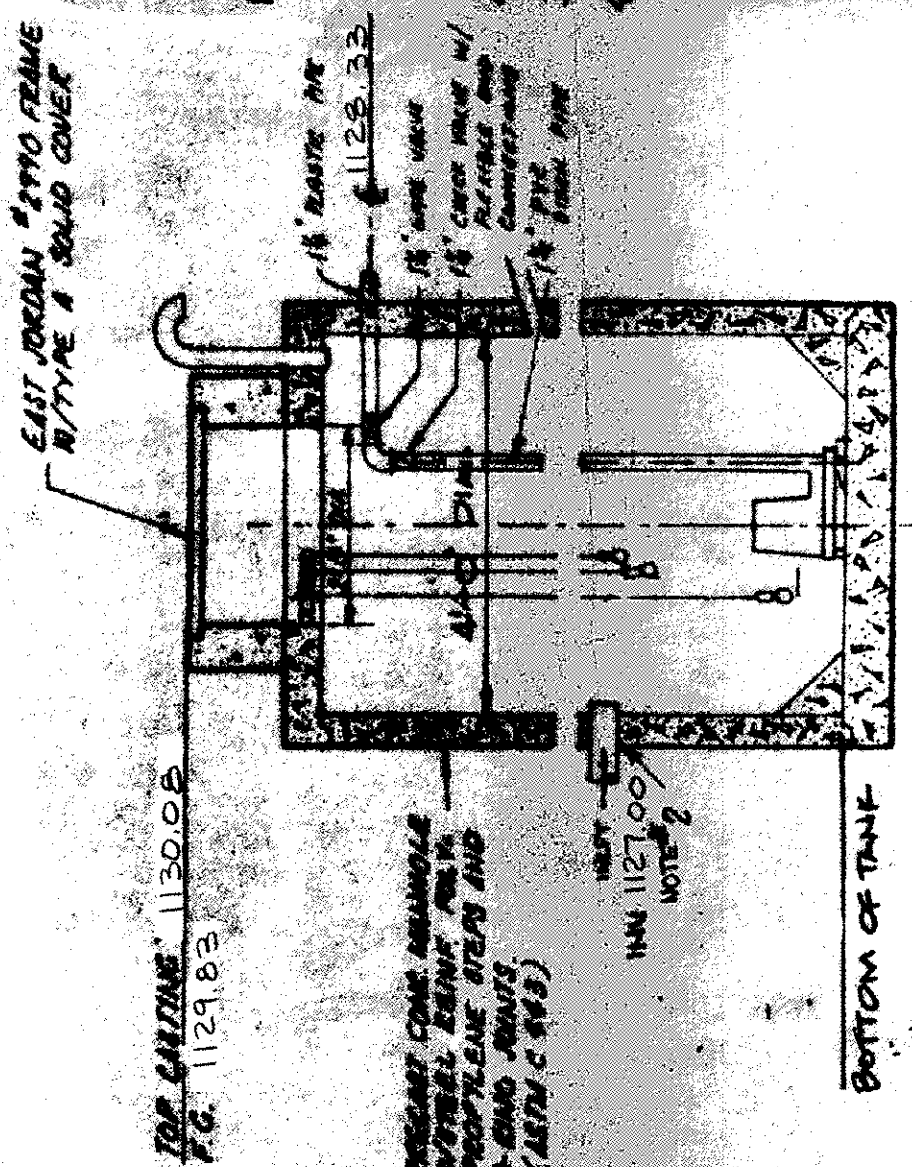



PUMP CHAMBER
(NO SCALE)

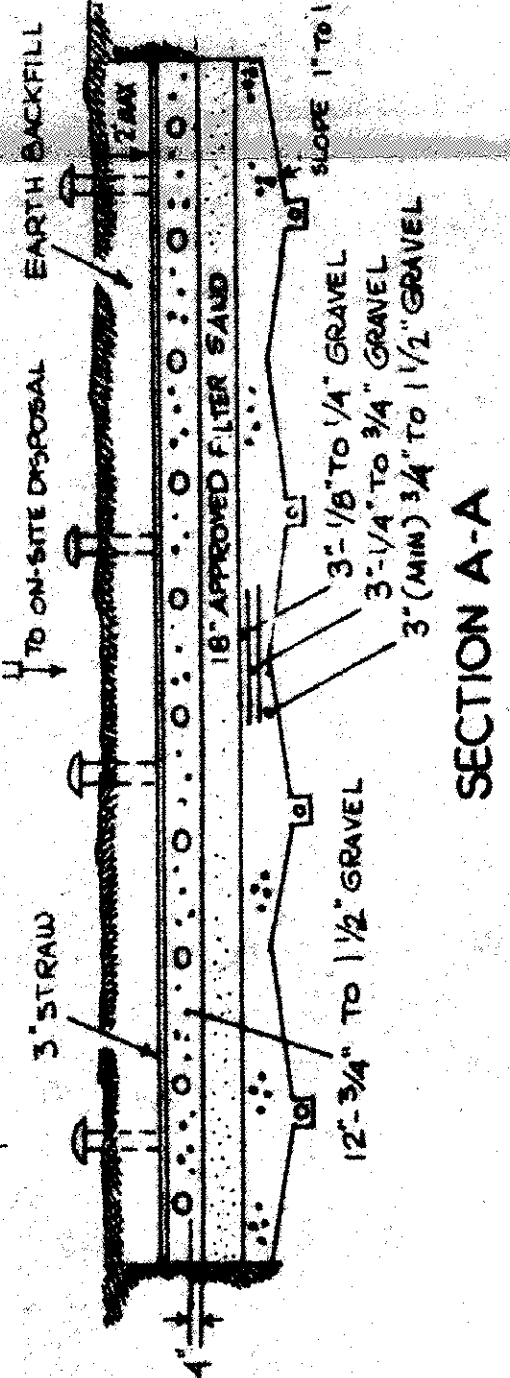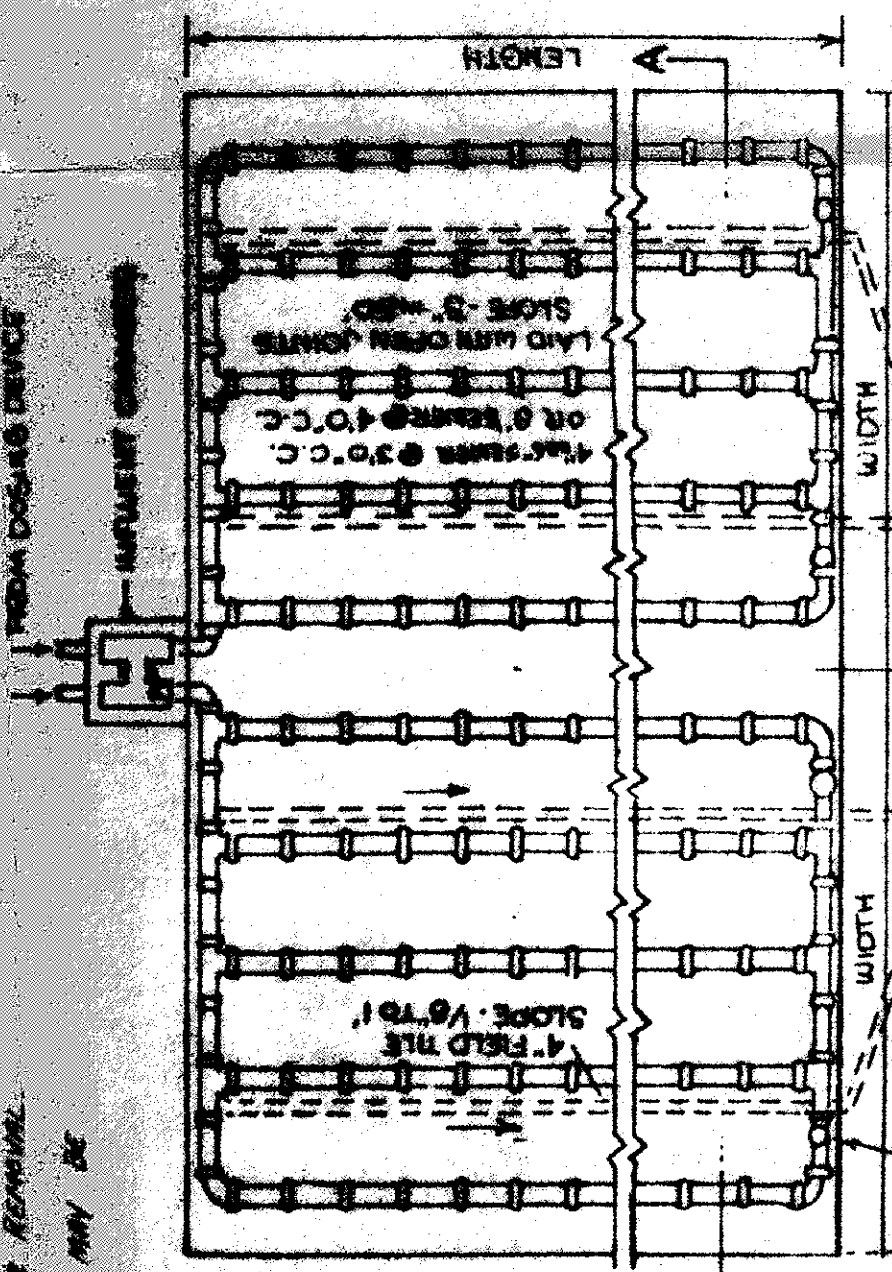


SUBSURFACE SAND FILTERS

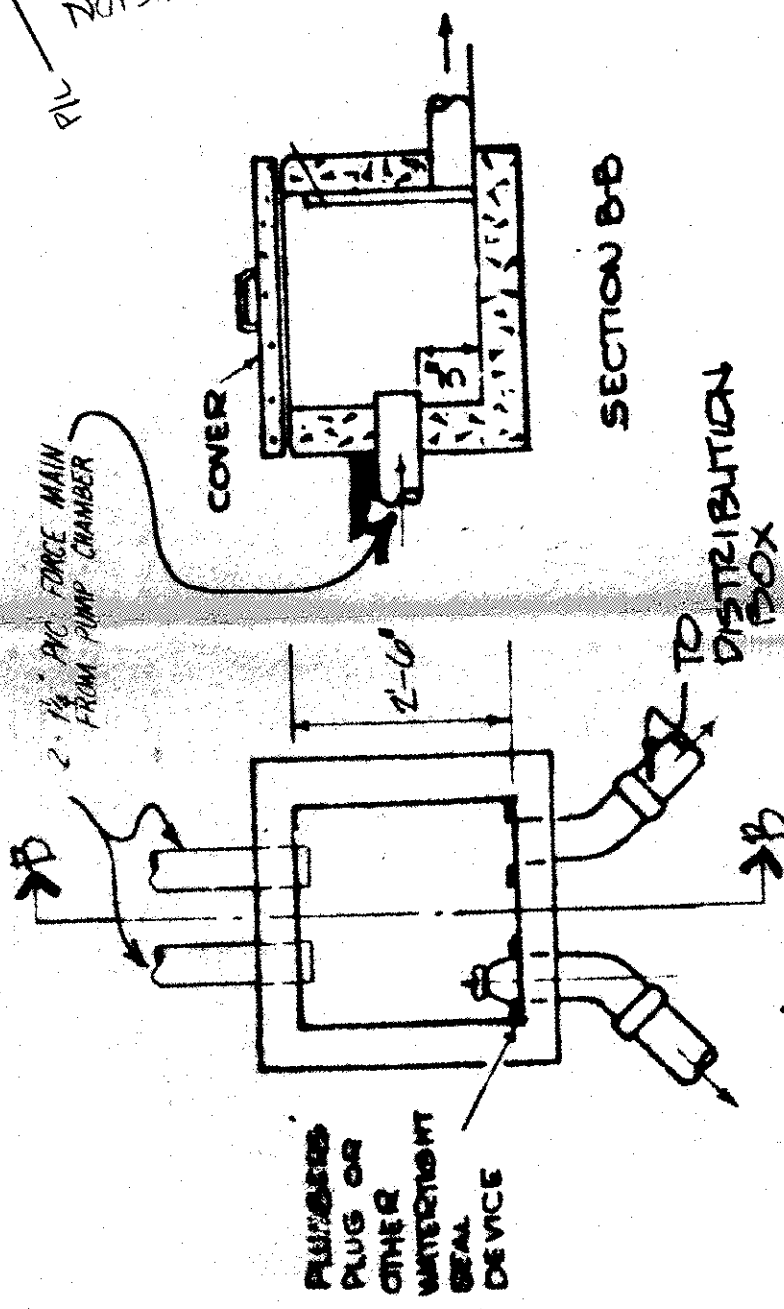

SPLITTER BOX

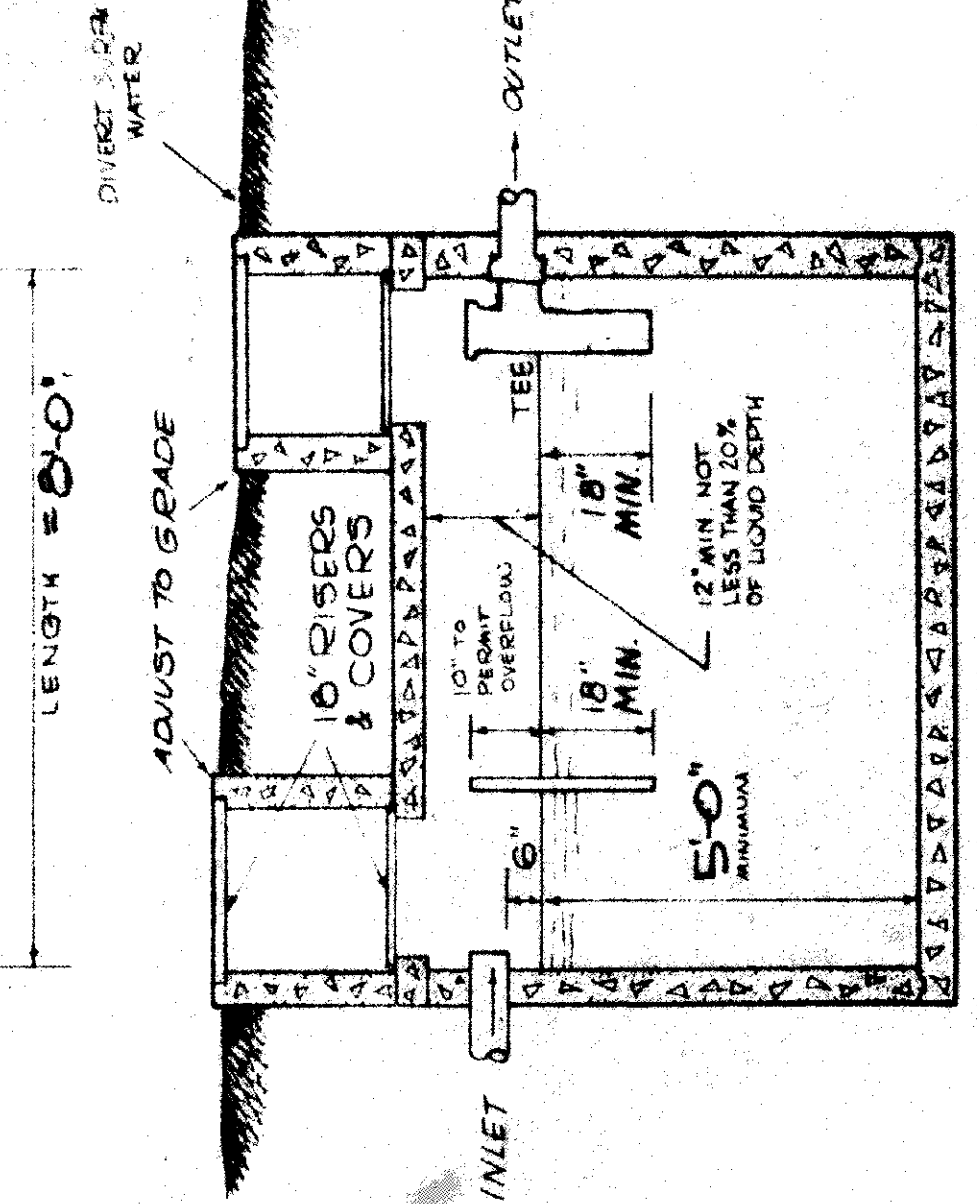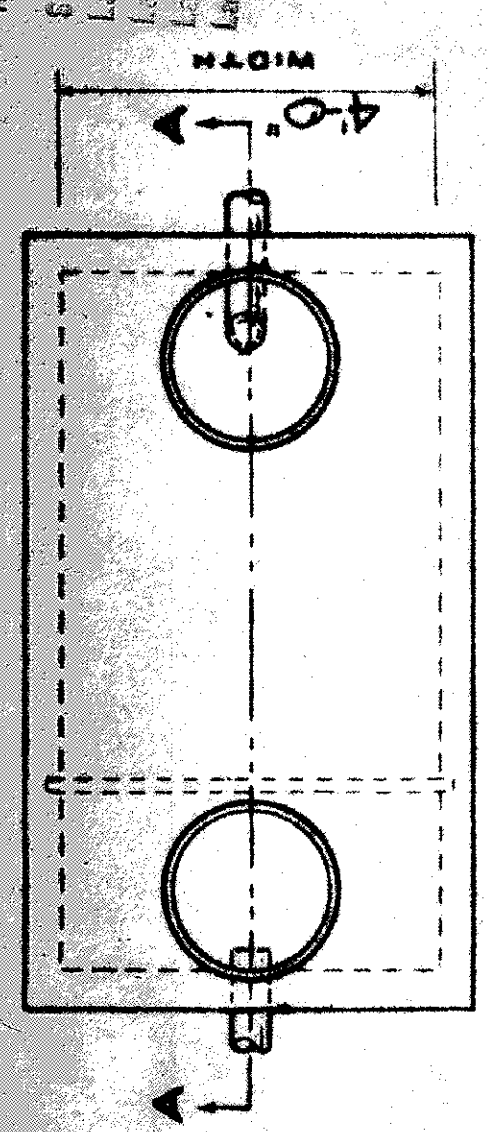



SECTION A-A
SEPTIC TANK

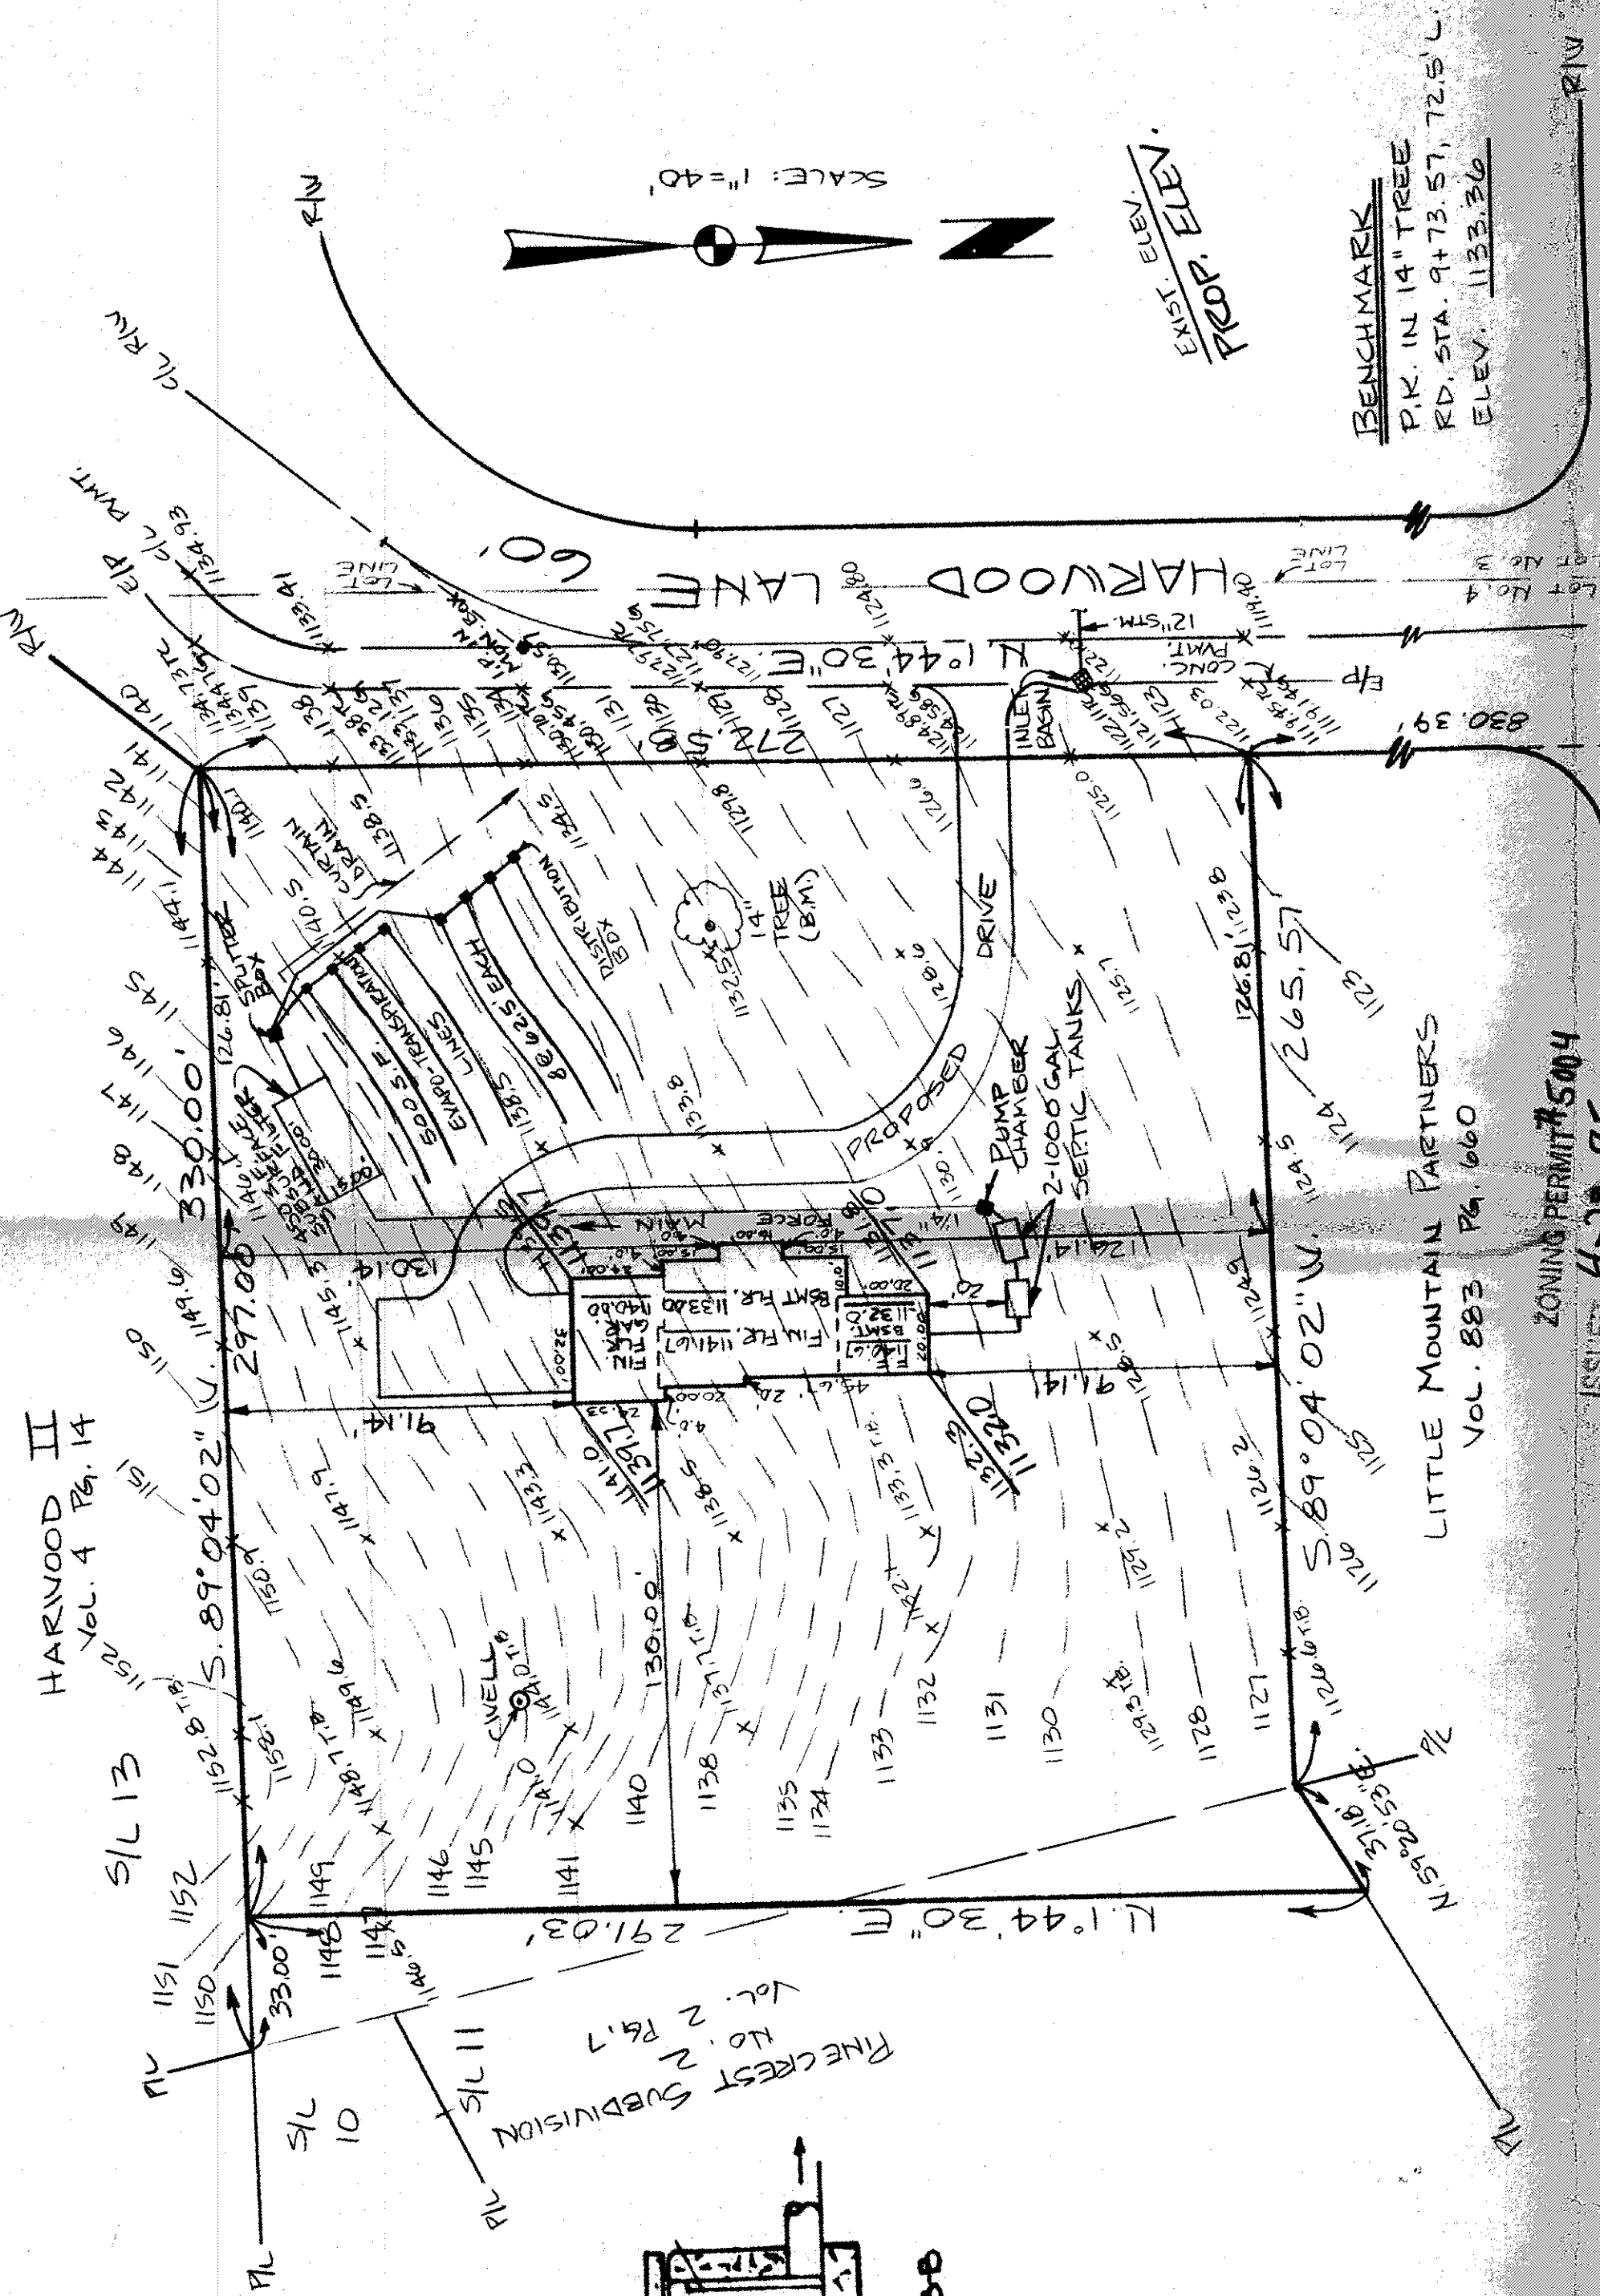

ISSUED 4-22-85
ZONING PERMIT #504

SUBJECT TO APPROVAL BY:
Lake County Zoning Dept.
Lake County Planning Comm.
Lake County Eng. Dept.

Tom & Mary

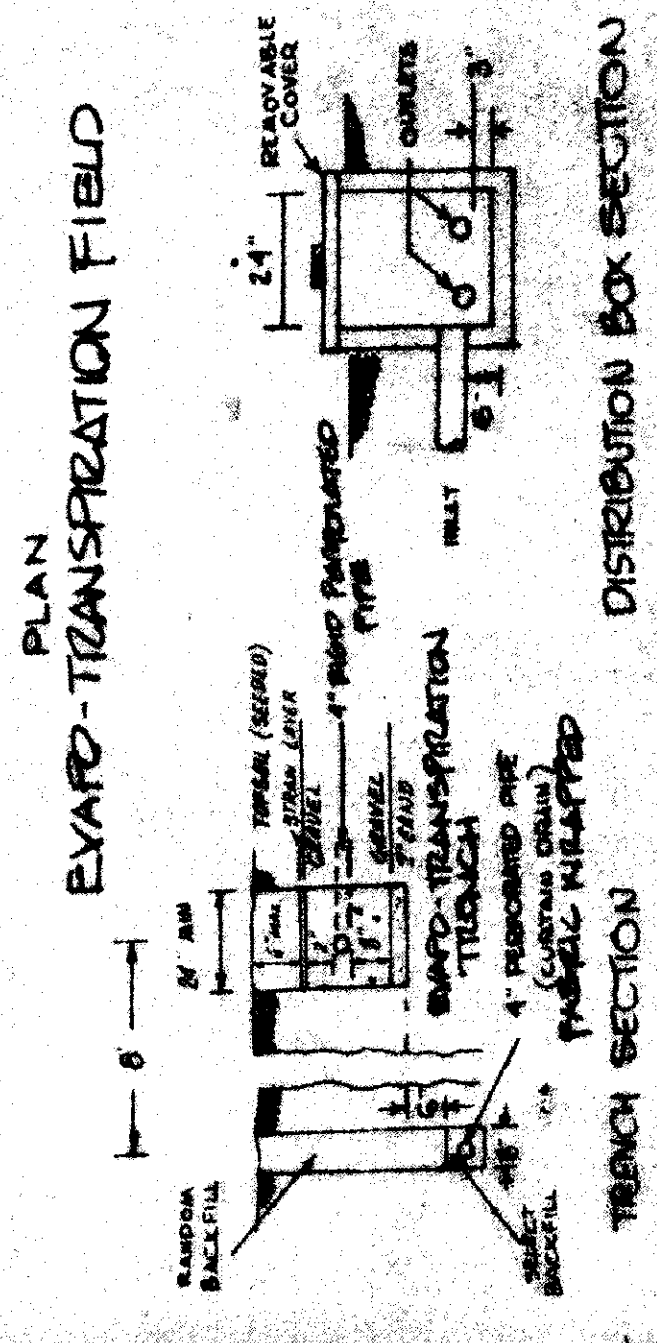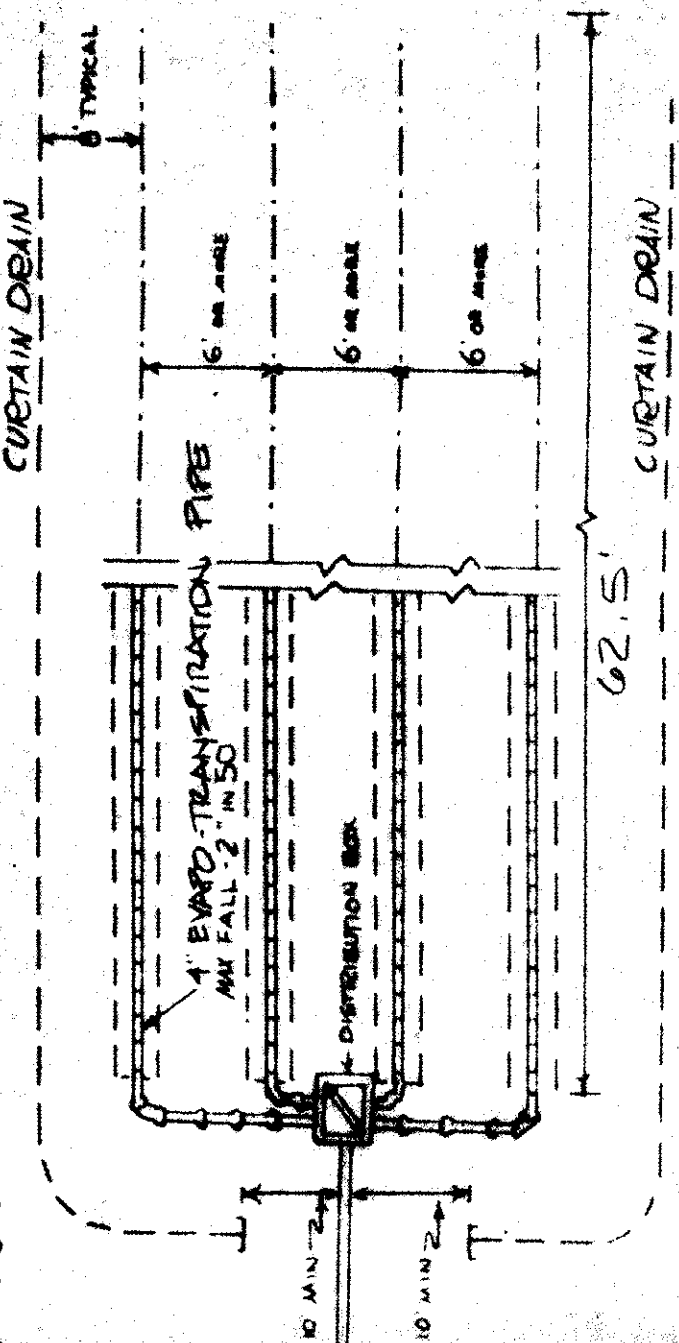

Grading Plan Approved
Seismic Analysis Performed
THOMAS P. GILLES, P.E.
Lake County Engineer