
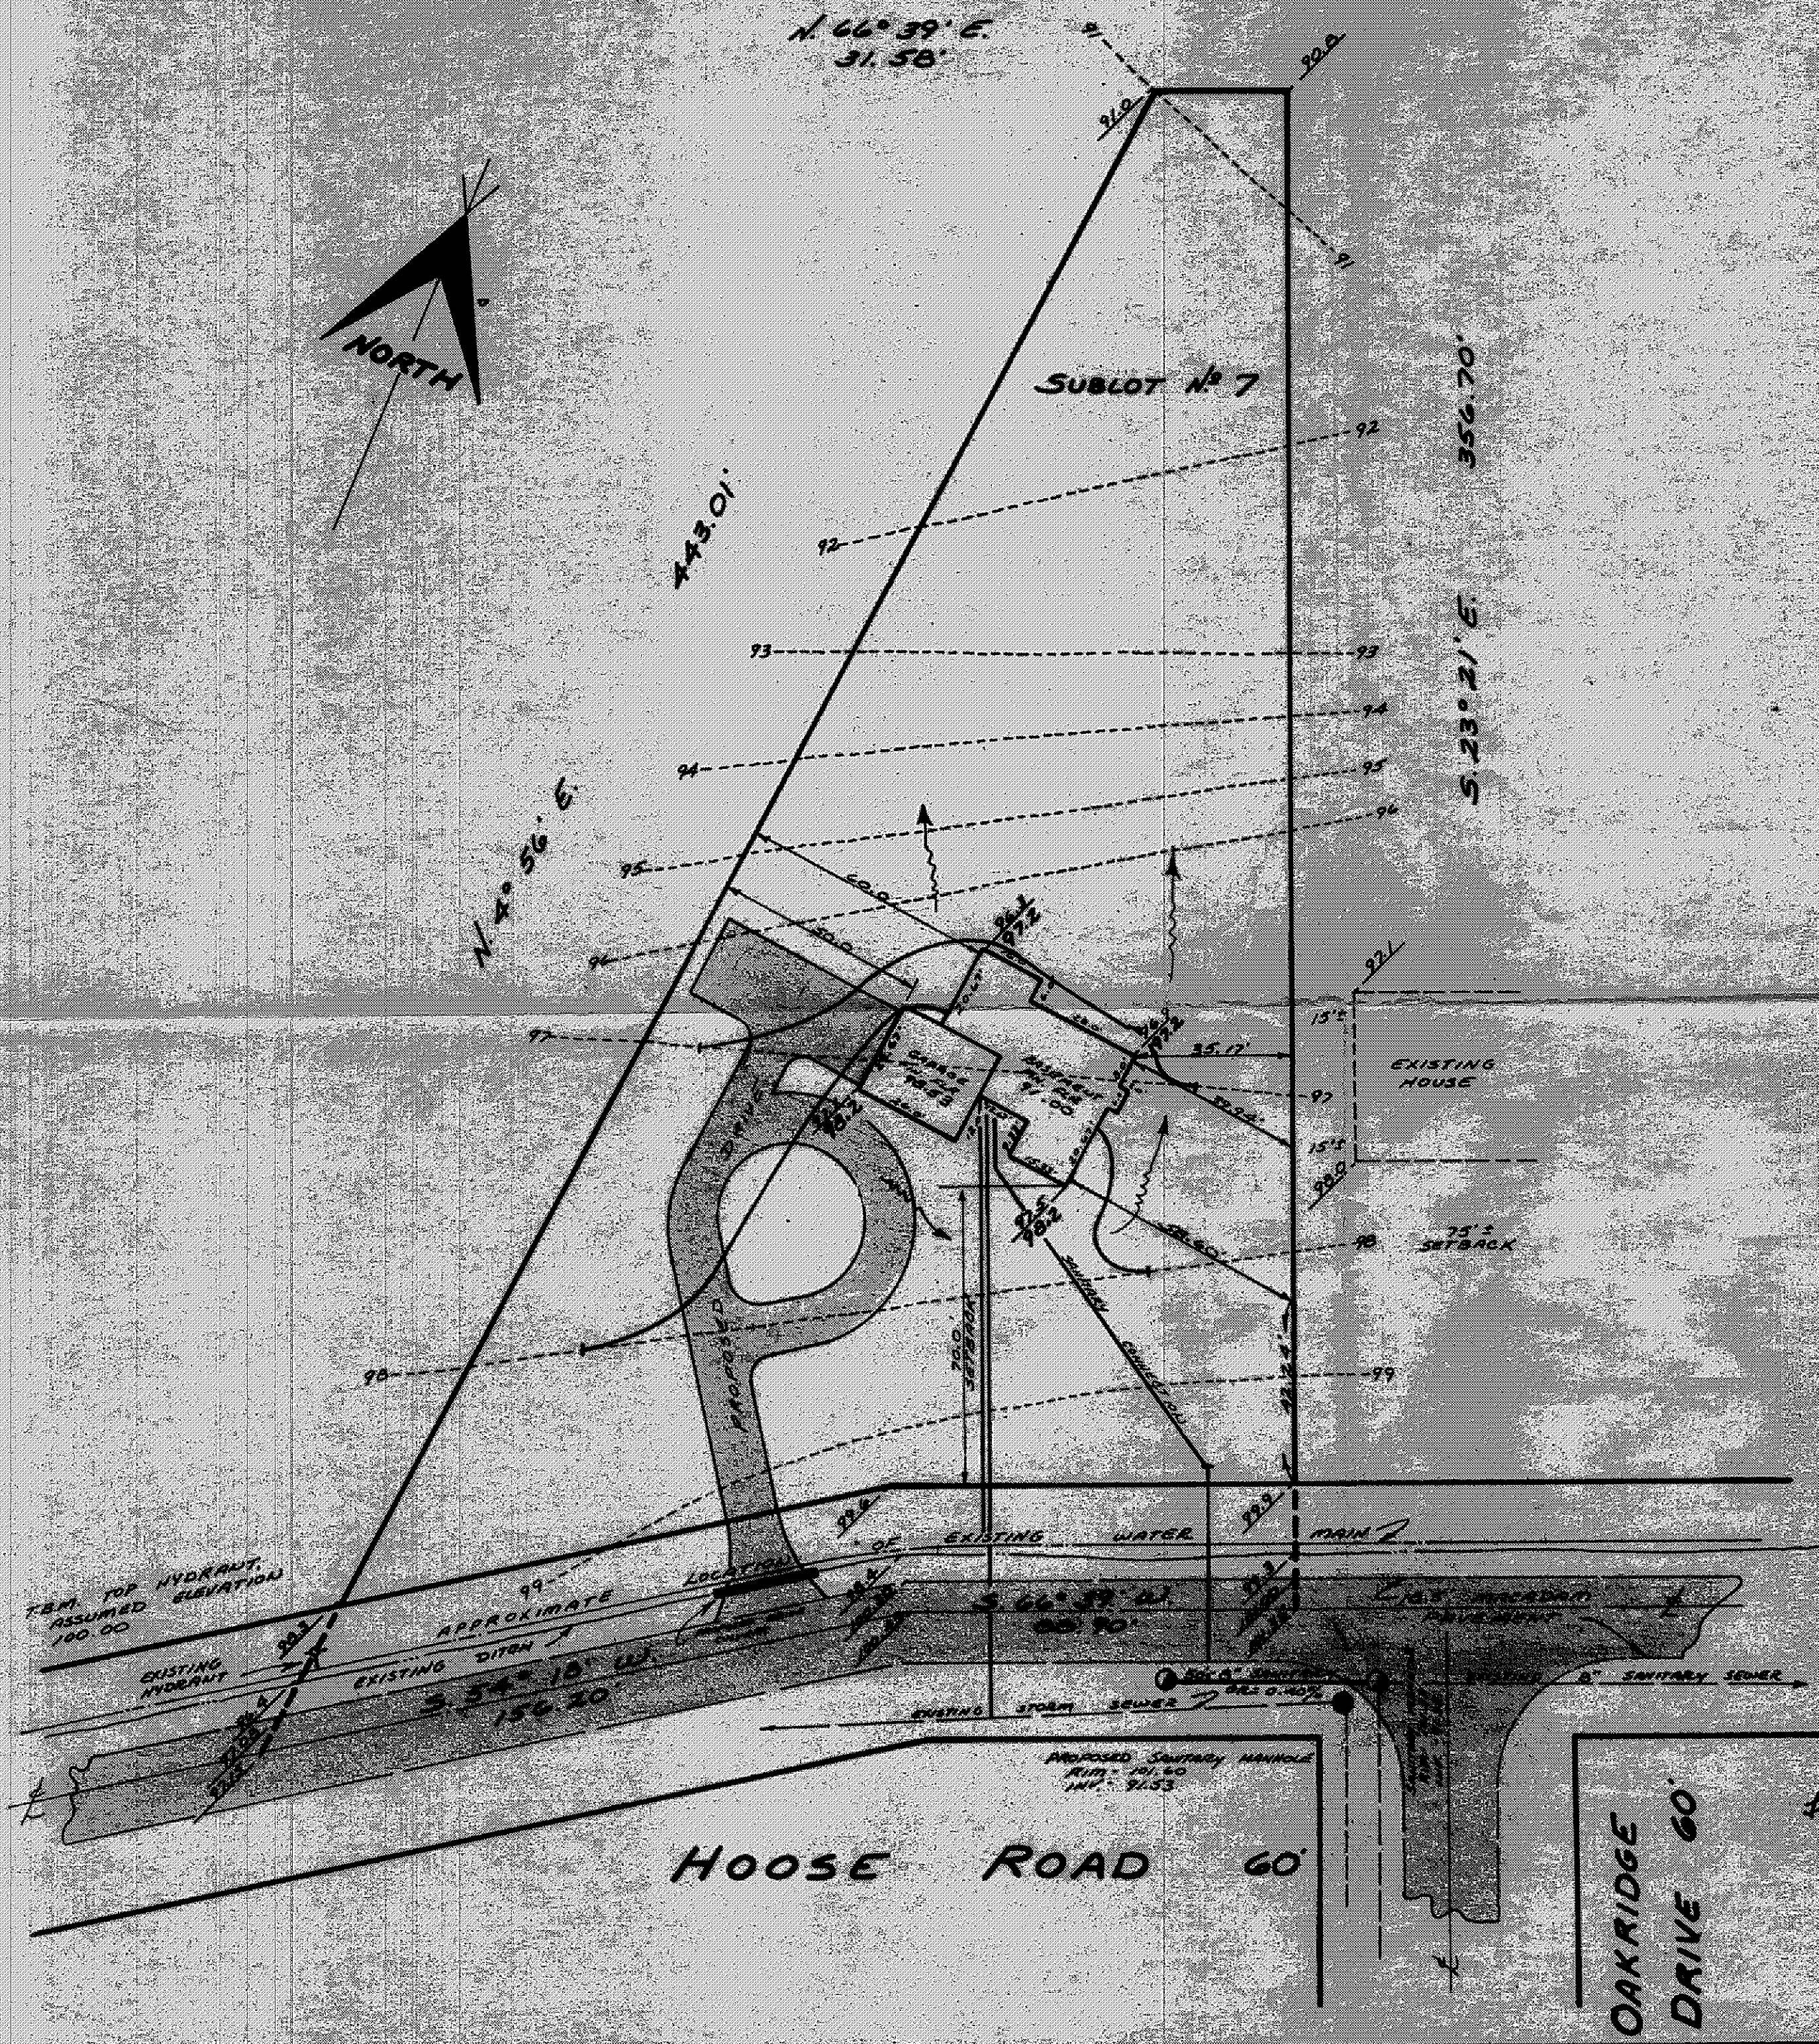


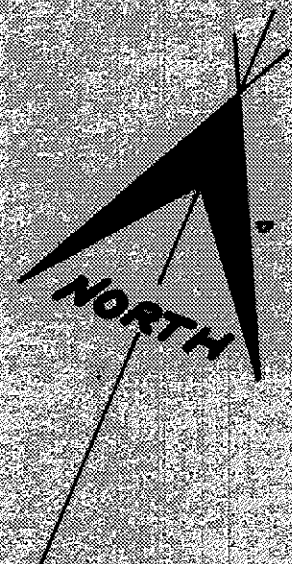

SITE PLAN

CONCORD LAKE COUNTY, OHIO
TOWNSHIP
for: **EVANS CONSTRUCTION**
CLIENT OWNER

ADDRESS STREET CITY ZIP

FRANCIS SUBDIVISION
SUBDIVISION **M-8** NAME
VOL. - PG. **NOOSE**
SUBLOT NO. STREET

LOT TRACT
VOLUME PAGE
PERM. PARCEL NO. STREET

LEGEND

SANITARY MANHOLE: WATER VALVE (GAS)
STORM MANHOLE: WATER METER (GAS)
INLET OR CATCH BASIN: AS BUILT ELEVATION
HYDRANT: INDICATES DIRECTION OF SURFACE DRAINAGE
EXISTING CONTOURS: 100.0
PROPOSED CONTOURS: 100.0
EXIST. ELEV. 100.0 PROP. ELEV.

REMARKS

ALL BOUNDARY DATA SHOWN WAS OBTAINED FROM (DEEDS, RECORDED SUBDIVISION PLAT OR OTHER PUBLIC RECORDS)
LOCATIONS AS SHOWN OF ADJACENT WELLS AND SEPTIC TANKS OBTAINED FROM LAKE COUNTY HEALTH DEPARTMENT

DESIGN CERTIFICATION

THIS PLAN WAS PREPARED BY ME, AND IS CORRECT TO THE BEST OF MY KNOWLEDGE AND BELIEF.

NAME SURVEYOR REGISTRATION NO.

CHECK LIST

NO. OF BEDROOMS
DIMENSIONS
BEARINGS
TIE TO NEAREST STREET
SUBLOT NO. PARCEL NO.
SURROUNDING OWNERS
BLOG. DIMENSIONS FIN. GR.
BLOG. TIES PLR. GRADES
APRON TYPE WIDTH THICKNESS
SIDEWALK TYPE WIDTH THICKNESS
CULVERT TYPE DIA. LENGTH
ROCK OUTCROPPINGS

WATER MAIN SIZE, LOCATION
SAN. SEWER SIZE % GR. LOC.
SAN. MH. CAST. ELEV. INV. ELEV.
SAN. CONN. SIZE, LOC. DEPTH
STORM SEWER SIZE % GR. LOC.
STORM MH. CAST. ELEV. INV. ELEV.
PAVT. TYPE GRADE CURBS
GAS LINE LOC. SIZE PRESSURE
SEPTIC TANK LOCATION & DUPLICATION AREA
WELL LOCATION
ISOLATION RADIUS FROM WELL

REVISIONS			PLAN PREPARED BY:		
NO.	DATE	BY	DEBEVEC - SALO & ASSOCIATES, INC.		
1	8 NOV 76	RK	130 EAST JACKSON ST. PAINESVILLE, OHIO		
2			DRAWN BY	SCALE	PHONE NO.
3			CHK'D.	DATE	DRAWING NO.
4			CREW CHIEF	APP'D.	

"AS-BUILT" CERTIFICATION

I, HEREBY CERTIFY THAT THE CIRCLED GRADES ARE EXISTING FINISH GRADES CHECKED IN FIELD ON 19 BY SURVEYING AND ARE CORRECT TO THE BEST OF MY KNOWLEDGE AND BELIEF.

REGISTERED SURVEYOR REG. NO.

ZONING PERMIT
PERMIT
PERMIT

Approved 11-10-76
HE van Diest

Grading Plan Approved
as shown and/or noted
THOMAS P. GILLES, P.E.
Lake County Engineer
By Date 11-15-76

4775-7