

WALKER TOWNSHIP, LAKE COUNTY, OHIO

for: John Mulcahey 691-1800
CLIENT OWNER

ADDRESS	STREET	CITY	ZIP
---------	--------	------	-----

131
 SUBLOT NO. _____
 LOT _____
 TRACT _____
 VOLUME _____
 PAGE _____
 PERM. PARCEL NO. _____
 STREET _____
 STREET _____

LEGEND	
SANITARY MANHOLE	①
STORM MANHOLE	●
INLET OR CATCH BASIN	■
HYDRANT	⊙
EXISTING CONTOURS	—
PROPOSED CONTOURS	---
EXIST. ELEV.	100.0
	100.0' PROP. ELEV.
WATER VALVE (GAS)	⊕
WATER METER (GAS)	—
AS BUILT ELEVATION	---
INDICATES DIRECTION OF SURFACE DRAINAGE	→

ALL BOUNDARY DATA SHOWN WAS OBTAINED FROM (DEEDS, RECORDED
SUBDIVISION PLAT OR OTHER PUBLIC RECORDS)

LOCATIONS AS SHOWN OF ADJACENT WELLS AND SEPTIC TANKS OBTAINED FROM
LAKE COUNTY HEALTH DEPARTMENT

THIS PLAT WAS PREPARED BY ME, AND IS CORRECT
TO THE BEST OF MY KNOWLEDGE AND BELIEF.

NAME	SURVEYOR	REGISTRATION	NO.

100

NO. OF BEDROOMS	WATER MAIN SIZE	LOCATION
DIMENSIONS	SAN. SEWER SIZE <td>% GR. LOC.</td>	% GR. LOC.
BEARINGS	SAN. MH. CAST. ELEV. <td>INV. ELEV. </td>	INV. ELEV.
TIE TO NEAREST STREET	SAN. CONN. SIZE <td>LOC. DEPTH </td>	LOC. DEPTH
SUBLOT NO. PARCEL NO.	STORM SEWER SIZE <td>% GR. LOC.</td>	% GR. LOC.
SURROUNDING OWNERS	STORM MH. CAST. ELEV. <td>INV. ELEV. </td>	INV. ELEV.
BLDG. DIMENSIONS FIN. GR.	PAV'TY TYPE <td>GRAD. CURVS </td>	GRAD. CURVS
BLDG. TIES FLR. GRADES	GAS LINE LOC. <td>SIZE PRESSURE </td>	SIZE PRESSURE
APPROX. TYPE WIDTH THICKNESS	SEPTIC TANK LOCATION	DUPLICATION AREA
SIDEWALK TYPE WIDTH THICKNESS	WELL LOCATION	
CULVERT TYPE DIA. LENGTH	ISOLATION RADIUS FROM WELL	
ROCK OUTCROPPINGS		

REVISIONS			PLAN PREPARED BY:		
NO.	DATE	BY			
1	9/19/94	HT			
2					
3					
4					
5					

BABCOCK • JONES & ASSOCIATES, INC.		
PAINESVILLE, OHIO		
DRAWN BY	SCALE	PHONE NO.
HT	1" = 30'	357-1811
CHKD.	DATE	DRAWING NO.
HT	9/16/94	
CREW CHIEF	APPD.	
LT	HT	88-158-131

I, HEREBY CERTIFY THAT THE CIRCLED GRADES ARE EXISTING
FINISH GRADES CHECKED IN THE FIELD ON , 19
AND ARE CORRECT TO THE BEST OF MY KNOWLEDGE AND BELIEF.

REGISTERED SURVEYOR	REG. NO.
---------------------	----------

7BM - 12.1M SAL MH, SL 154+35US
Elev. = 904.73

0994-7983

ISSUED 9-21-94


SUBJECT TO APPROVAL BY:

Lake County Sanitary Eng. ☐

Lake County Eng. Dept. ☒

Lake County Planning Comm. ☐

Lake County Bldg. Dept. ☒

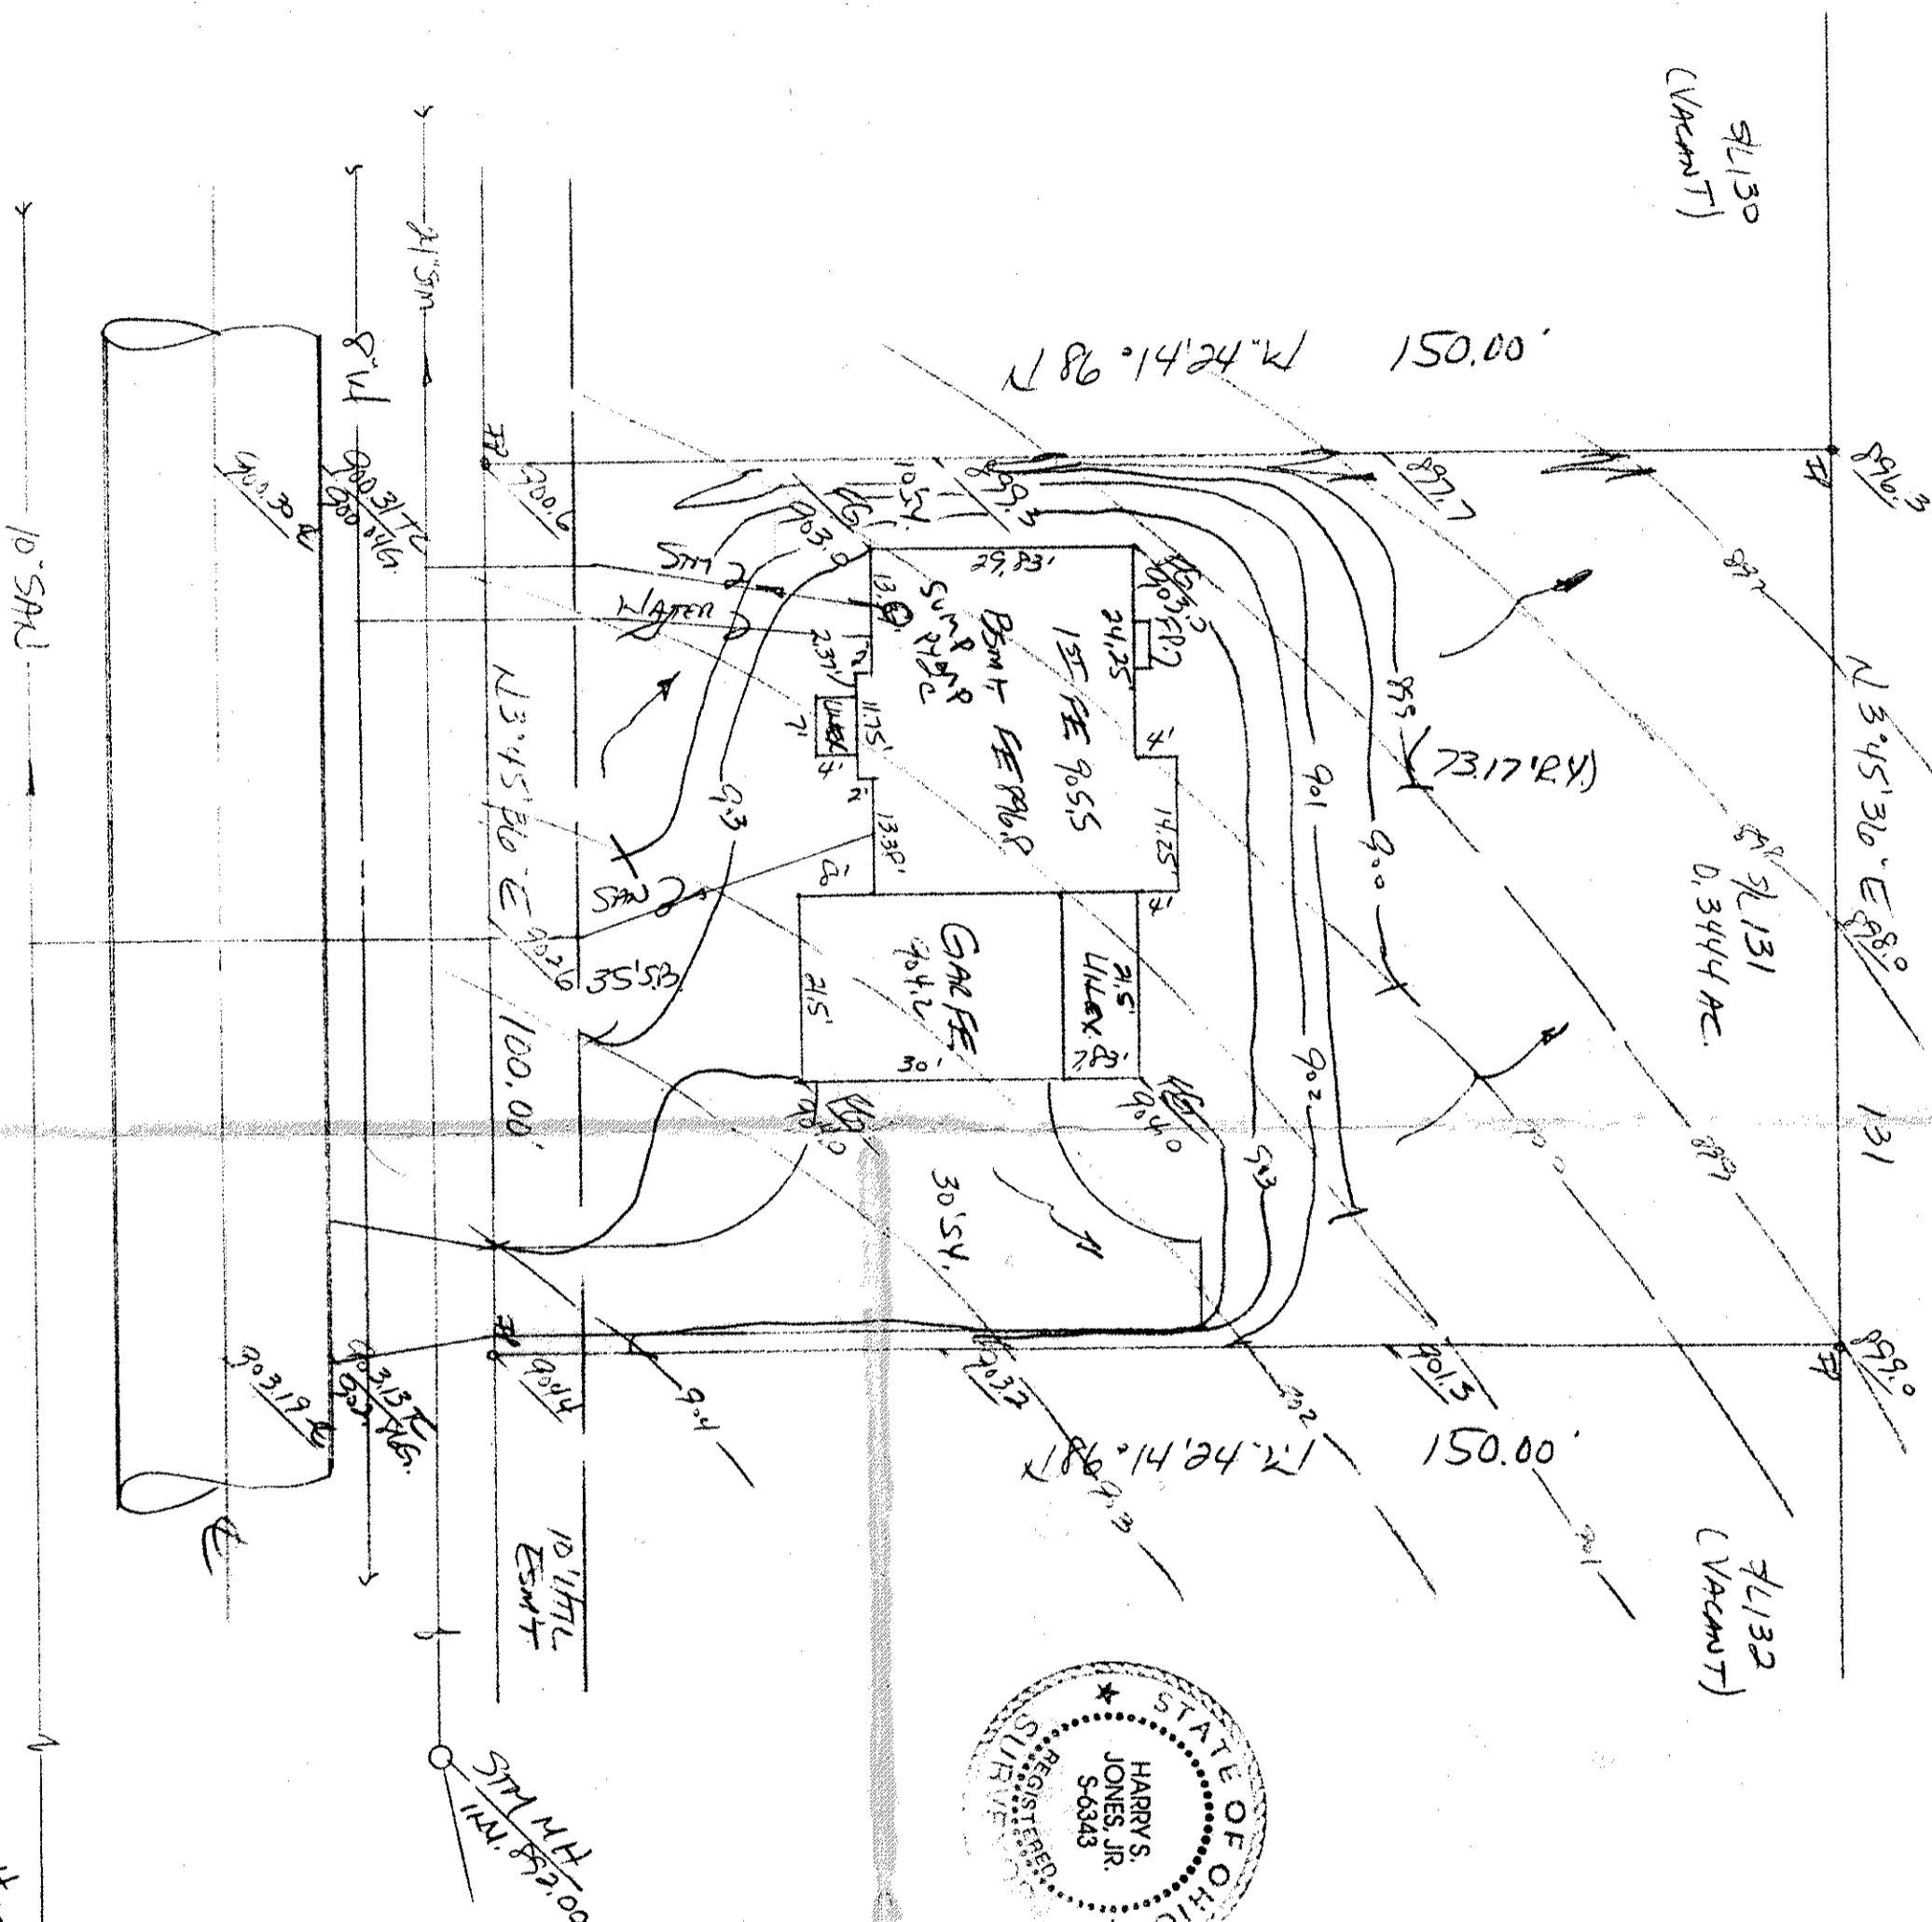

HUKTILS LAKE DR-60

**ROOF DRAINS
SHALL DISCHARGE
TO SPLASH BLOCKS.**

Grading Plan Approved
as shown and/or noted
THOMAS P. GILLES, P.E.
Lake County Engineer
Date 9/2/94