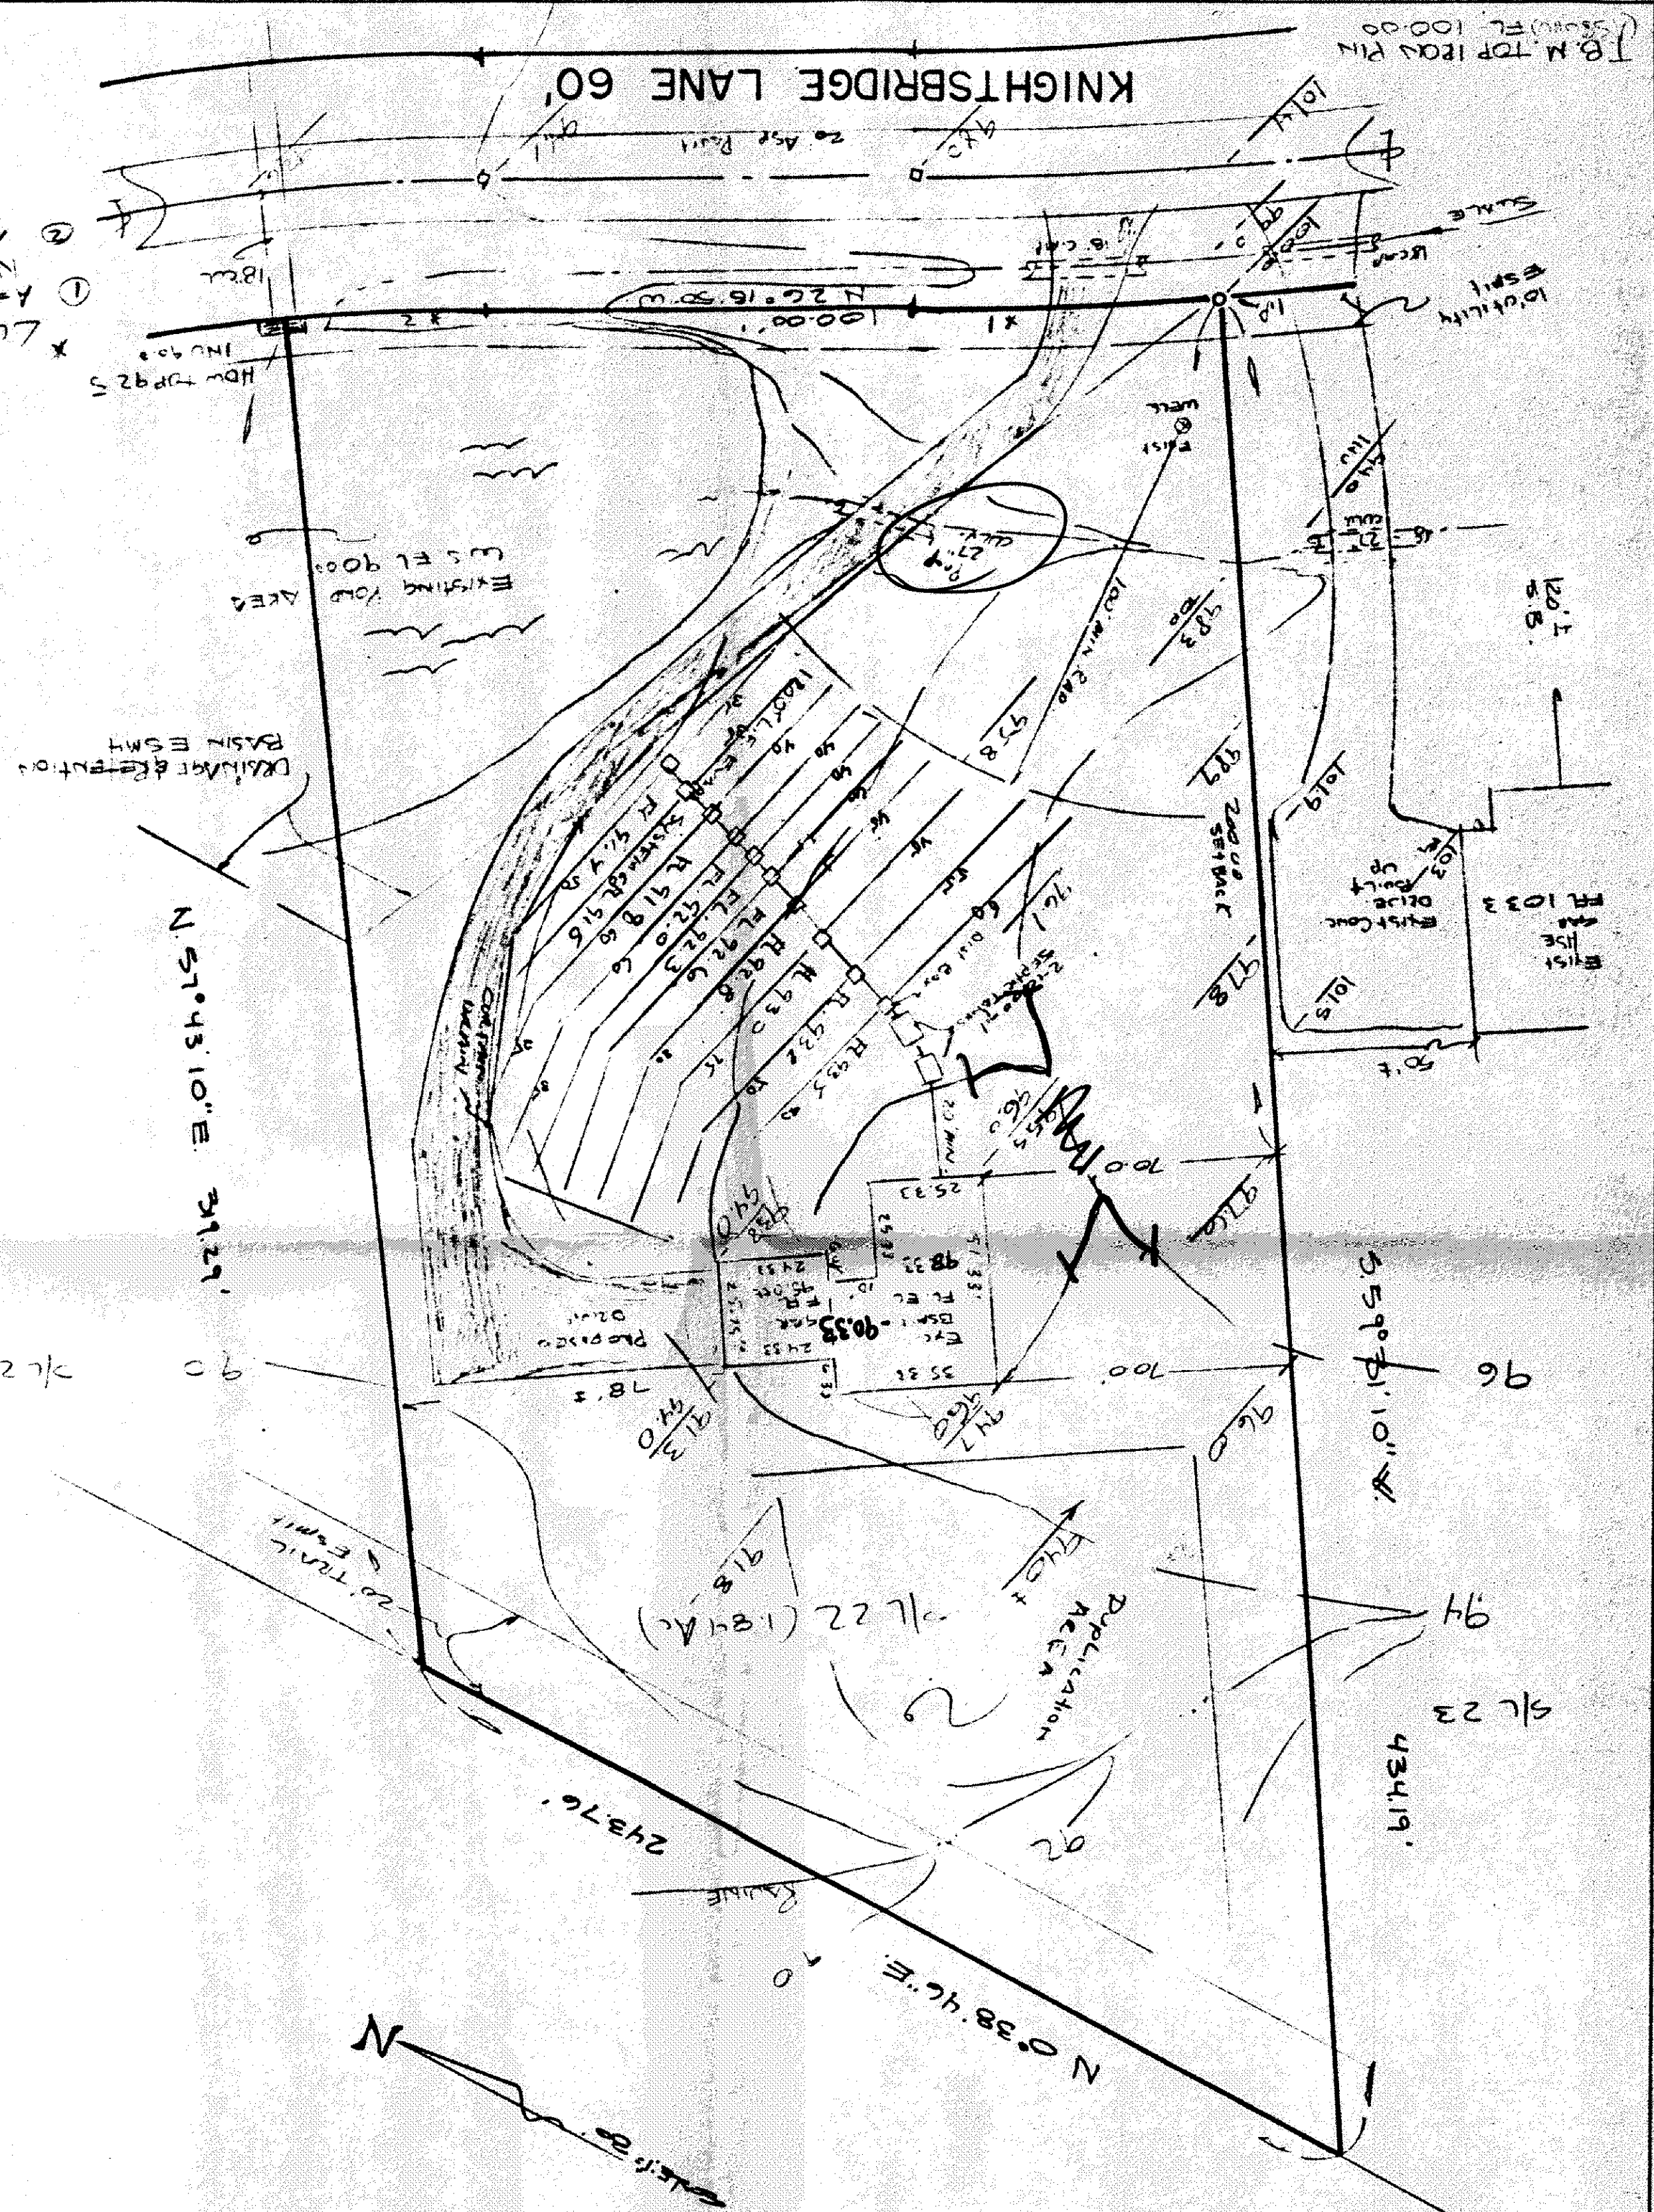
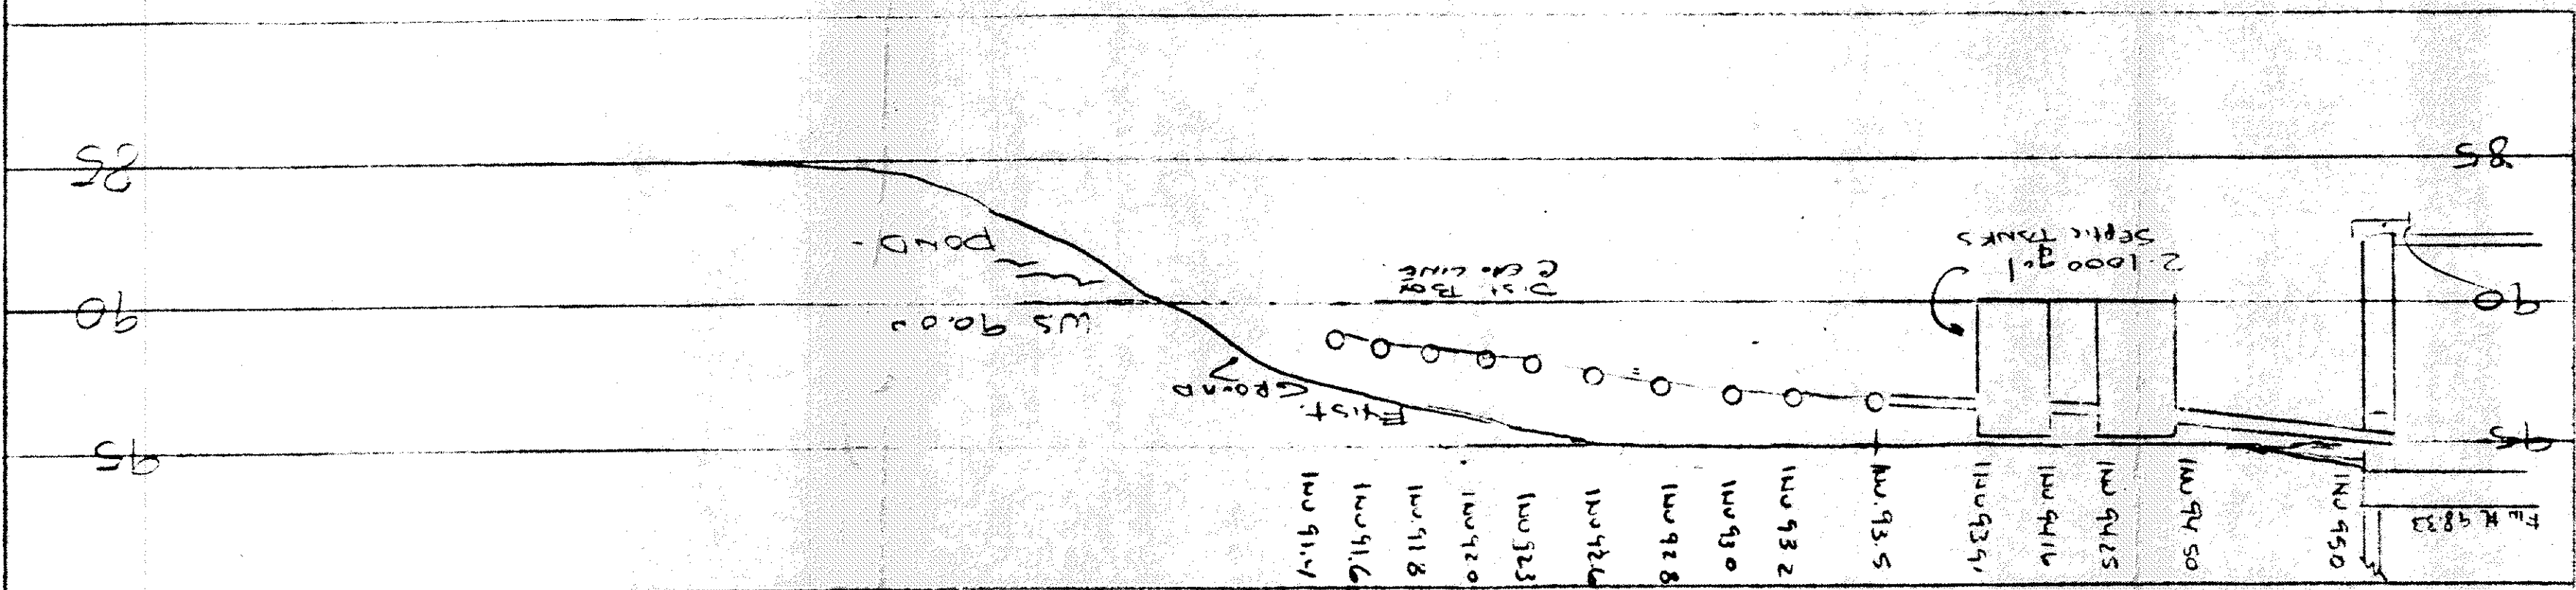


CK, JONES AND ASSOCIATES, INC.
CIVIL ENGINEERS - SURVEYORS - LAND PLANNERS
PAINESVILLE OHIO 44077

SCALES: Horz: 1" = 20'
Vert: 1" = 5'

[illegible]

Grading Plan Approved
as shown and/or noted
THOMAS P. GILES, P.E.
Lake County Engineer
Date 11-16-82

SEWAGE DISPOSAL PERMIT MUST BE
OBTAINED BY A LAKE COUNTY LICENSED
INSTALLER BEFORE INSTALLATION IS
STARTED.

Received and Accepted
 LAKE COUNTY GENERAL HEALTH DISTRICT
 Date Nov 4, 1983
 JOEL LUCIA, R. S. M. P. H.
 Health Commissioner
 BY William B. [Signature]

ISSUED 11-10-82
 ZONING PERMIT # 4563
 SUBJECT TO APPROVAL BY:
 Lake County Sanitary Eng. ☐
 Lake County Eng. Dept. ☒
 Lake County Planning Comm. ☒
 Lake County Bldg. Dept. ☒
 Town of Macleay