

SITE PLAN

for: MARK SMALL
CLIENT

ADDRESS: STREET: CITY:

3.2 KNIGHTSBRIDGE N/P 2
SUBLOT No. SUBDIVISION NAME VOL. PAGE
CONCORD TOWNSHIP 7/68
LOT, TRACT: 100

LAND DESIGN consultants
Civil Engineers and Surveyors
1000 N. 17th St., Suite 100
Concord, N.H. 03301
Tel: 603-271-1111

DESIGN CERTIFICATION
THIS PLAN WAS PREPARED BY ME AND IS CORRECT TO THE BEST OF MY KNOWLEDGE AND BELIEF.

Paul J. B...
DATE: 10/25/89

CHECK LIST
LOT DIMENSIONS & BEARINGS
SUBLOT No. (Parcel No.)
ADJACENT LOT No. (Parcel No.)
BUILDING DIMENSIONS
SETBACKS
DRIVE & DRIVEWAY TYPE, WIDTH, THICKNESS
SEWER & WATER MAINS
SEWER & WATER MAINS SIZE, MATERIAL, LOCATION
SEWER & WATER MAINS ELEV. LOC.
STORM SEWER SIZE, MATERIAL, LOCATION
STORM SEWER ELEV. LOC.
PAVING TYPE, GRADE, CURBS
ONE LINE LOC. SIZE
WELL LOCATION & ISOLATION RADIUS

"AS BUILT" CERTIFICATION
I HEREBY CERTIFY THAT THE CIRCLED INFORMATION IS EXISTING AS OBTAINED ON THE SITE AND IS CORRECT TO THE BEST OF MY KNOWLEDGE AND BELIEF.

NAME: DATE: 10/25/89

LEGEND
STORM MANHOLE
SANITARY MANHOLE
PROPOSED CONTOURS
EXIST. ELEV. 100.0
100.0 PROP. ELEV.
DIRECTION OF SURFACE DRAINAGE




ACCEPTED: CLIENT: DATE:



Reviewed and Accepted
LAKE COUNTY GENERAL HEALTH DISTRICT
10-24-89
JES. LINDA E. S. M. P. A.
Linda E. S. M. P. A.
Linda E. S. M. P. A.

SEWAGE DISPOSAL FRONT MUST BE OBTAINED BY A LAKE-COUNTY LICENSED INSTALLER BEFORE INSTALLATION IS STARTED.

HYDRAULIC PROFILE
SCALES: HORIZONTAL 1" = 30'
VERTICAL 1" = 5'

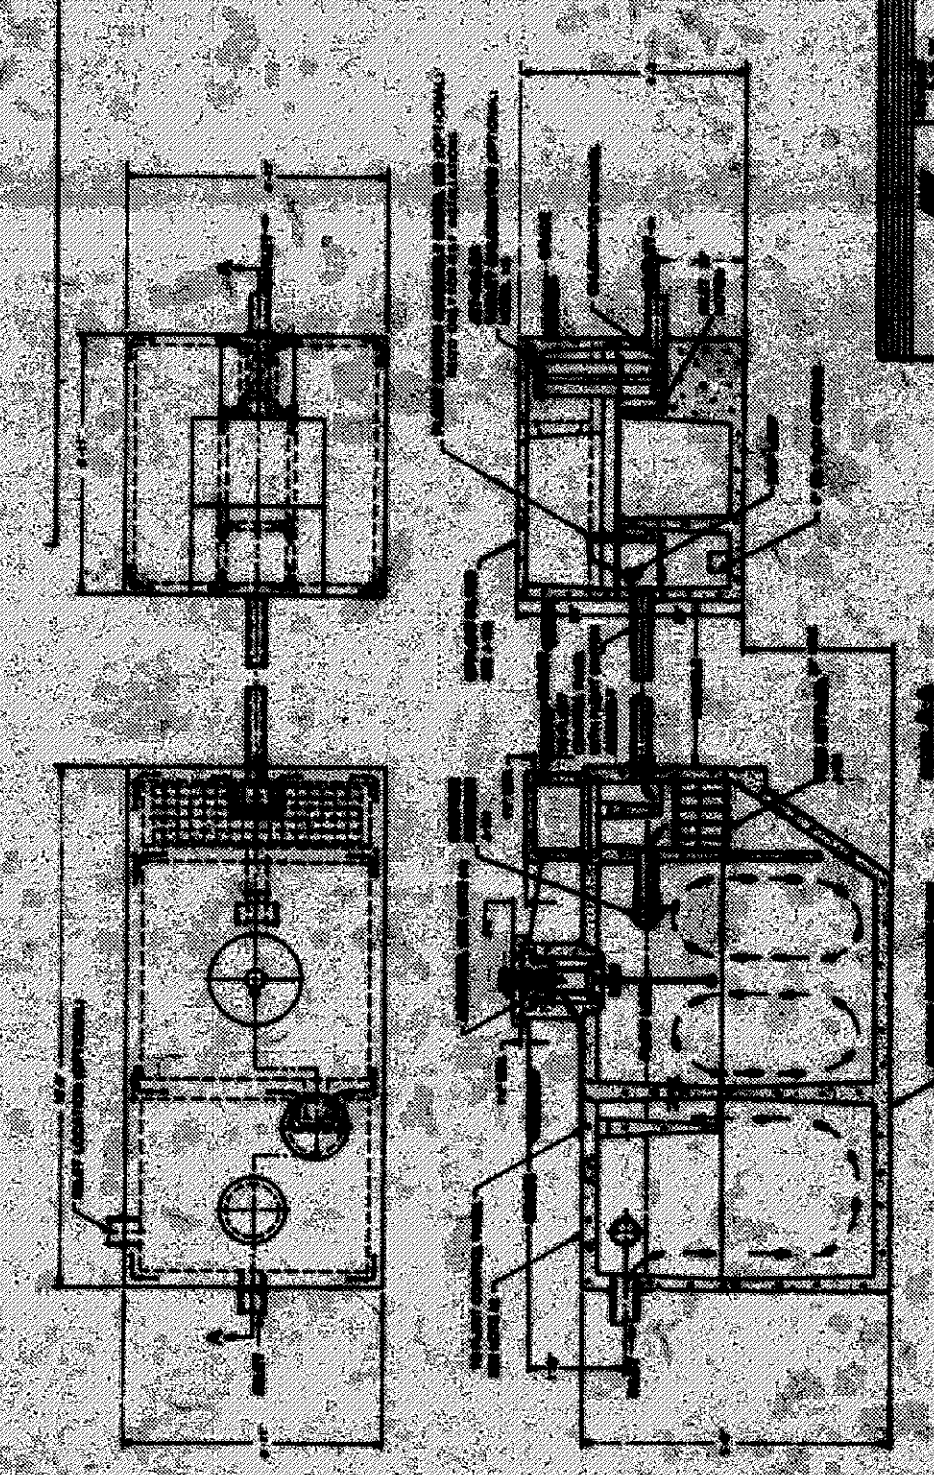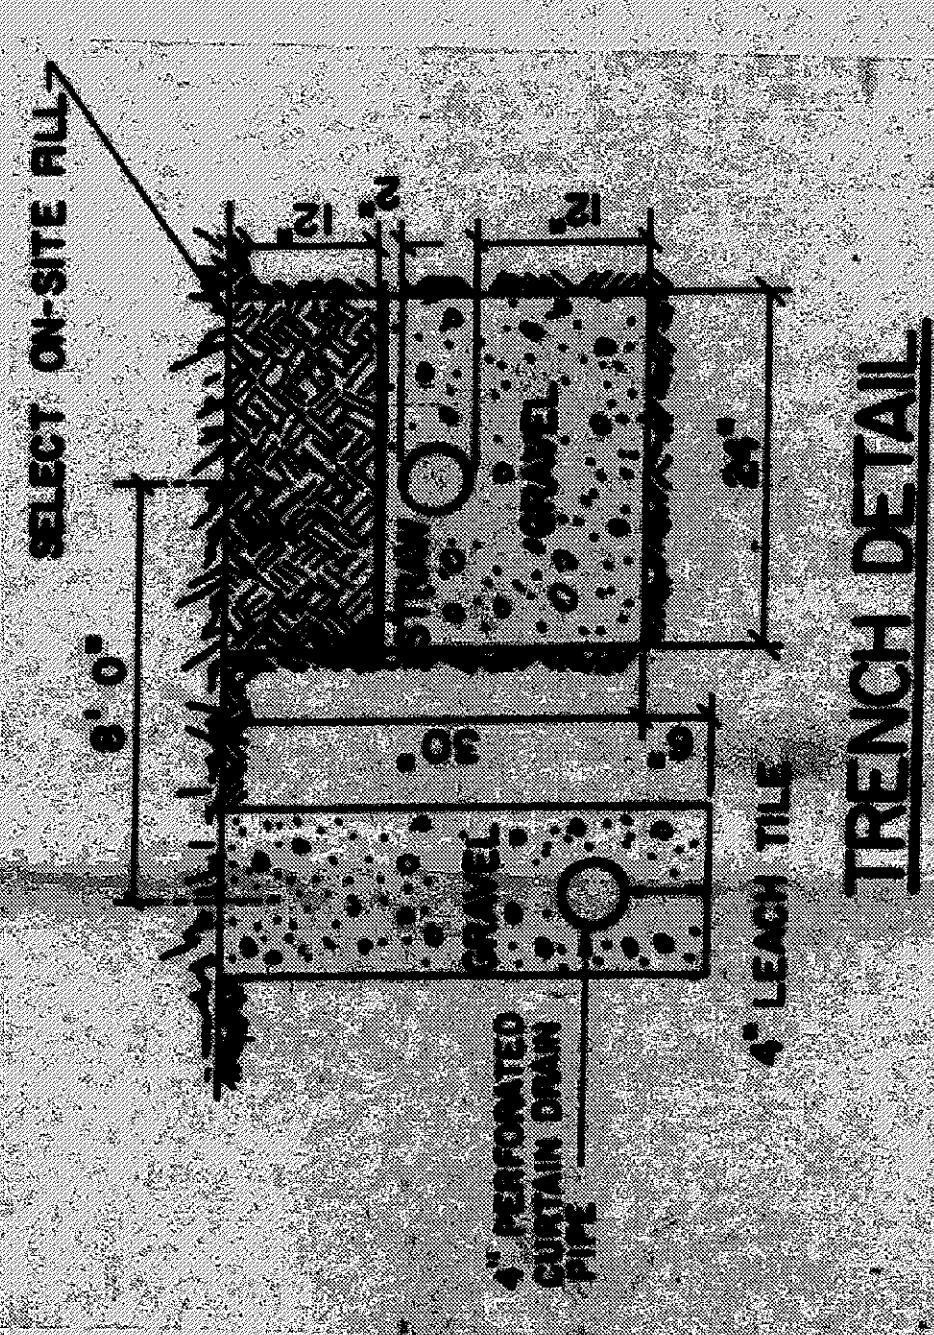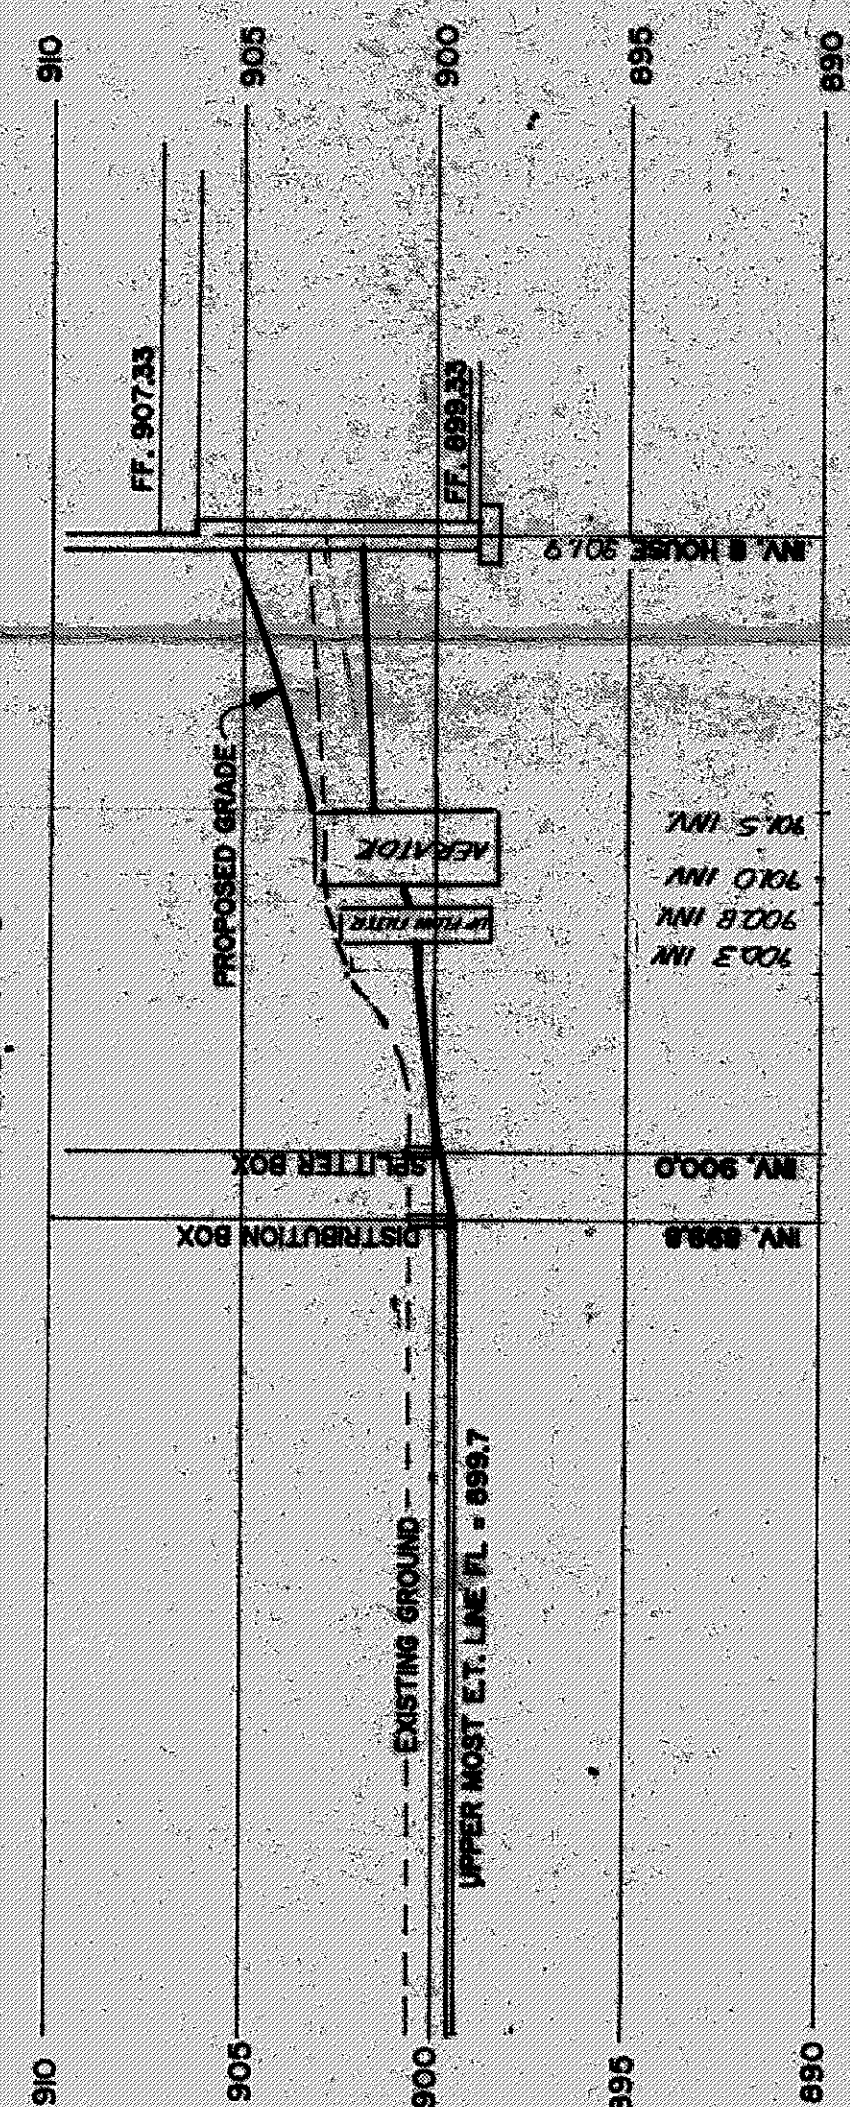

Grading Plan Approved
as shown and/or noted
THOMAS P. GILLES, P.E.
Lake County Engineer
By: Date: 10/26/89

Paul J. B...
Date: 10/26/89