

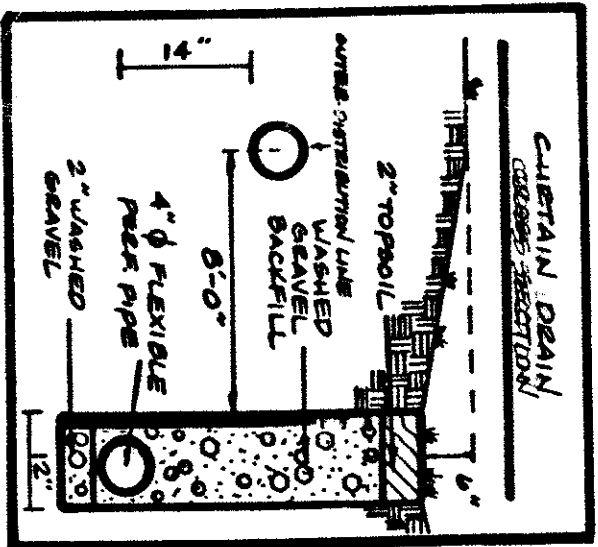
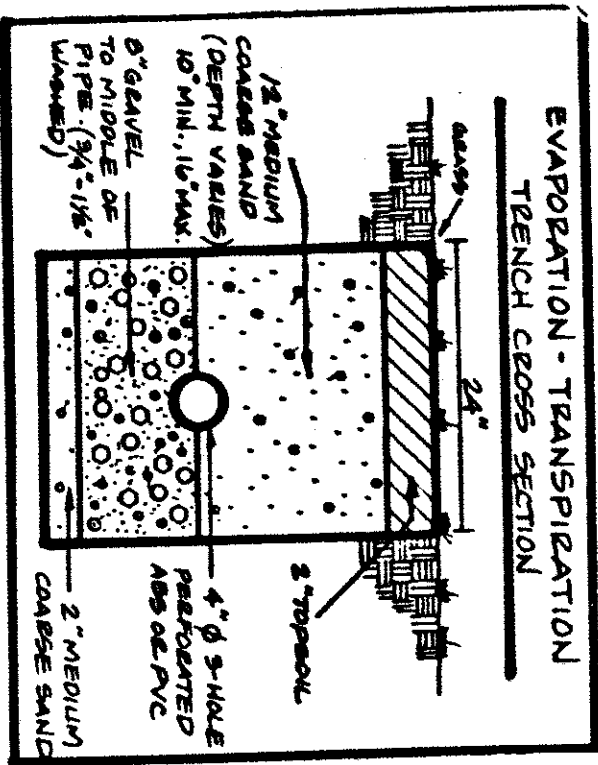
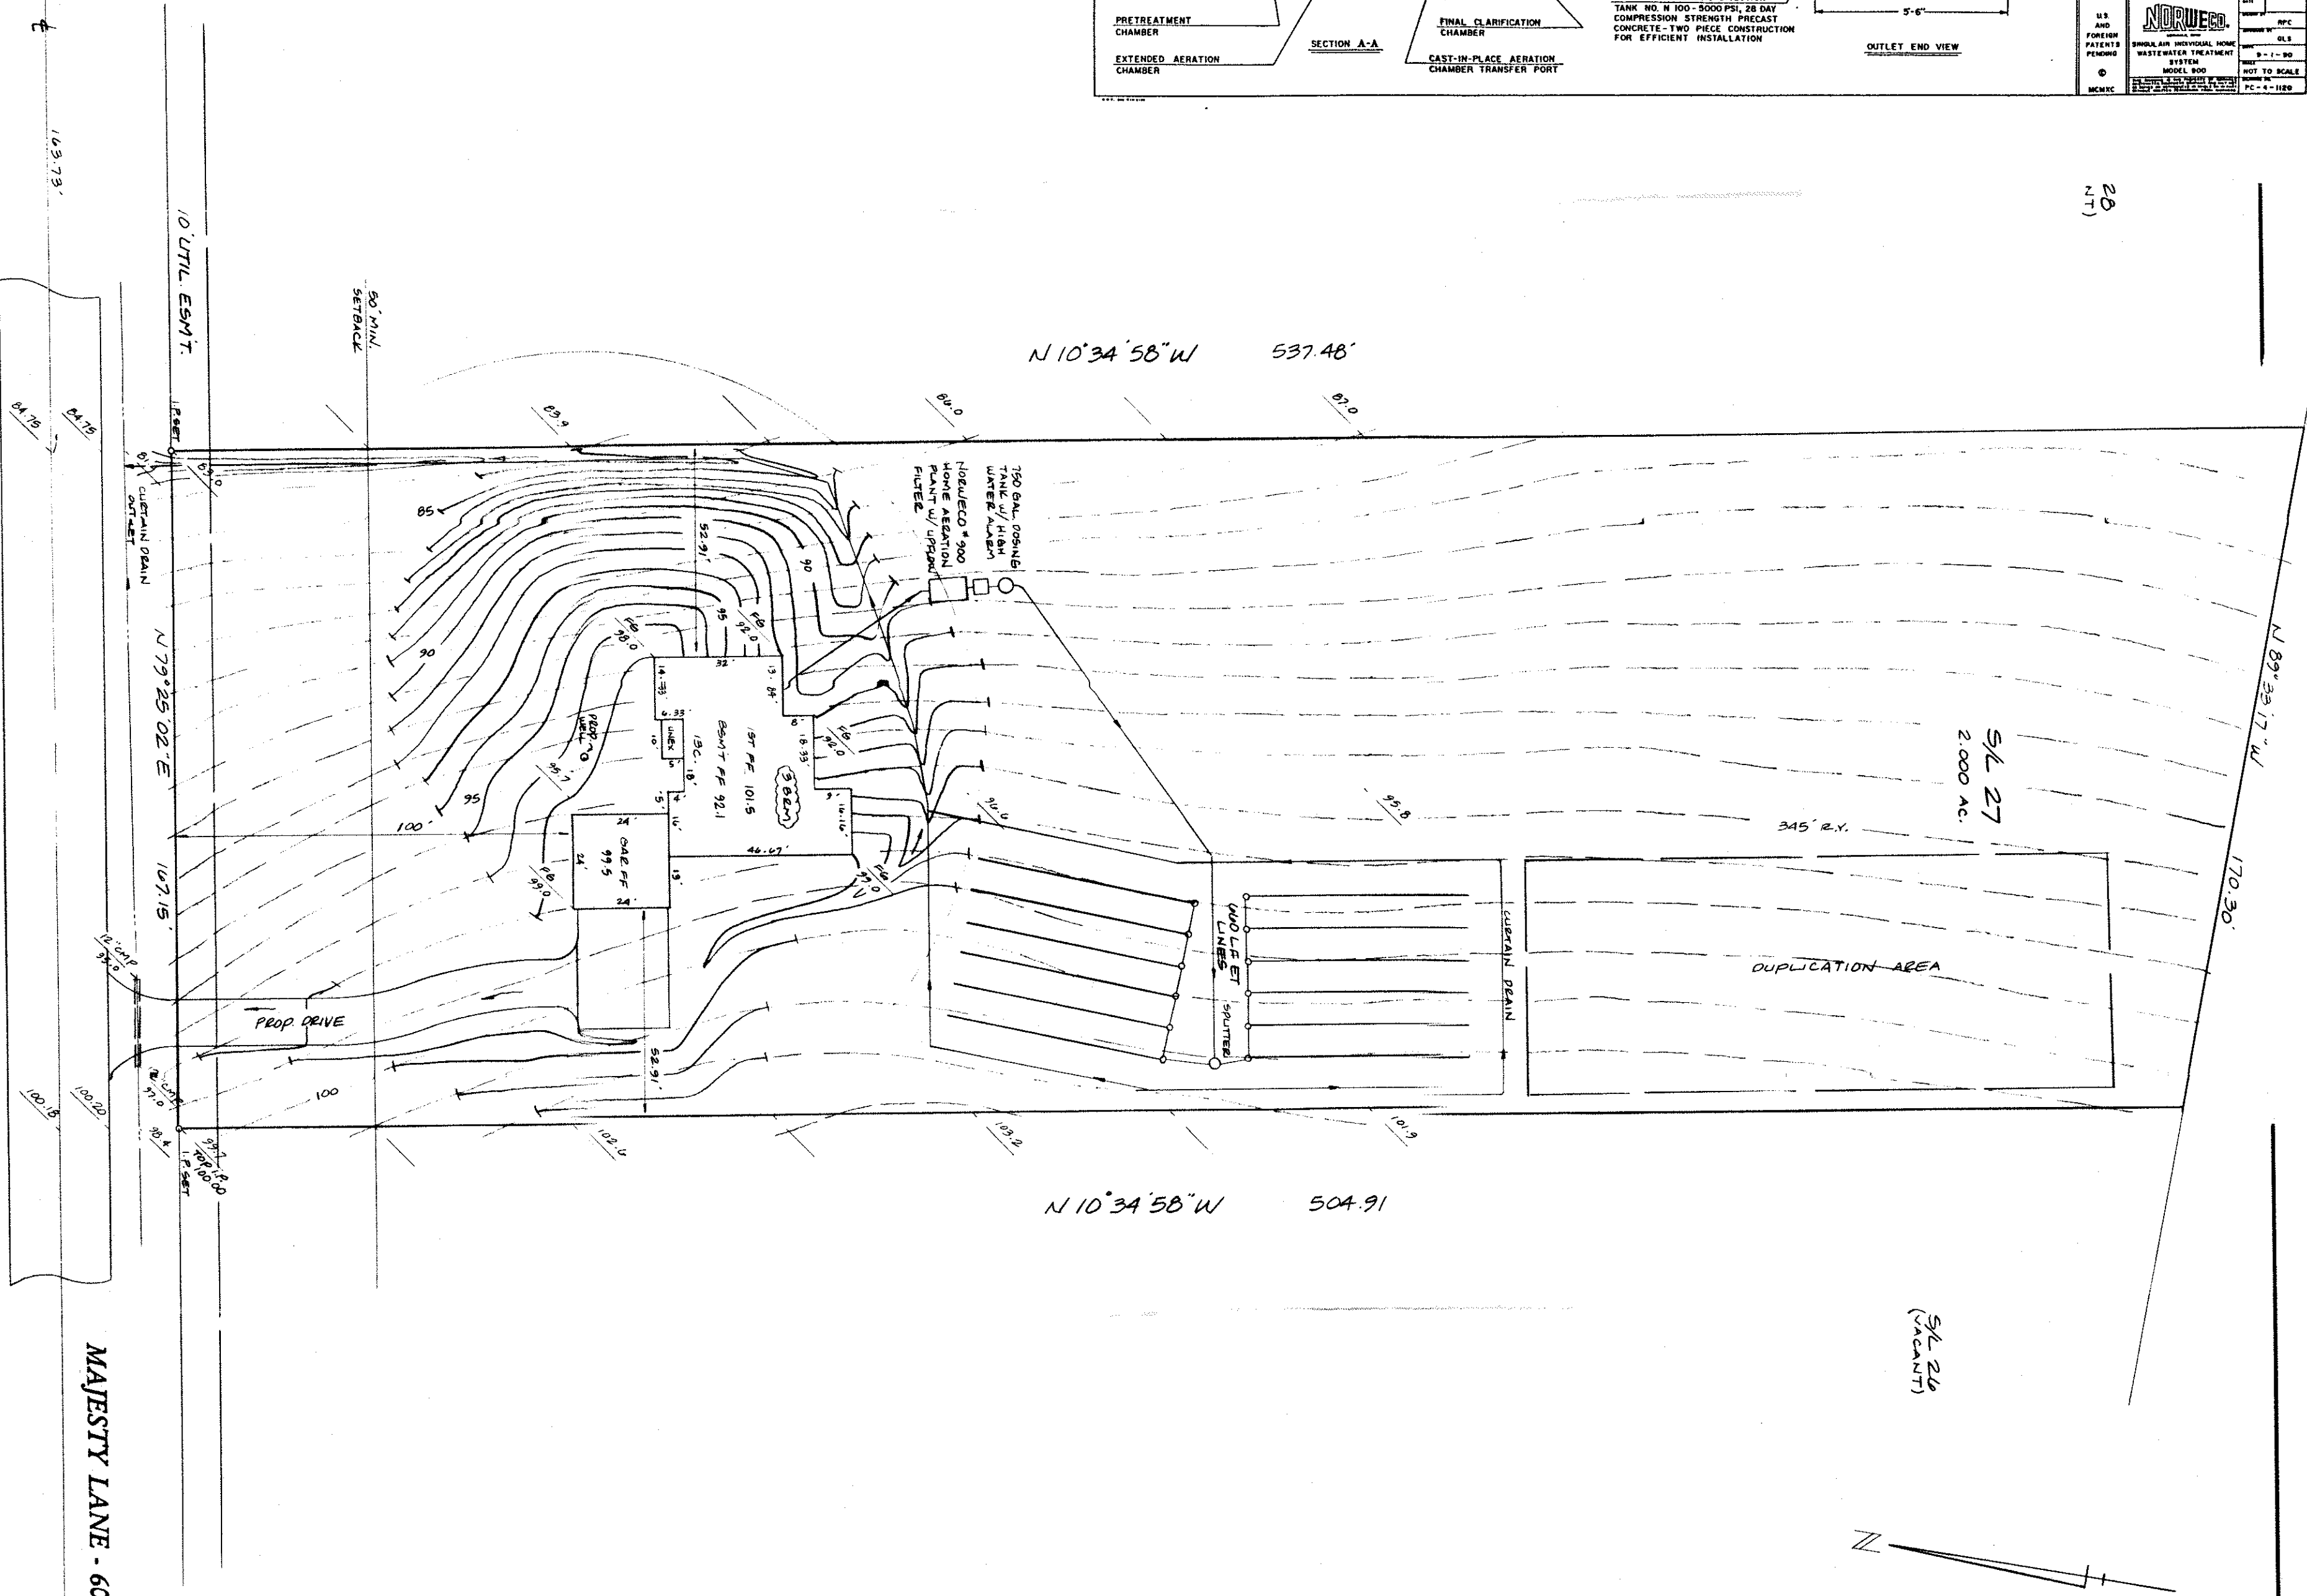


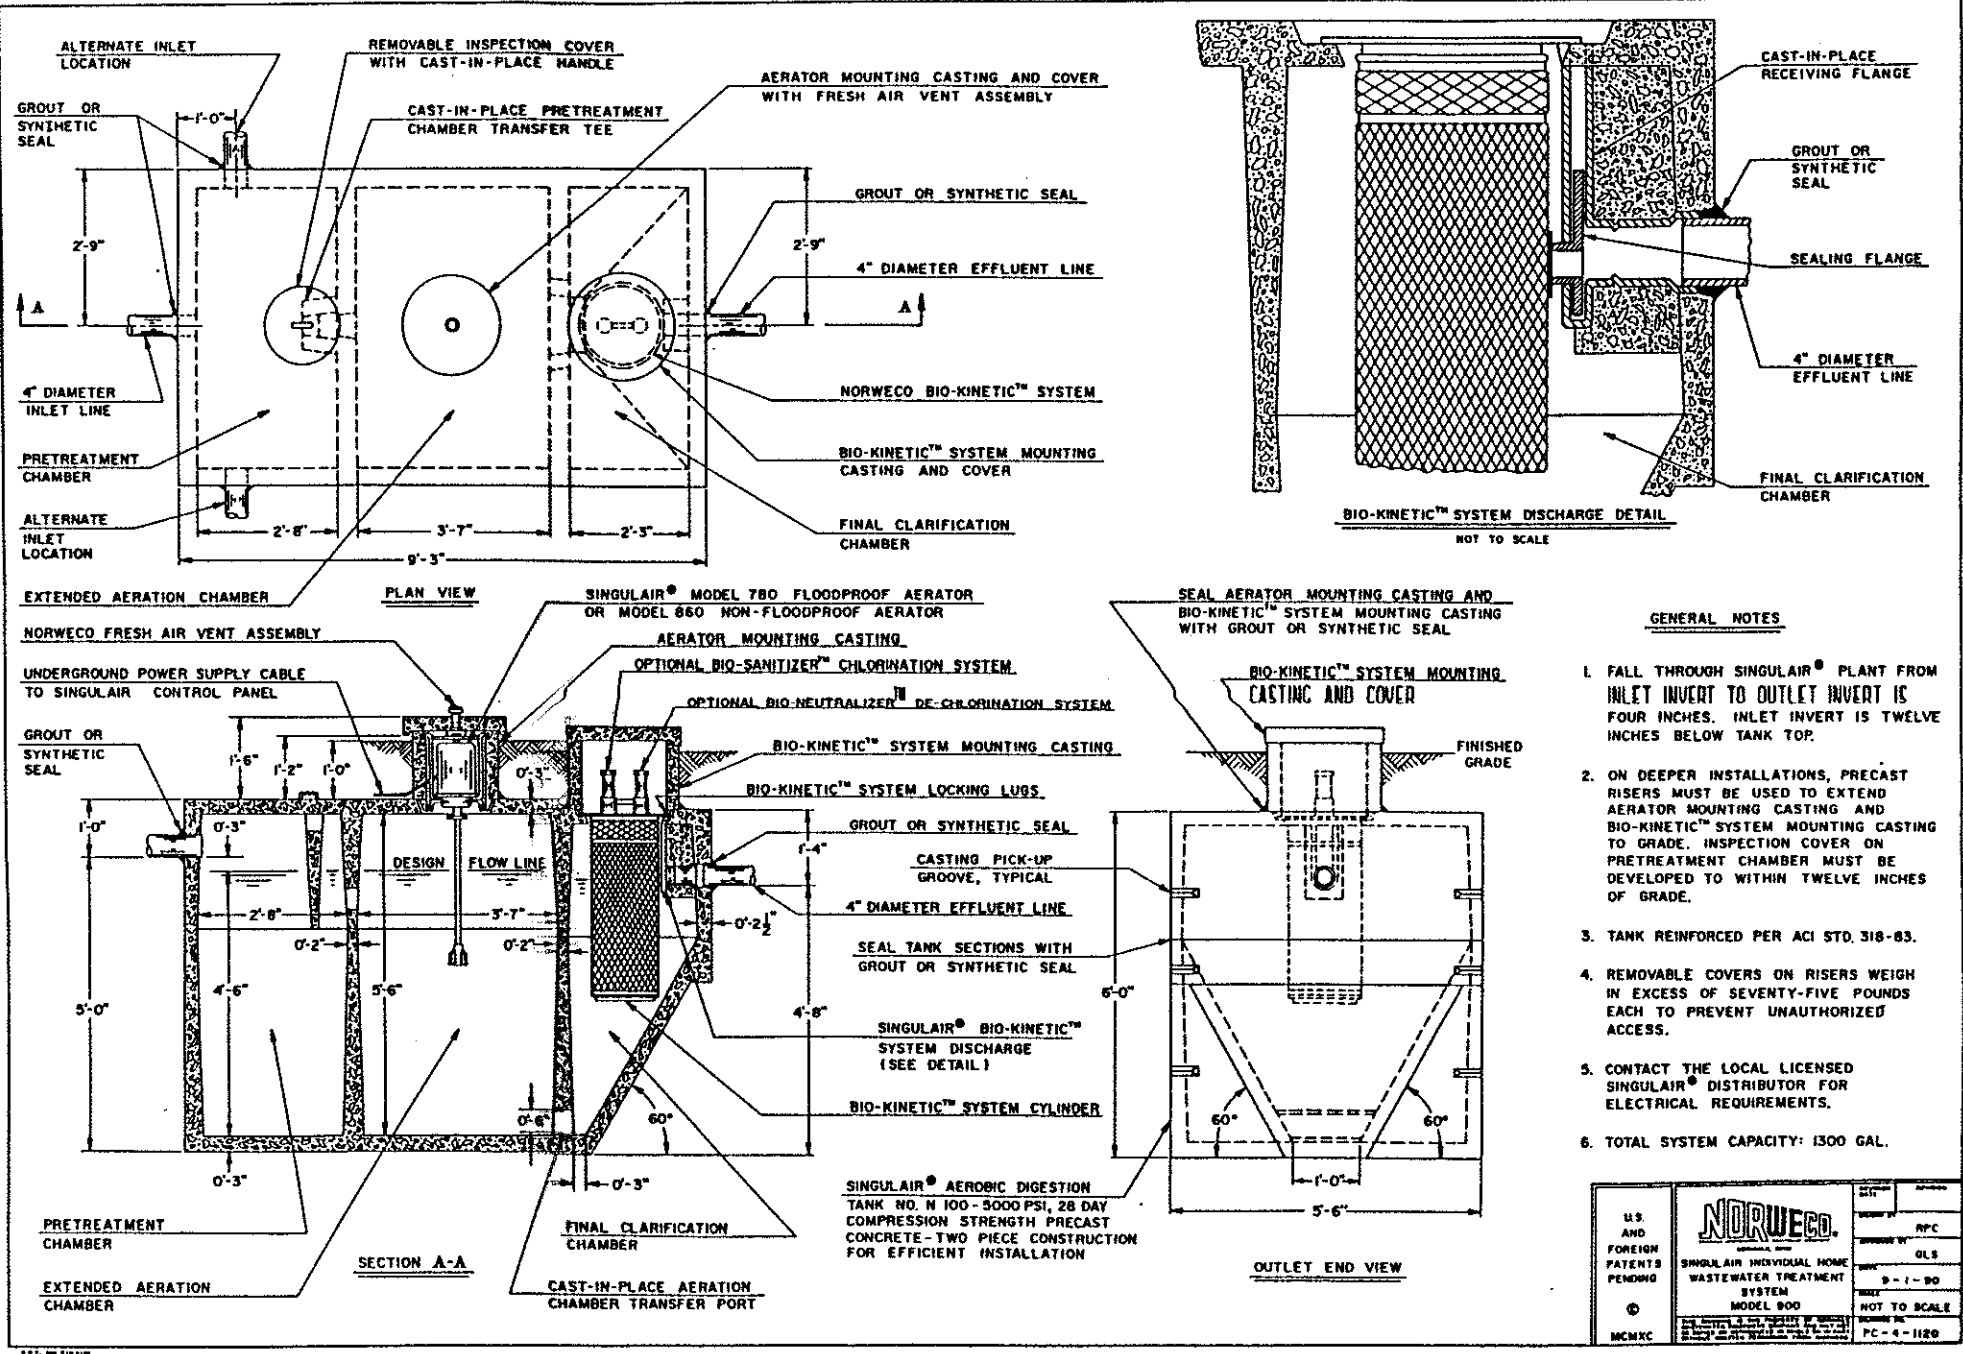

SPACE DISPOSAL PERMIT MUST BE OBTAINED BY A LAKE COUNTY LICENSED INSTALLER BEFORE INSTALLATION IS STARTED.

- A. To be brought to finished grade
1. Septic tank manhole covers
 2. Splitter box cover
 3. Distribution box cover
- B. No other drains or downspouts to be discharged into septic tanks
- C. All waste water to be discharged into septic tanks

Reviewed and Accepted
LAKE COUNTY GENERAL HEALTH DISTRICT
Date: 2-28-94
JOEL LUNA, R. E., M. E., M. H.
Health Commissioner
BY: [Signature]

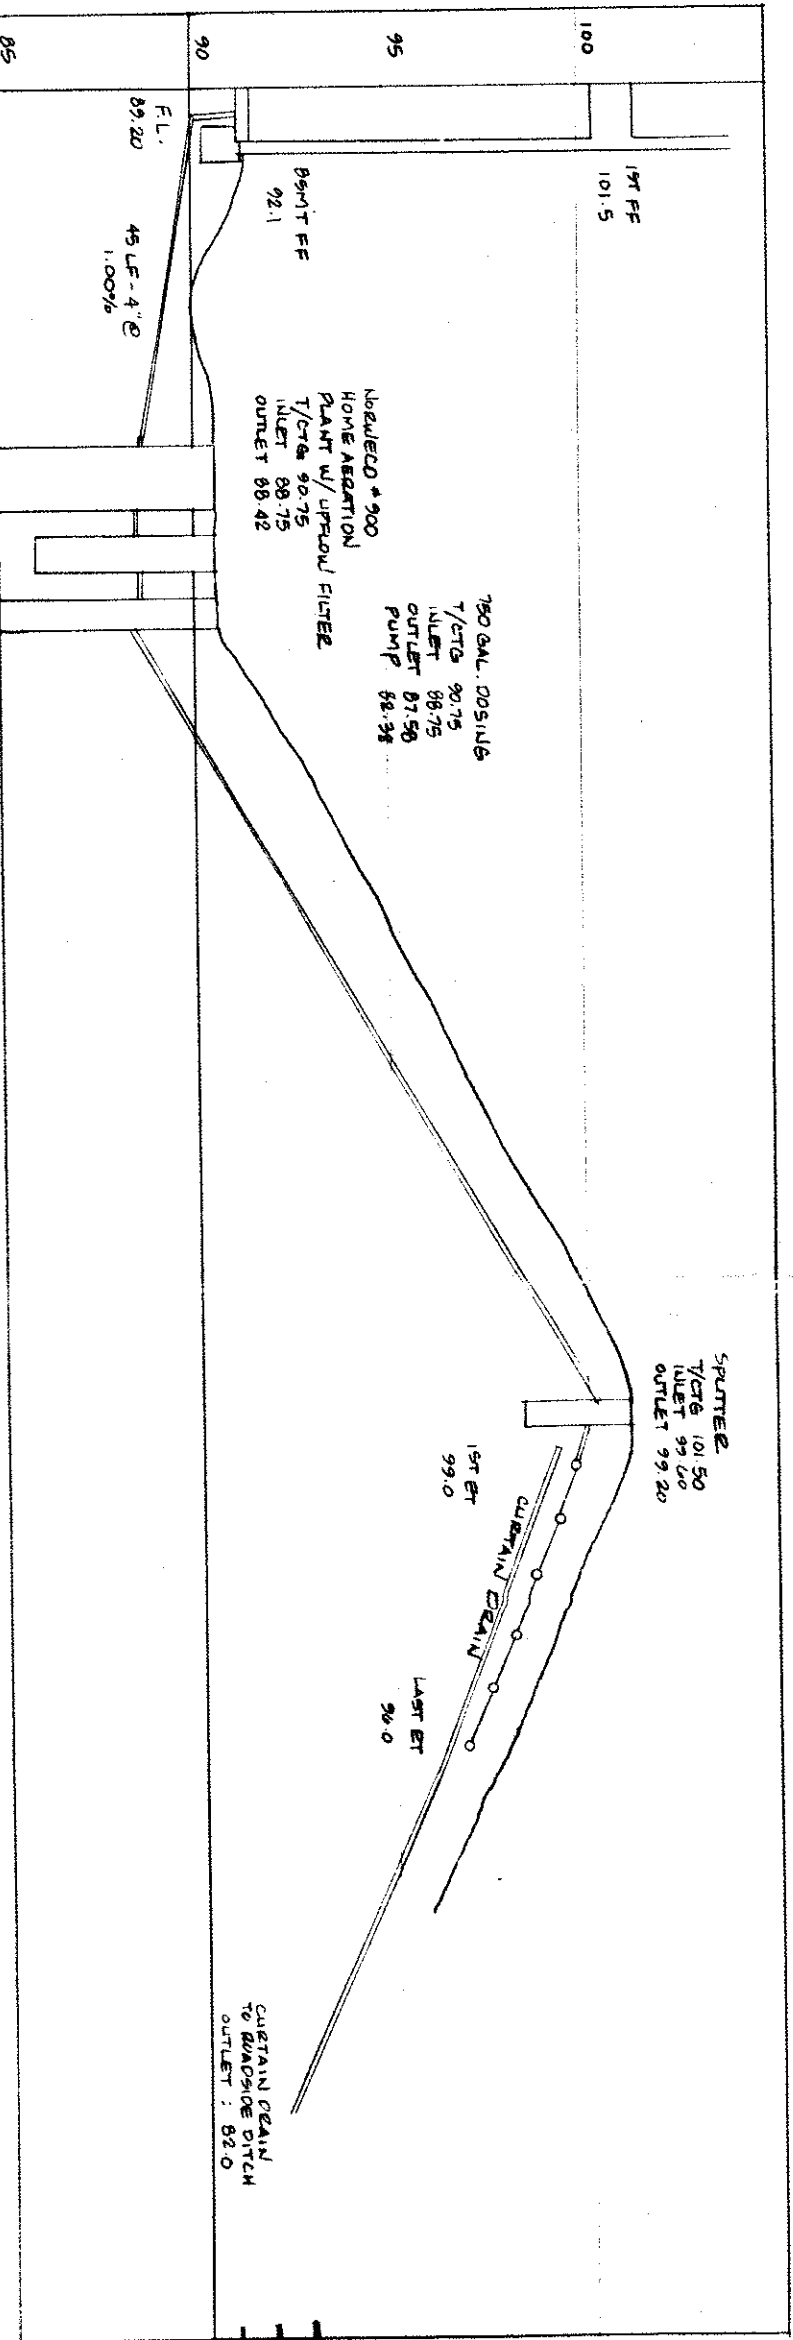

HYDRAULIC PROFILE
SCALE: HORIZ. 1" = 30', VERT. 1" = 5'


ISSUED _____
SUBJECT TO APPROVAL BY:
☐ Lake County Sanitary Eng.
☐ Lake County Eng. Dept.
☐ Lake County Planning Comm.
☐ Lake County Bldg. Dept.

APPROVED AS NOTED
SUBJECT TO LAKE COUNTY HEALTH DEPARTMENT REVIEW.
[Signature]
JOSEPH G. GOSSET, P.E.

"I, the undersigned hereby certify that the topography indicated by 6", 1" or 2" contours, and elevations shown hereon are a true and correct copy of the original field survey made by me on the 31st day of March, 1994, and that the elevations were taken at the intervals as indicated hereon."

[Signature]
J. No. 6343

Grading Firm Approved as shown and/or as shown on drawing
THOMAS P. GILLES, P.E.
Lake County Engineer
614
Date: 4-19-94

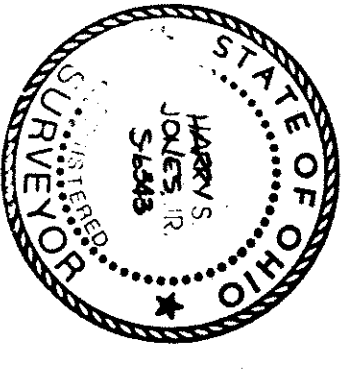

REV. NO.	DESCRIPTION	DATE	BY	C.H.D.

SITE PLAN FOR J.W. BETTELEY BLDG.

BABCOCK, JONES AND ASSOCIATES, INC.
CIVIL ENGINEERS - SURVEYORS - LAND PLANNERS
PAINESVILLE OHIO 44077

S/L 27 MOUNT ROYAL SUBDIVISION
CONCORD TOWNSHIP LAKE COUNTY OHIO

SCALE	DATE
1" = 30'	2-23-94
SHEET	1