
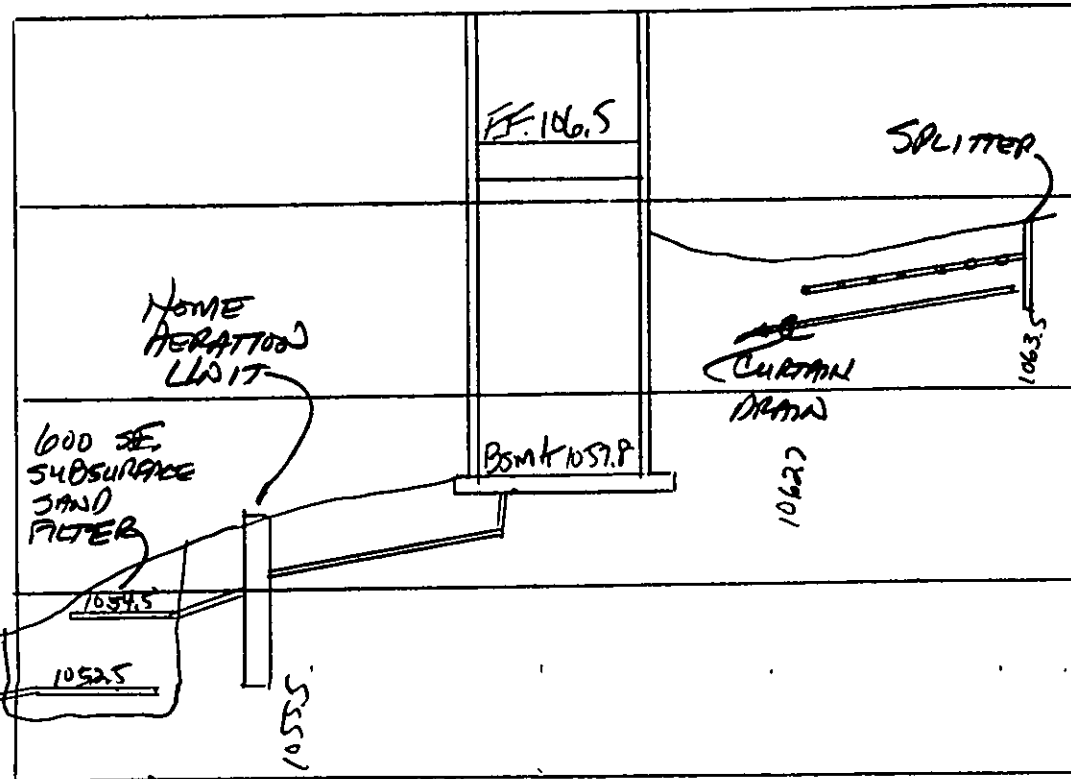
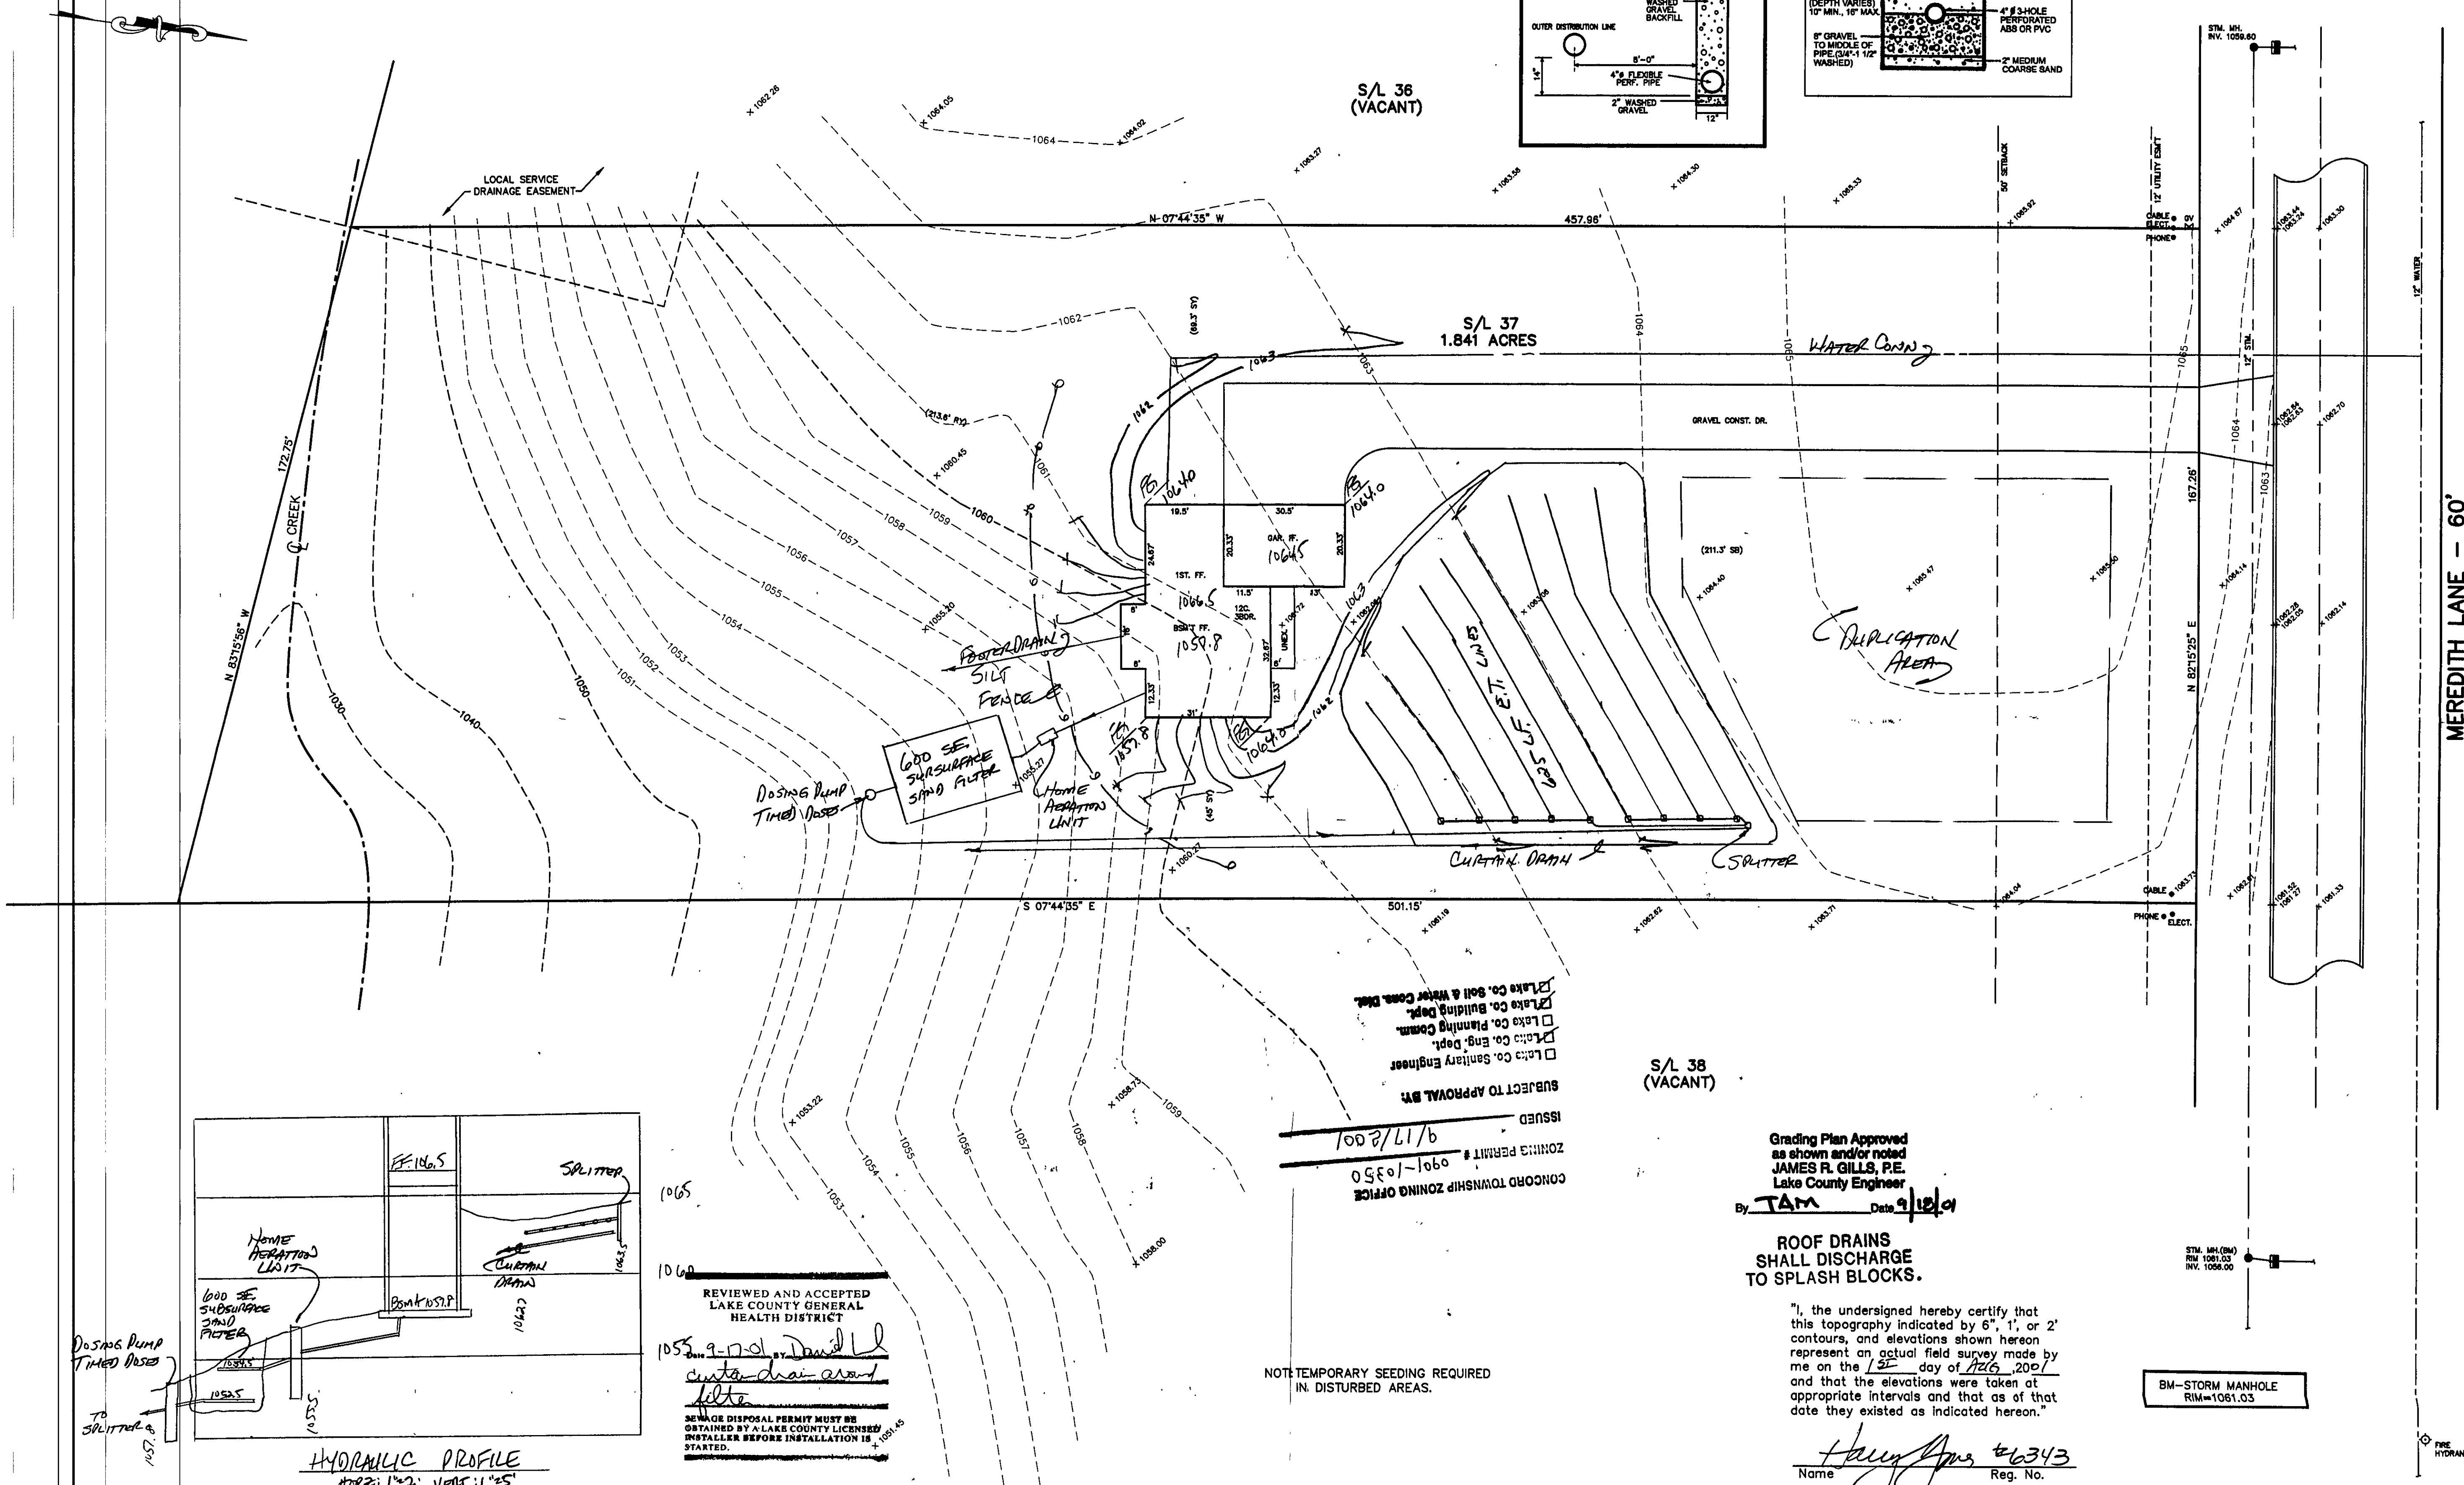
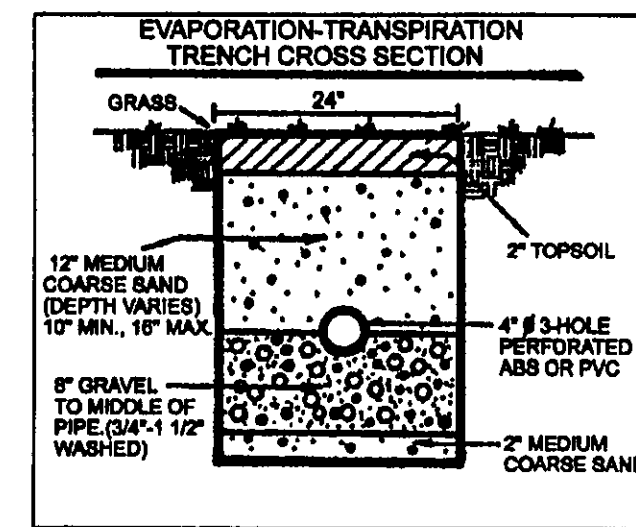


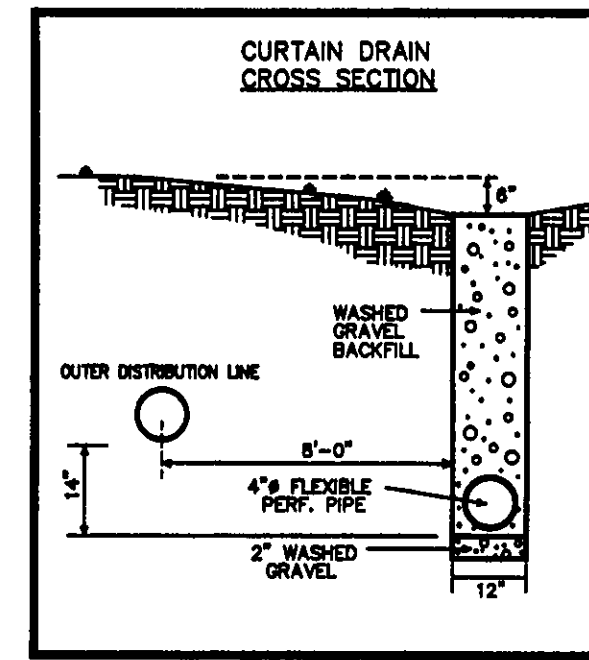

REVIEWED AND ACCEPTED
LAKE COUNTY GENERAL
HEALTH DISTRICT

1055-9-17-01 BY *David L. L.*
curtain drain around
filter

SEWAGE DISPOSAL PERMIT MUST BE
OBTAINED BY A LAKE COUNTY LICENSED
INSTALLER BEFORE INSTALLATION IS
STARTED.

LAKE CO. SOIL & WATER CONSERV. DIST.
LAKE CO. BUILDING DEPT.
LAKE CO. PLANNING COMM.
LAKE CO. ENG. DEPT.
LAKE CO. SANITARY ENGINEER

SUBJECT TO APPROVAL BY

ISSUED
9/17/2001

ZONING PERMIT # 0901-10350

CONCORD TOWNSHIP ZONING OFFICE

Grading Plan Approved
as shown and/or noted
JAMES R. GILLS, P.E.
Lake County Engineer

By *TAM* Date *9/12/01*

ROOF DRAINS
SHALL DISCHARGE
TO SPLASH BLOCKS.

"I, the undersigned hereby certify that
this topography indicated by 6", 1", or 2"
contours, and elevations shown hereon
represent an actual field survey made by
me on the *15th* day of *Aug.* 2001
and that the elevations were taken at
appropriate intervals and that as of that
date they existed as indicated hereon."

Harry Jones #6343
Name Reg. No.


BM-STORM MANHOLE
RIM=1061.03

REV NO.	DESCRIPTION	DATE	BY	CHK'D
1	CHANGED HOUSE LOCATION	8/20/01	H.J.	H.J.
2	CHANGED HOUSE LOCATION	8/21/01	H.J.	H.J.

BABCOCK, JONES AND ASSOCIATES, INC
CIVIL ENGINEERS - SURVEYORS - LAND PLANNERS
PAINESVILLE OHIO 44077

DATE 8/1/01
DESIGN BY H.J.
DRAWN BY T.R.
APPROVED BY H.J.

SITE PLAN
FOR
SHAMROCK CONSTRUCTION
S/L 37 STANFORD SPRINGS SUBDIVISION
CONCORD TOWNSHIP LAKE COUNTY

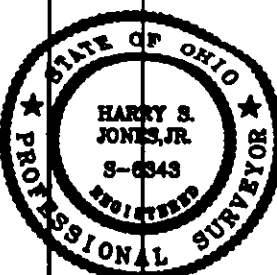

SCALE 1"=20'
JOB NO 98-185-37
SHEET 1 OF 1