
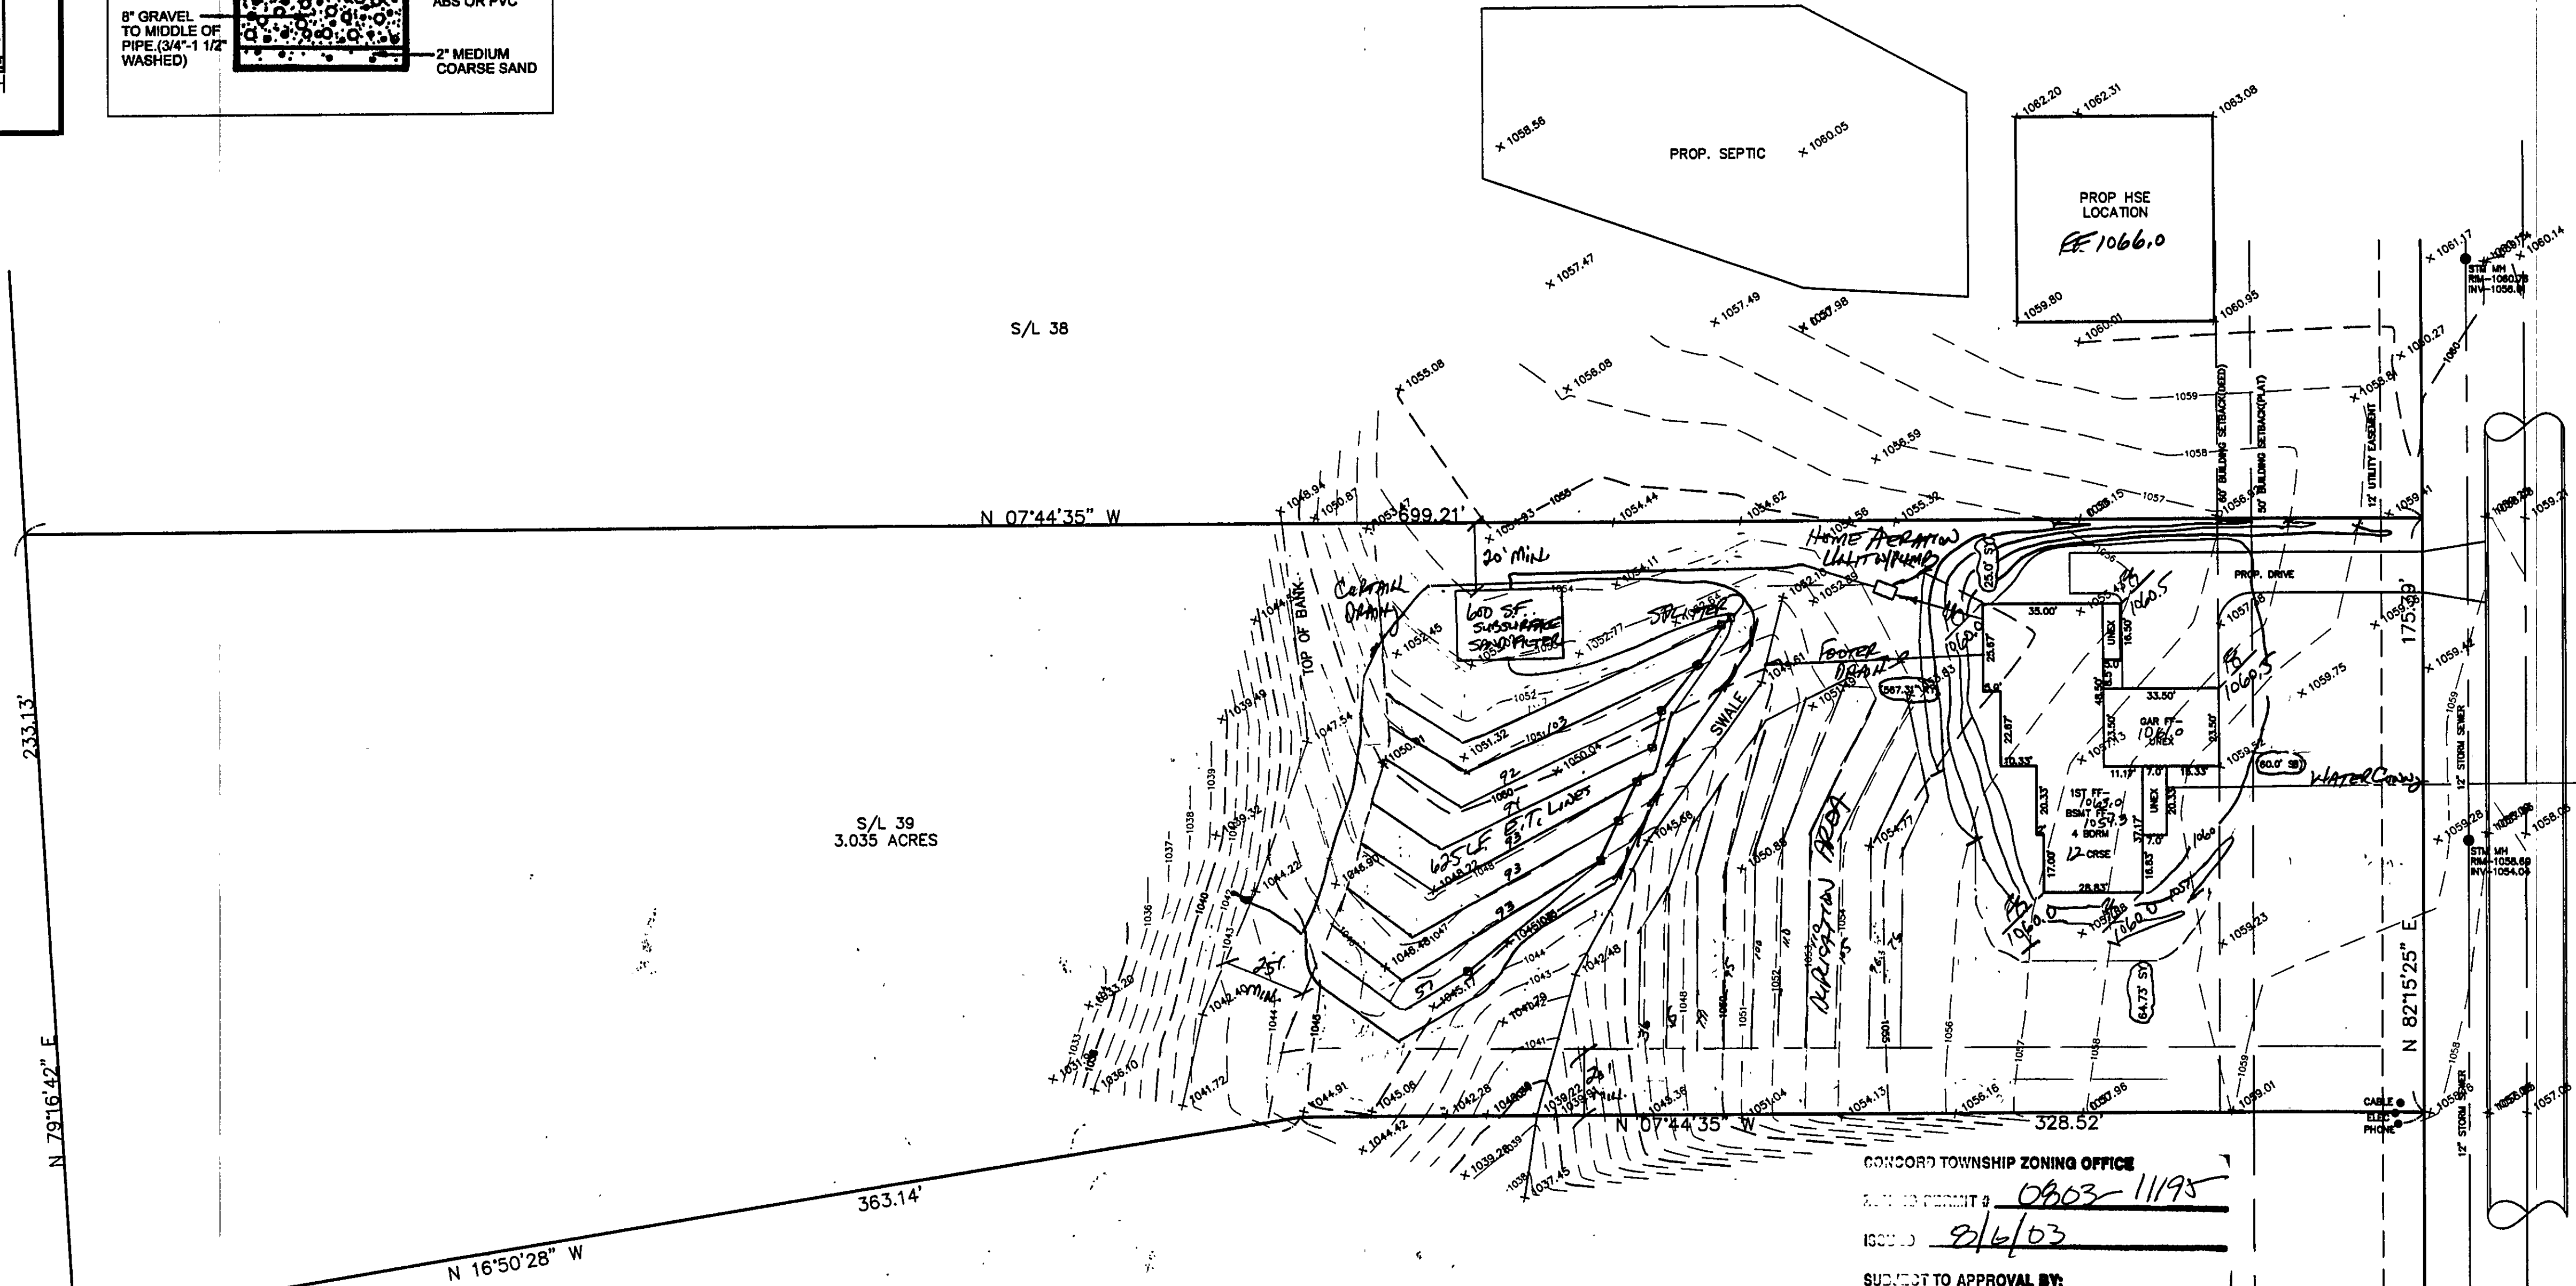
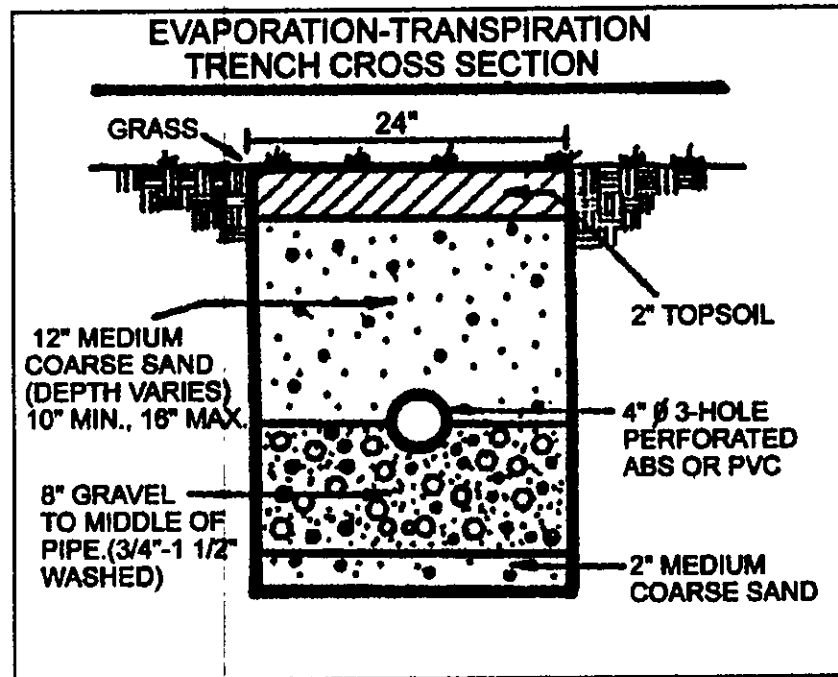


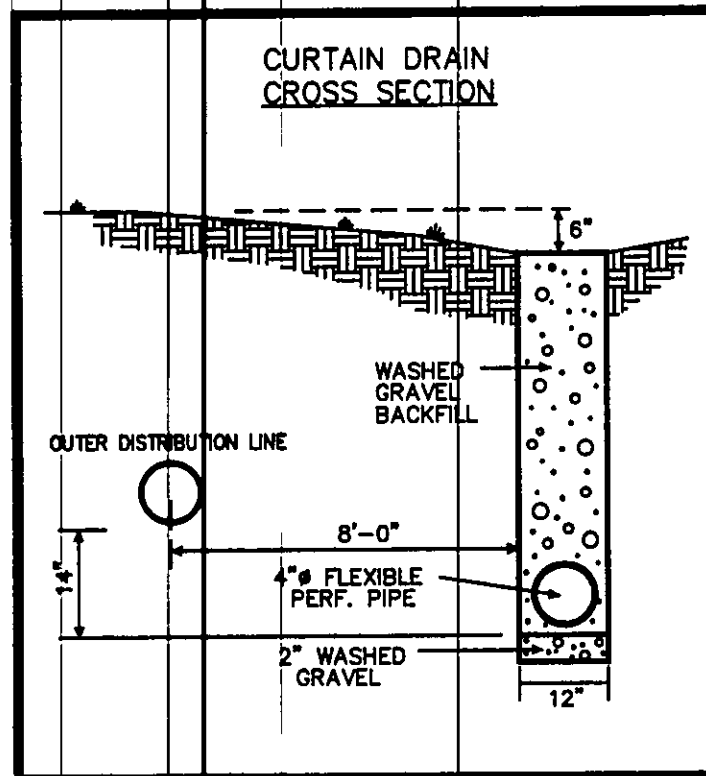


REVIEWED AND ACCEPTED
LAKE COUNTY GENERAL
HEALTH DISTRICT

Date: 8-4-03 BY: DAL

SEWAGE DISPOSAL PERMIT MUST BE
OBTAINED BY A LAKE COUNTY LICENSED
INSTALLER BEFORE INSTALLATION IS
STARTED

S/L 40
(VACANT)

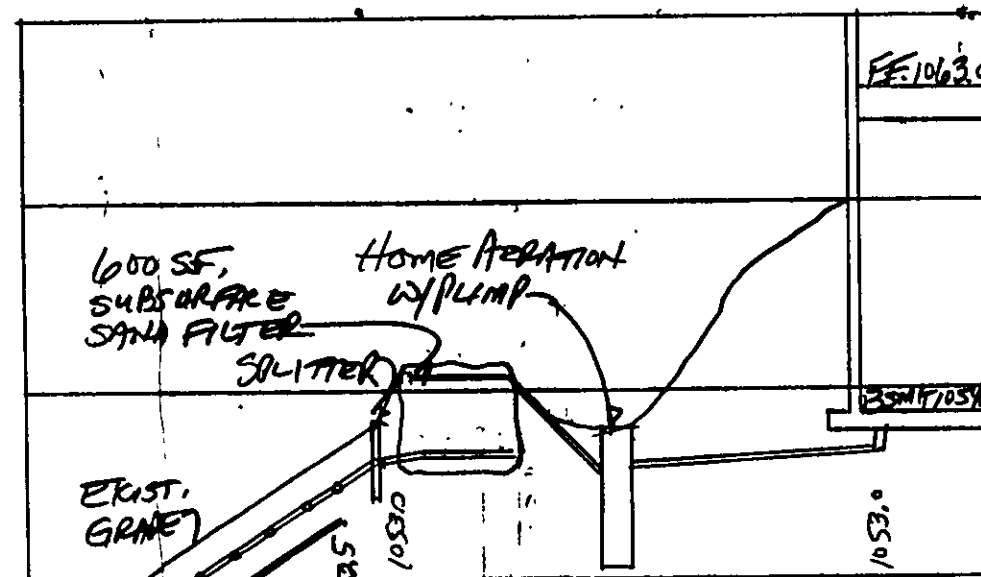

CONCORD TOWNSHIP ZONING OFFICE

APPROVED PERMIT # 0803-11195

ISSUED 8/6/03

SUBJECT TO APPROVAL BY:

- ☒ Lake Co. Health Engineer
- ☒ Lake Co. Eng. Dept.
- ☒ Lake Co. Planning Comm.
- ☒ Lake Co. Building Dept.
- ☒ Lake Co. Soil & Water Cons. Dist.

"I, the undersigned hereby certify that
this topography indicated by 6", 1", or 2"
contours, and elevations shown hereon
represent an actual field survey made by
me on the 14th day of JULY, 2003
and that the elevations were taken at
appropriate intervals and that as of that
date they existed as indicated hereon."

Name: Tracy Jones #6343
Reg. No.

MEREDITH LANE - 60'

8-4-03 Date
6114
By: James R. Gilles, P.E.
Lake County Engineer

TBM TOP OF HYDRANT
ELEV-1062.62

EXISTING UTILITIES NOTE:
THE SIZE AND LOCATION, BOTH HORIZONTAL AND VERTICAL
OF THE UNDERGROUND UTILITIES SHOWN HEREON, HAVE BEEN
OBTAINED BY A SEARCH OF AVAILABLE RECORDS.
VERIFICATION BY FIELD OBSERVATION HAS BEEN CONDUCTED
WHERE PRACTICAL, HOWEVER, BABCOCK, JONES AND ASSOCIATES
INC. DOES NOT GUARANTEE THE COMPLETENESS NOR ACCURACY
THEREOF.



REV. NO.	DESCRIPTION	DATE	BY	CHK'D
1	Revised Septic	8-4-03	HJD	KAT



BABCOCK, JONES AND ASSOCIATES, INC
CIVIL ENGINEERS - SURVEYORS - LAND PLANNERS
PAINESVILLE OHIO 44077

DATE	7/22/03
DESIGN BY	HJ
DRAWN BY	NS
APPROVED BY	HJ

SITE PLAN FOR SHAMROCK CONSTRUCTION		SCALE 1"=30'
S/L 39 MADISON TOWNSHIP	STANFORD SPRINGS LAKE COUNTY	98-185-39 SHEET 1 OF 1