



CONSTRUCTION ENTRANCE DETAIL

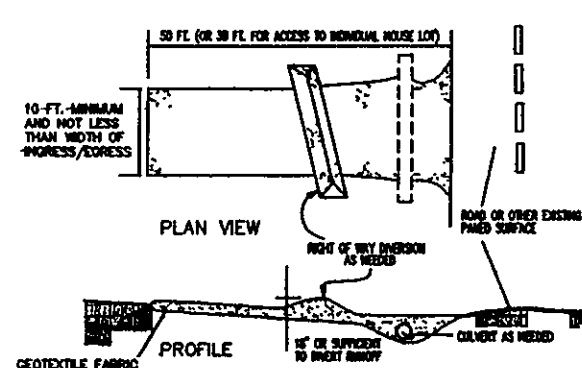



SILT FENCE DETAIL

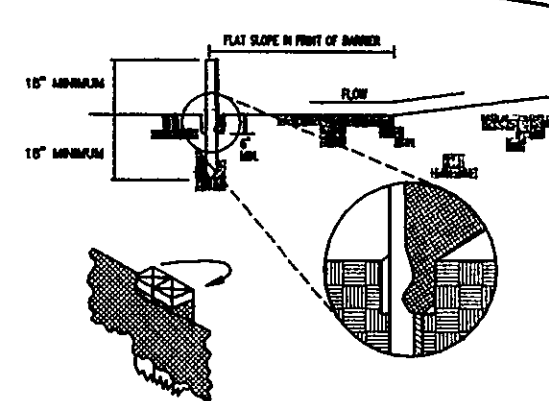


TEMPORARY SEEDING SPECIFICATIONS

SEEDING DATES	SPECIES	LB./1,000 FT ²	PER ACRE
MARCH 1 TO AUGUST 15	DAVE	3	1 BUNNEL
	TALL FESCUE	1	40 LB.
	ANNUAL FESCUE	1	40 LB.
	PERennial FESCUE	1	40 LB.
	TALL FESCUE	1	40 LB.
	ANNUAL FESCUE	1	40 LB.
	PERennial FESCUE	1	40 LB.
AUGUST 16 TO NOVEMBER 1	RYE	3	1 BUNNEL
	TALL FESCUE	1	40 LB.
	ANNUAL FESCUE	1	40 LB.
	PERennial FESCUE	1	40 LB.
	TALL FESCUE	1	40 LB.
	ANNUAL FESCUE	1	40 LB.
	PERennial FESCUE	1	40 LB.
NOVEMBER 1 TO SPRING SEEDING	USE MULCH ONLY, SEEDING PRACTICES OR DRUMM SEEDING.		


NOTE: ORDER APPROVED SEED SPECIES MAY BE SUBSTITUTED

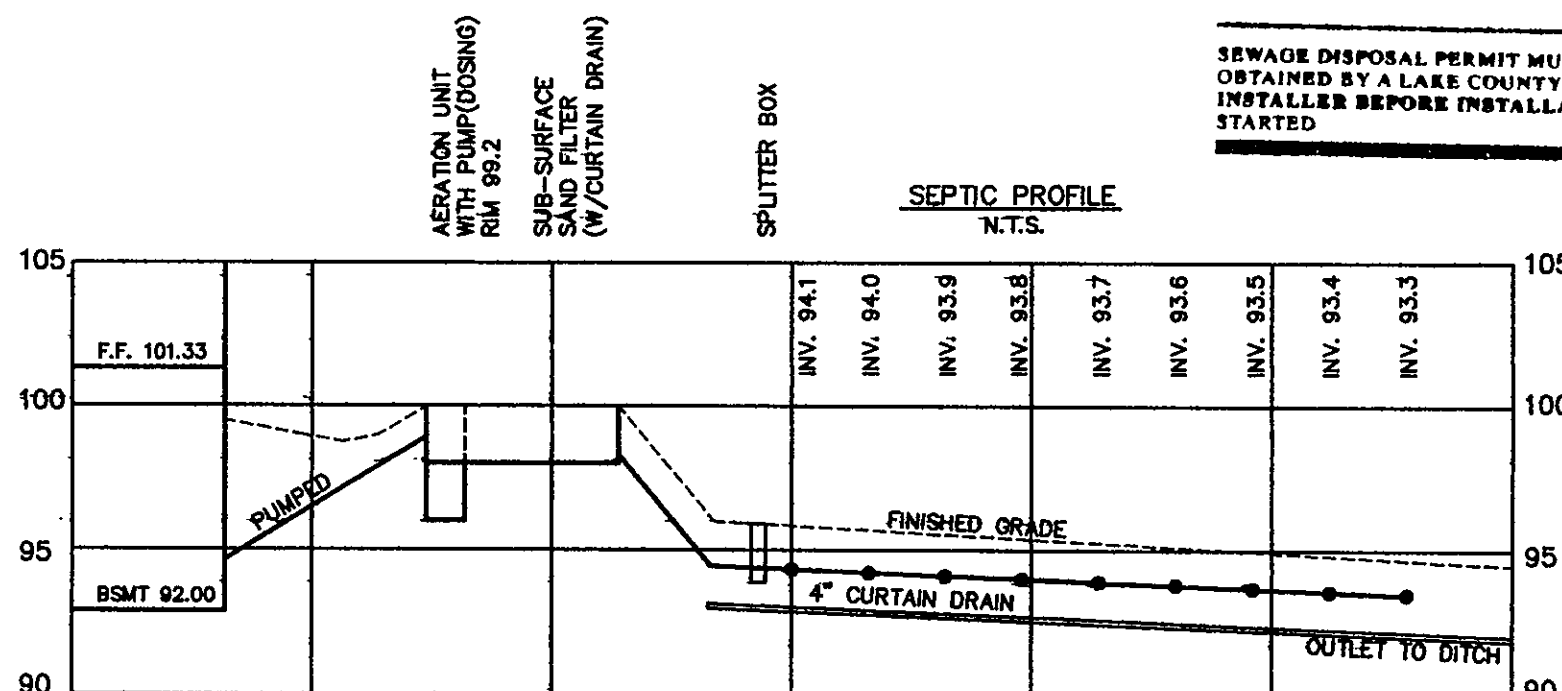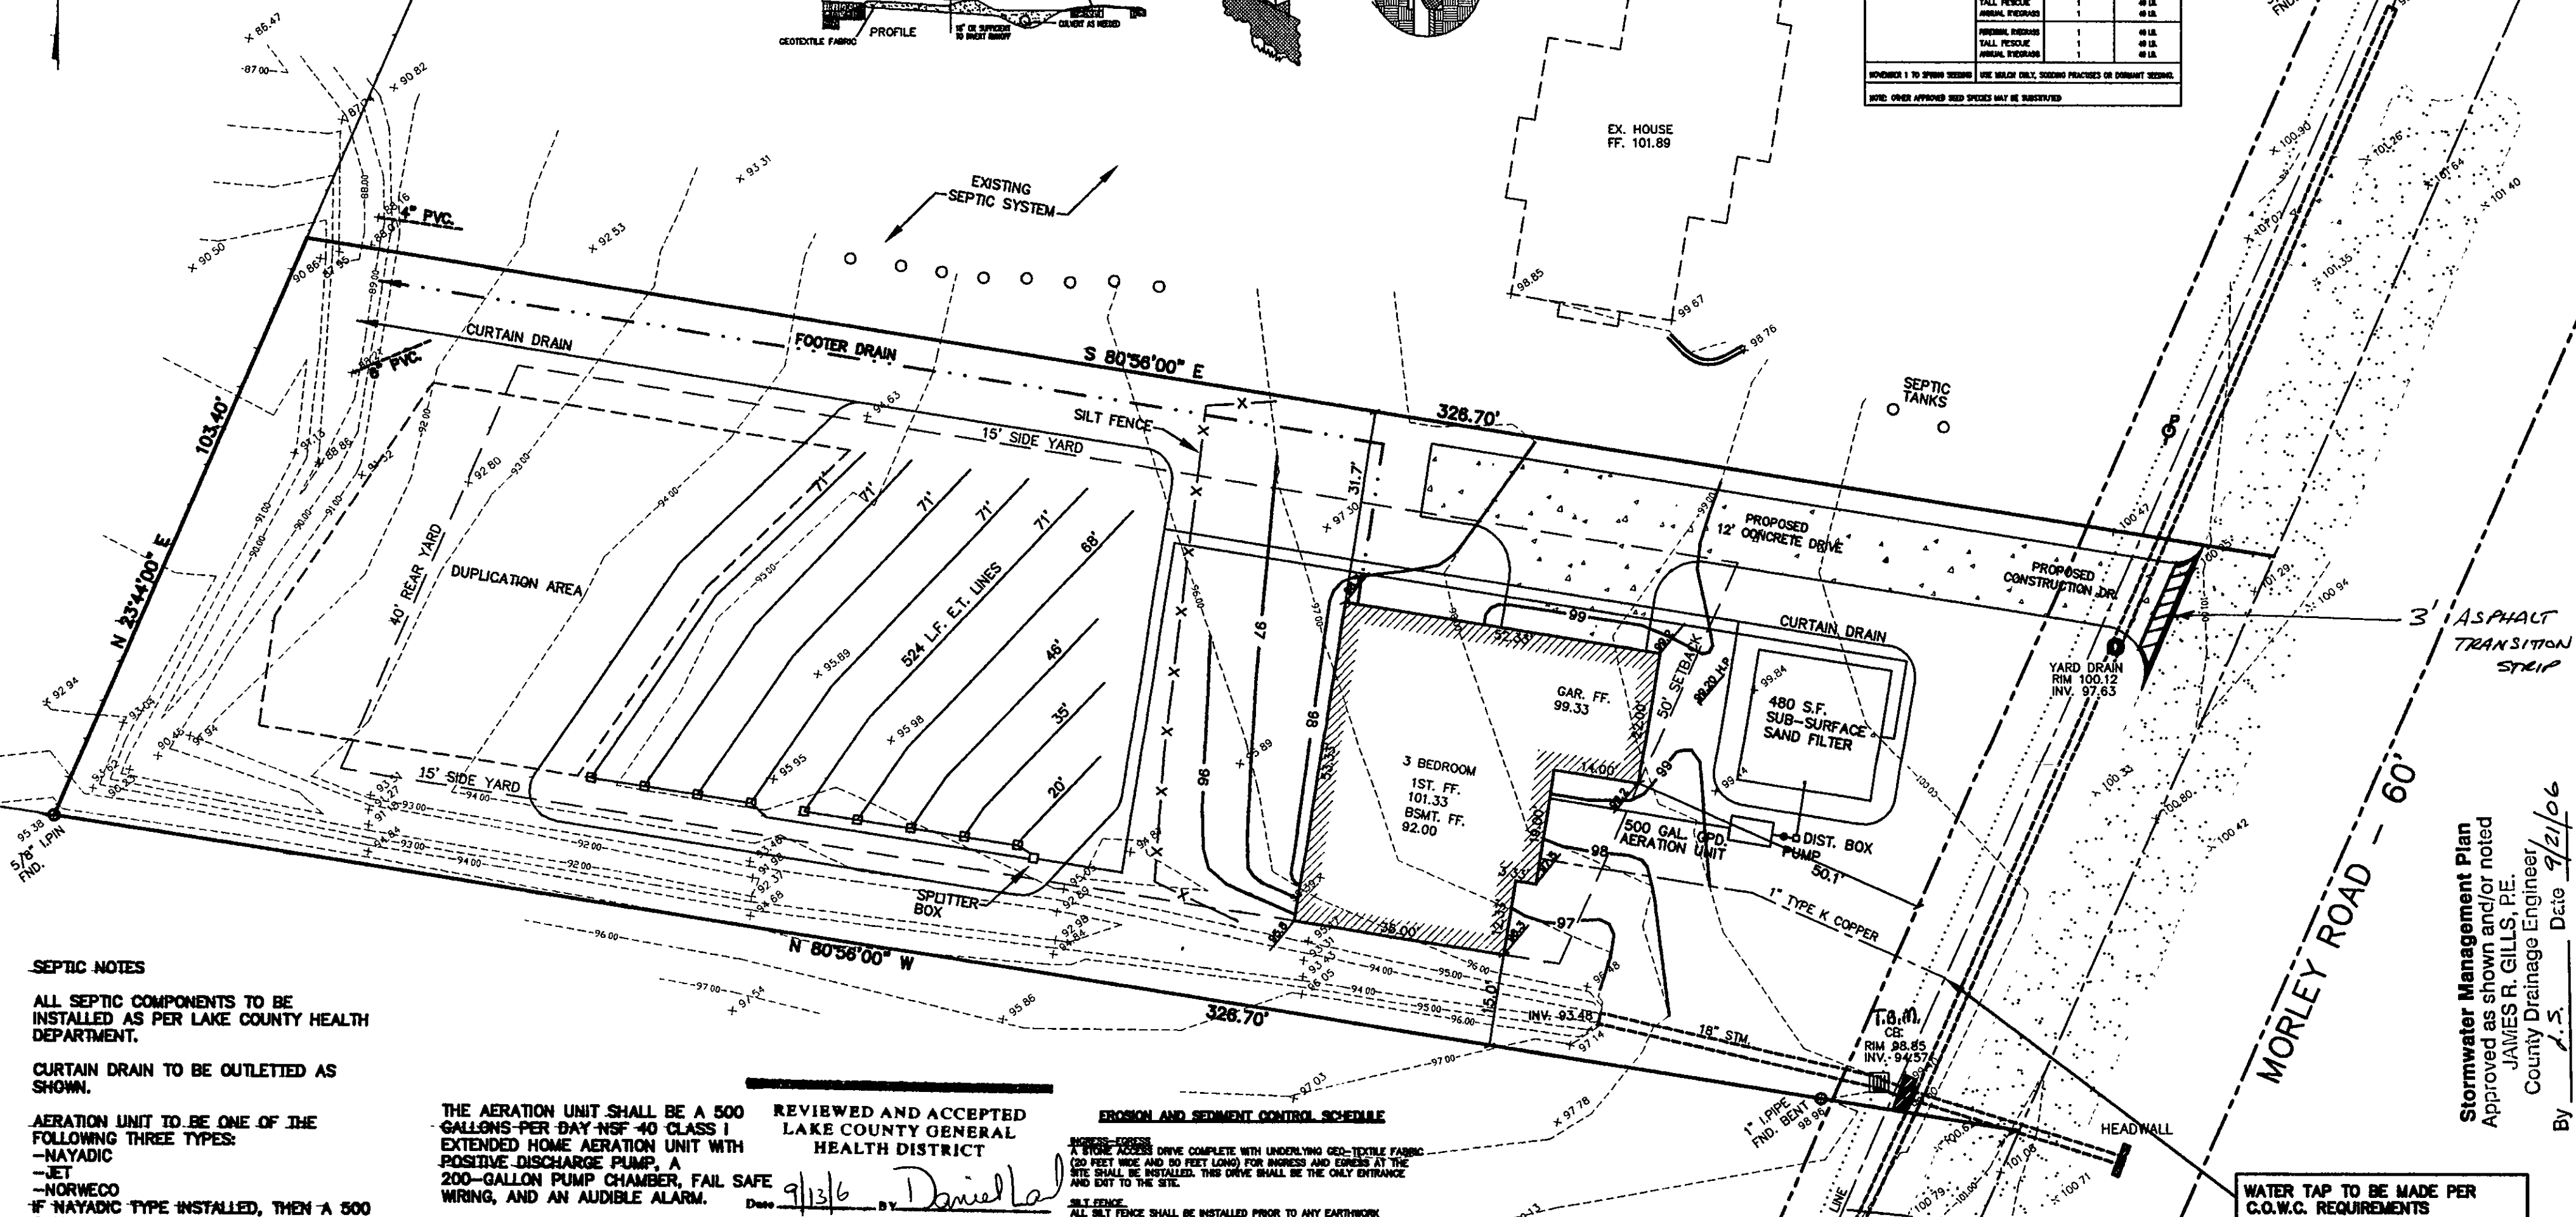

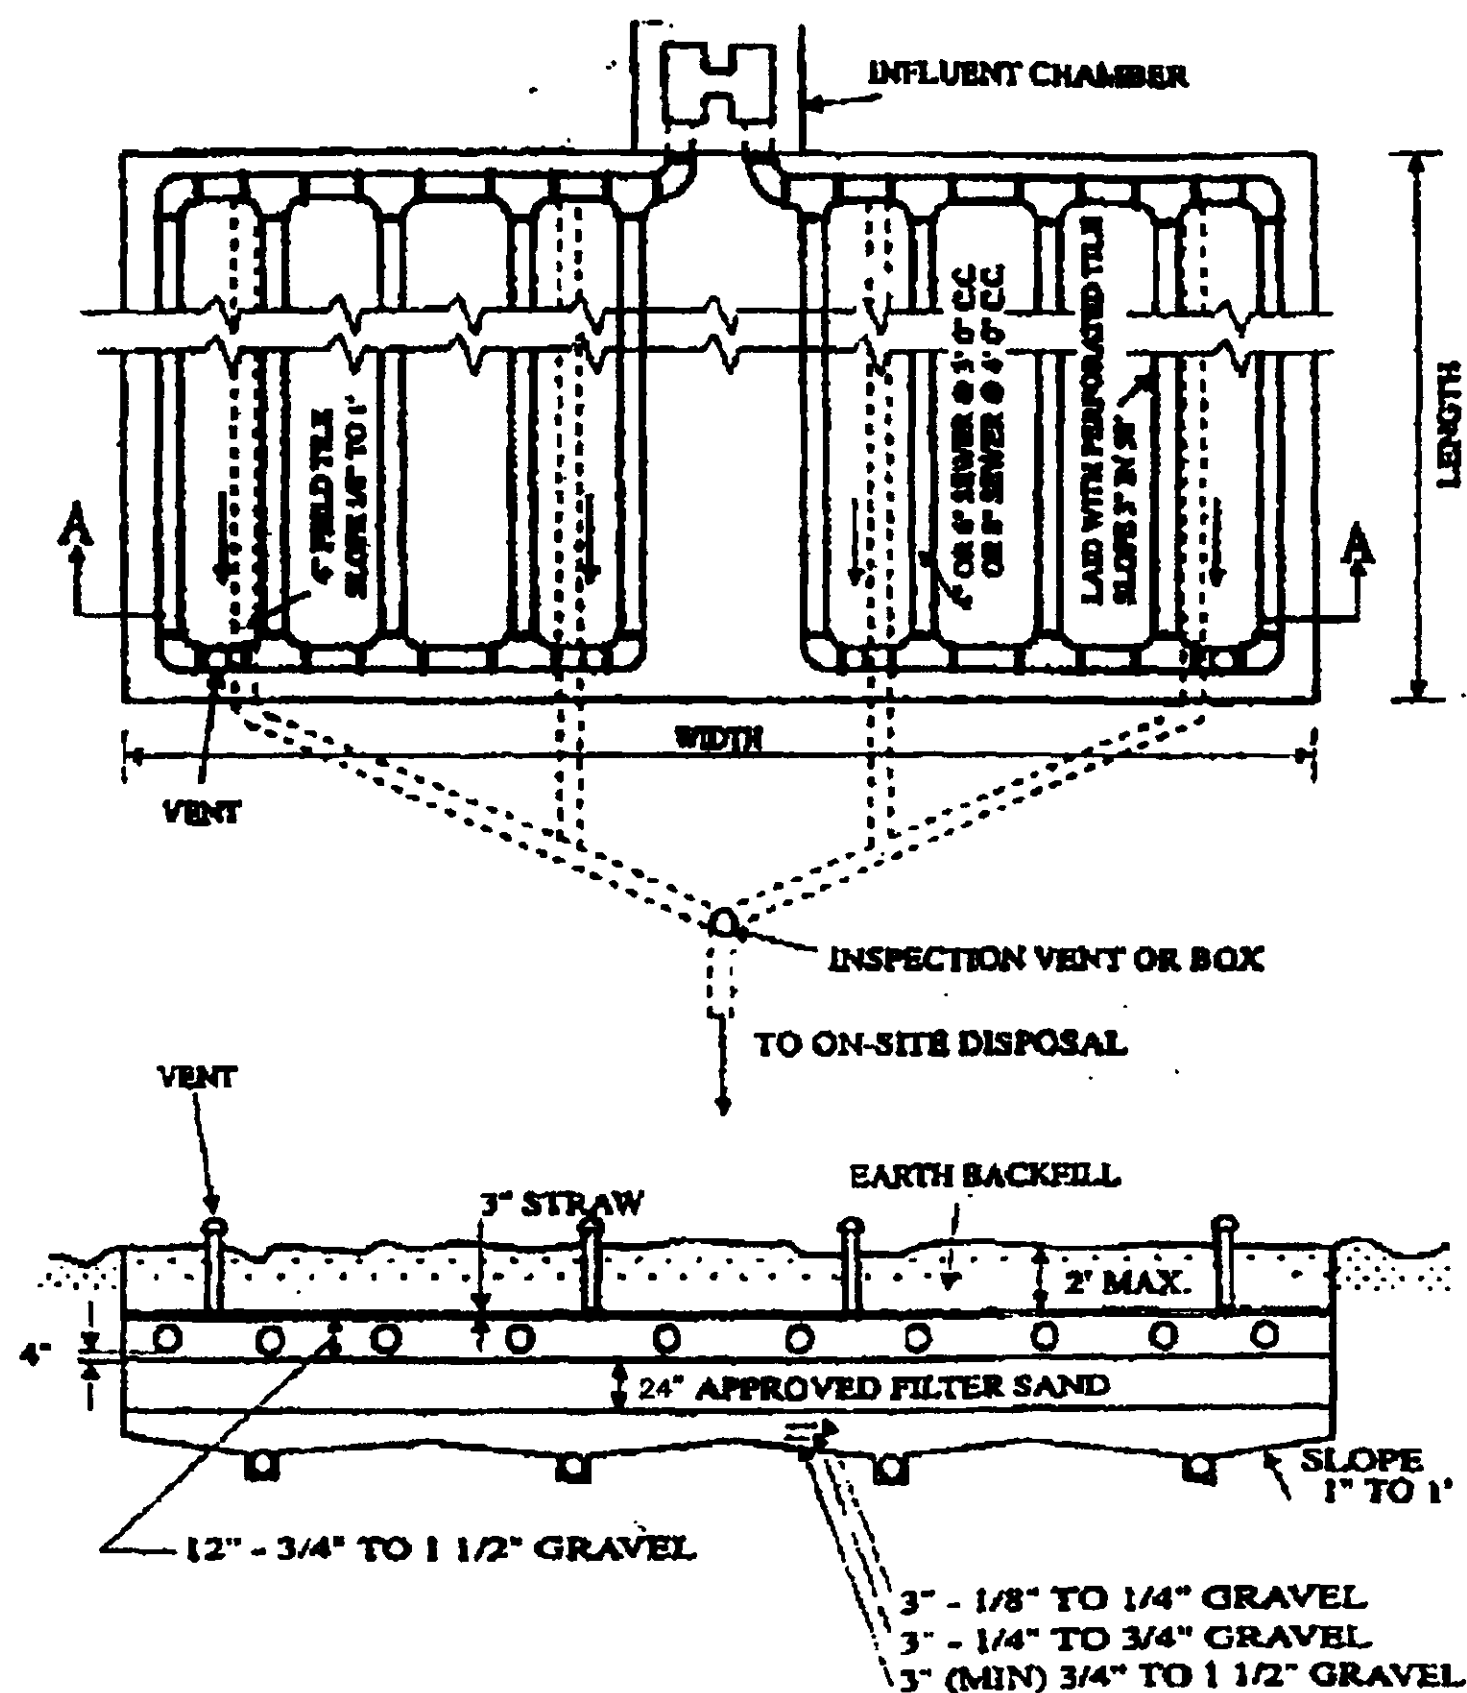


SECTION A-A


SUBSURFACE SAND FILTERS

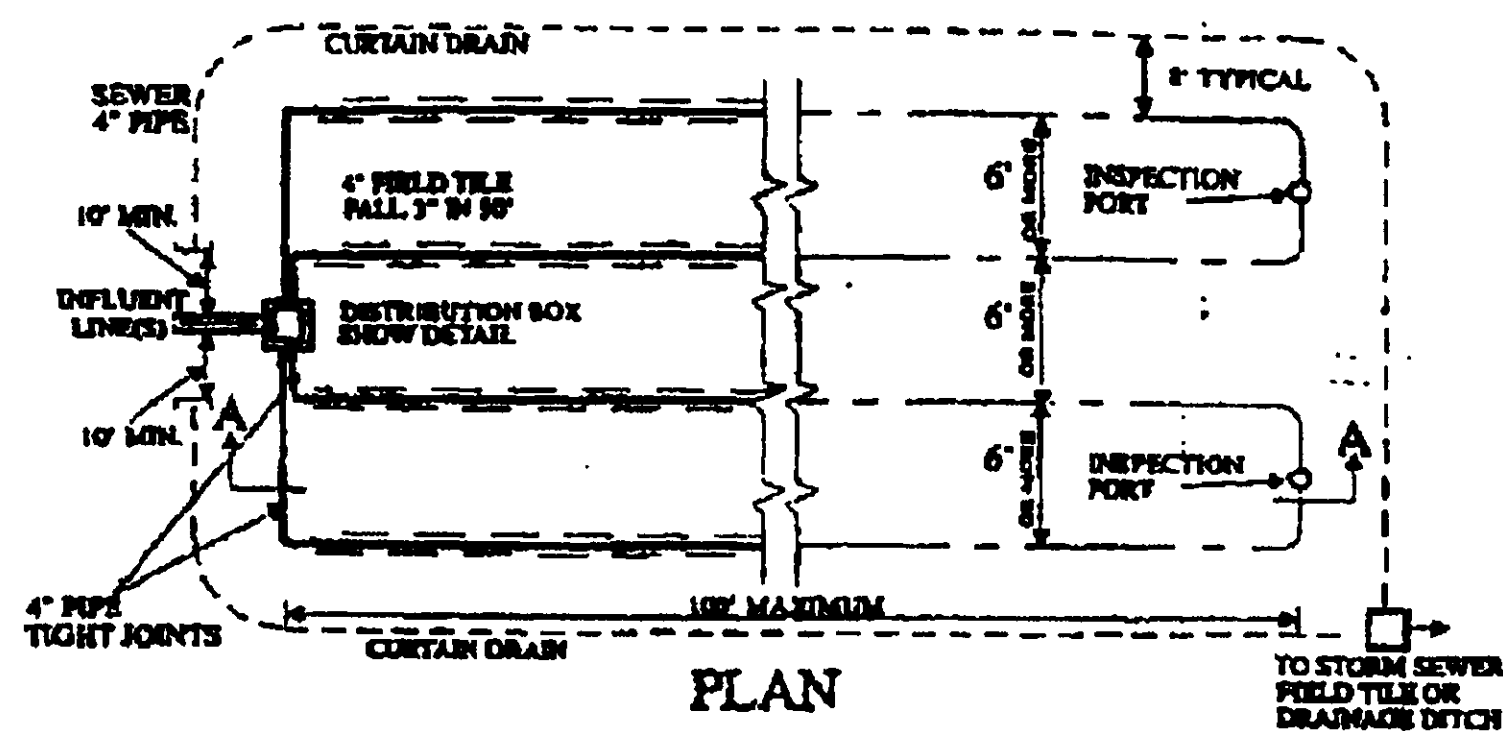

NOTE: TILES SHOULD FOLLOW CONTOURS

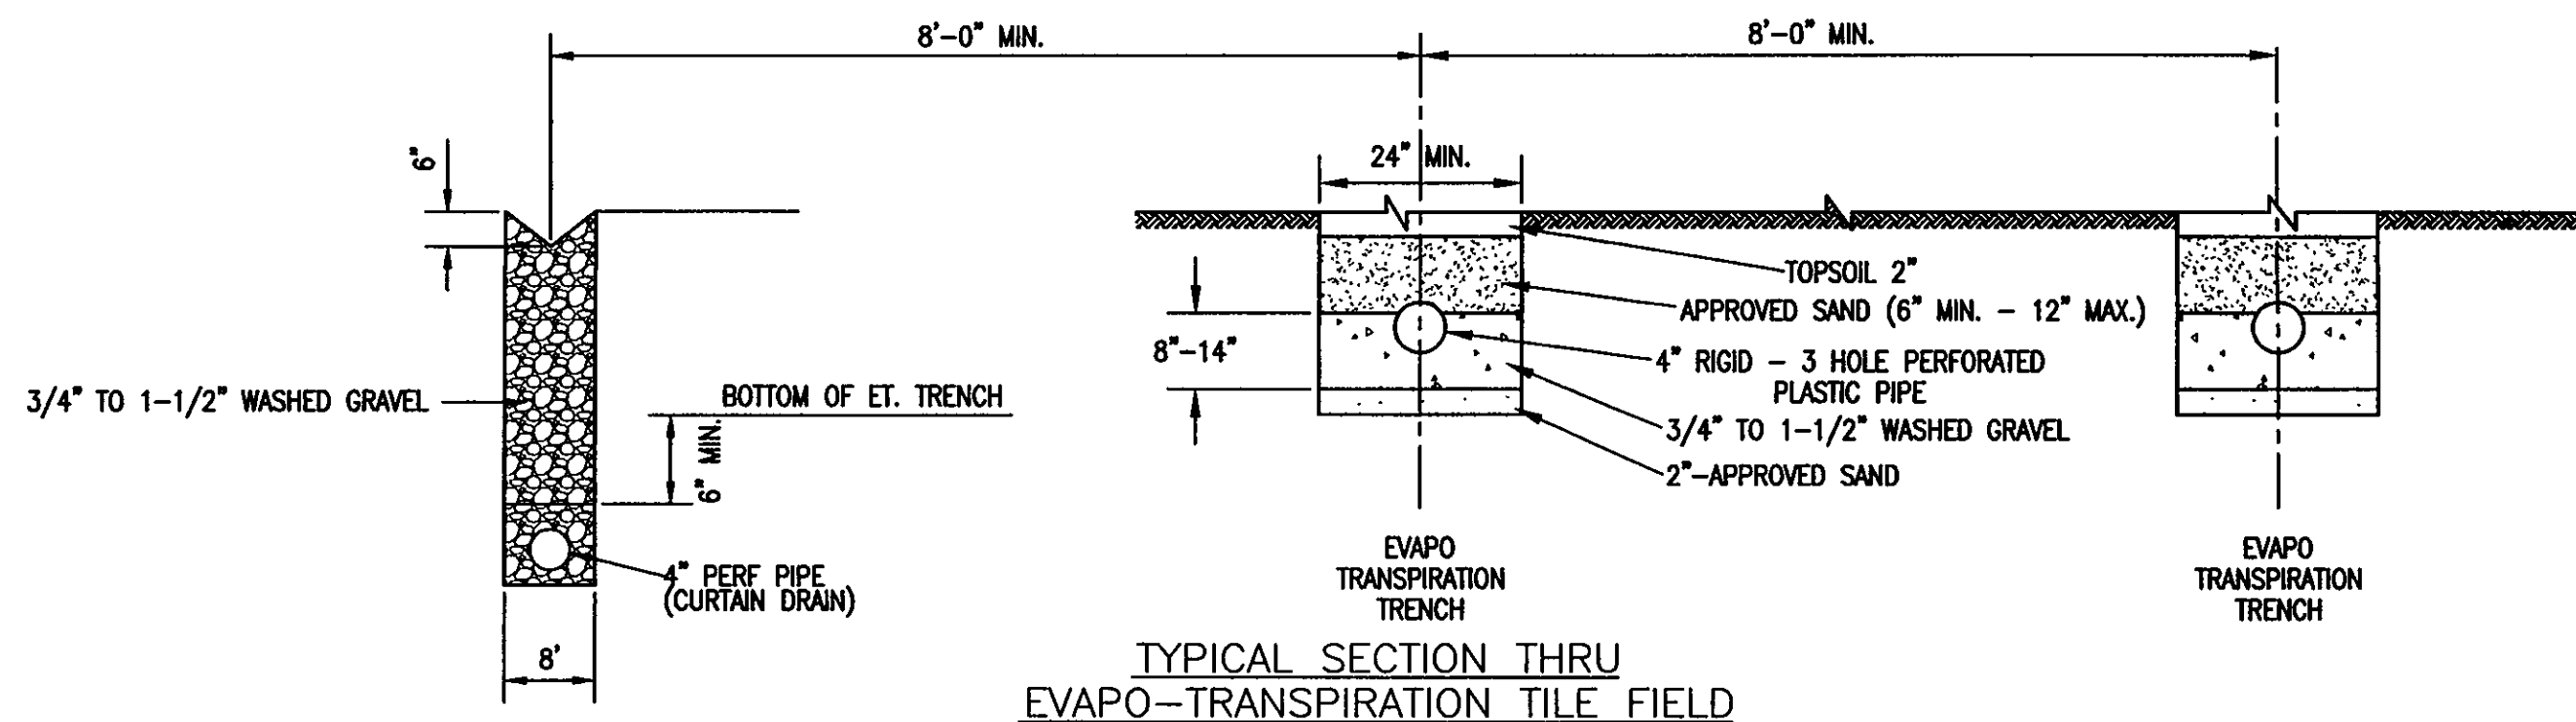

2/2	PPN. 8A-26-16 MORLEY ROAD CONCORD TWP. LAKE COUNTY	TITLE			
		DETAIL SHEET			
		DATE 6-29-03	DRAWN BY TDR	CHECKED BY DJG	SCALE NONE

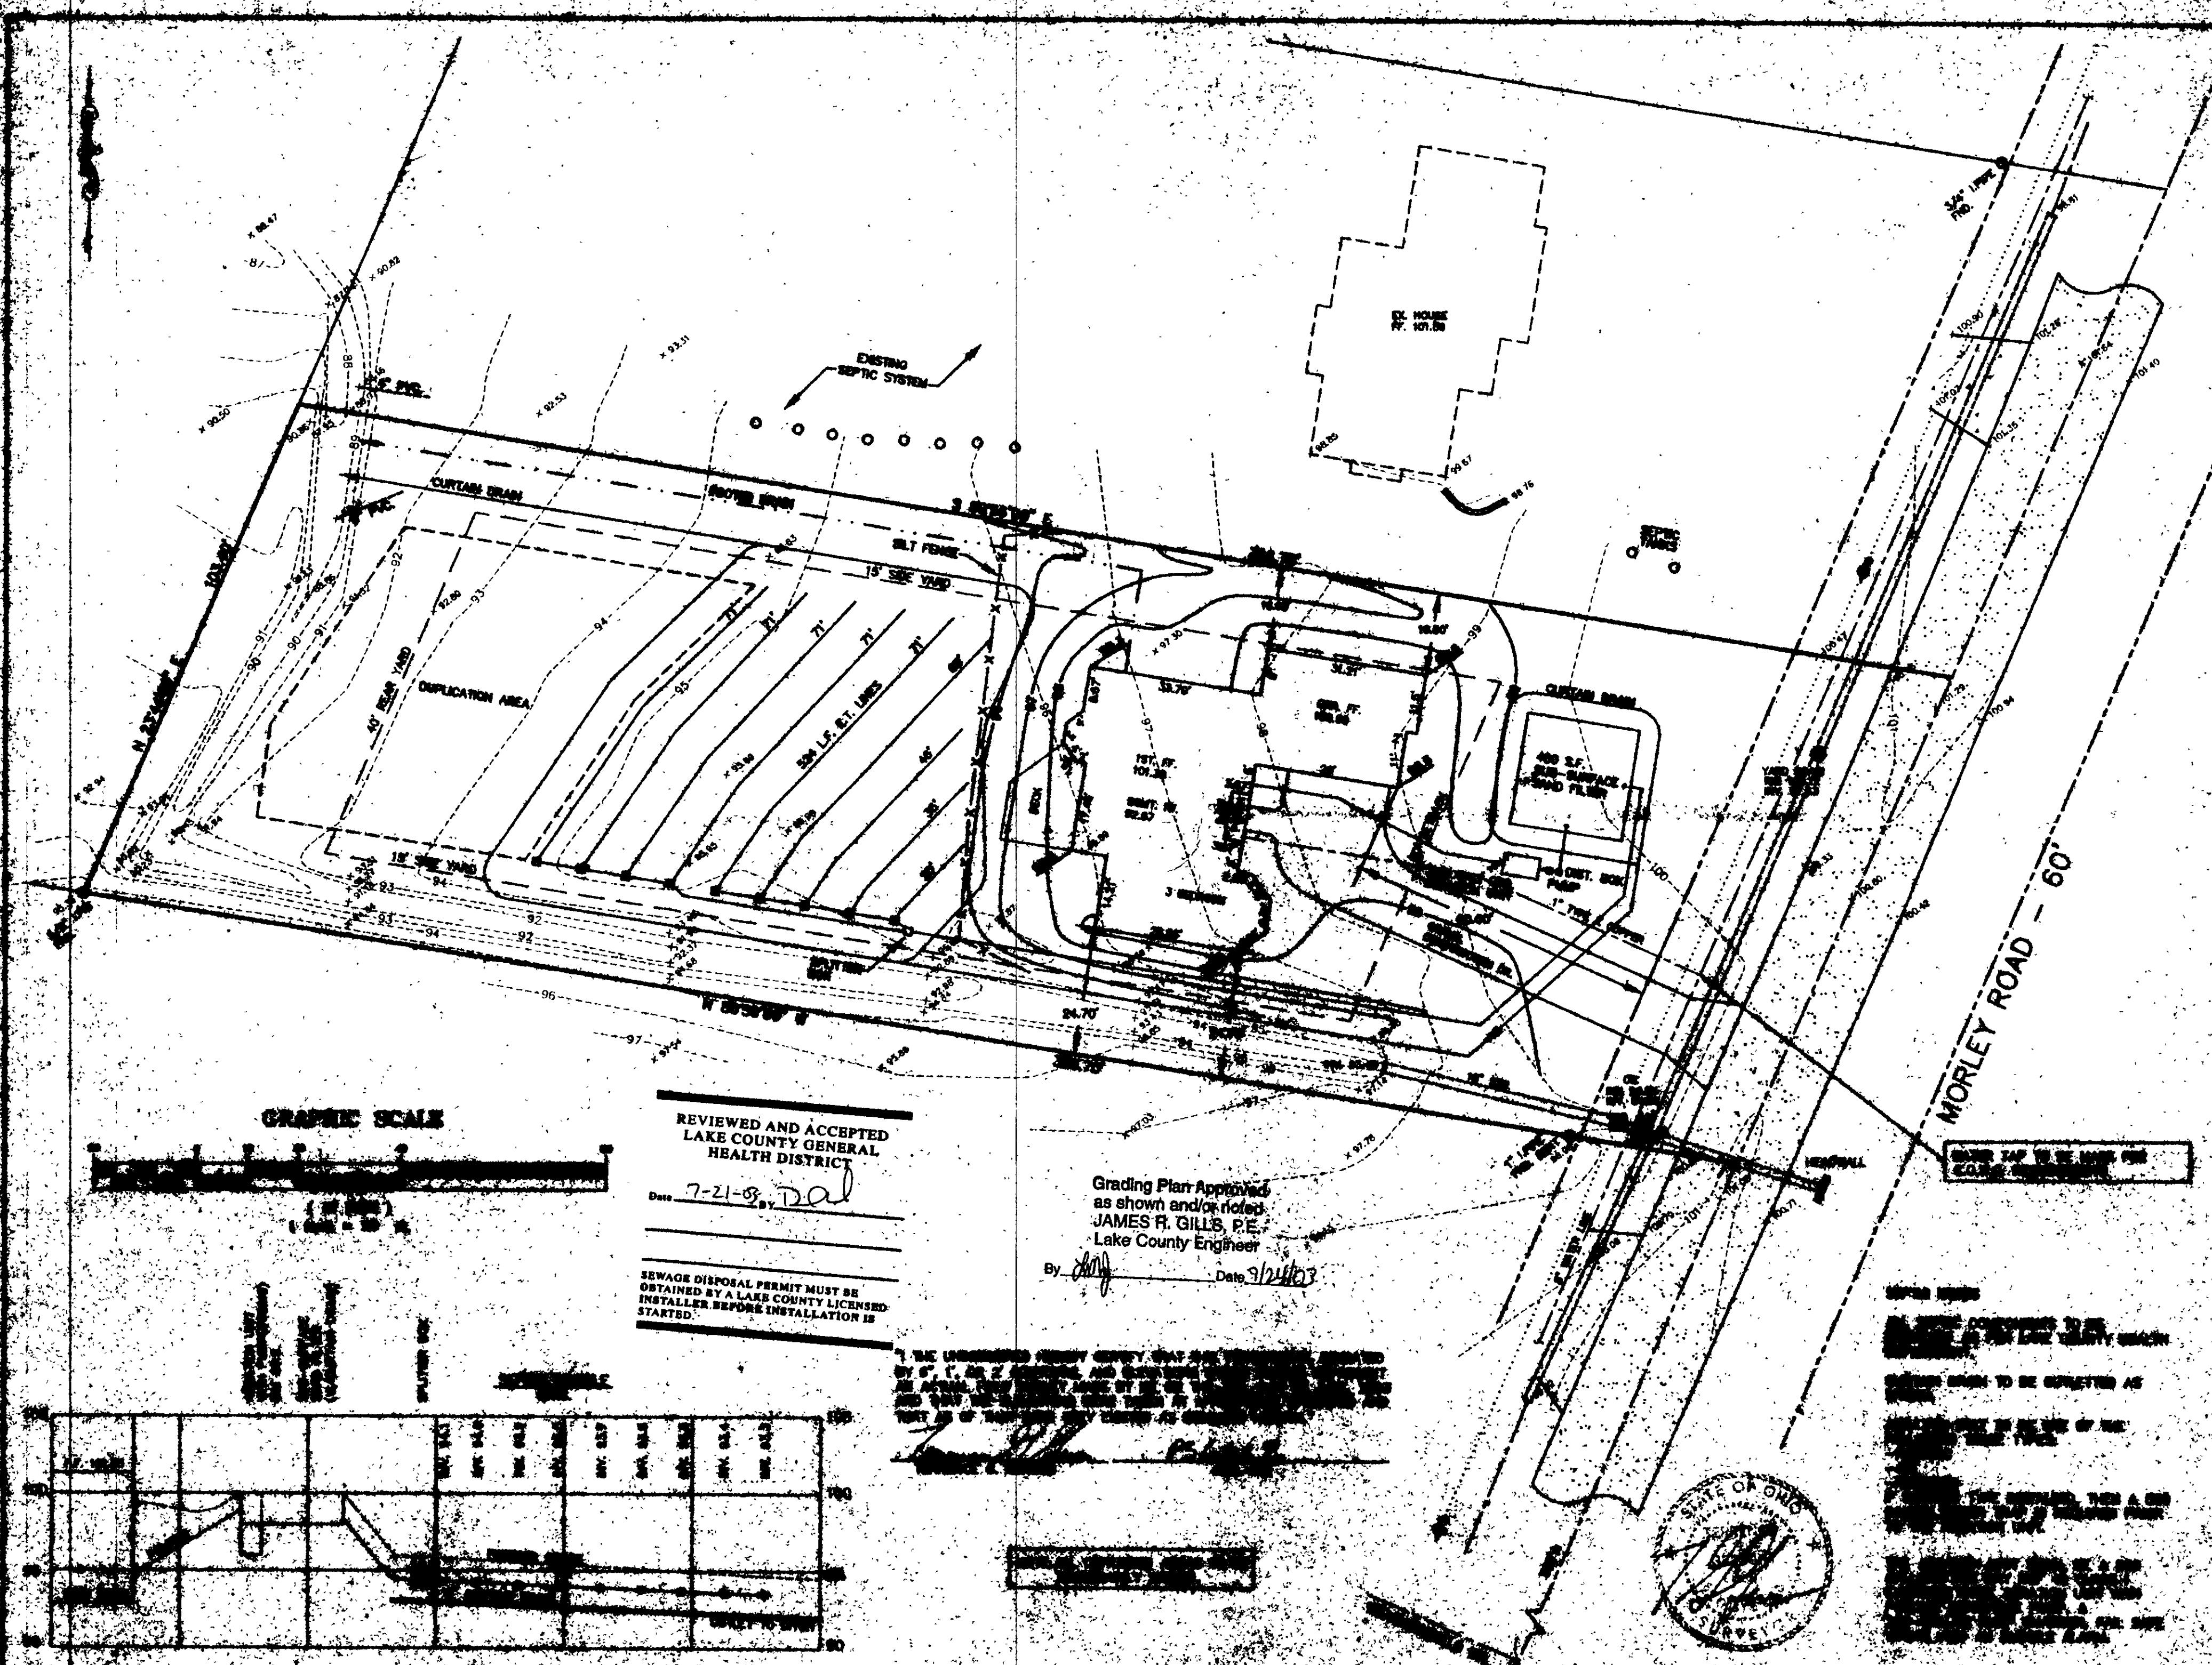

GRAPHIC SCALE



REVIEWED AND ACCEPTED
LAKE COUNTY GENERAL
HEALTH DISTRICT


Date 7-21-08 BY *[Signature]*

SEWAGE DISPOSAL PERMIT MUST BE
OBTAINED BY A LAKE COUNTY LICENSED
INSTALLER BEFORE INSTALLATION IS
STARTED.

Grading Plan Approved
as shown and/or noted
JAMES R. GILLS, P.E.
Lake County Engineer

By *[Signature]* Date 9/24/08


THE UNDERSIGNED COUNTY ENGINEER HEREBY CERTIFIES THAT THE SEWAGE DISPOSAL SYSTEM SHOWN ON THIS PLAN WAS DESIGNED AND CONSTRUCTED IN ACCORDANCE WITH THE REQUIREMENTS OF THE LAKE COUNTY HEALTH DISTRICT AND THE LAKE COUNTY ENGINEER'S OFFICE. THE SEWAGE DISPOSAL SYSTEM SHOWN ON THIS PLAN IS THE PROPERTY OF THE LAKE COUNTY ENGINEER'S OFFICE.

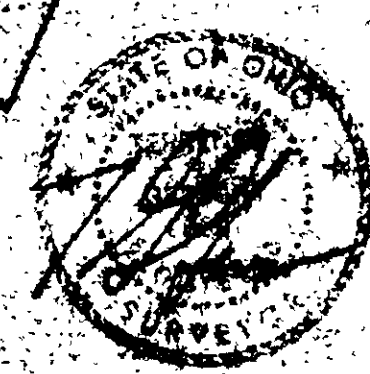

NOTES:
1. ALL CONSTRUCTION SHALL BE IN ACCORDANCE WITH THE LAKE COUNTY HEALTH DISTRICT REQUIREMENTS.
2. THE SEWAGE DISPOSAL SYSTEM SHALL BE DESIGNED AND CONSTRUCTED IN ACCORDANCE WITH THE REQUIREMENTS OF THE LAKE COUNTY ENGINEER'S OFFICE.
3. THE SEWAGE DISPOSAL SYSTEM SHALL BE DESIGNED AND CONSTRUCTED IN ACCORDANCE WITH THE REQUIREMENTS OF THE LAKE COUNTY ENGINEER'S OFFICE.


PN. 04-20-10
MORLEY ROAD
CONCORD TWP. LAKE COUNTY, OHIO
DATE 9/24/08
BY *[Signature]*

WILLIAM R. GRAY ASSOCIATES, INC.
7511 DENVER AVENUE, SUITE 100
DENVER, CO 80231
(440) 948-1886

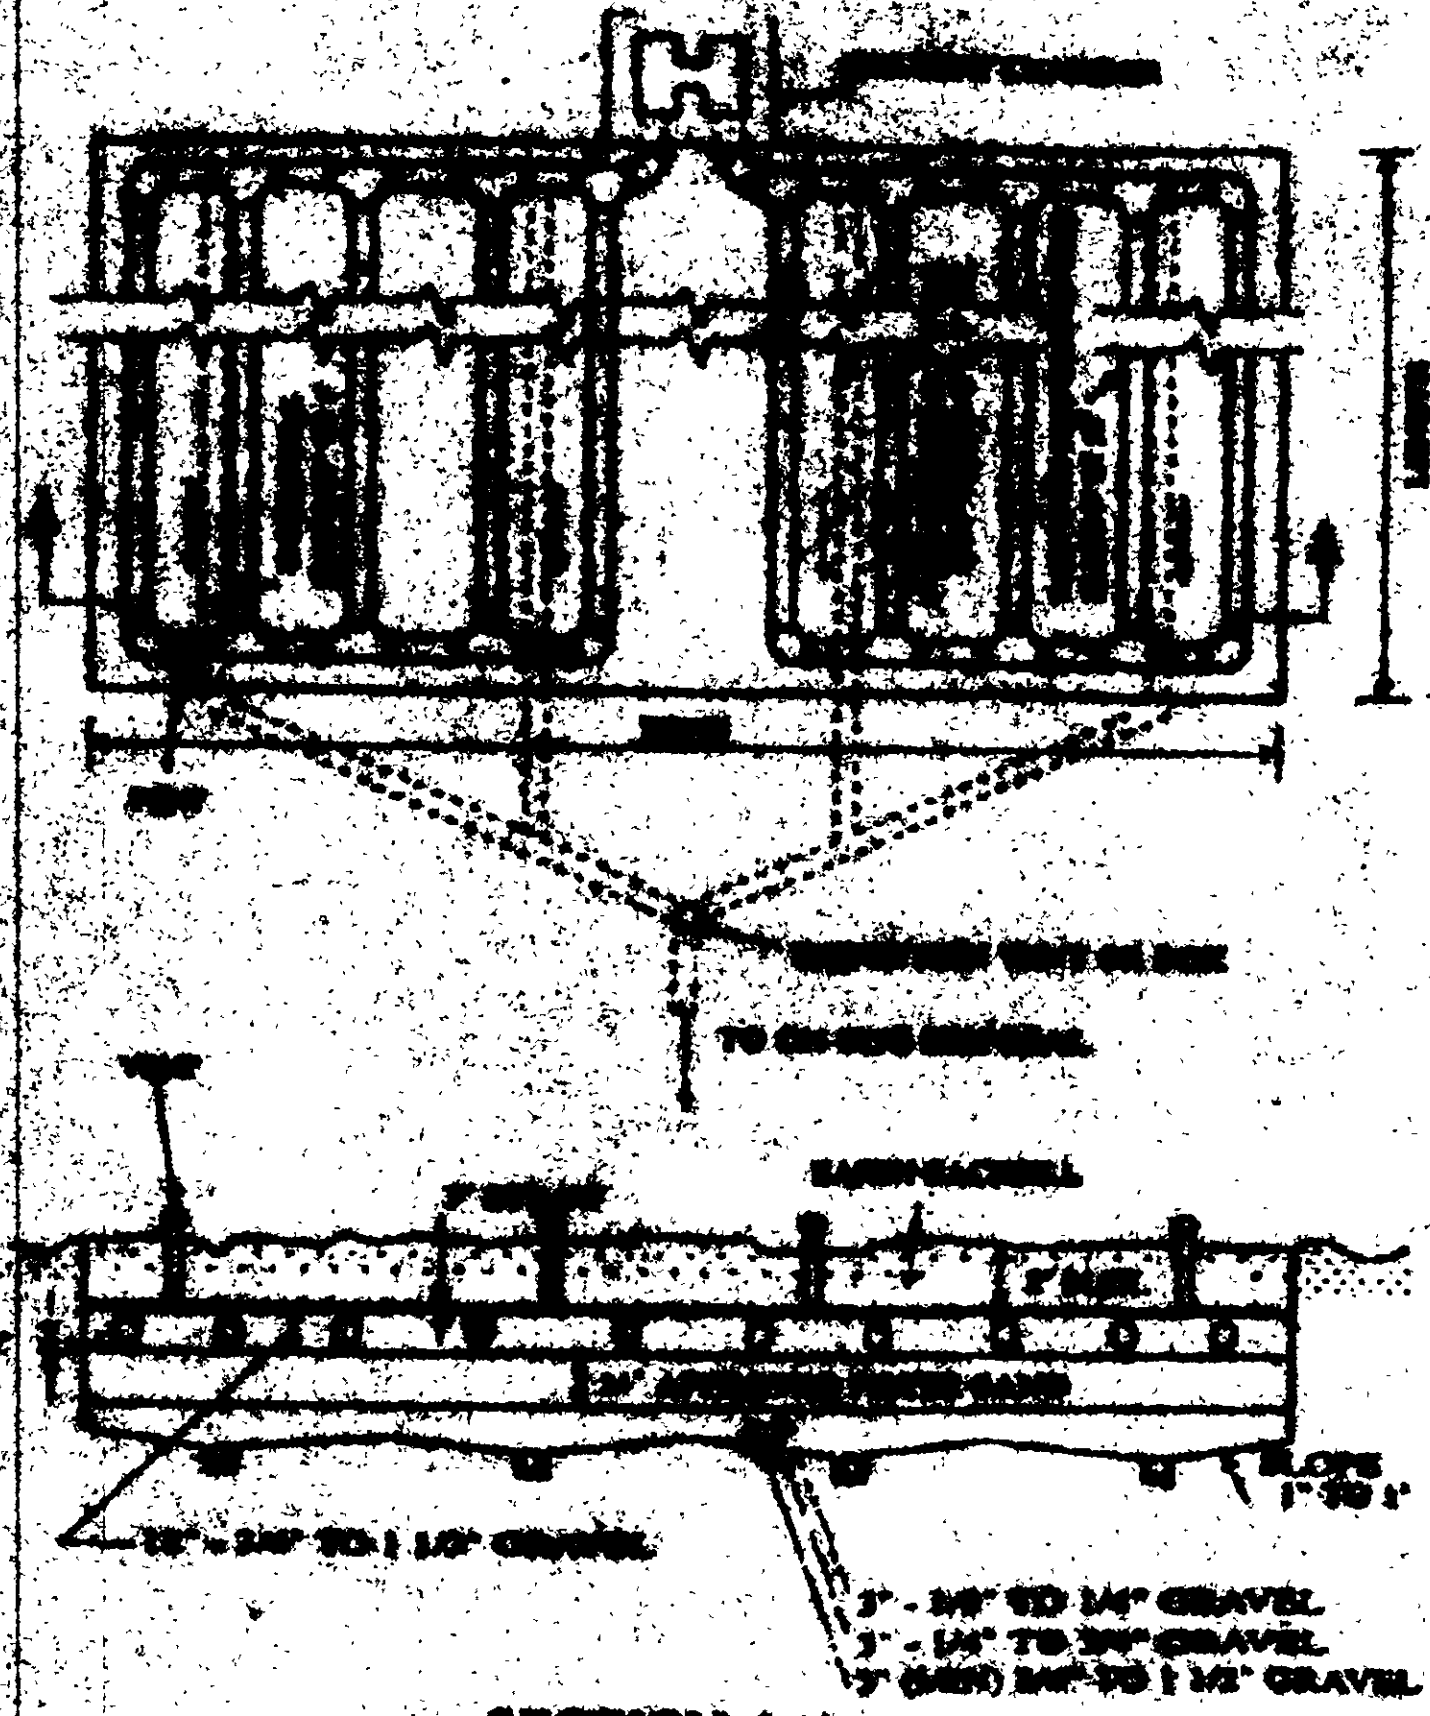


SECTION A-A

SUBSURFACE SAND FILTERS

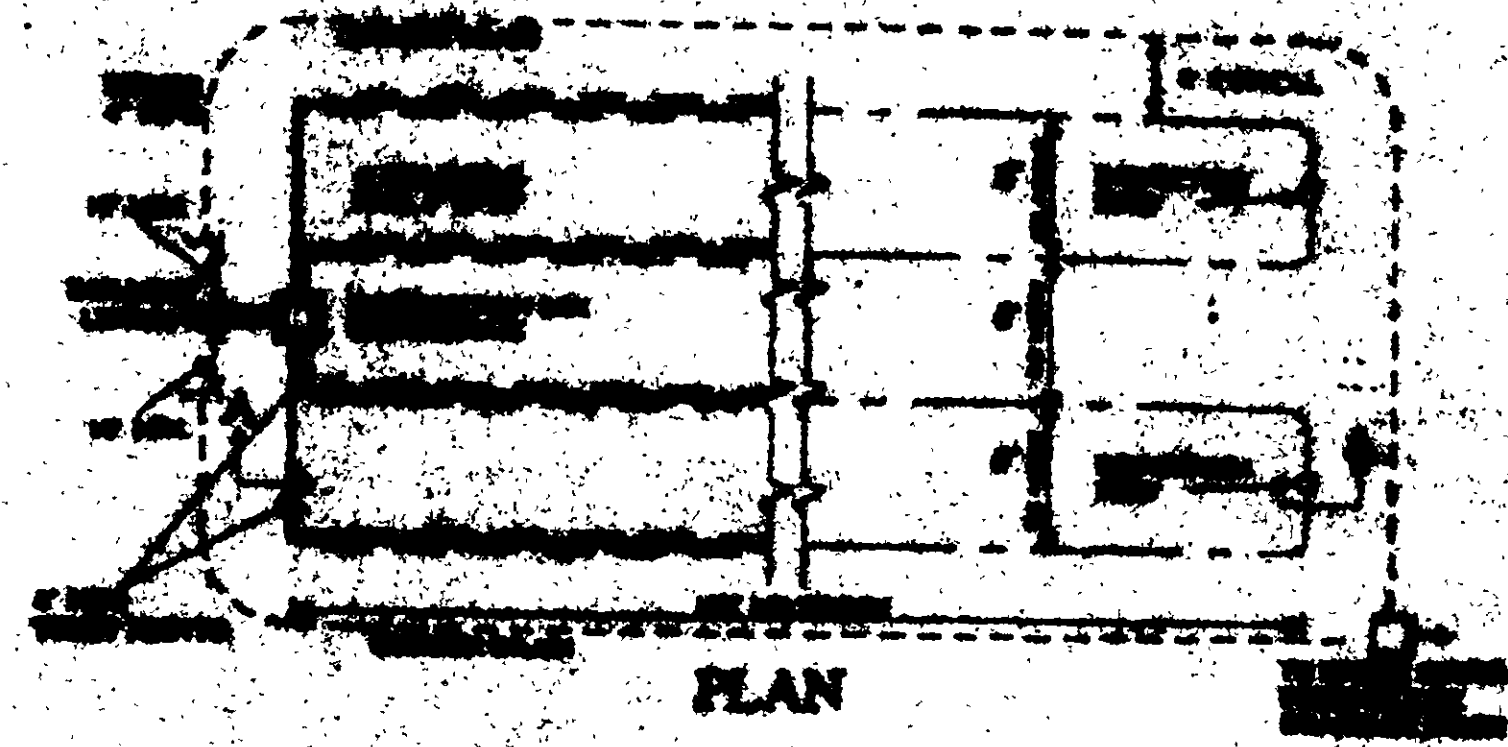

PLAN

NOTE: THIS DRAWING IS FOR INFORMATION ONLY

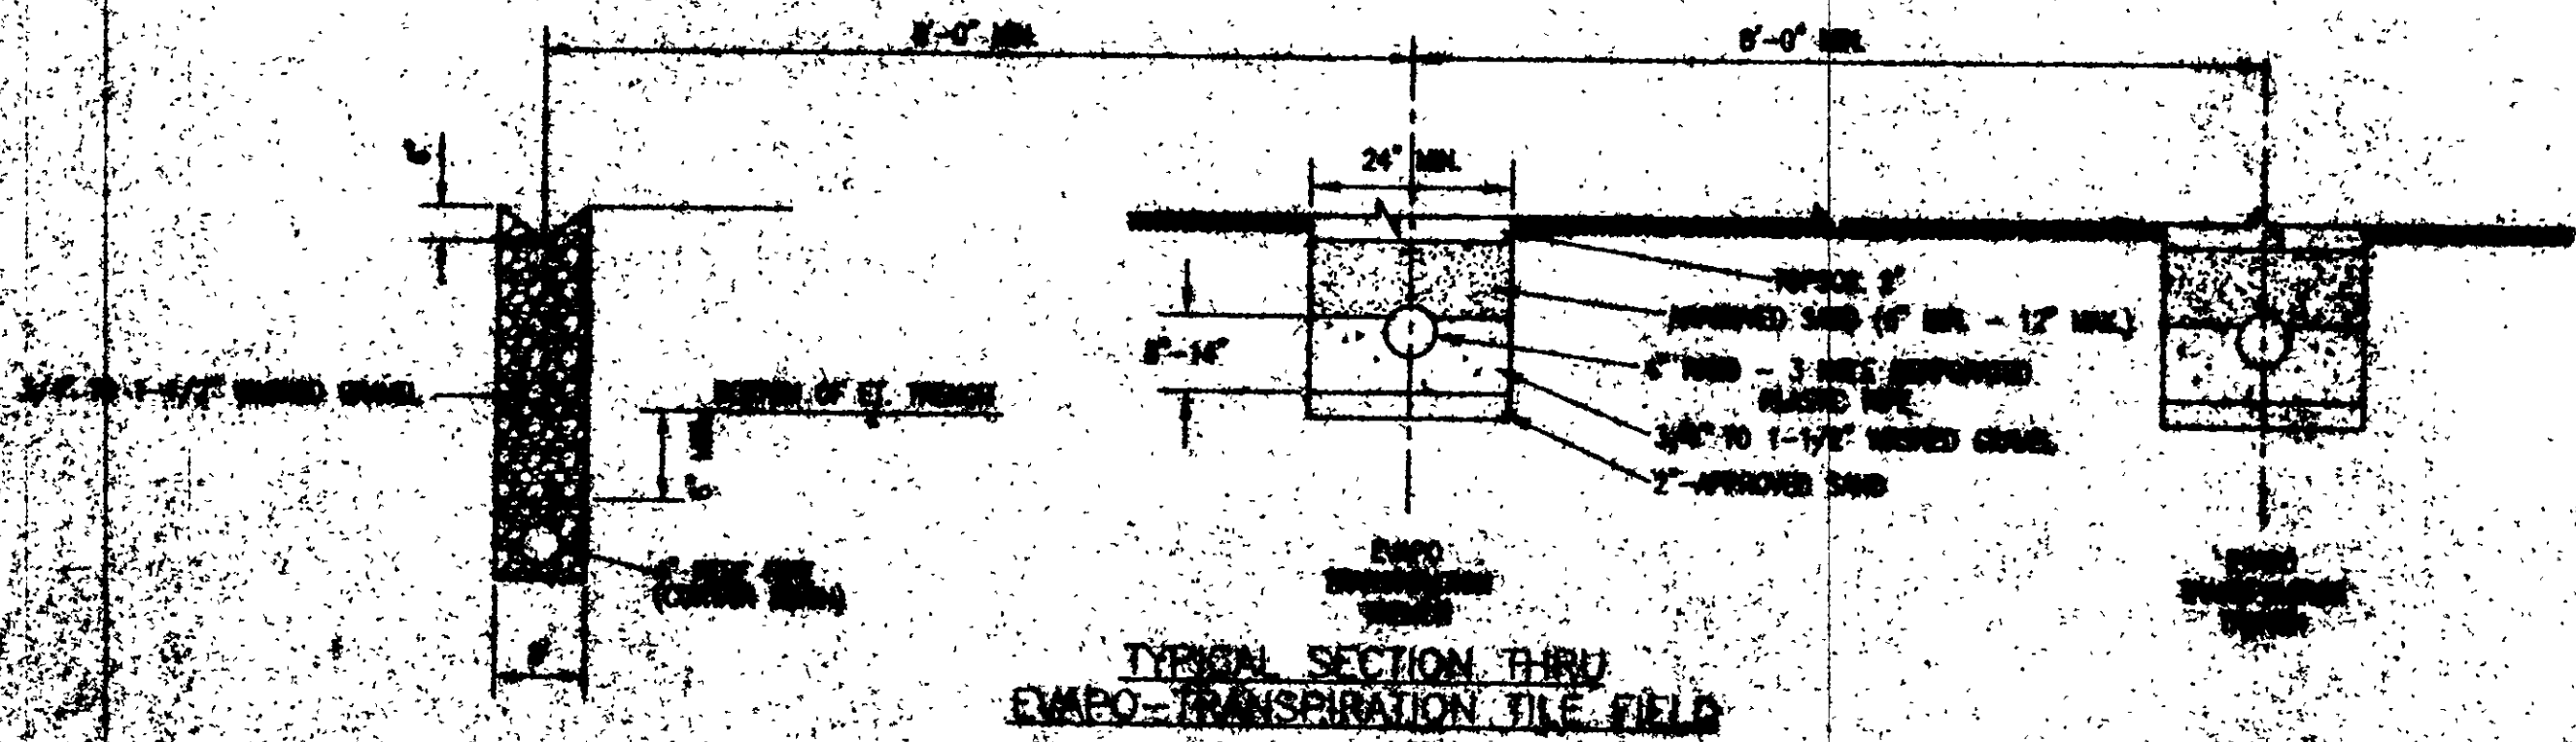

TYPICAL SECTION THRU
EVAPO-TRANSPIRATION TILE FIELD

SHEET PLAN
 FOR
 EPN 84-28-18
 WASTEWATER
 TREATMENT PLANT
 1/2" = 1'