

SITE PLAN

Collegio Township, Lake County, Ohio

for: Social Development

ADDRESS STREET CITY ZIP

SUBDIVISION NAME LOT 538 TRACT 4
VOL. - PG. 30-43 PAGE 91
SUBLOT NO. STREET PERM. PARCEL NO. STREET

LEGEND	
WATER VALVE (GAS)	---
WATER METER (GAS)	---
AS BUILT ELEVATION	---
INDICATES DIRECTION OF SURFACE DRAINAGE	---
NO OF BEDROOMS	---
BATHROOMS	---
KITCHEN	---
LIVING ROOM	---
DINING ROOM	---
SAN. SEWER SIZE % GR. LOC.	---
SAN. MH. CAST. ELEV. INV. ELEV.	---
BLDG. DIMENSIONS FIN. OR.	---
BLDG. TYPE WITH THICKNESS	---
SEPTIC TANK LOCATION & DUPPLICATION AREA	---
ISOLATION RADIUS FROM WELL	---

REMARKS
ALL BOUNDARY DATA SHOWN WAS OBTAINED FROM IDEEDS, RECORDED
SUBDIVISION PLAT OR OTHER PUBLIC RECORDS
LOCATIONS AS SHOWN OF ADJACENT WELLS AND SEPTIC TANKS OBTAINED FROM
LAKE COUNTY HEALTH DEPARTMENT

DESIGN CERTIFICATION
THIS PLAT WAS PREPARED BY ME, AND IS CORRECT
TO THE BEST OF MY KNOWLEDGE AND BELIEF
NAME SURVEYOR REGISTRATION NO.

CHECK LIST	
NO. OF BEDROOMS	---
BATHROOMS	---
KITCHEN	---
LIVING ROOM	---
DINING ROOM	---
SAN. SEWER SIZE % GR. LOC.	---
SAN. MH. CAST. ELEV. INV. ELEV.	---
BLDG. DIMENSIONS FIN. OR.	---
BLDG. TYPE WITH THICKNESS	---
SEPTIC TANK LOCATION & DUPPLICATION AREA	---
ISOLATION RADIUS FROM WELL	---

REVISIONS	
NO.	DATE
1	9/10/90
2	9/20/90
3	9/20/90
4	9/20/90
5	9/20/90



PLAN PREPARED BY:
BABCOCK • JONES & ASSOCIATES, INC.
PAINESVILLE, OHIO
DATE 9/20/90
SCALE 1" = 30'
PHONE NO. 357-1811
DRAWING NO. 93-013

"AS BUILT" CERTIFICATION
I, JAMES H. JONES, P.E., HEREBY CERTIFY THAT THE CIRCLED GRADES ARE EXISTING
FINISH GRADES CHECKED IN THE FIELD ON 9/19/90
AND ARE CORRECT TO THE BEST OF MY KNOWLEDGE AND BELIEF.
REGISTERED SURVEYOR REG. NO.

T.B.M. SAN M.H. 94.45 TIFFANY CULVERT, ELEV. = 775.45
HYDRAULIC PROFILE SCALE: HORIZ. 1" = 20', VERT. 1" = 5'

"I, the undersigned hereby certify that this topography indicated by 6", 1' or 2' contours, and elevations shown hereon represent an actual field survey made by me on the day of AUG 29, 1990, and that the elevations were taken at appropriate intervals and that as of that date they existed as indicated hereon."

Name Harry Jones
Reg. No. 6343

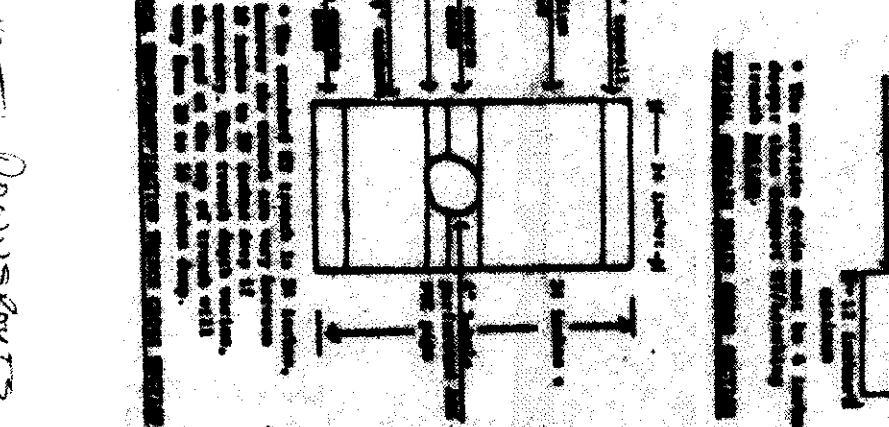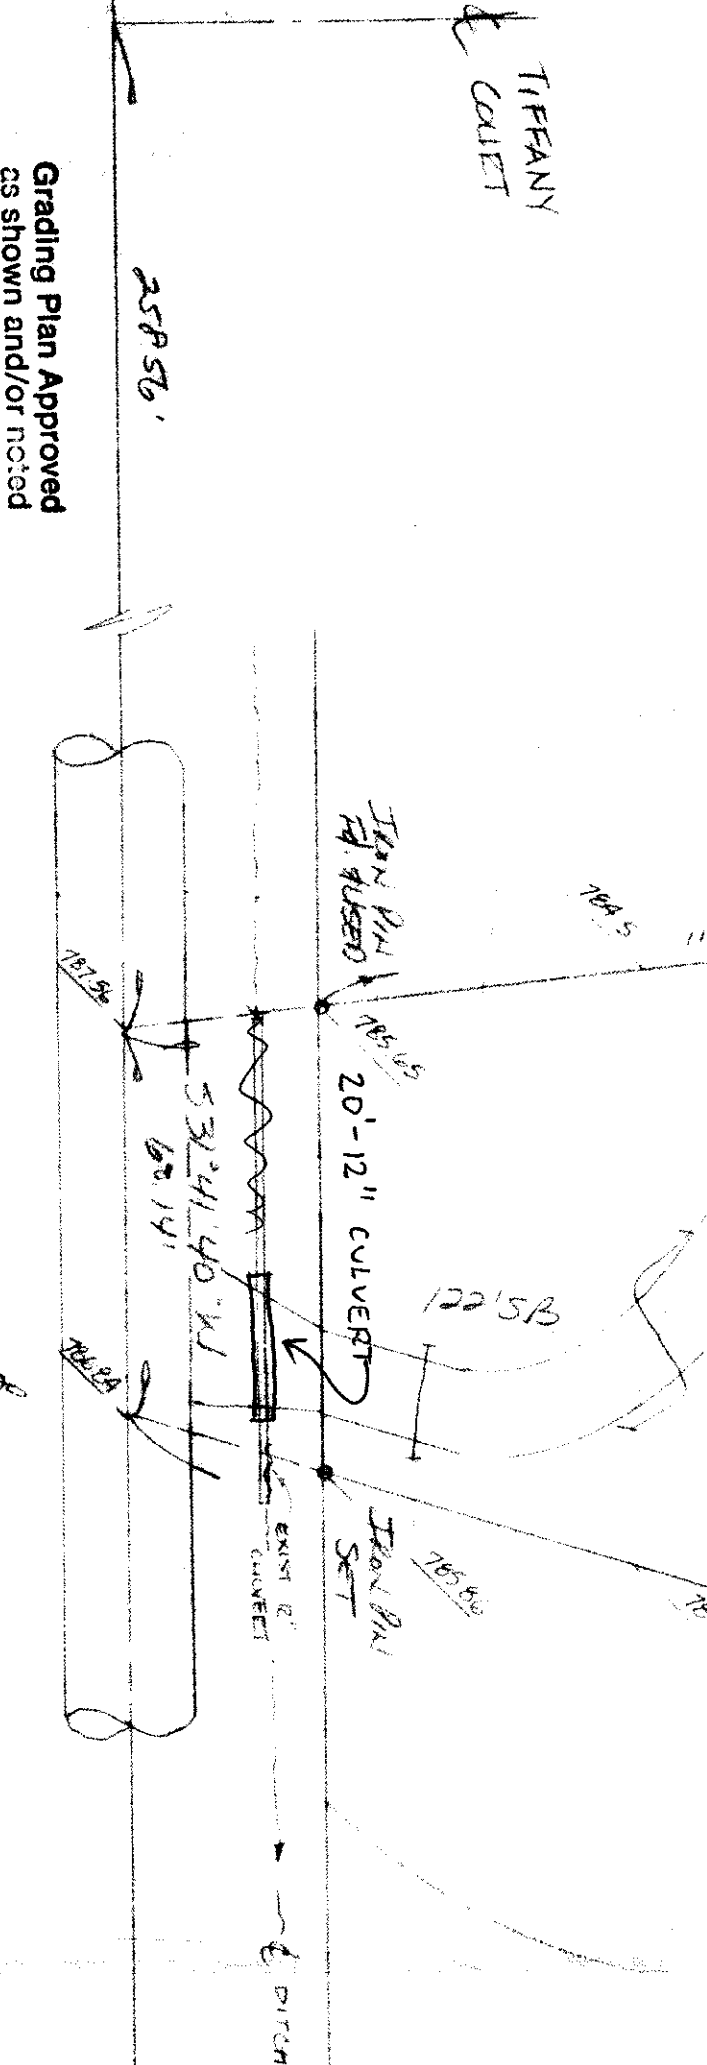

SEWAGE DISPOSAL PERMIT MUST BE OBTAINED BY A LAKE COUNTY LICENSED INSTALLER BEFORE INSTALLATION IS STARTED.
LAKE COUNTY GENERAL HEALTH DISTRICT
Date 9-24-90
R. J. Jones and Accepted
JAMES H. JONES, P.E.
Health Commissioner
OFFICE OF THE HEALTH COMMISSIONER
PAINESVILLE, OHIO

LOW YIELD WATER FIXTURES REQUIRED ON ALL:
Shower Head
Toilet
FENCES TO BE DISCHARGED INTO SEPTIC TANKS
VOL. 397-4311 Waste water to be discharged into
84-30-43 septic tanks
To be brought to finished grade
1. Manhole bank manhole covers
2. Sprinkler box cover
3. Distribution box cover

Grading Plan Approved
as shown and/or noted
THOMAS P. GILLES, P.E.
Lake County Engineer
By G.H. Date 9/23/90
1. REMOVE EXISTING 12" CULVERT AND REPLACE WITH 20'-12" CULVERT.
2. SWALE AS SHOWN.

MORLEY ROAD - 600'