


S/L 18

S/L 19A	S/L 19B
R = 2405.00'	R = 30.00'
A = 229.83'	A = 10.69'
C = 229.75'	C = 10.63'
Δ = 05°28'22"	Δ = 20°24'40"
N 82°31'44" W	N 75°03'40" W

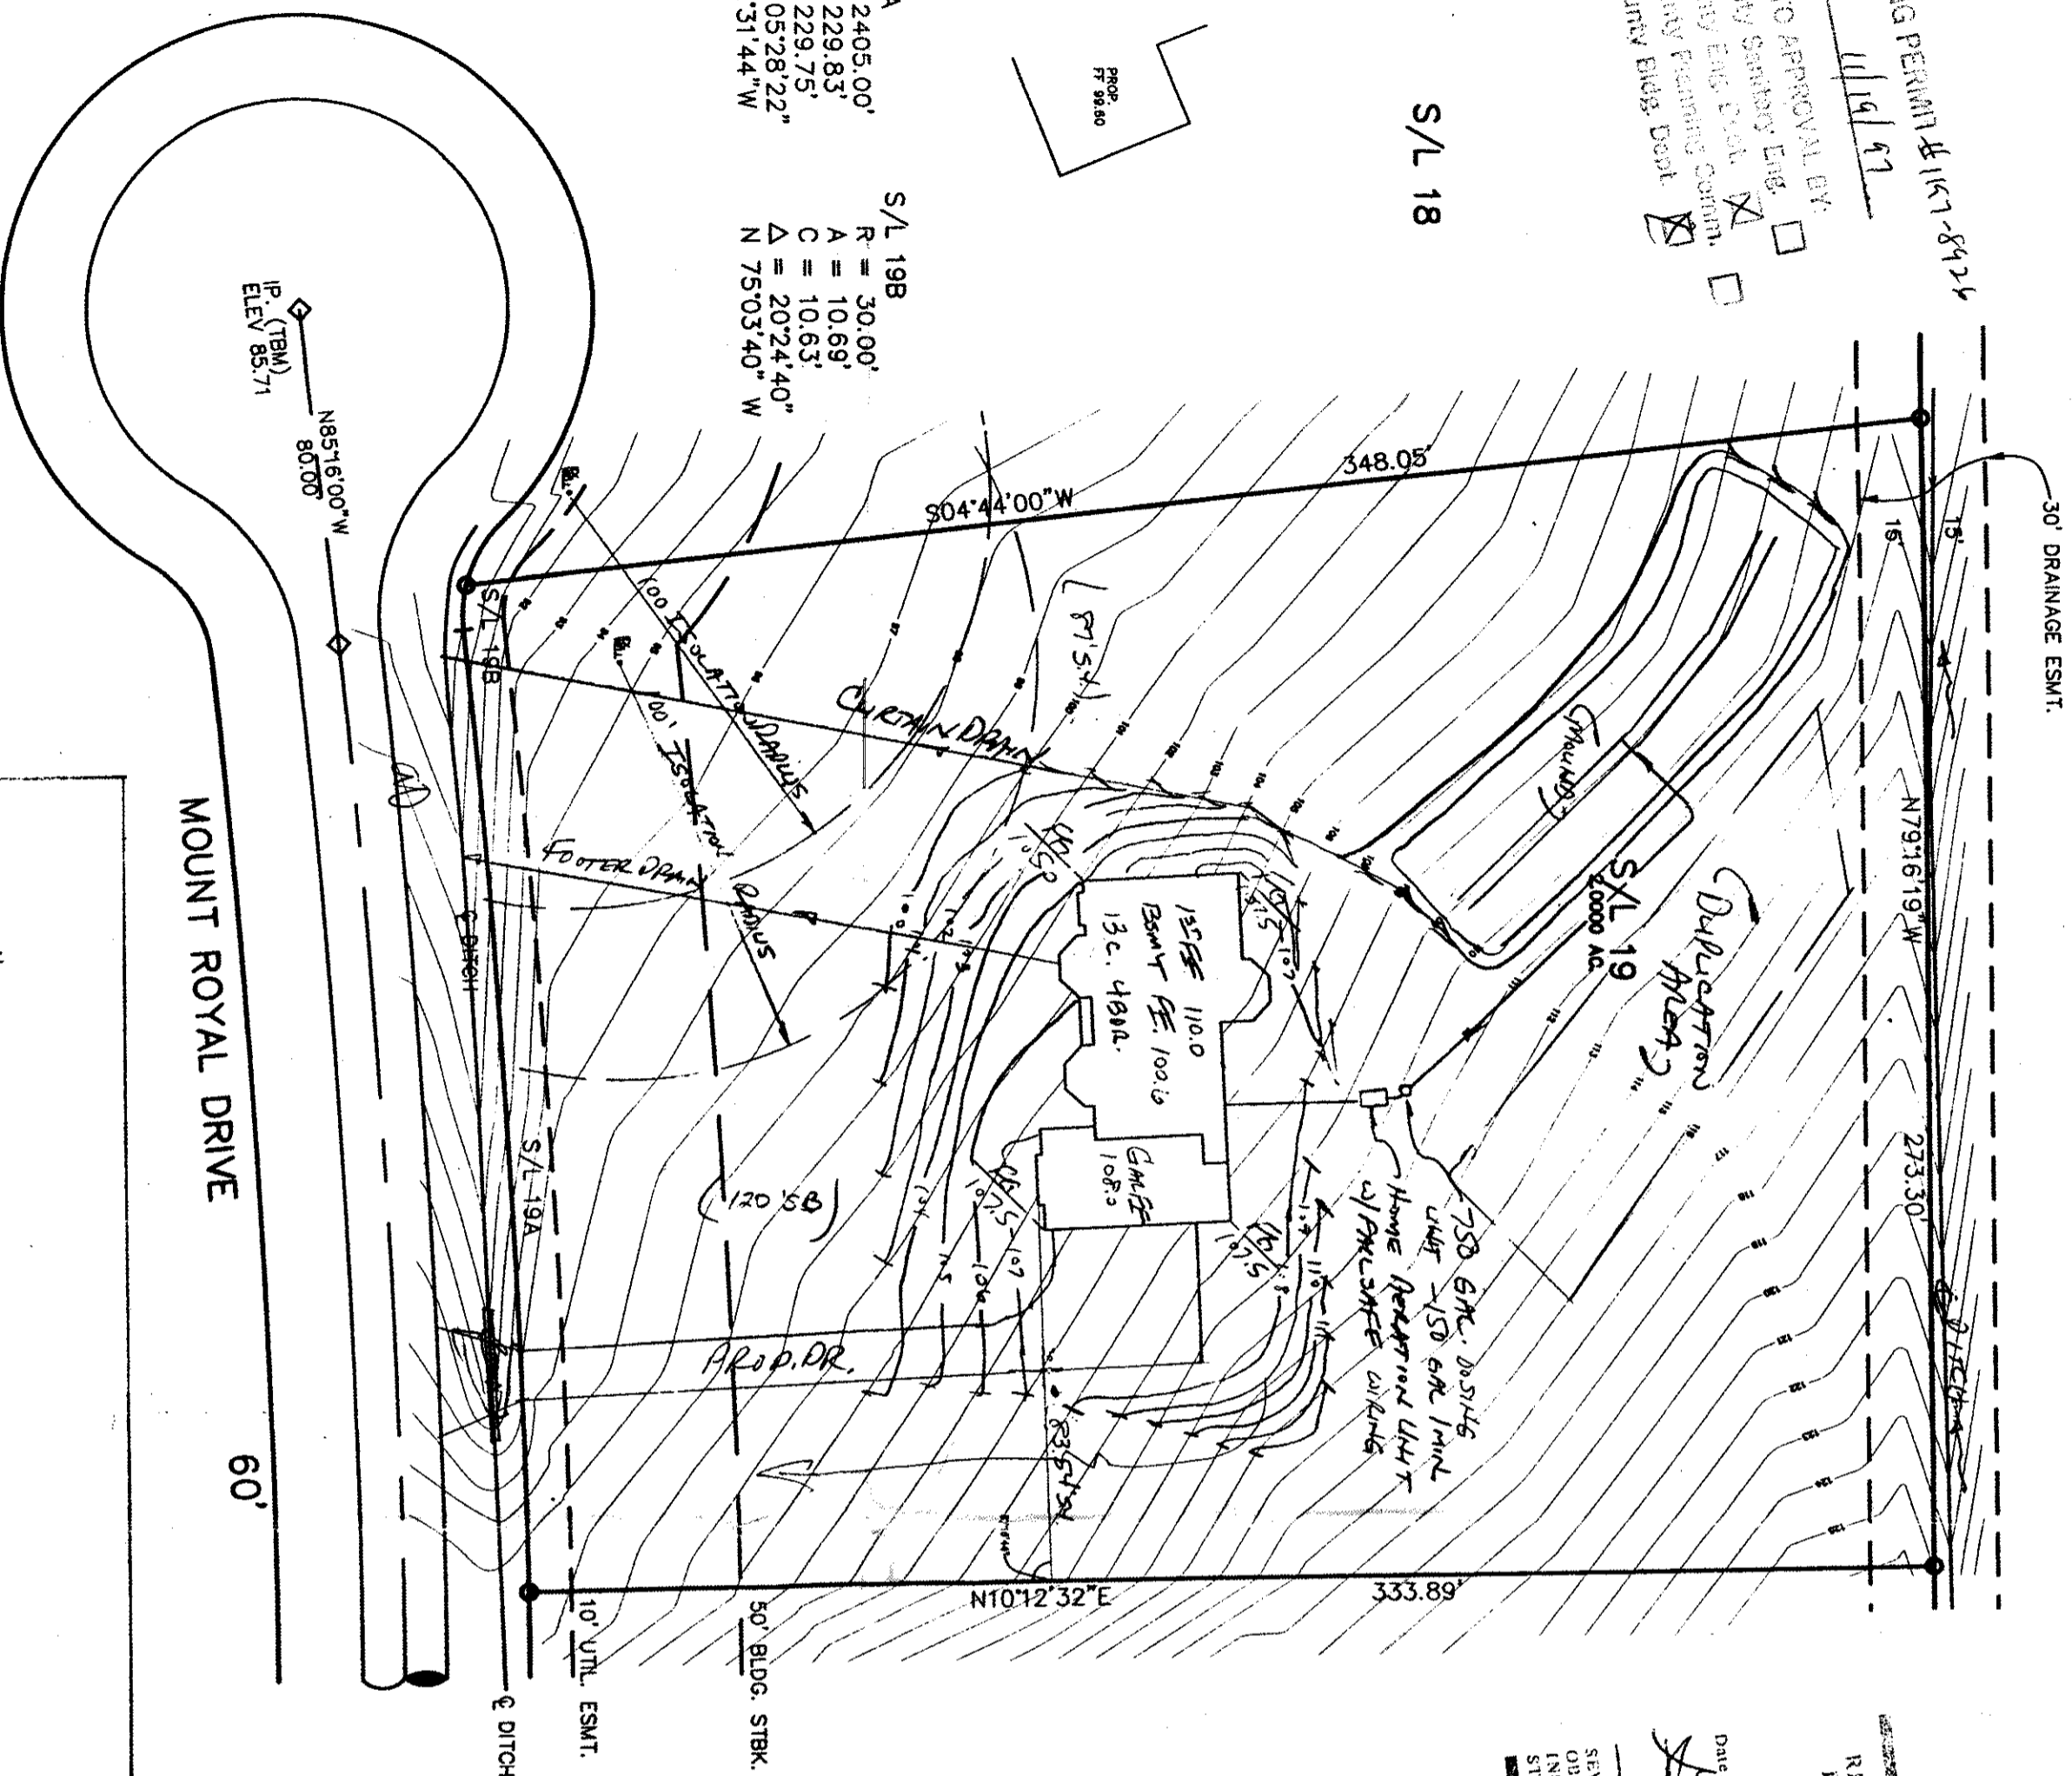

REVIEWED AND ACCEPTED
LAKE COUNTY CORONER
HEALTH DISTRICT

DATE 11-18-97 BY [Signature]
SEWAGE DISPOSAL PERMIT MUST BE
OBTAINED BY A LAKE COUNTY LICENSED
INSTALLER BEFORE INSTALLATION IS
STARTED.

CONCORD TWP., LAKE COUNTY, OHIO

for: KERN BUILDING
CLIENT

ADDRESS	STREET	CITY	ZIP
---------	--------	------	-----

MOUNT ROYAL SUBDIVISION	
SUBDIVISION	NAME
18-18	
VOL.-PG.	
MOUNT ROYAL	
18	
SUBLOT NO.	STREET
LOT	TRACT
VOLUME	PAGE
PERM. PARCEL NO.	STREET

LEGEND

EXIST. ELEV. - 100.0
2 PROP. ELEV. - 100.0

SANITARY MANHOLE ———— ①
 STORM MANHOLE ———— ●
 INLET OR CATCH BASIN ———— ■
 HYDRANT ———— ⊕
 EXISTING CONTOURS ————
 PROPOSED CONTOURS ————

EXIST. ELEV. ——— 100.00 ——— PROP. ELEV.
 AS BUILT ELEVATION
 INDICATES
 DIRECTION OF
 SURFACE DRAINAGE

REMARKS

ALL BOUNDARY DATA SHOWN WAS OBTAINED FROM (DEEDS, RECORDED SUBDIVISION PLAT OR OTHER PUBLIC RECORDS)

LOCATIONS AS SHOWN OF ADJACENT WELLS AND SEPTIC TANKS OBTAINED FROM LAKE COUNTY HEALTH DEPARTMENT

DESIGN CERTIFICATION

THIS PLAT WAS PREPARED BY ME, AND IS CORRECT TO THE BEST OF MY KNOWLEDGE AND BELIEF.

NAME	SURVEYOR	REGISTRATION NO.
13	13	13

CHECK LIST

~~CHECK LIST~~

[illegible]

REVISIONS		
NO.	DATE	BY

PLAN PREPARED BY:

PLAN PREPARED BY:
BABCOCK · JONES & ASSOCIATES, INC.

PAINESVILLE, OHIO

3	DRAWN BY K.S. & T.B.	SCALE 1" = 40'	PHONE NO. 216-357-1811
---	-------------------------	-------------------	---------------------------

4	CHK'D. H.J.	DATE 8/19/97	DRAWING NO.
---	-------------	--------------	-------------

	CREW K.J.	APPO H.J.	93-163-19
5	CHIEF		

1042

"AS BUILT" CERTIFICATION

I, HEREBY CERTIFY THAT THE CIRCLED GRADES ARE EXISTING
FINISH GRADES CHECKED IN THE FIELD ON _____, 19____

AND ARE CORRECT TO THE BEST OF MY KNOWLEDGE AND BELIEF.

REGISTERED SURVEYOR	REG. NO.

TBM--TOP IRON P/N
CENTER OF CUL--DE--SAC
ELEV = 85.71

Grading Plan Approved as shown and/or noted
THOMAS P. GILLES, P.E.
Lake County Engineer

By 6/11 Date 11.20.07

-Stroke as shown

110 72" Drive culvert

105

SCALE: 1":20'

[illegible]