


EVAPORATION - TRANSPIRATION
TRENCH CROSS SECTION

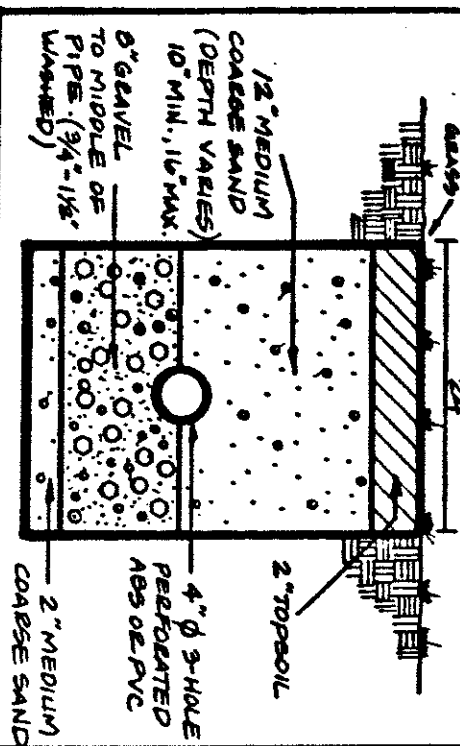

LOW YIELD WATER
FIXTURES REQUIRED
ON ALL
Shower Head
Toilet

SEWAGE DISPOSAL PERMIT MUST BE
OBTAINED BY A LAKE COUNTY LICENSED
INSTALLER BEFORE INSTALLATION IS
STARTED.

- A. To be brought to finished grade
1. Septic tank manhole covers
 2. Splitter box cover
 3. Distribution box cover
- B. No footer drains or downspouts
to be discharged into septic tanks
- C. All waste water to be discharged into
septic tanks

SITE PLAN

662022 TOWNSHIP, LAKE COUNTY, OHIO

for: R.L. Moore Homes

ADDRESS: 11540 CUL-DE-SAC CT, CITY: ZIP:

Owner: R.L. Moore Homes

Subdivision: 2013

LOT: TRACT: VOLUME: PAGE: PERM. PARCEL NO.: STREET:

LEGEND

- SANITARY MANHOLE --- WATER VALVE (GAS) ---
STORM MANHOLE --- WATER METER (GAS) ---
INLET OR CATCH BASIN --- AS BUILT ELEVATION ---
HYDRANT ---
EXISTING CONTOURS ---
PROPOSED CONTOURS ---
EXIST. ELEV. --- 100.0 --- PROP. ELEV. ---
- INDICATES DIRECTION OF SURFACE DRAINAGE

REMARKS

ALL BOUNDARY DATA SHOWN WAS OBTAINED FROM (DEEDS, RECORDED SUBDIVISION PLAT OR OTHER PUBLIC RECORDS)
LOCATIONS AS SHOWN OF ADJACENT WELLS AND SEPTIC TANKS OBTAINED FROM LAKE COUNTY HEALTH DEPARTMENT

DESIGN CERTIFICATION

THIS PLAN WAS PREPARED BY ME, AND IS CORRECT TO THE BEST OF MY KNOWLEDGE AND BELIEF

NAME: SURVEYOR REGISTRATION NO.:

CHECK LIST

NO. OF BEDROOMS	WATER MAIN SIZE, LOCATION
1	SAN. MAIN SIZE, LOCATION
2	SAN. MAIN CAST. ELEV. INV. ELEV.
3	SAN. CONN. SIZE, LOC. DEPTH
4	STORM SEWER SIZE, LOC. DEPTH
5	STORM MH. CAST ELEV. INV. ELEV.
	PAV'T TYPE GRADE CURBS
	GAS LINE LOC. SIZE PRESSURE
	SEPTIC TANK LOCATION & DUPLICATION AREA
	WELL LOCATION
	ISOLATION RADIUS FROM WELL

PLAN PREPARED BY: BABCOCK • JONES & ASSOCIATES, INC. PAINESVILLE, OHIO

NO.	DATE	BY
1		
2		
3		
4		
5		

DRAWN BY: H	SCALE: 1" = 30'	PHONE NO.: 357-1811
CHKD. H	DATE: 1/5/94	DRAWING NO.:
CREW: H	APP'D. H	9313713
CHIEF: H		

"AS BUILT" CERTIFICATION

I, HEREBY CERTIFY THAT THE CIRCLED GRADES ARE EXISTING FINISH GRADES CHECKED IN THE FIELD ON 19 AND ARE CORRECT TO THE BEST OF MY KNOWLEDGE AND BELIEF.

REGISTERED SURVEYOR REG. NO.:

TBM - 788 OF HYDRAULIC CUL-DE-SAC

#0099-778

ZONING PERMIT

ISSUED 4-28-94

SUBJECT TO APPROVAL BY:
☐ Lake County Sanitary Eng.
☐ Lake County Eng. Dept.
☐ Lake County Planning Comm.
☐ Lake County Bldg. Dept.

CUL-DE-SAC

CB412

Name: Reg. No.: