







DESIGNED AND ACCEPTED
BY: COUNTY GENERAL
HEALTH DISTRICT

DON #1197 BY
David B. Jenkins


SEWAGE TREATMENT PLANT PERMIT MUST BE
OBTAINED FROM LAKE COUNTY HEALTH DISTRICT
BEFORE INSTALLATION IS
STARTED

KIRKWOOD
VA. 22040-0000
11-4-97

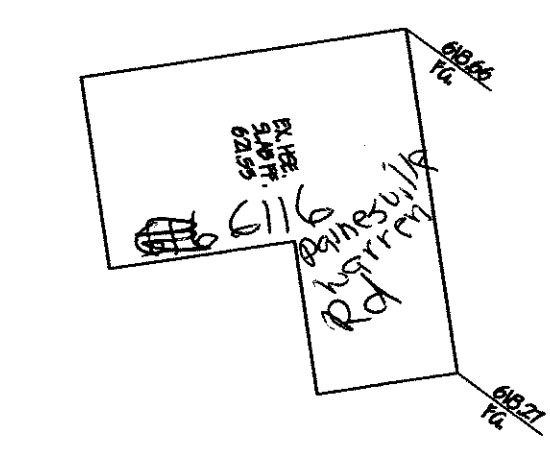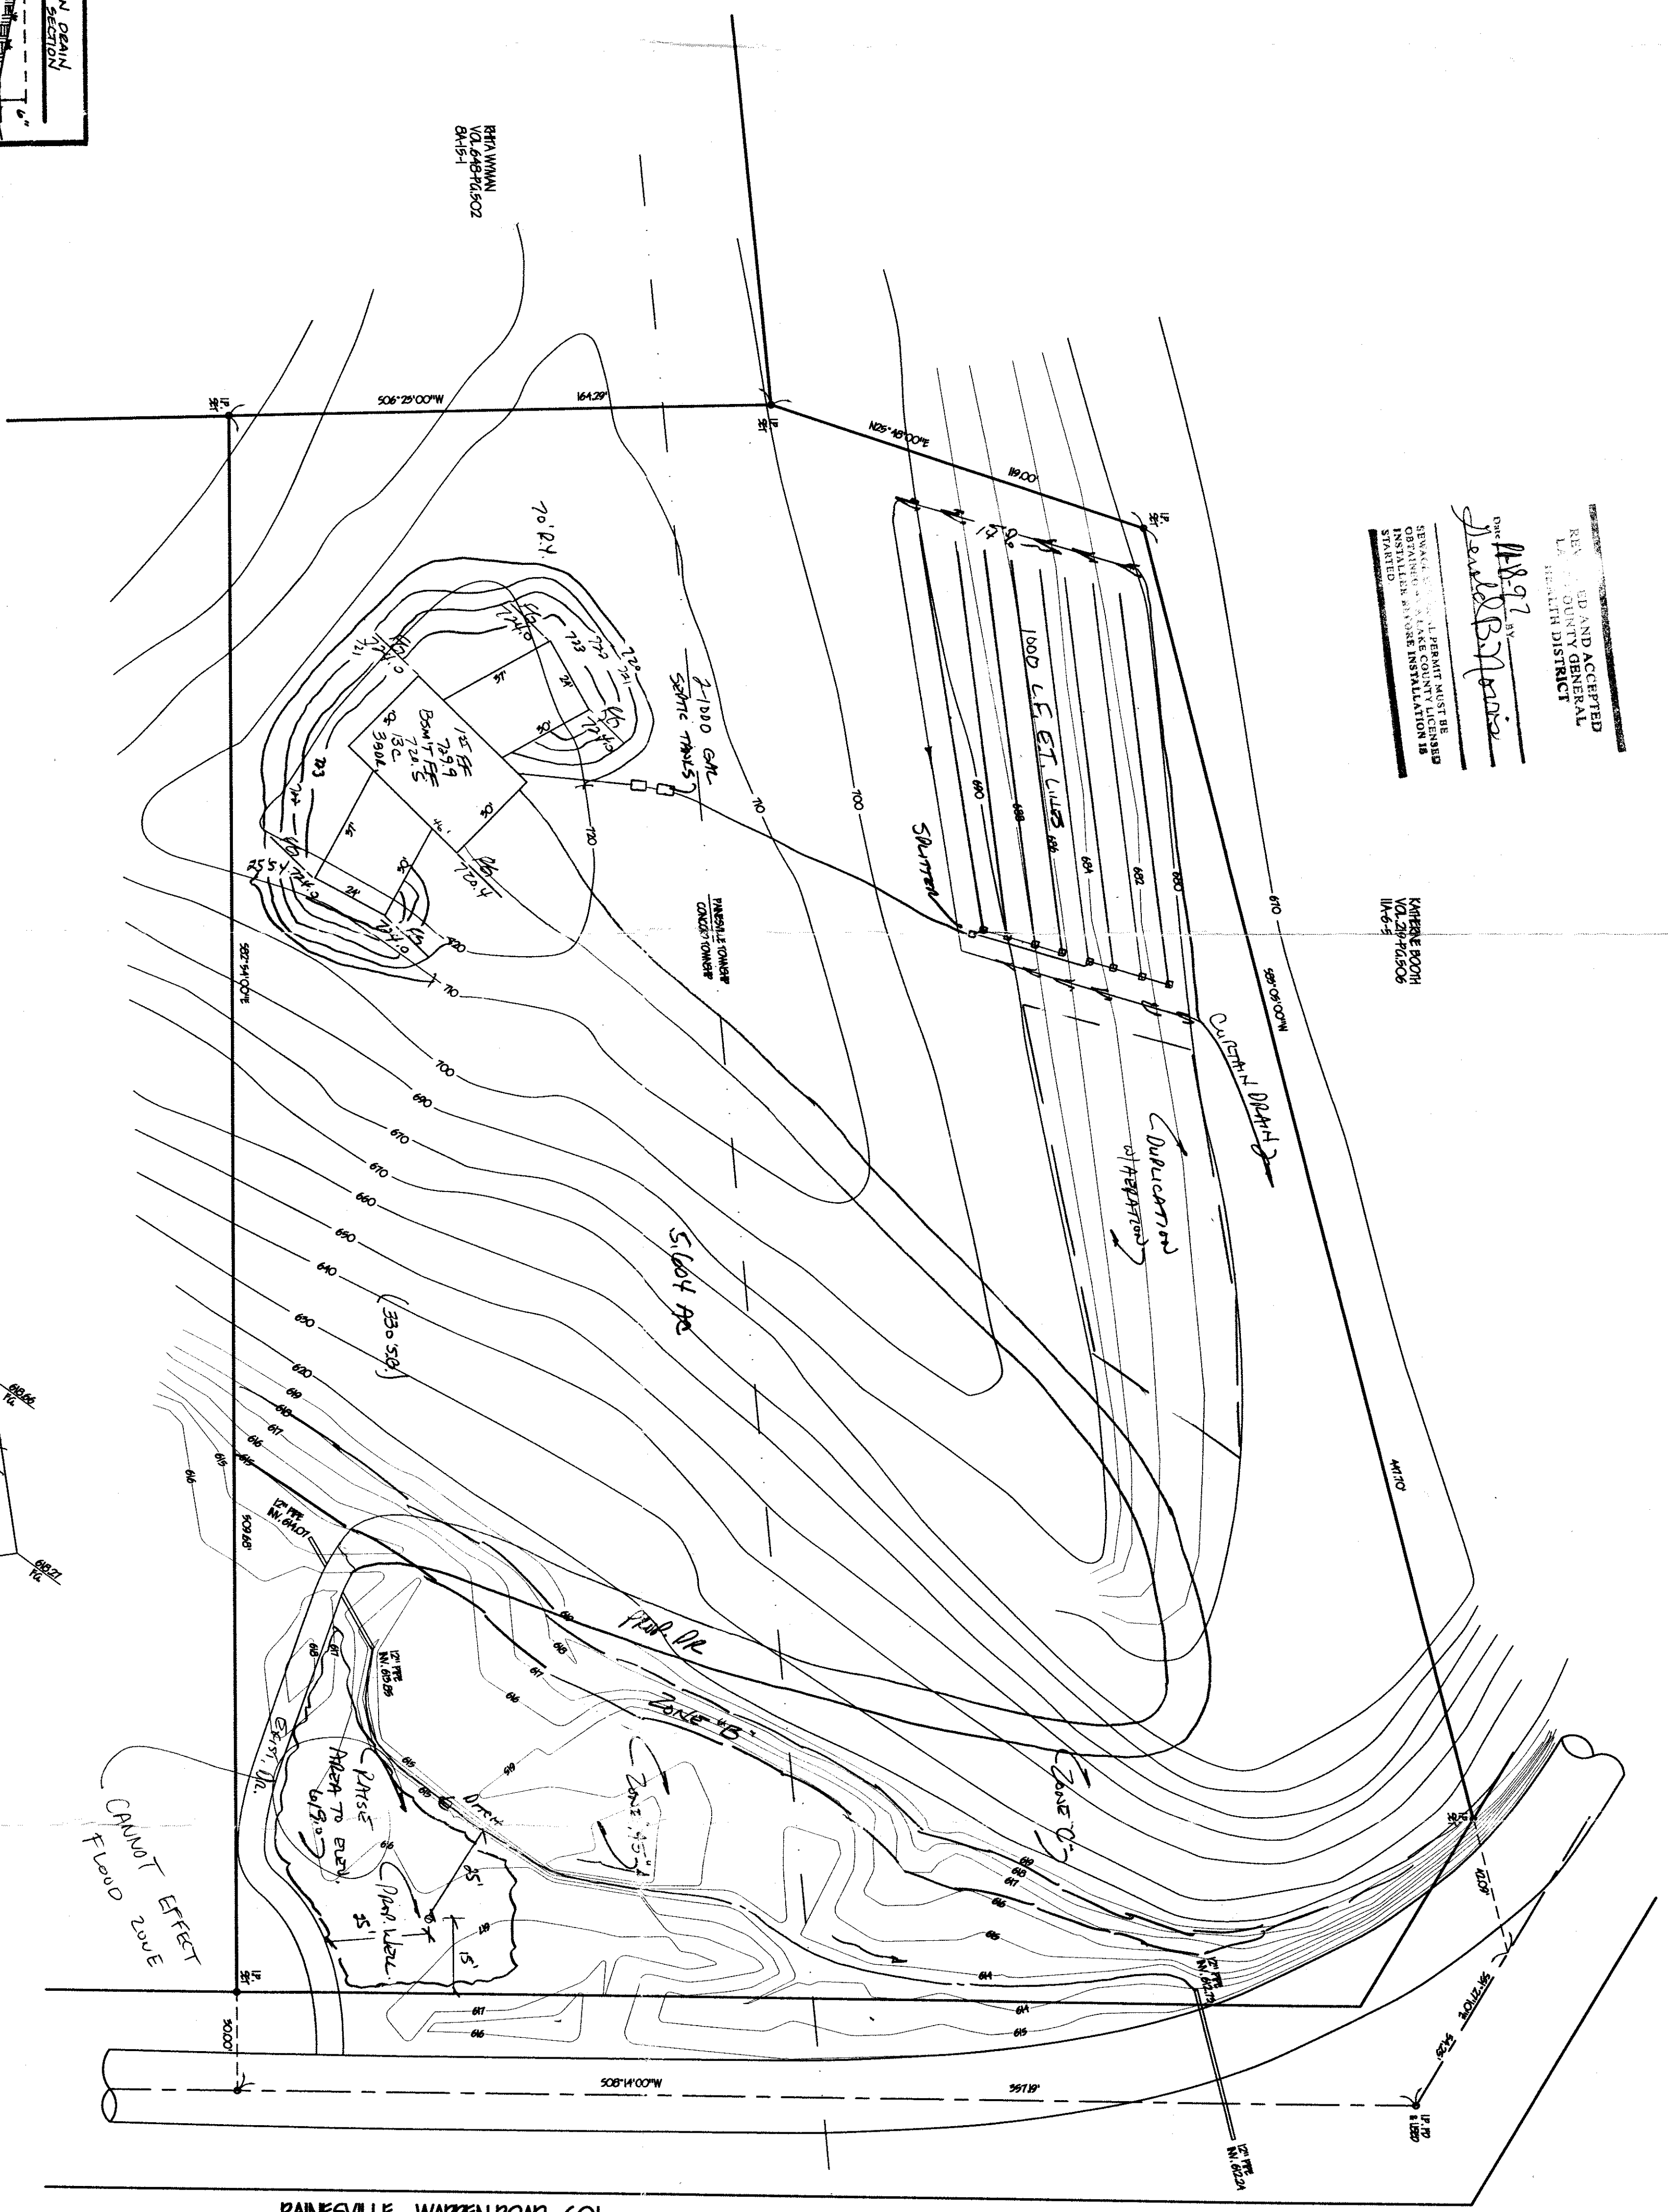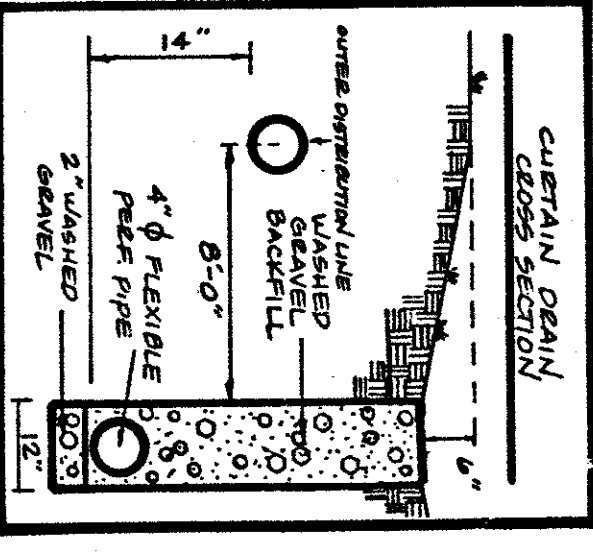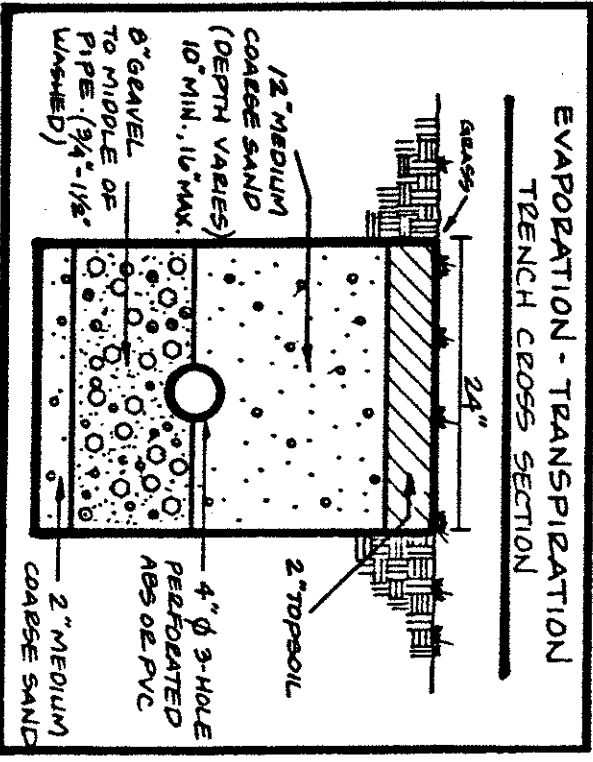

"I, the undersigned, hereby certify that this topography, located by 6", 1" or 2" contours, and elevations shown hereon represent an original and true survey made by me on the 11/29/97. All elevations were taken at appropriate intervals and that as of that date they existed as indicated hereon."

Kevin Keach
Reg. No. #1313

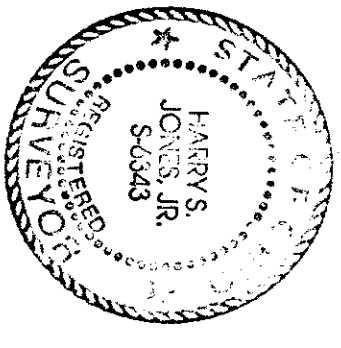

ZONING PERMIT #1197-8927
ISSUED 11/21/97
SUBJECT TO APPROVAL BY:
Lake County Sanitary Eng. ☐
Lake County Eng. Dept. ☒
Lake County Planning Comm. ☐
Lake County Sdg. Dept. ☒

Grading Plan As
as shown and/or
THOMAS P. GILLES, P.E.
Lake County Engineer

By *W.H.* Date 11/24/97
Cannot fill Flood Zone

REV. NO.	DESCRIPTION	DATE	BY	CHK'D
1	REVISED (see last sheet)	11-11-97	TK	TK

DATE	10/29/97
DESIGN BY	H.J.
DRAWN BY	TK
APPROVED BY	H.J.

SITE PLAN FOR: KEVIN KEACH	SCALE 1" = 30' JOB NO. 96-086 SHEET 7 OF 1
----------------------------------	---

CONCORD / PAINESVILLE TOWNSHIP	LAKE COUNTY
--------------------------------	-------------

babcock
BABCOCK, JONES AND ASSOCIATES, INC.
CIVIL ENGINEERS - SURVEYORS - LAND PLANNERS
PAINESVILLE OHIO 44077