

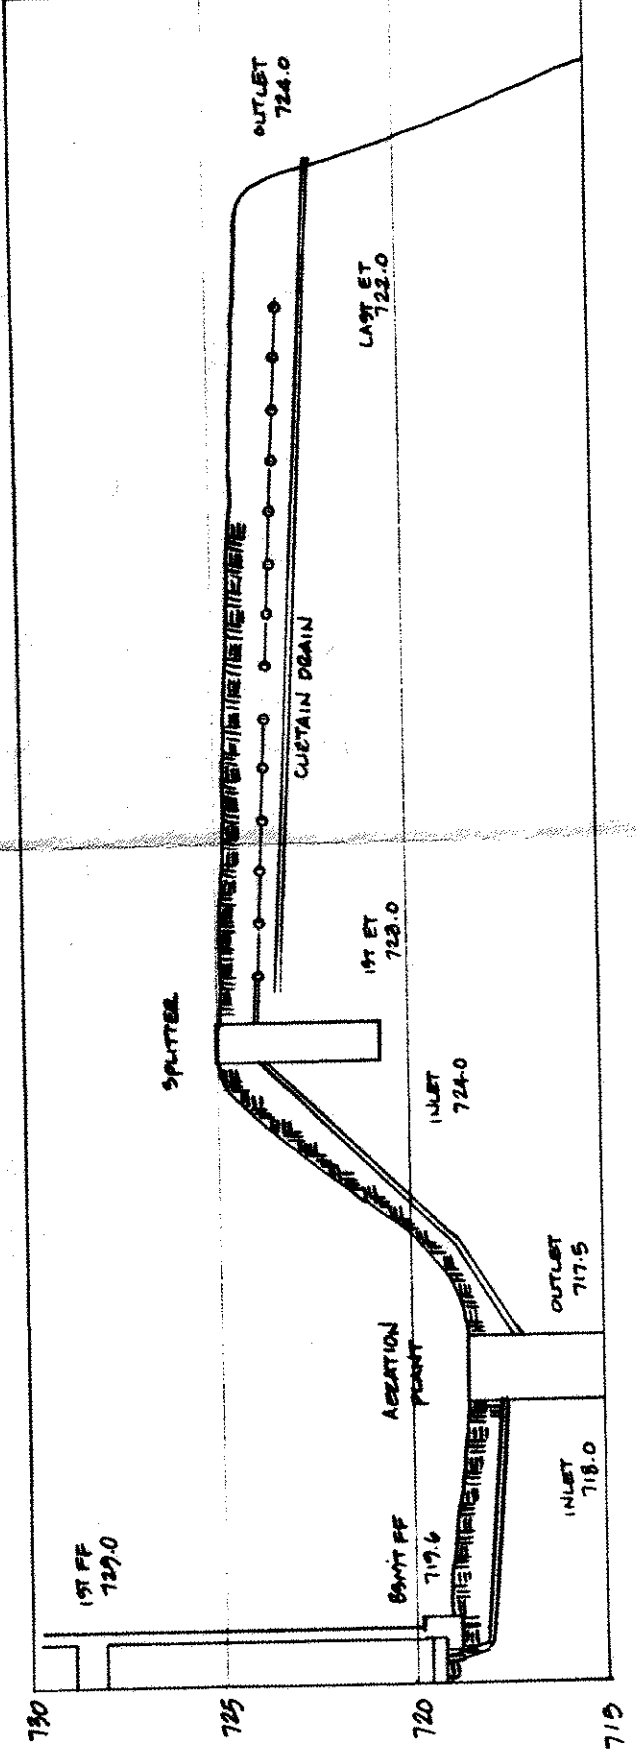


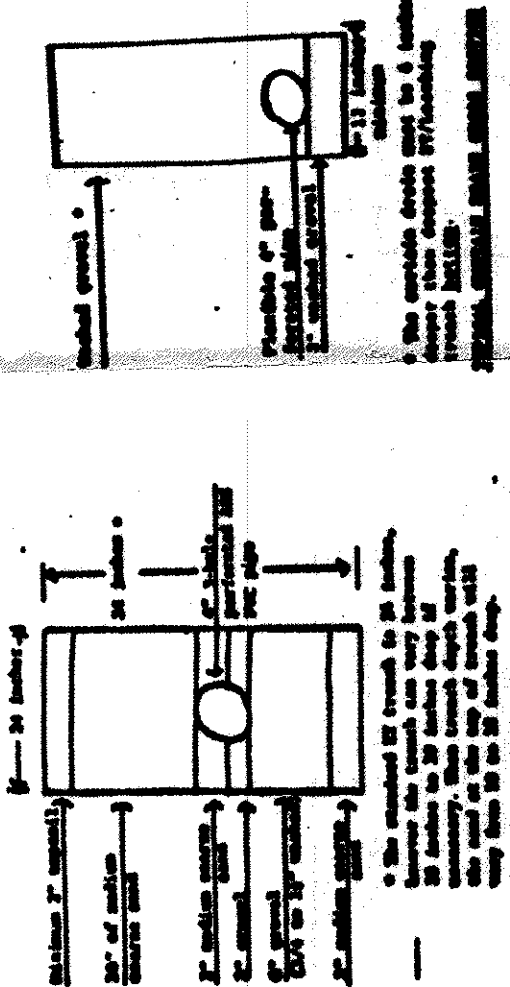

HYDRAULIC PROFILE
SCALE: HORIZ. 1"=30', VERT. 1"=3'

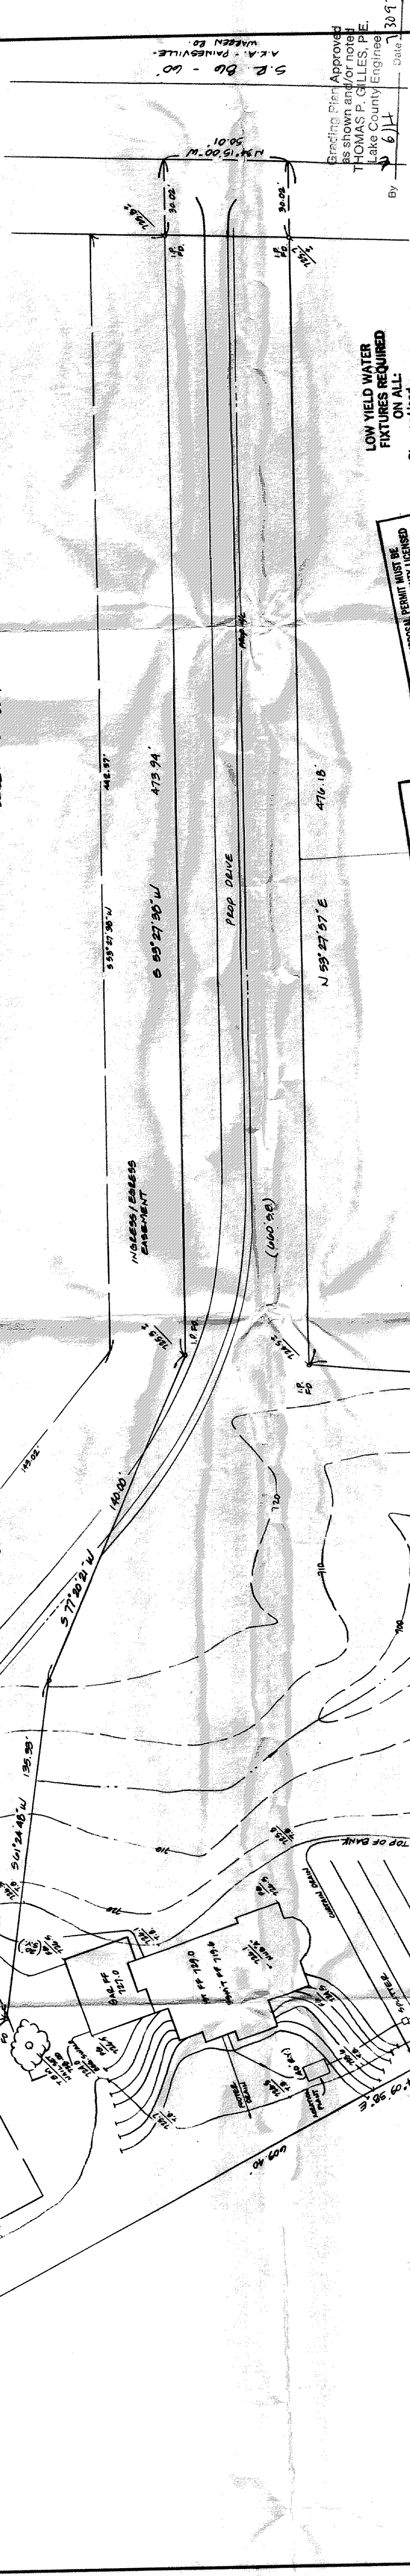

GRAND LODGE POINTE
VOL. 5 - PG. 15
7-28-93
JOEL LUCAS, S. E. & P. H.
Health Commissioner
Reviewed and Accepted


SEWAGE DISPOSAL PERMIT MUST BE OBTAINED A LATE COUNTDOWN INSTALLER BEFORE INSTALLATION IS STARTED.

LOW YIELD WATER FIXTURES REQUIRED ON ALL:
Shower Head
Toilet

- To be brought to finished grade
1. Septic tank cover
 2. Sifters on tank cover
 3. 5" pipe on tank cover
- B. No toilet drains or downspouts to be discharged into septic tanks
C. All waste water to be discharged into septic tanks


ZONING PERMIT #0793-7587
ISSUED 7-29-93

SUBJECT TO APPROVAL BY:
☐ Lake County Sanitary Eng.
☒ Lake County Eng. Dept.
☐ Lake County Planning Comm.
☒ Lake County Bldg. Dept.

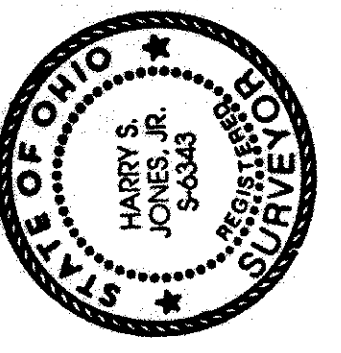

"I, the undersigned hereby certify that this topography indicated by 5', 1 or 2 contours, and elevations shown hereon represent the actual ground surface as shown by the 25' day of July 1993 and that the elevations were taken at appropriate intervals and that as of that date they existed as indicated hereon."

Harry S. Jones, Jr.
#6343
Eng. No.

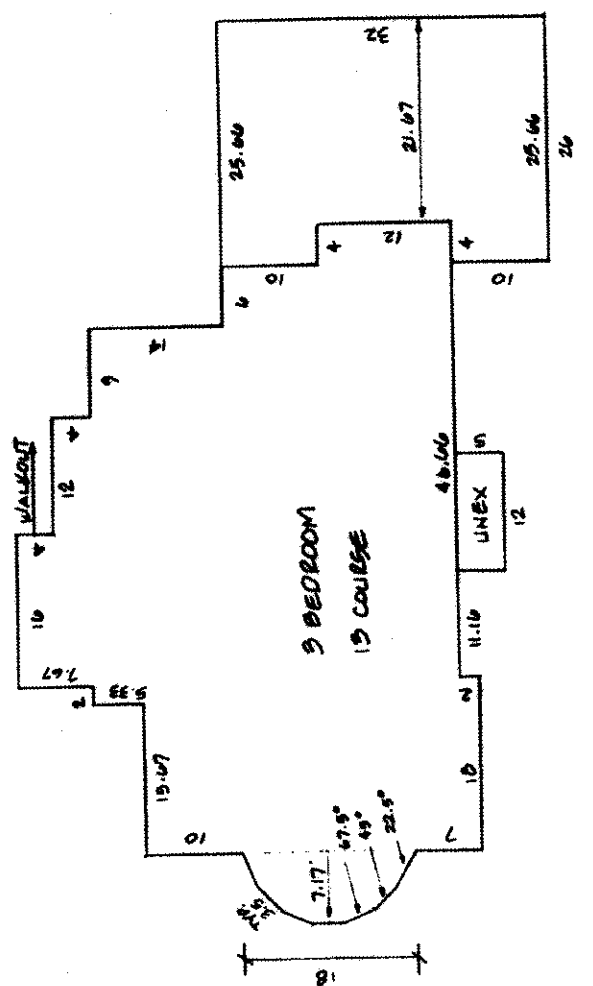

FOUNDATION DIMENSIONS

SITE PLAN FOR J. W. BETTELEY BUILDING INC

REV. NO.	DESCRIPTION	DATE	BY	CHKD.

DATE	7-9-93
DESIGN BY	HT
DRAWN BY	X
APPROVED BY	HT

SCALE	1"=30'
JOB NO.	93-107
SHEET	OF 1

BEING A PART OF LOT 16, TRACT 1 & LOT 5, TRACT 2
VOL 595-PG. 1025 PPA 8A-11-30
CONCORD TOWNSHIP - LAKE COUNTY - OHIO

Bj BABCOCK, JONES AND ASSOCIATES, INC
CIVIL ENGINEERS - SURVEYORS - LAND PLANNERS
PANESVILLE OHIO 44077