



HYDRAULIC PROFILE
VERTICAL SCALE 1"=5' HORIZONTAL SCALE 1"=20'

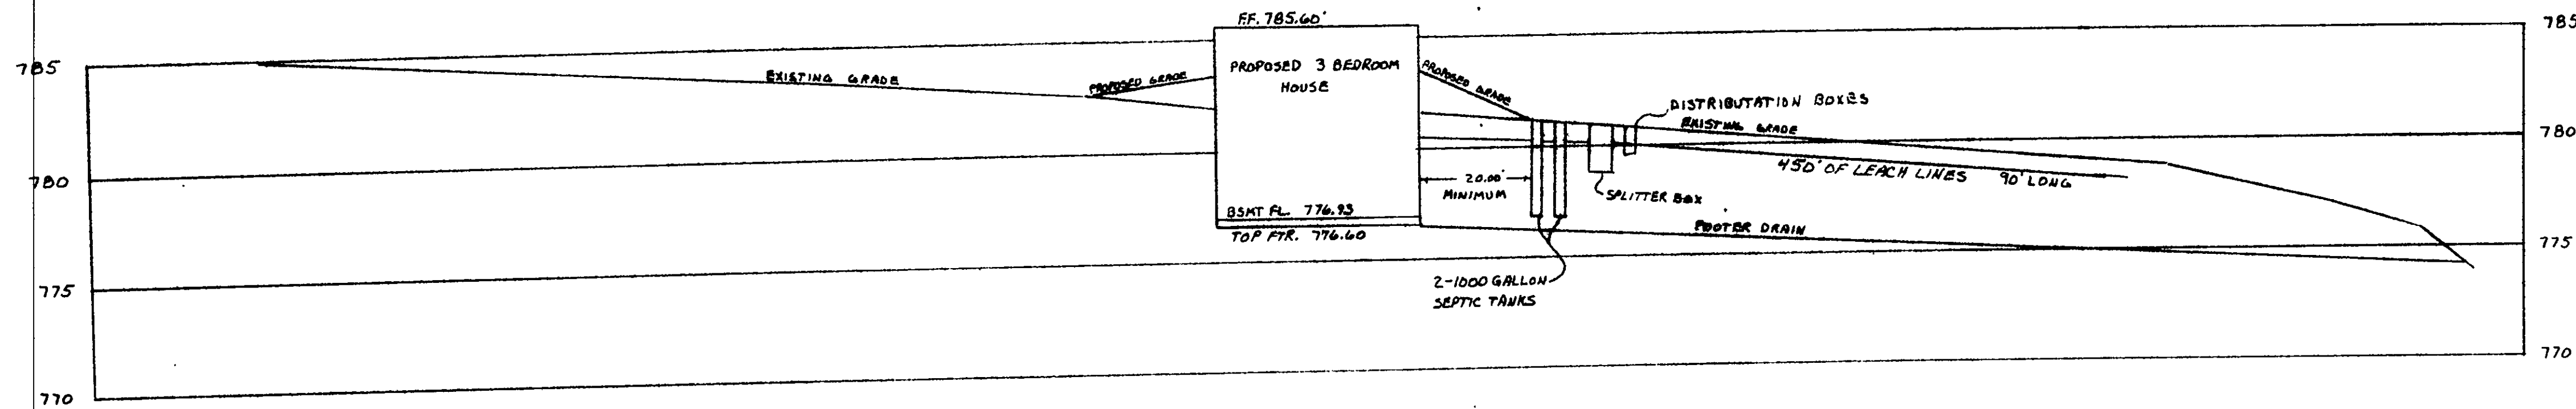

REVIEWED AND ACCEPTED
LAKE COUNTY GENERAL
HEALTH DISTRICT

7-27-98
Dated: 7-27-98
S. M. Starnets

SEWAGE DISPOSAL PERMIT MUST BE
OBTAINED BY A LAKE COUNTY LICENSED
INSTALLER BEFORE INSTALLATION IS
STARTED.

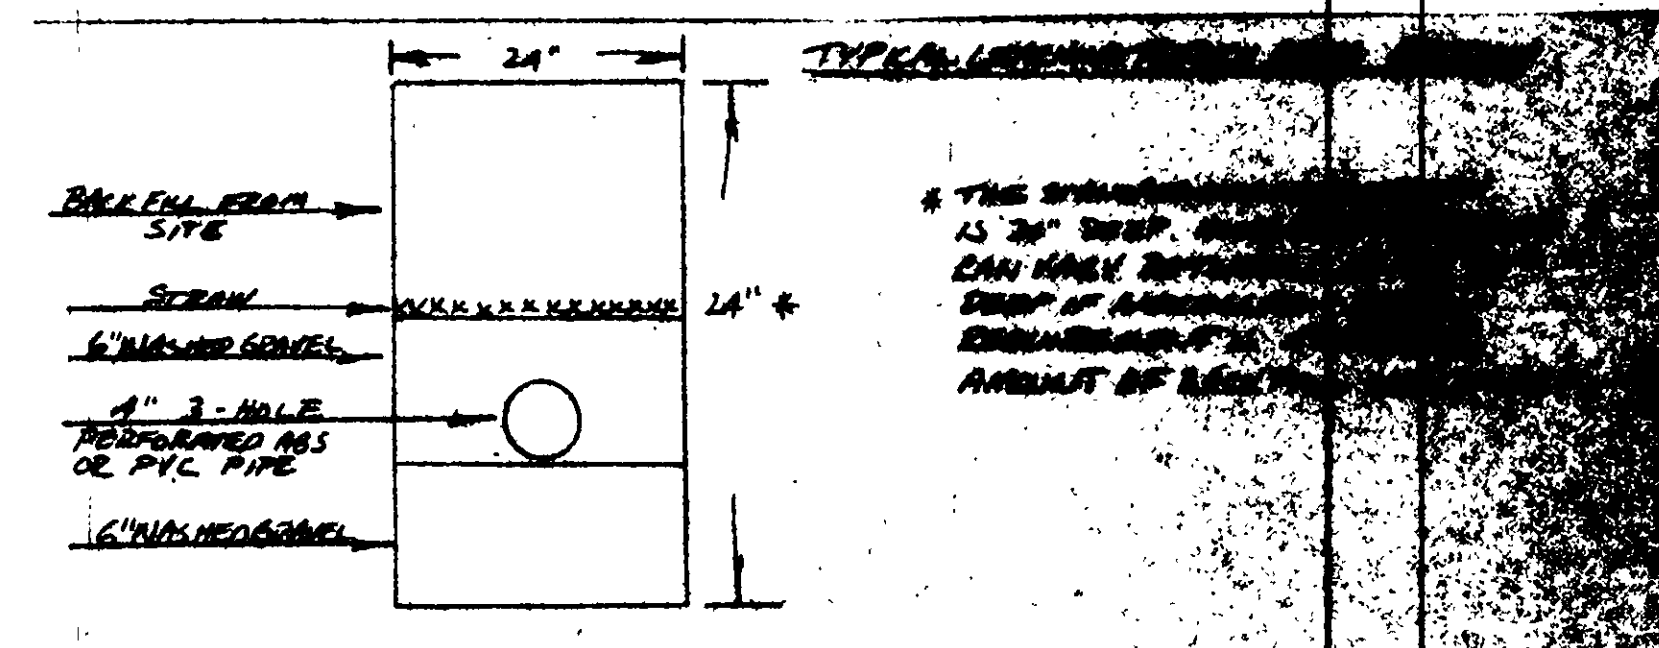

- NOTES
1. HOUSE TO BE EQUIPPED WITH WATER SAVING FIXTURES.
 2. DOWNSPOUTS MUST BE DIRECTED AWAY FROM THE SEWAGE SYSTEM.
 3. MANHOLES ON SEPTIC TANKS, SPLITTER BOX AND DISTRIBUTION BOXES MUST BE BROUGHT UP TO GRADE.
 4. NO TREES ARE PERMITTED IN THE SEWAGE DISPOSAL AREA.
 5. FOOTER TO REST ON VIBRUM SOIL.
 6. TWO 1000 GALLON SEPTIC TANKS IN SERIES.
 7. 450' OF LEACH LINES.
 8. LOT NO. 36, TRACT 4 LAKE COUNTY.

Grading Plan Approved
as shown and/or noted
THOMAS P. GILLES, P.E.
Lake County Engineer

By 614 Date 8-3-98

LEGEND

EXISTING ELEVATION
PROPOSED ELEVATION

I WILLARD F. SCHADE HEREBY CERTIFY THAT THE TOPOGRAPHY SHOWN HEREON, INDICATED BY ONE FOOT BENCHMARKS AND ELEVATIONS REPRESENTS AN ACTUAL FIELD TOPOGRAPHIC SURVEY MADE BY ME ON THE 17 DAY OF JUNE, 1998 AND THAT THE ELEVATIONS WERE TAKEN AT APPROPRIATE INTERVALS AND THAT AS OF THAT DATE THEY EXISTED AS INDICATED HEREON.


I ALSO CERTIFY THAT I PERFORMED A BOUNDARY SURVEY THAT MEETS OR EXCEEDS THE MINIMUM STANDARDS FOR BOUNDARY SURVEYS IN THE STATE OF OHIO.

Willard F. Schade
WILLARD F. SCHADE JR., P.S.



SCHADE SURVEYING 1043 ERIE STREET WILLOUGHBY, OHIO	COMPANY 1440 95TH AVE N P.O. BOX 100 PINEHILL ROAD LAKE COUNTY, OHIO 44132
SEPTIC SYSTEM AND SITE PLAN SURVEY	DATE 7-1-98
FOR: ALBERT AND MARIE PERRICO CONCORD, OHIO LAKE COUNTY	APPROVED BY [Signature]

2 WORKING DAYS
BEFORE YOU DIG
CALL TOLL FREE 800-362-2784
OHIO UTILITIES PROMOTION BOARD

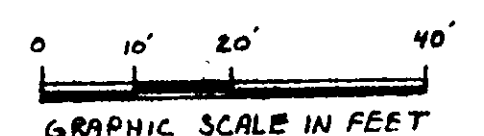

S/L 5

S/L 6

S/L 7

WYNDTREE SUBDIVISION
VOL. 9 PG. 8 & 9-1
LAKE COUNTY RECORD OF PLATS

A. JUHASZ
VOL. 548 PG. 754 P.P.N. 8A-30C-03
6-19-90 L.C.O.R.

R. M. STARNETS
VOL. 694 PG. 278
6-12-68 L.C.O.R.D.
P.P.N. 8A-30C-02

ADJOINERS
HOUSE
F.F. 785.68