


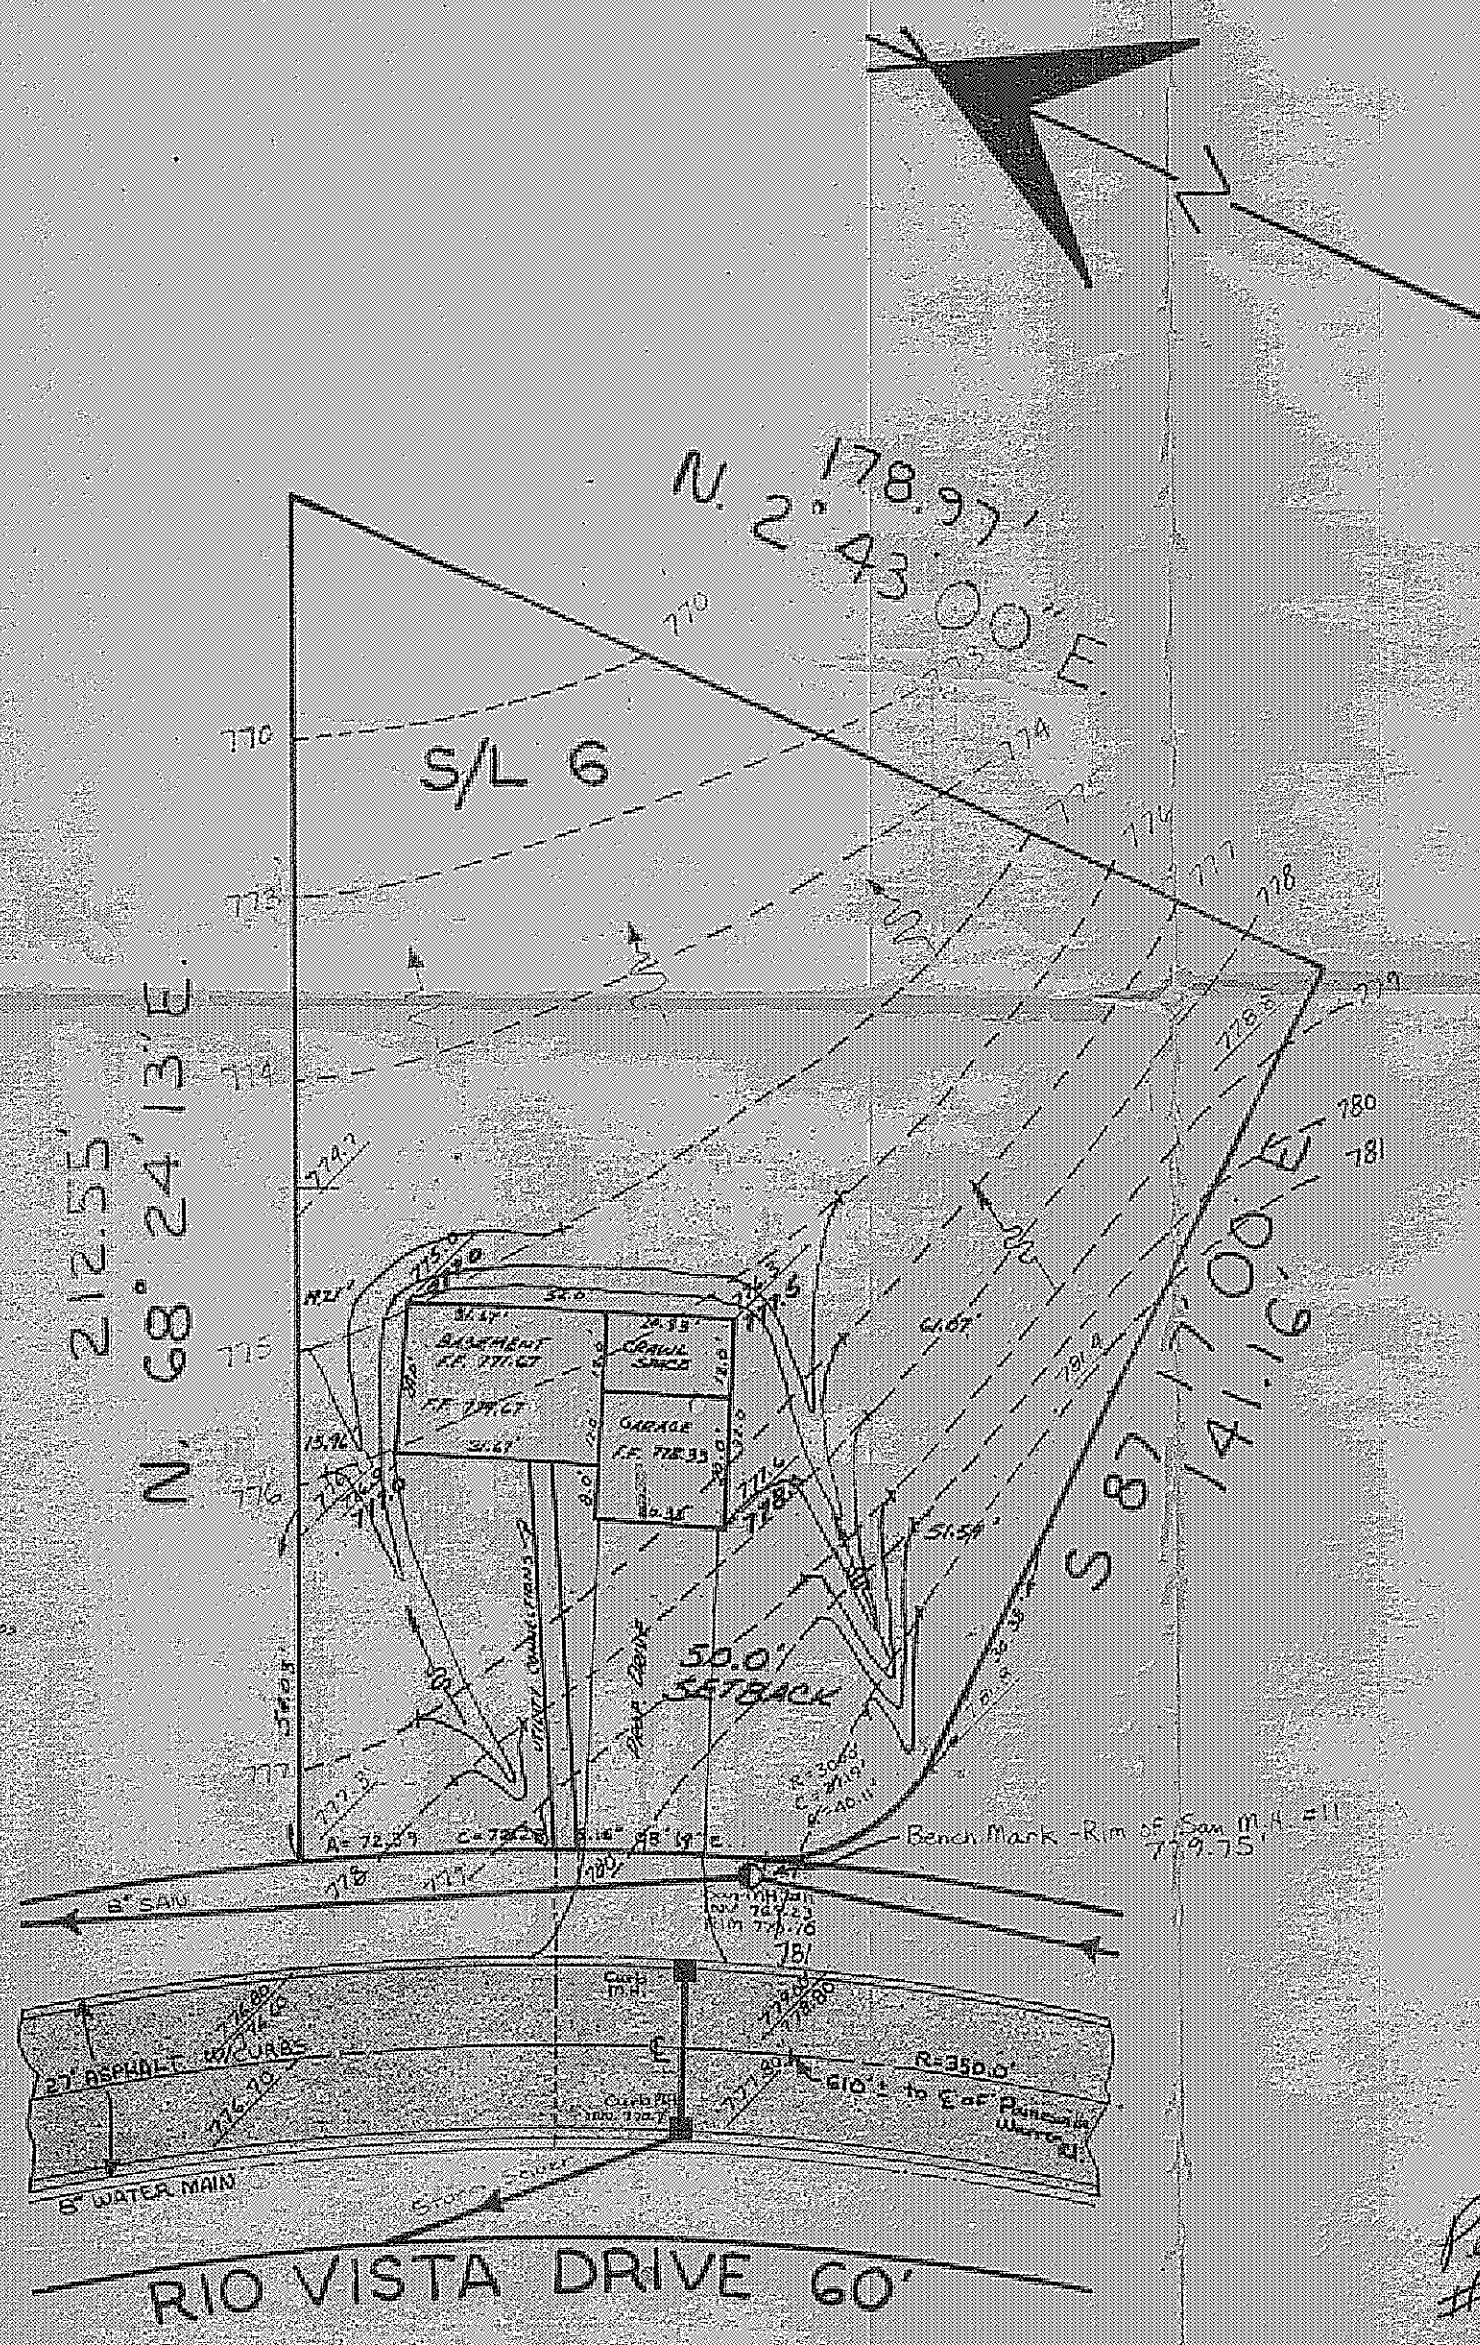

SITE PLAN			
CONCORD		LAKE COUNTY, OHIO	
TOWNSHIP			
for: RYAN HOMES		CLIENT OWNER	
ADDRESS		STREET	CITY ZIP
RIO GRANDE			
SUBDIVISION	NAME	LOT	TRACT
6	RIO VISTA	VOLUME	PAGE
SUBLOT NO.	STREET	PERM. PARCEL NO.	STREET
LEGEND			
SANITARY MANHOLE		WATER VALVE (GAS)	
STORM MANHOLE		WATER METER (GAS)	
INLET OR CATCH BASIN		AS BUILT ELEVATION	
HYDRANT		INDICATES DIRECTION OF SURFACE DRAINAGE	
EXISTING CONTOURS			
PROPOSED CONTOURS			
EXIST. ELEV. 100.0		PROP. ELEV. 100.0	
REMARKS			
ALL BOUNDARY DATA SHOWN WAS OBTAINED FROM (DEEDS, RECORDED SUBDIVISION PLAT OR OTHER PUBLIC RECORDS)			
LOCATIONS AS SHOWN OF ADJACENT WELLS AND SEPTIC TANKS OBTAINED FROM LAKE COUNTY HEALTH DEPARTMENT			
DESIGN CERTIFICATION			
THIS PLAT WAS PREPARED BY ME, AND IS CORRECT TO THE BEST OF MY KNOWLEDGE AND BELIEF.			
NAME		SURVEYOR	REGISTRATION NO.
CHECK LIST			
NO. OF BEDROOMS		WATER MAIN SIZE, LOCATION	
DIMENSIONS		SAN. SEWER SIZE, % GR. LOC.	
BEARINGS		SAN. MH. CAST ELEV. INV. ELEV.	
TIE TO NEAREST STREET		SAN. CONN. SIZE, LOC. DEPTH	
SUBLOT NO. PARCEL NO.		STORM SEWER SIZE, % GR. LOC.	
SURROUNDING OWNERS		STORM MH. CAST ELEV. INV. ELEV.	
BLDG. DIMENSIONS FIN. GR.		PAV'T. TYPE, GRADE, CURBS	
BLDG. TIES FLR. GRADES		GAS LINE LOC. SIZE, PRESSURE	
APRON TYPE, WIDTH, THICKNESS		SEPTIC TANK LOCATION & DUPLICATION AREA	
SIDEWALK TYPE, WIDTH, THICKNESS		WELL LOCATION	
CULVERT TYPE DIA., LENGTH		ISOLATION RADIUS FROM WELL	
ROCK OUTCROPPINGS			
REVISIONS		PLAN PREPARED BY:	
NO.	DATE	BY	DEBEVEC, SALO & ASSOCIATES, INC.
1	6-27-77	D.V.	PAINESVILLE, OHIO
2			
3			
4			
5			
DRAWN BY Joe Rygielski		SCALE 1" = 38'	PHONE NO. 325-7250
CHK'D		DATE 6-9-77	DRAWING NO. 4701-6
CREW CHIEF		APP'D.	

"AS BUILT" CERTIFICATION
I, HEREBY CERTIFY THAT THE CIRCLED GRADES ARE EXISTING FINISH GRADES CHECKED IN FIELD ON 19 BY SURVEYING AND ARE CORRECT TO THE BEST OF MY KNOWLEDGE AND BELIEF.

REGISTERED SURVEYOR REG. NO.

ZONING PERMIT

Permit #3301 Approved 6-29-77
H. E. van Buren

Grading Plan Approved as shown and/or noted THOMAS P. GILLES, P.E. Lake County Engineer By A.J.L. Date 7/1/77