


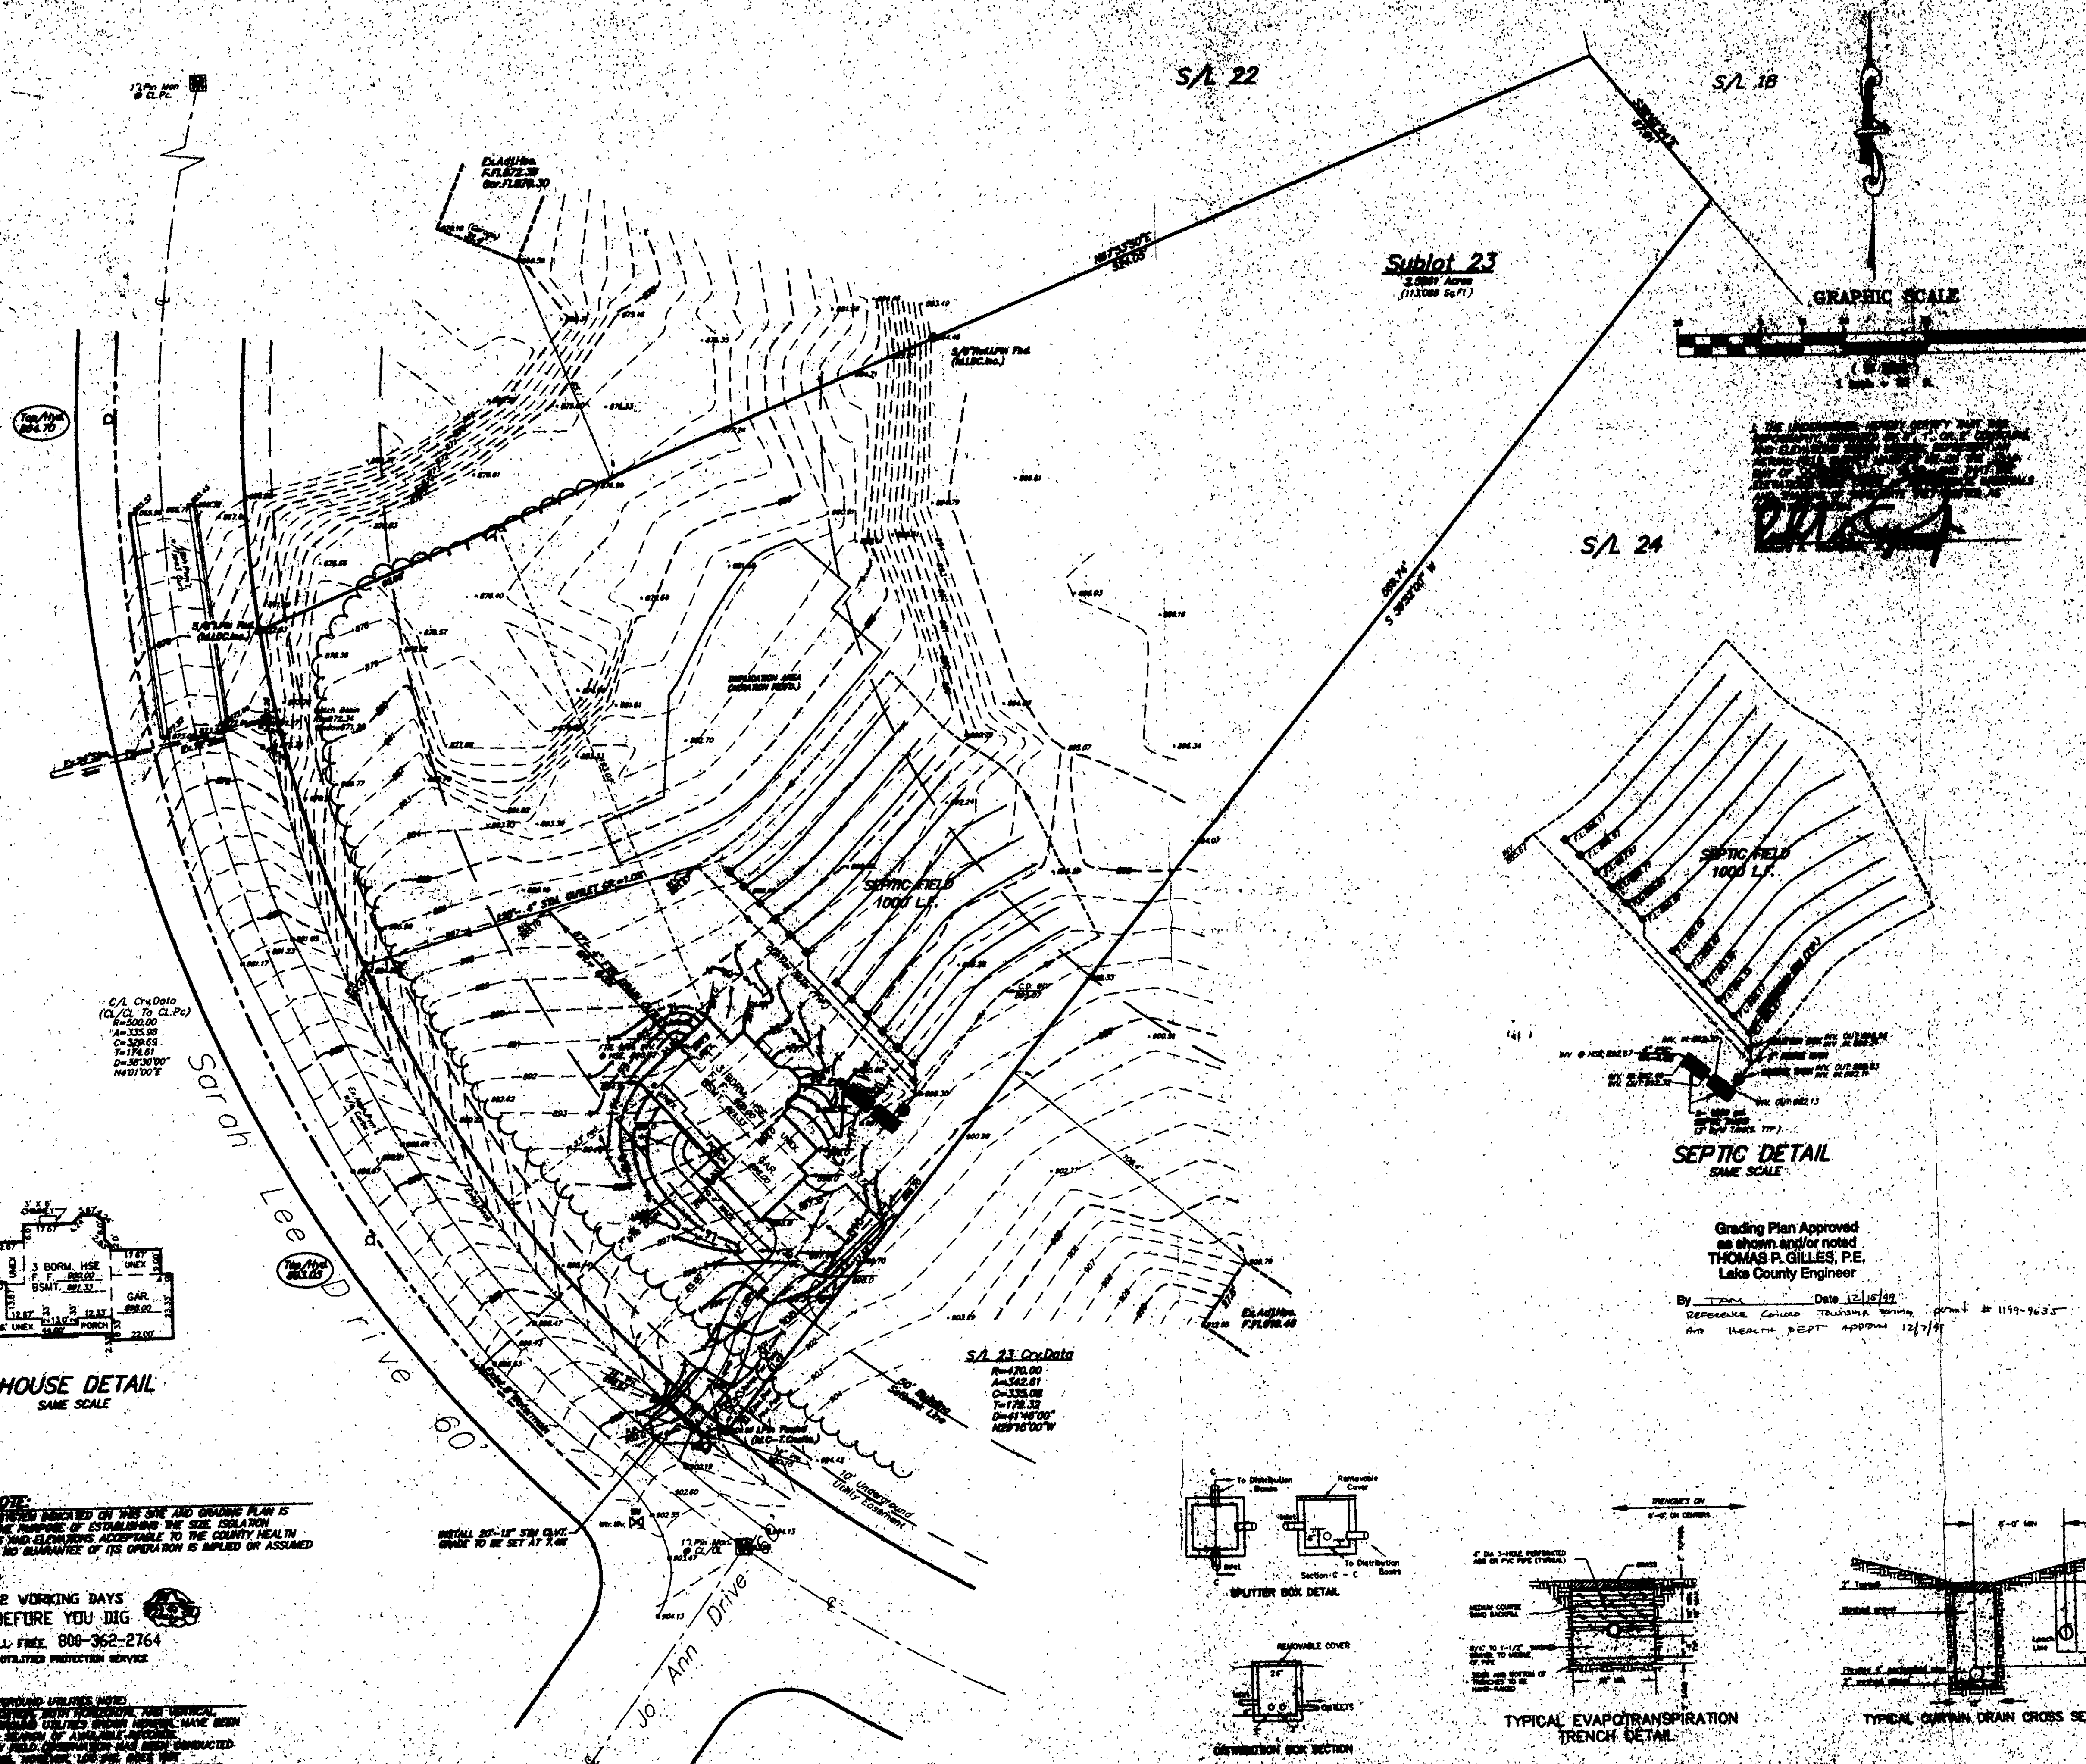


SITE PLAN

For: **OWNERS**

P.O. **NO. 1234**

DATE: **12/15/99**

BY: **THOMAS P. GILLES, P.E.**

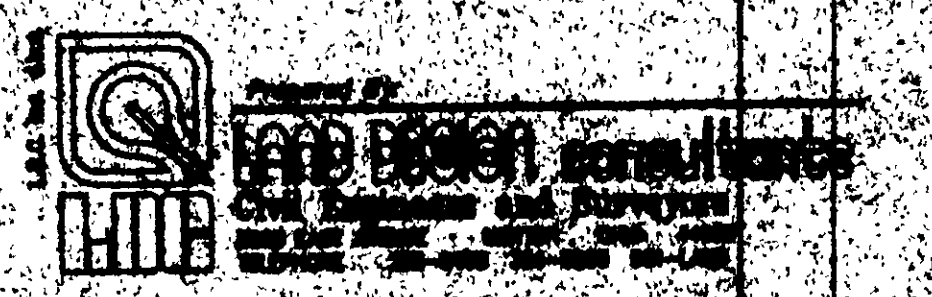

DESIGN CERTIFICATION

THIS PLAN WAS PREPARED BY ME OR UNDER MY CLOSE PERSONAL SUPERVISION AND I AM A duly Licensed Professional Engineer in the State of Illinois.

Thomas P. Gilles 12/15/99

CHECK LIST

☒ 1. All required permits have been obtained.	
☒ 2. All required fees have been paid.	


"AS BUILT" CERTIFICATION

I HEREBY CERTIFY THAT THE CONSTRUCTION OF THIS SEPTIC SYSTEM WAS IN ACCORDANCE WITH THE DESIGN AND IS CORRECT TO THE BEST OF MY KNOWLEDGE AND BELIEF.


LEGEND

SEPTIC FIELD	1" = 30'-0"
SEPTIC TANK	DATE: Oct. 1999
SEPTIC DETAIL	1. NO ADJUSTMENT FOR ADJUSTMENT
SEPTIC DETAIL	2. NO ADJUSTMENT FOR ADJUSTMENT

BENCHMARK: B.M. = T.E.M.'s Set On Top Of Hydrant Located As Noted.

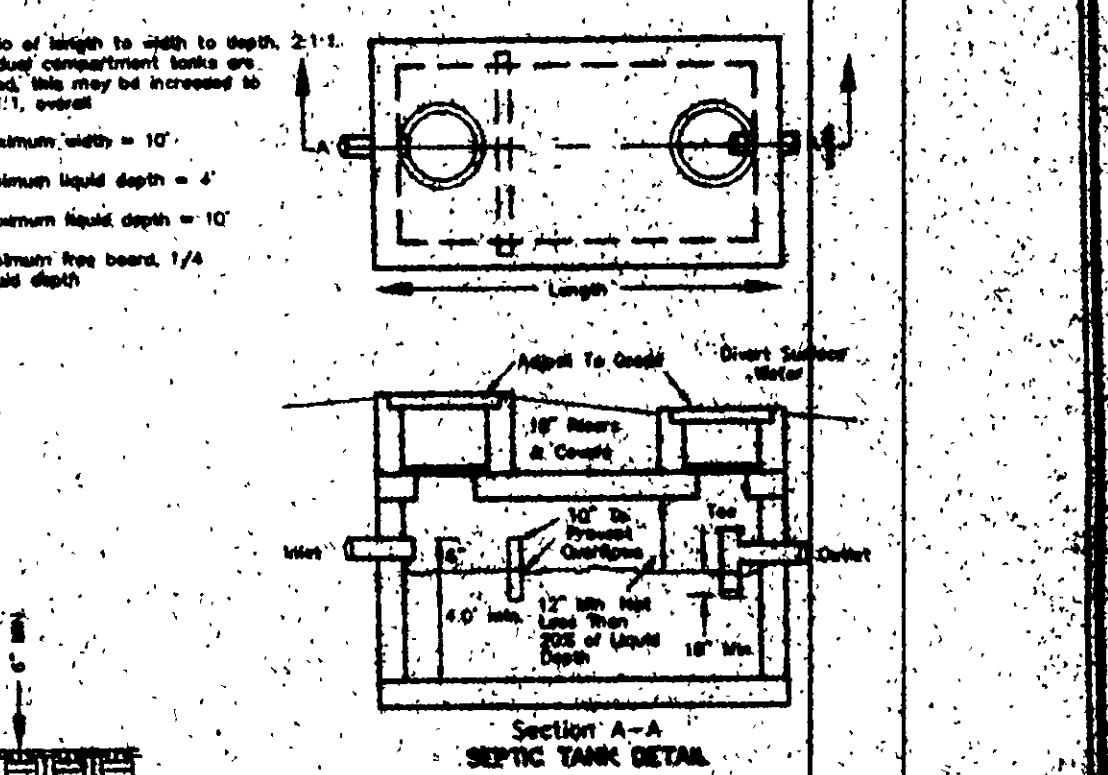

HOUSE DETAIL SAME SCALE

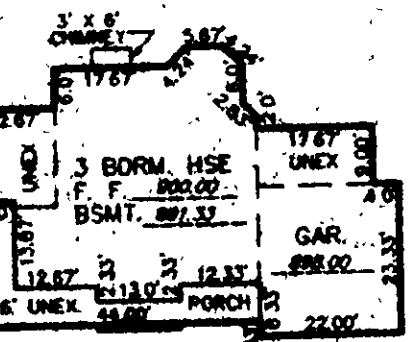

SEPTIC NOTE:
THE SEPTIC SYSTEM INDICATED ON THIS SITE AND GRADING PLAN IS THE MINIMUM REQUIRED FOR THE PURPOSE OF ESTABLISHING THE SIZE ISOLATION DISTANCE AND ELEVATIONS ACCORDING TO THE COUNTY HEALTH DEPARTMENT AND NO GUARANTEE OF ITS OPERATION IS IMPLIED OR ASSUMED BY LSC, INC.

2 WORKING DAYS BEFORE YOU DIG
CALL TOLL FREE 800-362-2764
MISSOURI UTILITIES PROTECTION SERVICE

NOTICE: THE SEPTIC SYSTEM INDICATED ON THIS SITE AND GRADING PLAN IS THE MINIMUM REQUIRED FOR THE PURPOSE OF ESTABLISHING THE SIZE ISOLATION DISTANCE AND ELEVATIONS ACCORDING TO THE COUNTY HEALTH DEPARTMENT AND NO GUARANTEE OF ITS OPERATION IS IMPLIED OR ASSUMED BY LSC, INC.