

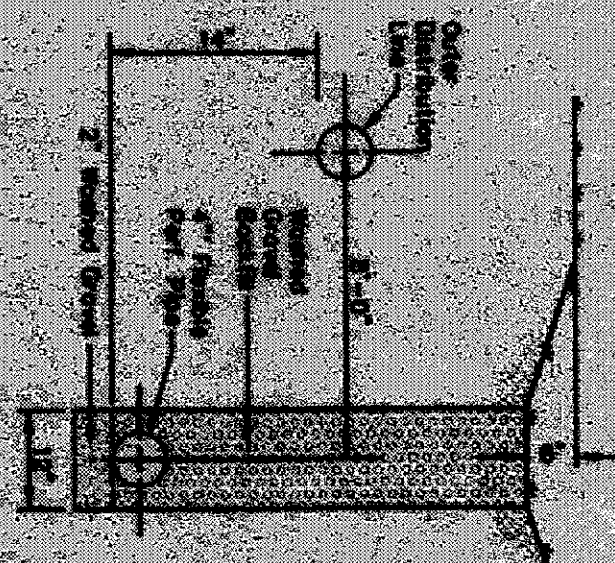
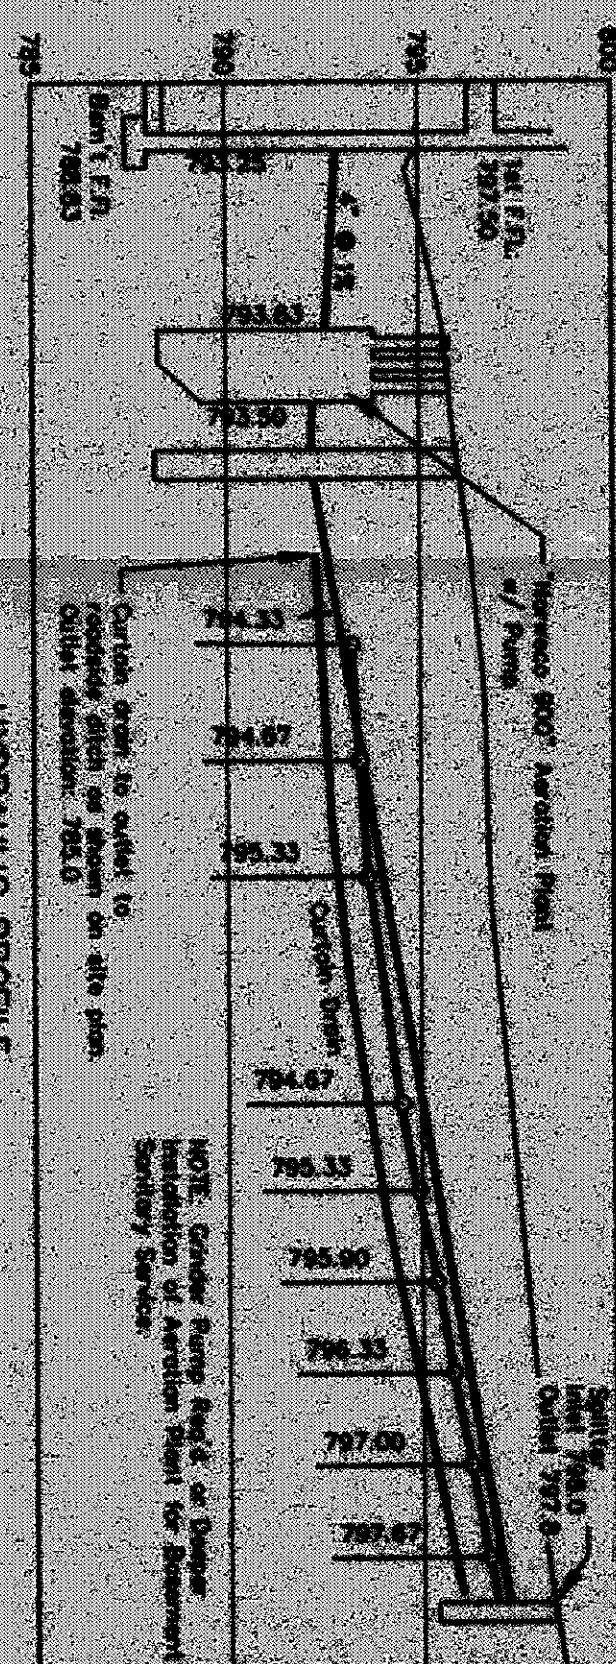
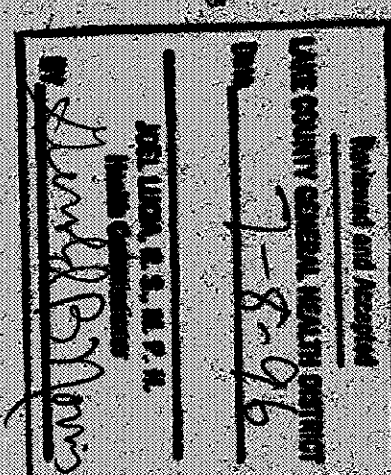
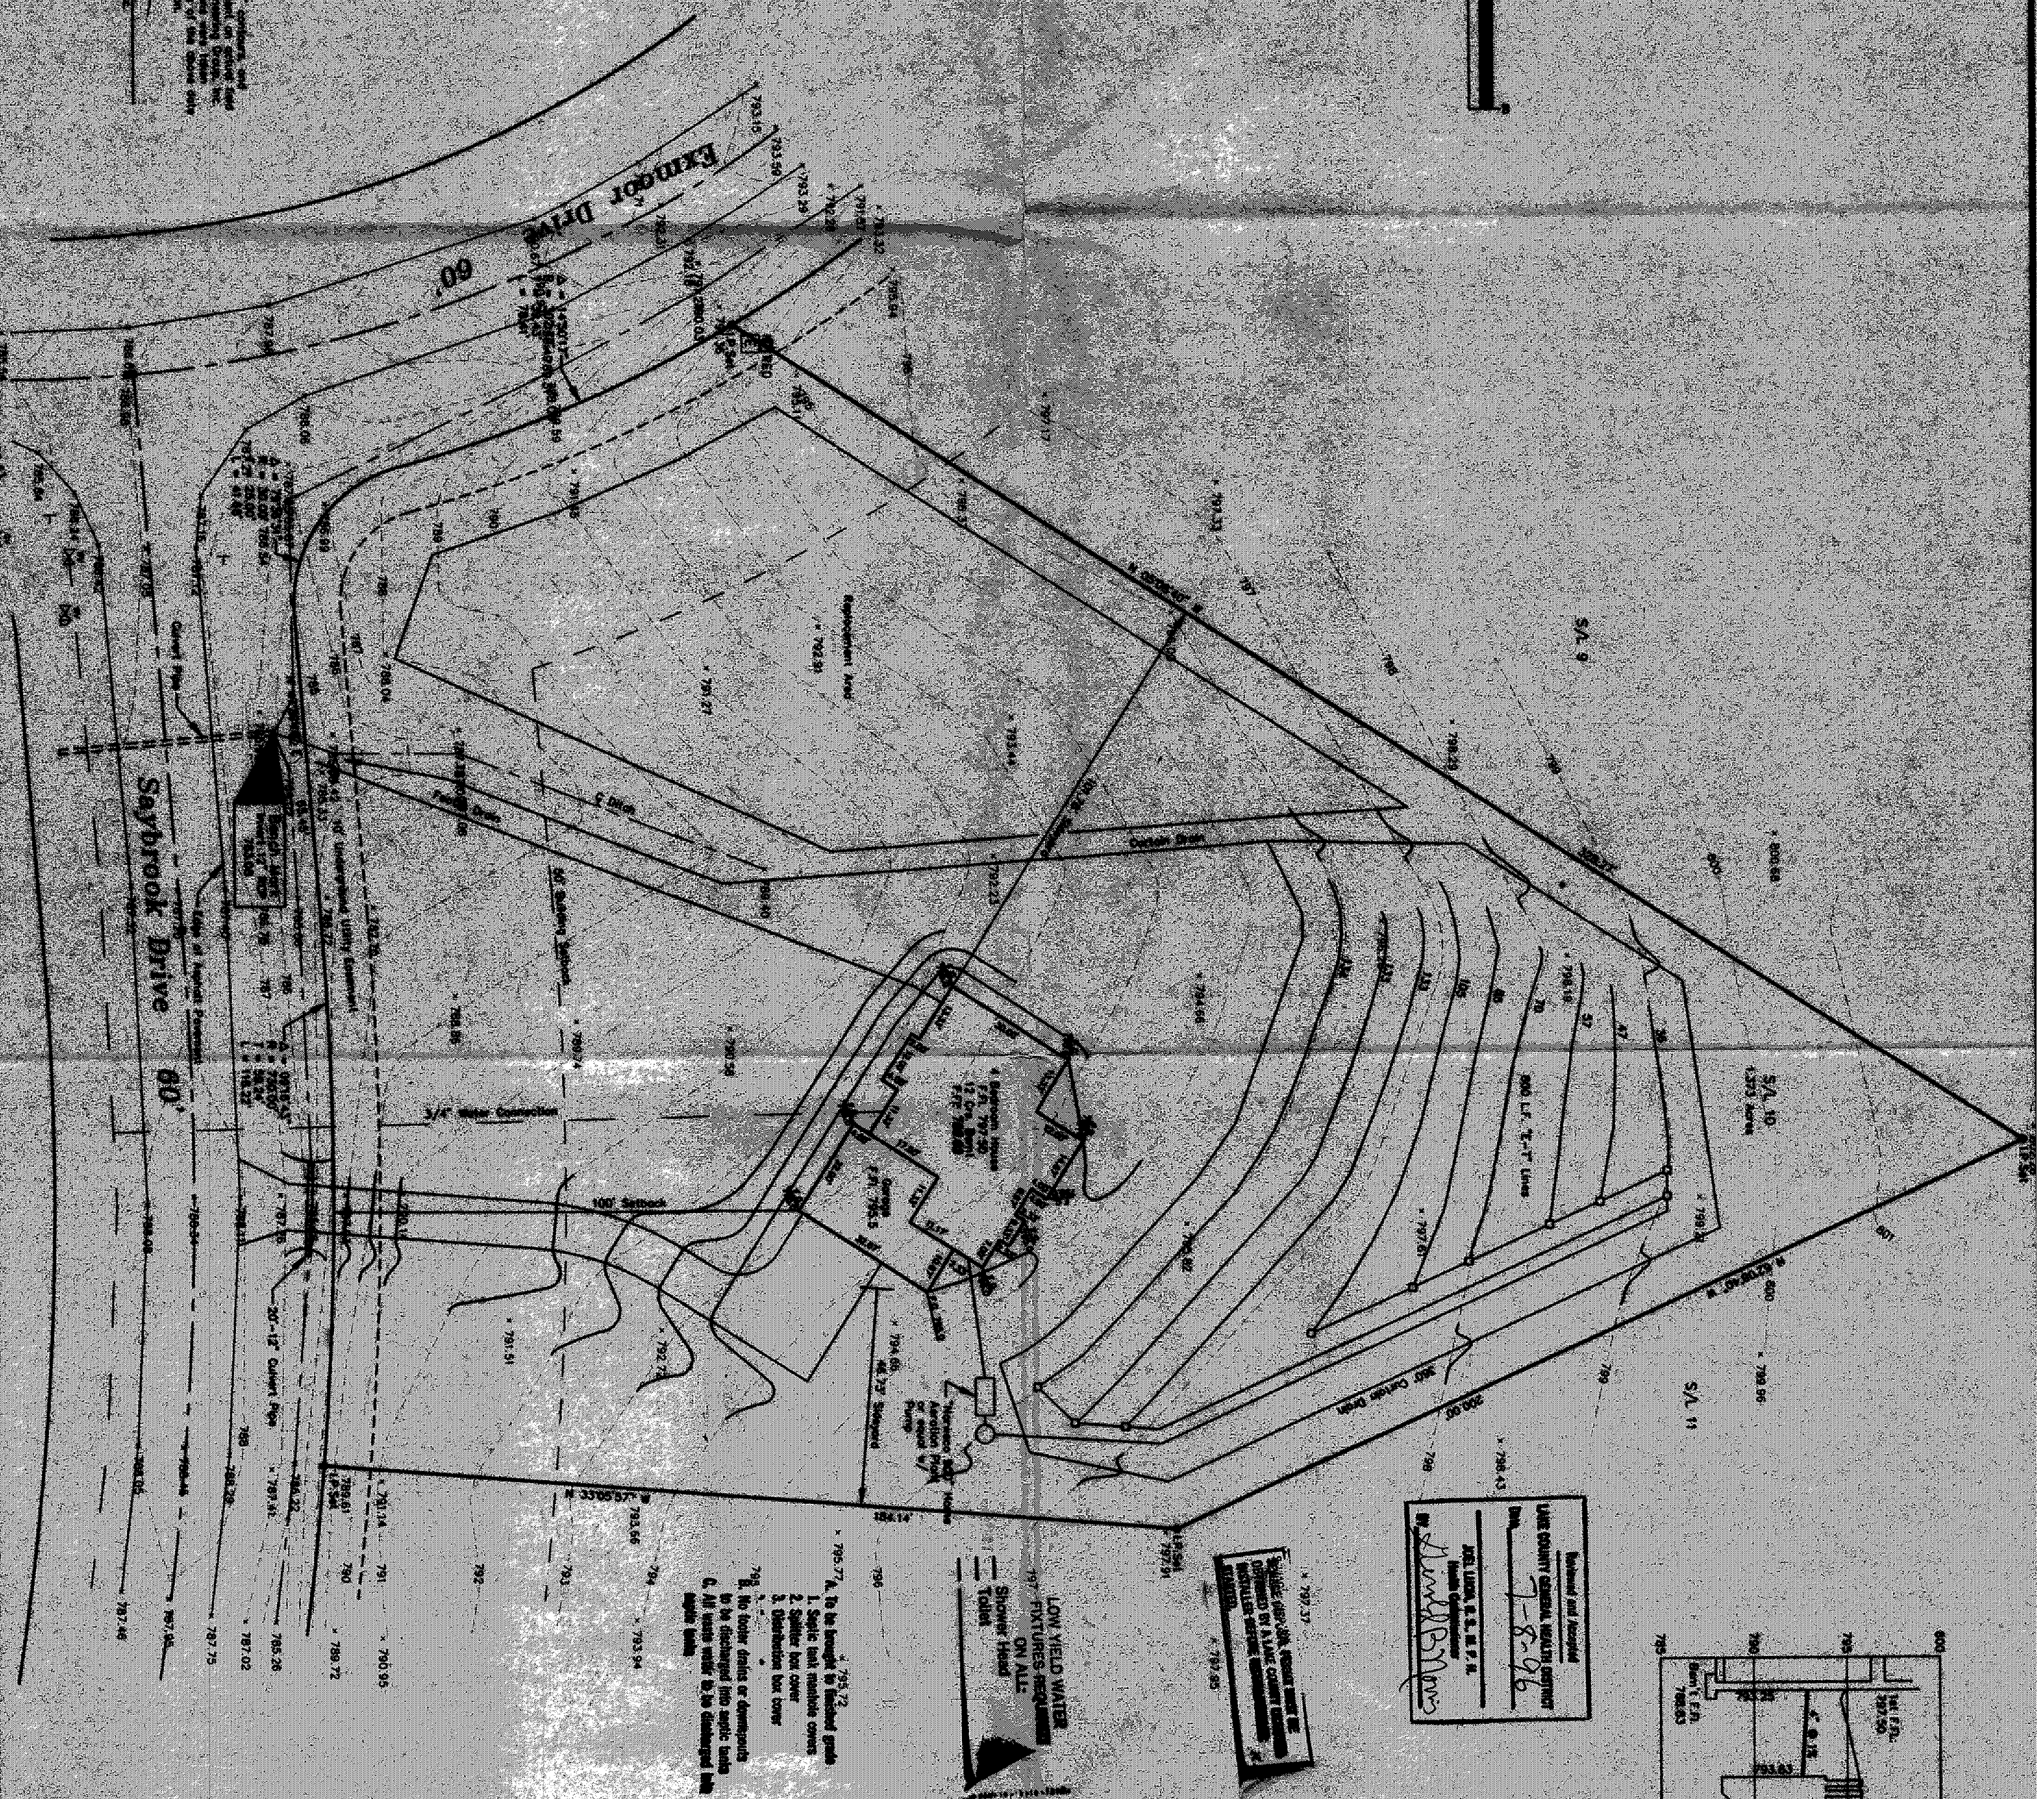


SYMBOL Legend	
☒ X	Water Valve
☒ X	Oil Valve
☒ O	Fry Exhaust
☒ T	Electrical Transformer
☒ T	Tap
☒ T	Telephone Box

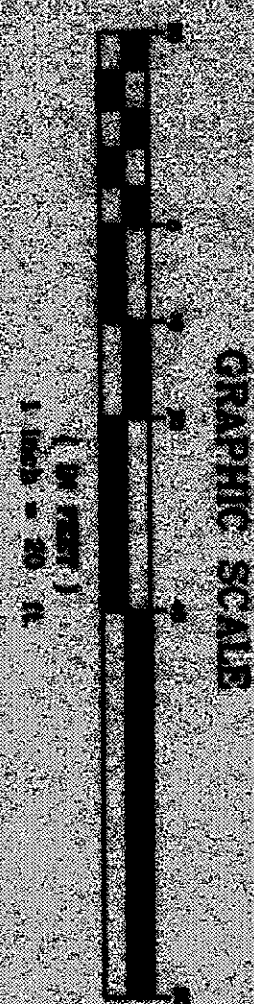

CURTAIN BRAIN CROSS SECTION

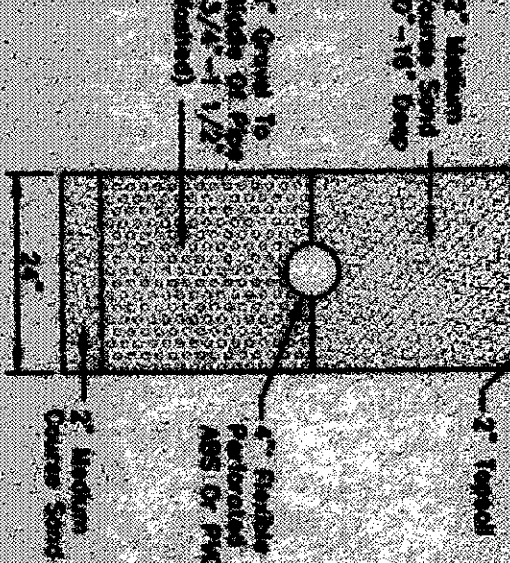

EVAPORATION-TRANSPIRATION
TRENCH CROSS-SECTION
NO SCALE

795.72
A. To be brought to licensed grade
1. Septic tank, manhole covers
2. Siphon box cover
3. Distribution box cover
795.73
B. No toilet drains or downspouts
to be discharged into septic tanks
C. All waste water to be discharged into
septic tanks

LOW YIELD WATER
FIXTURES REQUIRED
ON ALL:
Shower Head
Toilet

G-2014-2 Permit Approved
 as shown and/or noted
 THOMAS P. GILLES, P.E.
 Lake County Engineer
 Date 2/11/14 6/11
 ISSUED 7-10-16
 SUBJECT TO APPROVAL BY:
 Lake County Sanitary Eng. ☐
 Lake County Eng. Dept. ☒
 Lake County Planning Comm. ☐
 Lake County Bldg. Dept. ☒

ANDREWS BUILDERS
10 - Devonshire Subdivision
Township - Lake County - Ohio
Site Plan

REVISIONS:

1. Revised per Lake Co. Health Dept.

SCALE : Horiz. 1" = 20'
Vert. NONE

FILE NAME:
I:\AND1000\1\TOPO.dwg

DATE May 4,
May 23, 1996

Foresight Engineering Group
216-265-1010
265-1034 fax
350 Center Street, Unit F
Chardon, Ohio 44024

**Engineers &
Surveyors**