



NOTE:
HIGH WALL PLUMBING REQUIRED



GRAPHIC SCALE

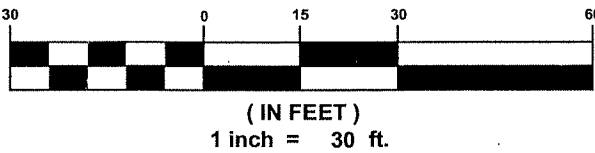

(A)
L=50.74'
R=60.00'
Δ=48°26'58"
C=49.24'
S 24°50'08" W

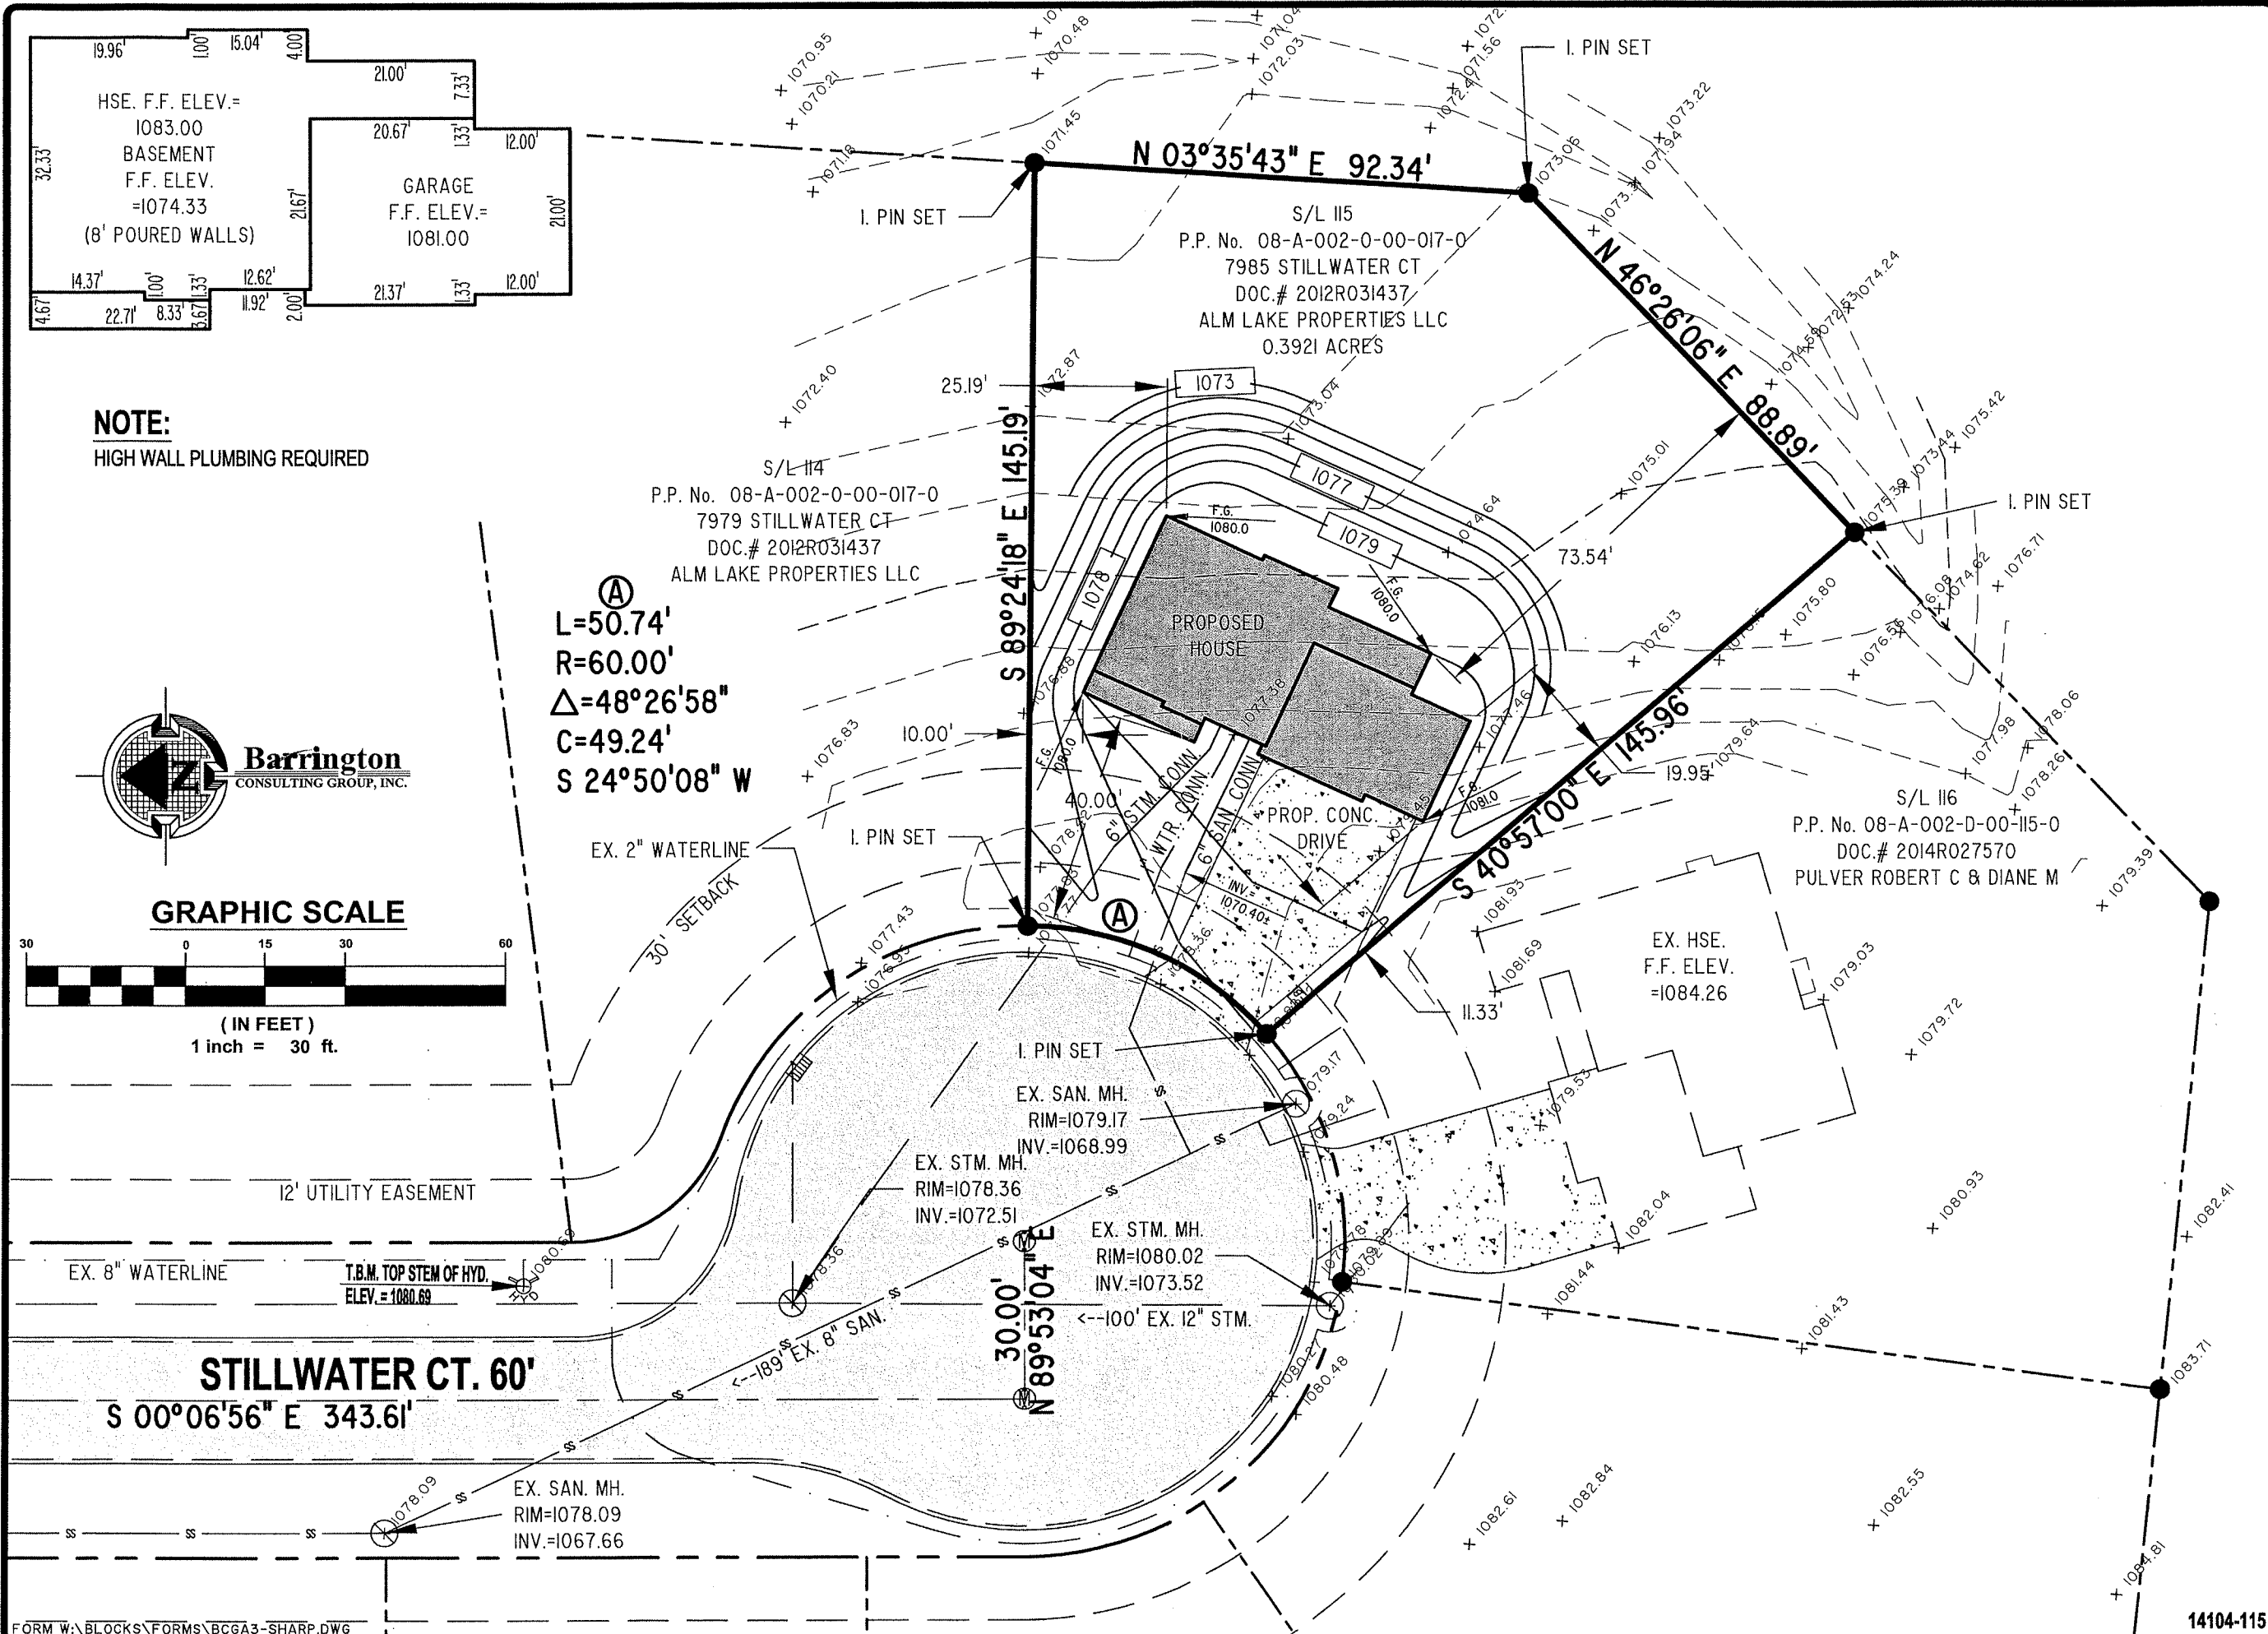

REVISIONS	BY

Barrington
CONSULTING GROUP, INC.
9114 TYLER BLVD., MENTOR, OHIO 44060
PHONE 440.205.1260 FAX 440.205.1262
www.BarringtonCGL.com



SITE PLAN
7985 STILLWATER CT., CONCORD TWP., OHIO 44077
S/L 115 SUMMERWOOD SUBDIVISION PH. 4 VOL. 63 PG. 26
WILLIAM R. DAWSON & SON CONSTRUCTION, LLC

DRAWN	WSO
CHECKED	DWN
DATE	JAN. 28, 2015
SCALE	1" = 30'
JOB NO.	14104-115
SHEET	3/3