


Diagram of a 4' flexible pipe manhole. The manhole is shown in cross-section, with a circular opening at the bottom. The opening is labeled "12' MIN." and the depth is labeled "40' MIN." The manhole is labeled "FLEXIBLE 4' PERFORATED PIPE" and "WASHED GRAVEL" is indicated on the sides.

FOR
PROPERTY OF CONTRACT CONSULTANTS, INC.
PART OF LOT 16, TRACT 4, IN THE TOWNSHIP OF CONCORD,
COUNTY OF LAKE, STATE OF OHIO.
S/L 37 (T180) VIEWMOUNT DRIVE

"I, THE UNDERSIGNED HEREBY CERTIFY THAT THE
TOPOGRAPHY SHOWN HEREON, INDICATED BY ONE FOOT
CONTOURS AND ELEVATIONS REPRESENTS AN ACTUAL
FIELD TOPOGRAPHIC SURVEY MADE BY ME ON THE
15th DAY OF JULY, 1997 AND THAT
THE ELEVATIONS WERE TAKEN AT APPROPRIATE
INTERVALS AND THAT AS OF THAT DATE THEY EXISTED
AS INDICATED HEREON."

[Signature]
JOHN R. ALBAN, P.S. REG. NO. 7651

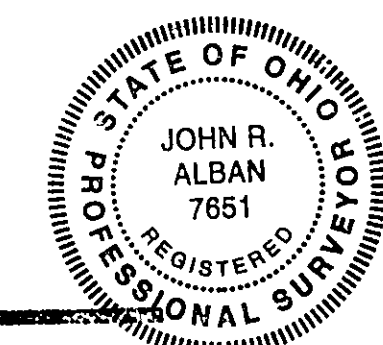

REVIEWED AND ACCEPTED
LAKE COUNTY GENERAL
HEALTH DISTRICT

Grading Plan Approved
as shown and/or noted
THOMAS P. GILLES, P.E.
Lake County Engineer

Date 9-2-97 BY Gerald B. Norris LSH Date 9.3.97

SEWAGE DISPOSAL PERMIT MUST BE
OBTAINED BY A LAKE COUNTY LICENSED
INSTALLER BEFORE INSTALLATION IS
STARTED.


RICHARD R. &
DANIELLA F. INTIHAR
VOL 24 PG. 583

CONTRACT CONSULTANTS, INC.

RUSSEL J & ROSA BRUNSTETTER
VOL 769 PG. 483

ROBERT J. GERMOVSEK
VOL. 836 PG 898


SOIL TYPE:
LORDSTOWN CHANNERY SILT LOAM (LrB)
2 TO 6 PERCENT SLOPES

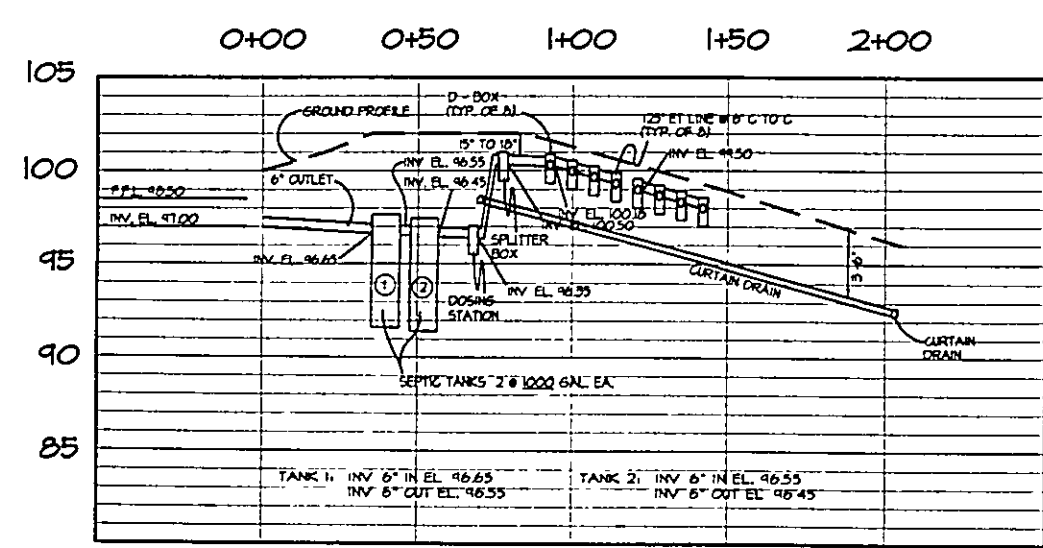


SANITARY SYSTEM
PROFILE
HOR. - 1" = 30'
VERT. - 1" = 5'

ZONING PERMIT #0697-8778
ISSUED 6/24/97; revised 9/2/97

SUBJECT TO APPROVAL BY:
Lake County Sanitary Eng. ☐
Lake County Engr. Dept. ☒
Lake County Planning Comm. ☐
Lake County Bldg. Dept. ☒

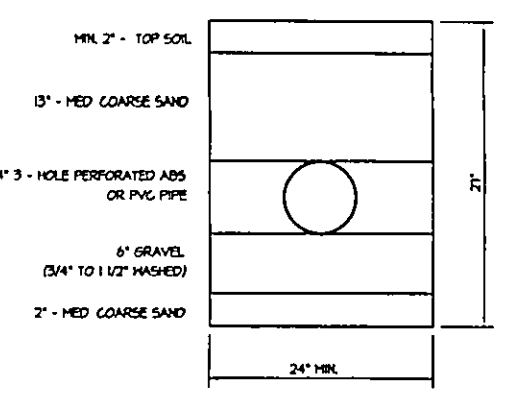

TYPICAL E.T. TRENCH
CROSS SECTION
NOT TO SCALE

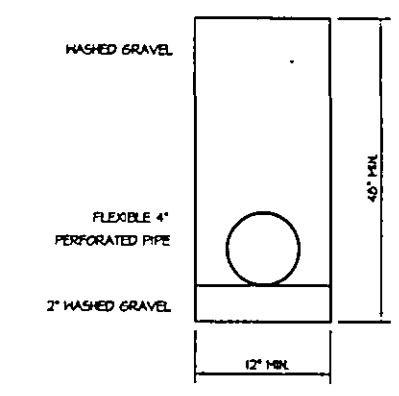

TYPICAL CURTAIN DRAIN
CROSS SECTION
NOT TO SCALE

D:\HOUSE\SITEPLAN\ 0-27-97 5 01 04 pm EST

TK Engineering & Design Group Inc.
"Concept Thru Construction"
TELEPHONE 975-1674 / 942-6030 * FAX 975-1774
5000 EAST 345th STREET * WILLOUGHBY, OHIO 44094

REV	DESCRIPTION	BY	DATE

PROPOSED SITE PLAN
T180 VIEWMOUNT DRIVE

HOUSE PLANS
CONTRACT CONSULTANTS, INC.
CONCORD, OHIO

HORIZ. 1"=60'	VERT. 1"=60'
DRAWN BY GEA	CHECKED BY TMT
DATE SEPTEMBER, 1997	
JOB NUMBER 12972	SHEET 5 of 5