

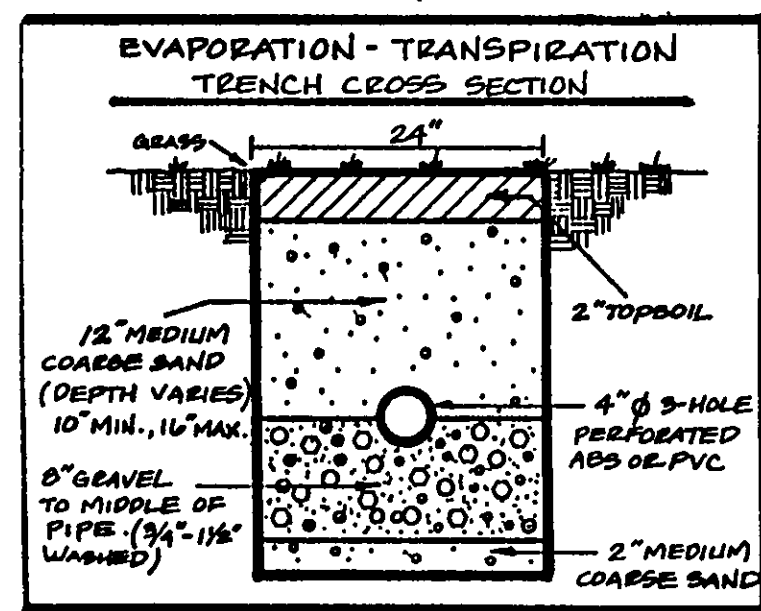
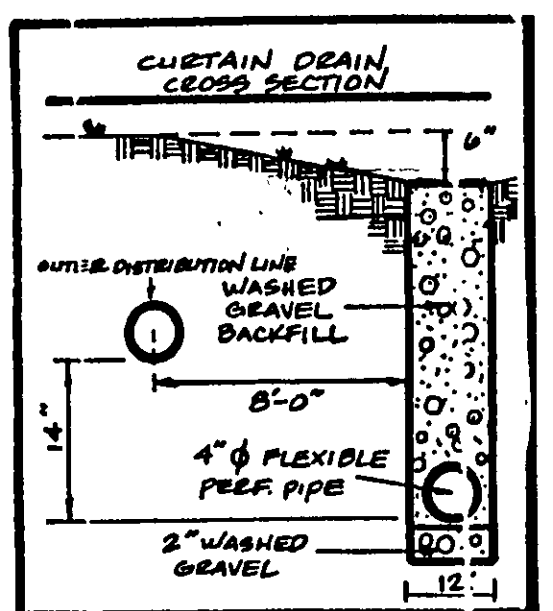


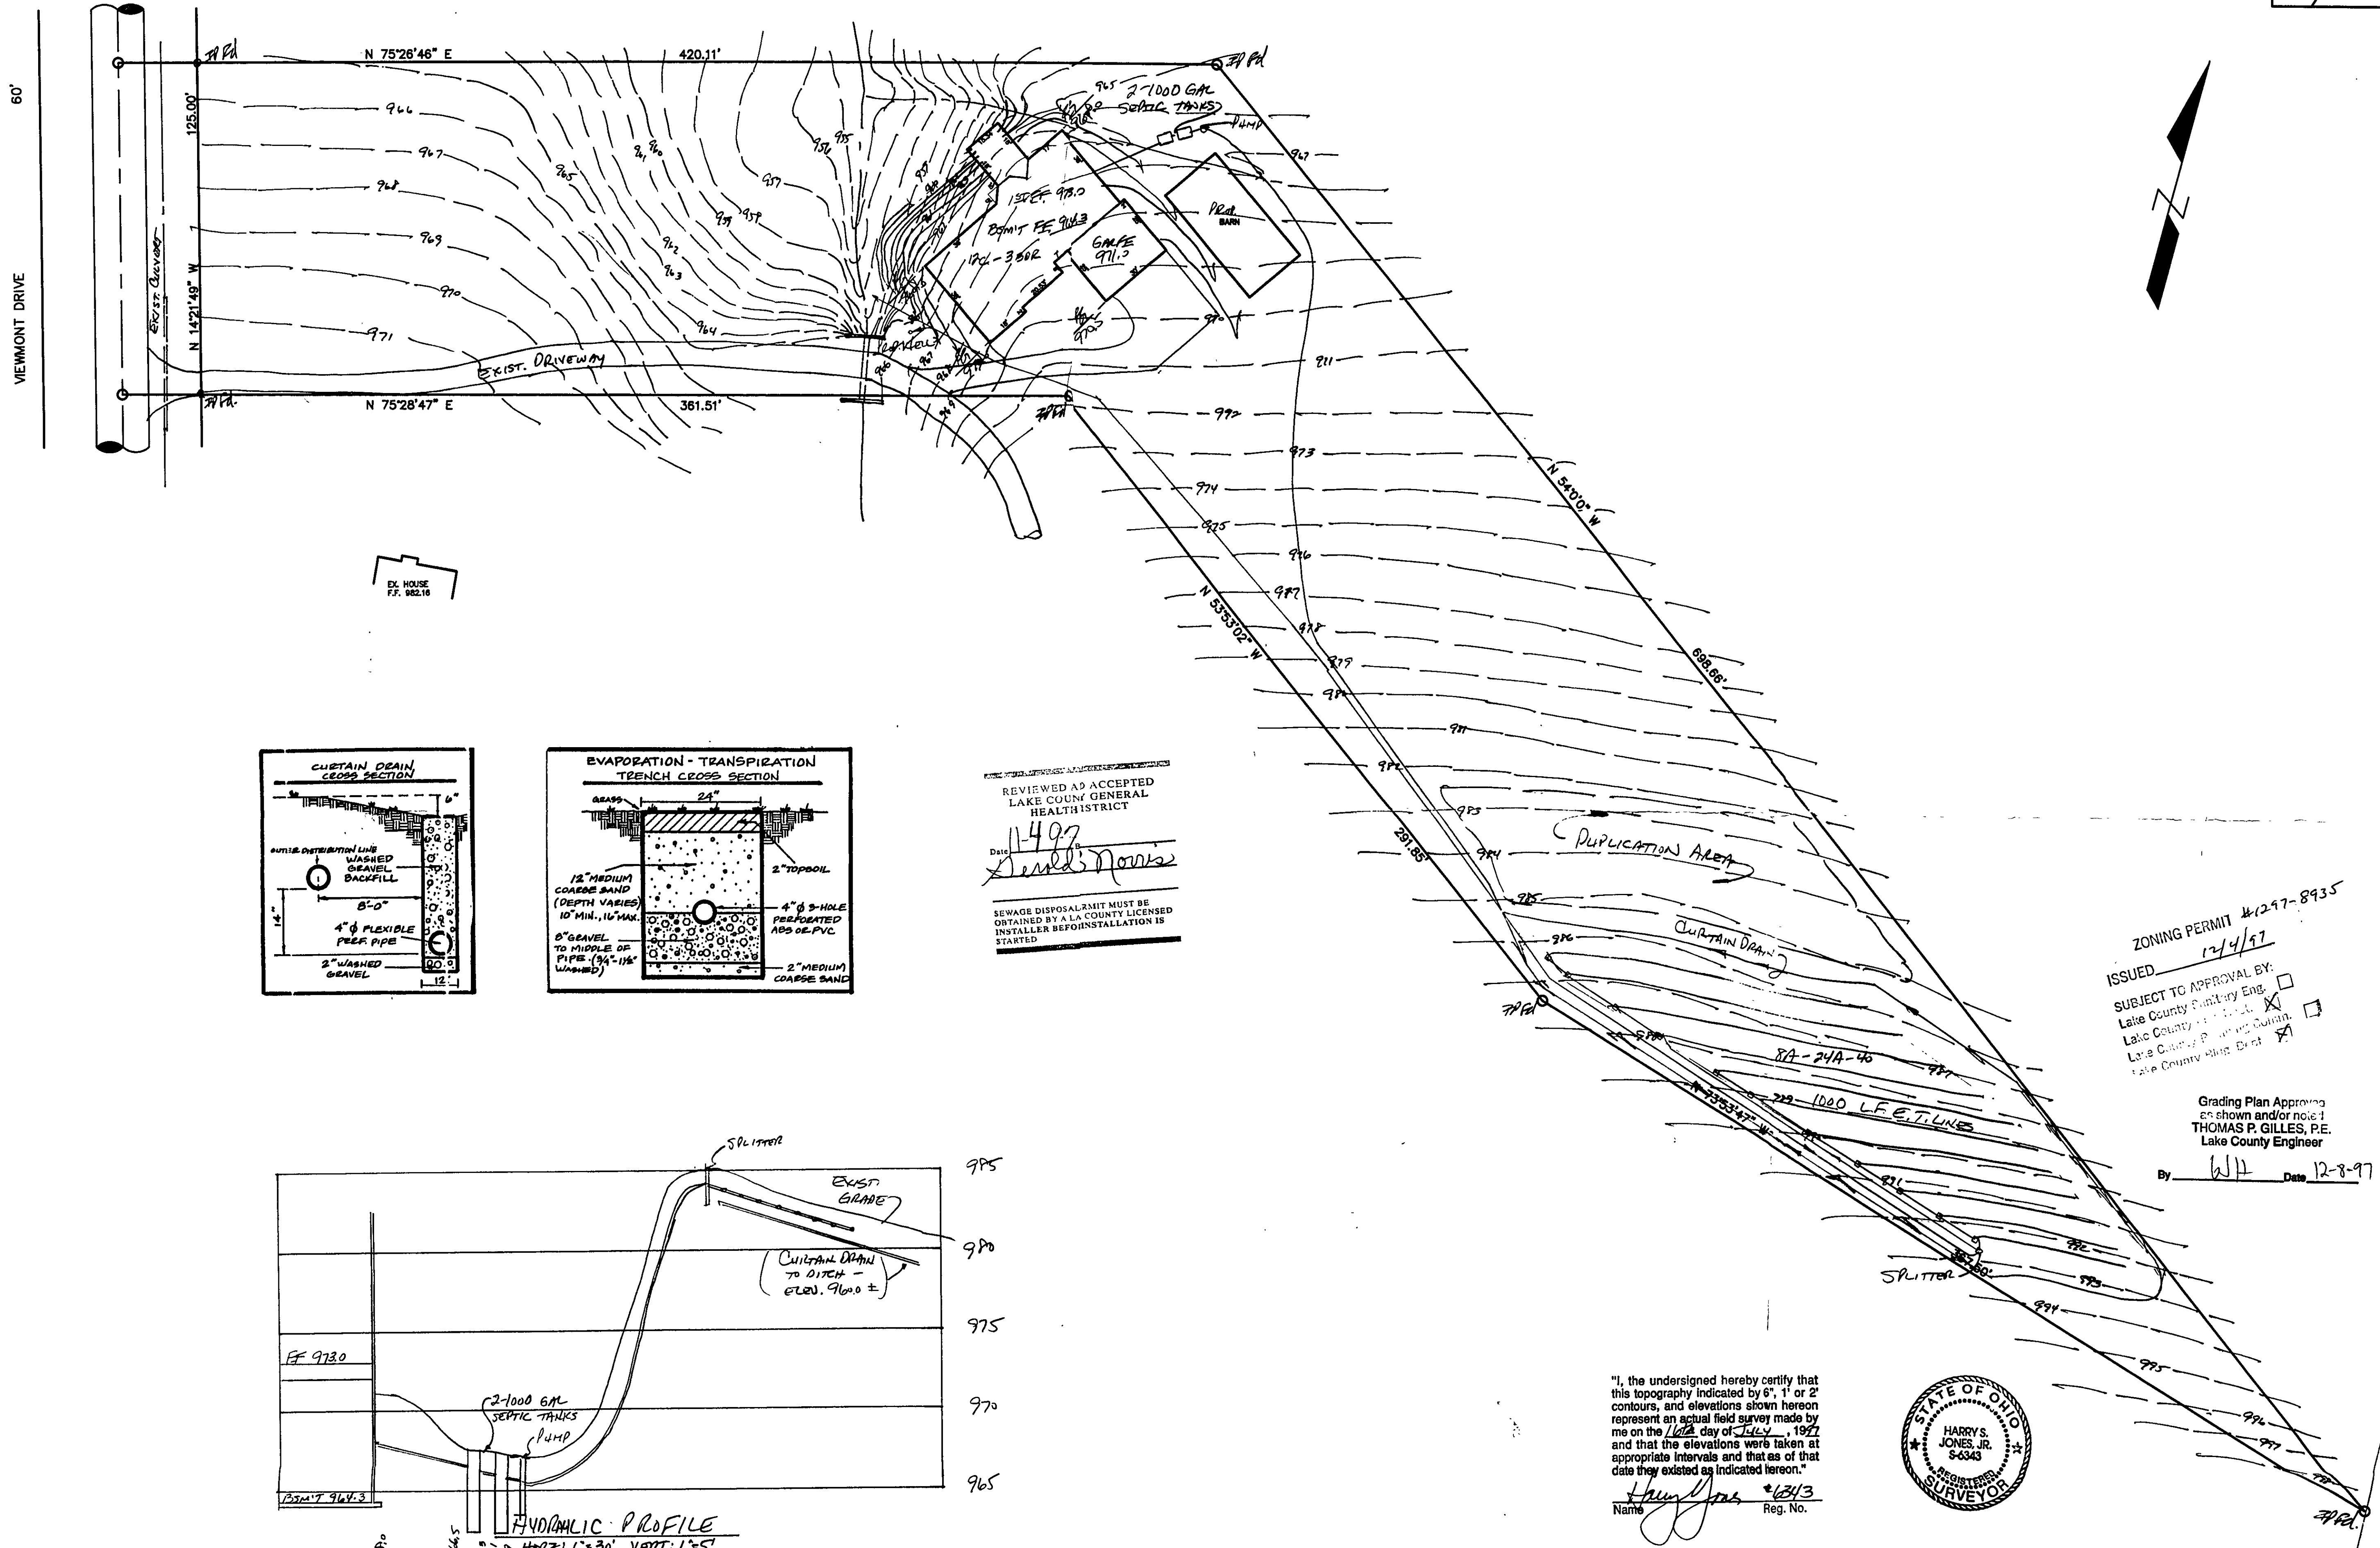

REVIEWED AND ACCEPTED
LAKE COUNTY GENERAL
HEALTH DISTRICT
Date: 11-4-97
Sewage Disposal Permit must be obtained by a Lake County Licensed Installer before installation is started.

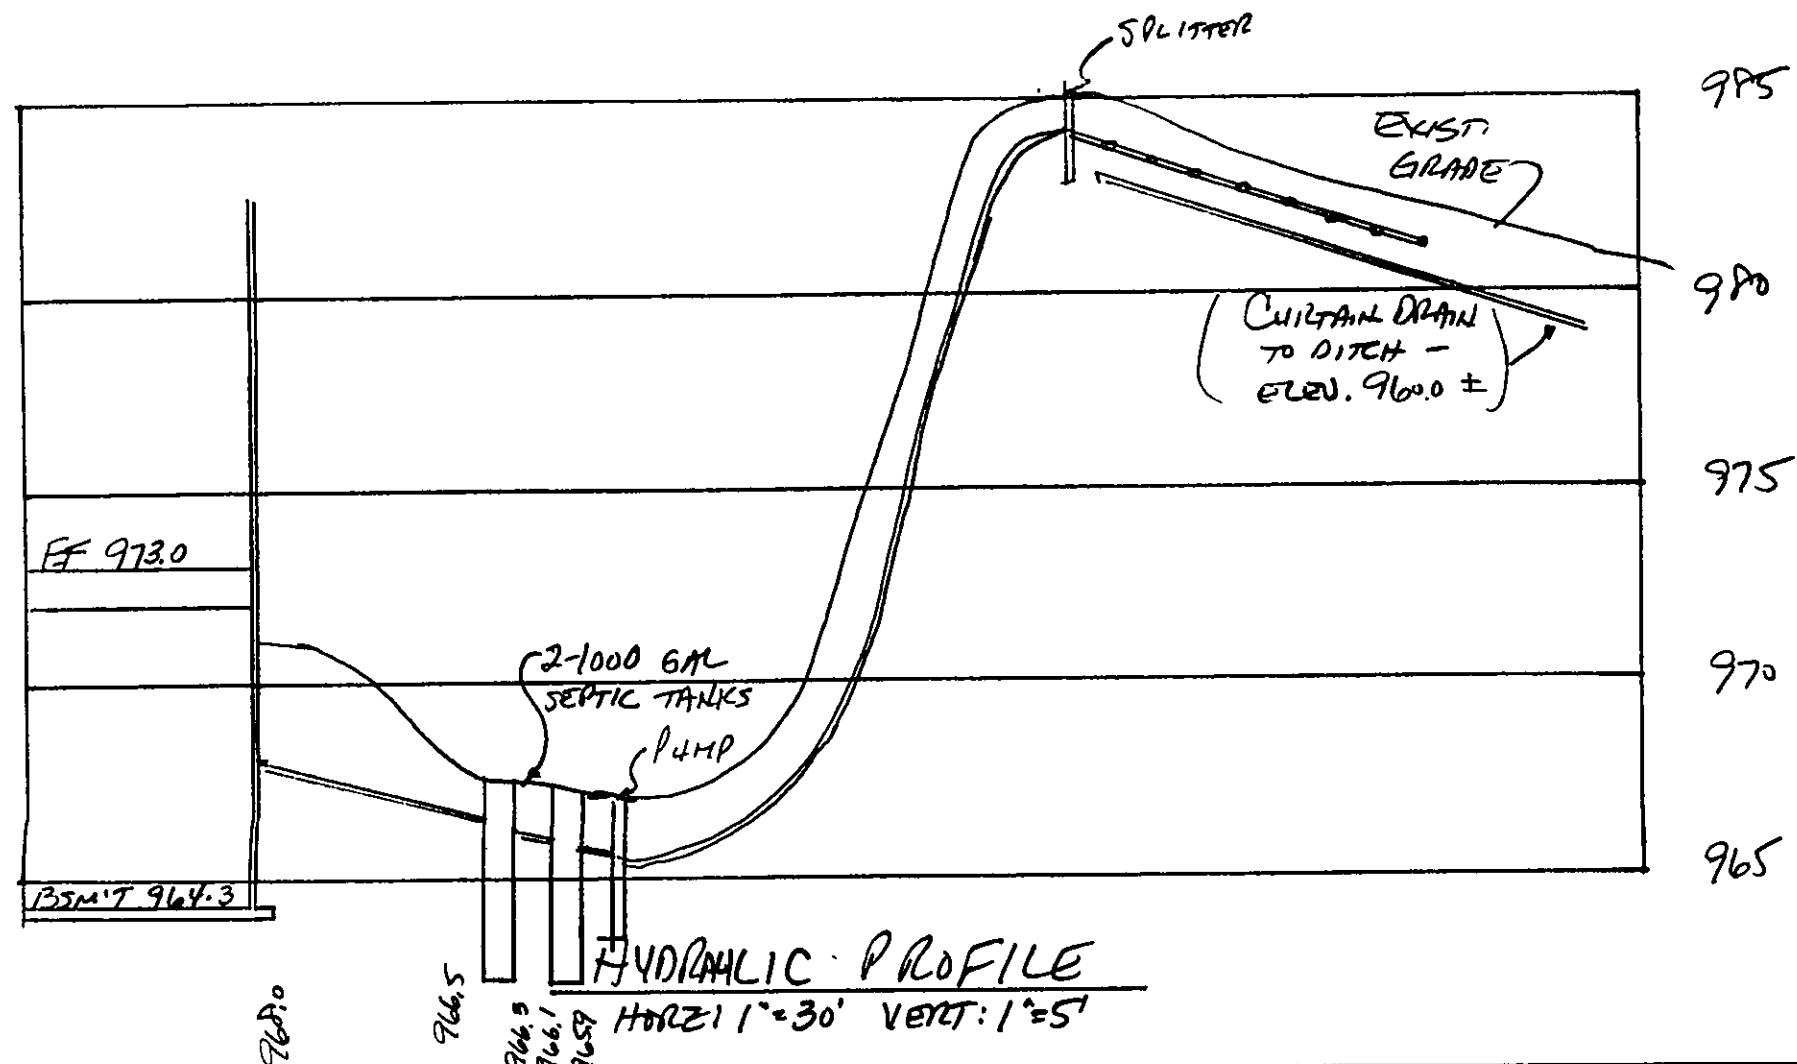

REV NO.	DESCRIPTION	DATE	BY	CHK'D
1	REVISION SEPTIC	10-13-97	HT	HT

BABCOCK, JONES AND ASSOCIATES, INC
CIVIL ENGINEERS - SURVEYORS - LAND PLANNERS
PAINESVILLE OHIO 44077

DATE: 7/11/97
DESIGN BY: HT
DRAWN BY: M.S.
APPROVED BY: HT

SITE PLAN
for
P.P.N.: 08A-024A-00-040
for
PAULETTE LINGAFELTER
CONCORD TOWNSHIP LAKE COUNTY, OHIO

SCALE: 1"=30'
JOB NO: 97-160
SHEET 1 OF 1