
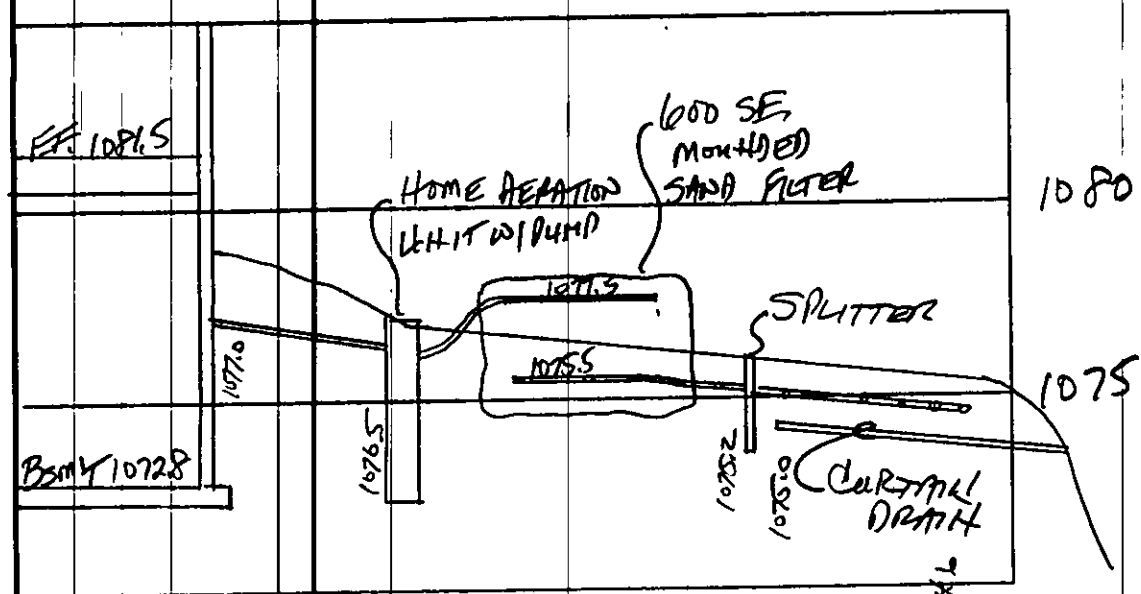


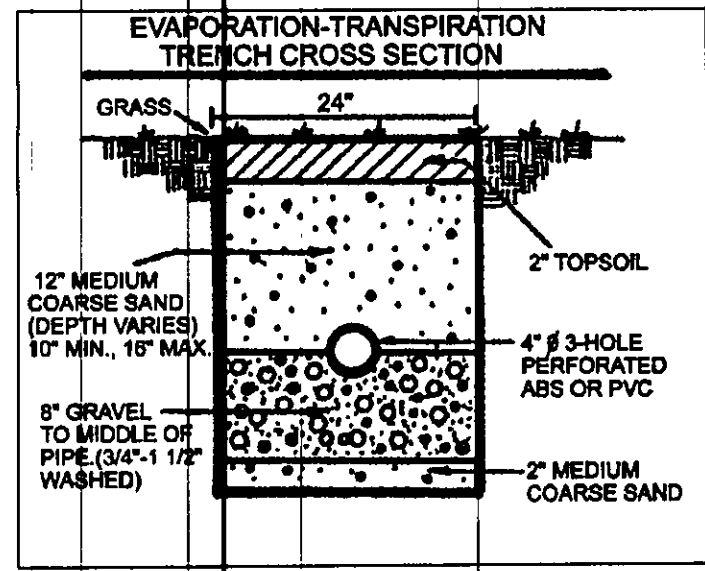

HYDRAULIC PROFILE
HORIZ: 1"=30' VERT: 1"=5'

CONCORD TOWNSHIP ZONING OFFICE

ZONING PERMIT # 0903-11300

ISSUED 9/24/03

SUBJECT TO APPROVAL BY:


- ☒ Lake Co. Civil/Env. Engineer
- ☒ Lake Co. Eng. Dept.
- ☐ Lake Co. Planning Comm.
- ☒ Lake Co. Building Dept.
- ☒ Lake Co. Soil & Water Cons. Dist.

WETLANDS

REVIEWED AND ACCEPTED
LAKE COUNTY GENERAL
HEALTH DISTRICT

Date 9-23-03 By DCK

SEWAGE DISPOSAL PERMIT MUST BE OBTAINED BY A LAKE COUNTY LICENSED INSTALLER BEFORE INSTALLATION IS STARTED.

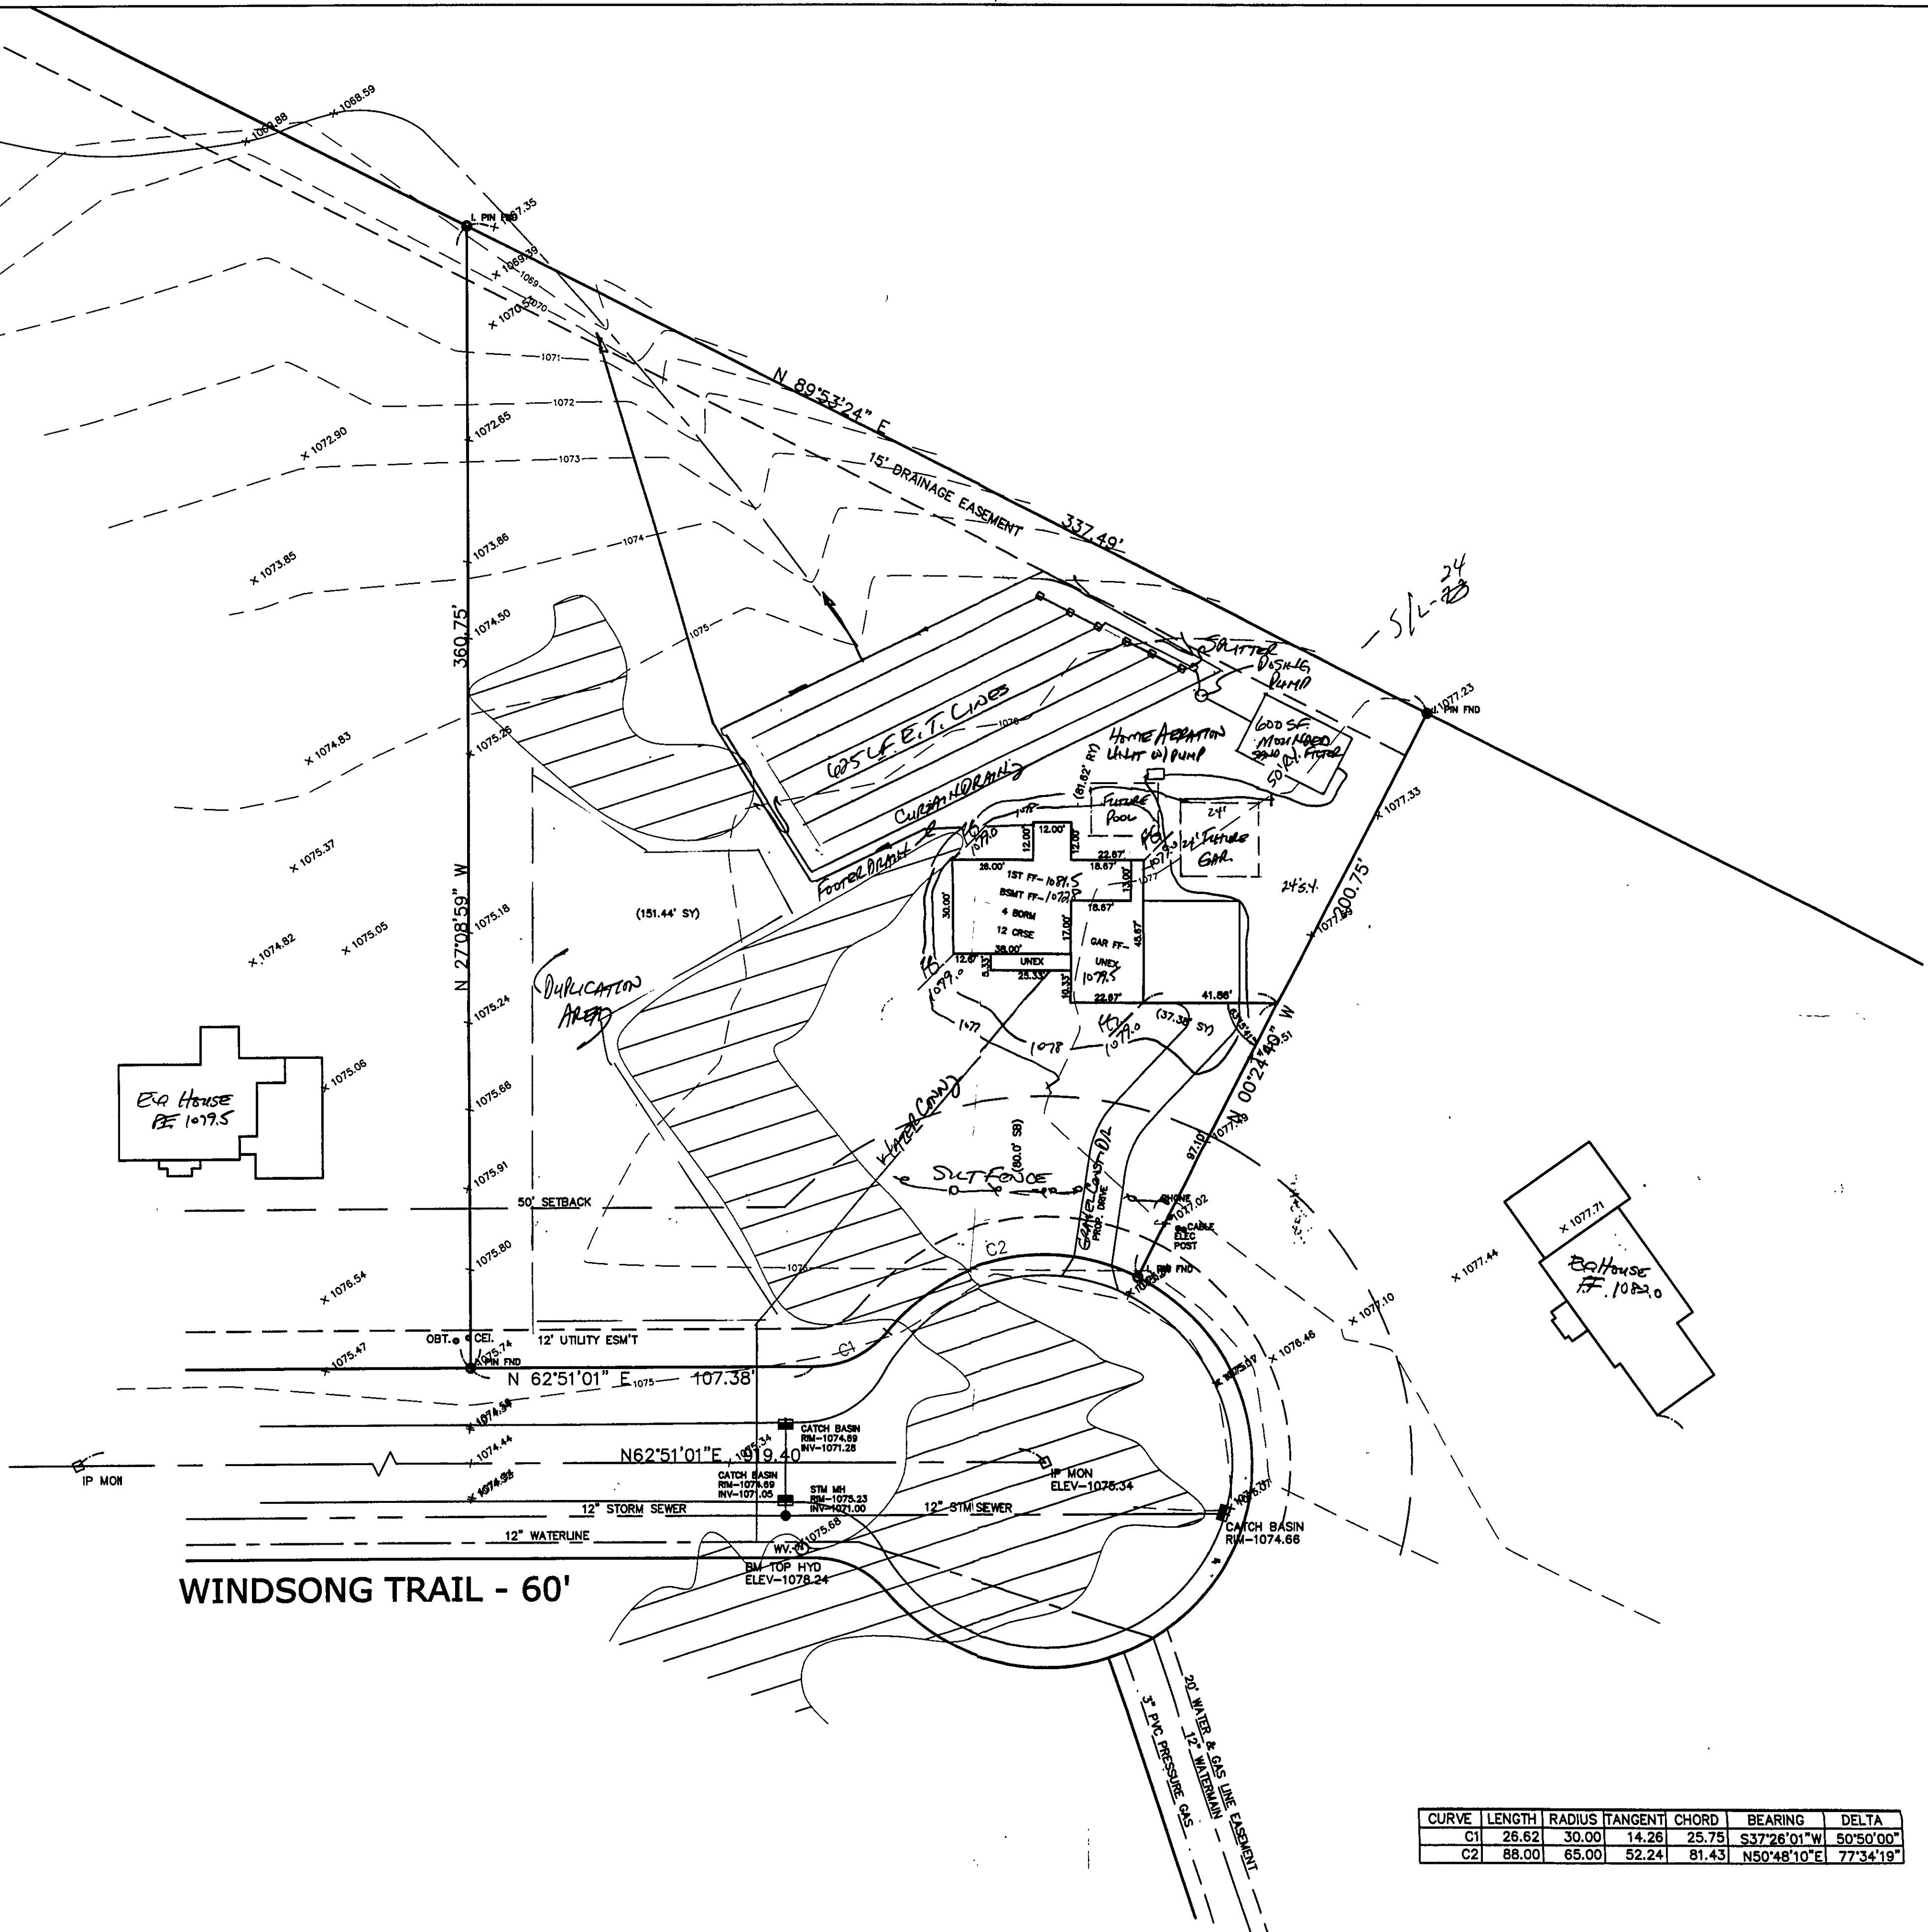

CURVE	LENGTH	RADIUS	TANGENT	CHORD	BEARING	DELTA
C1	26.62	30.00	14.26	25.75	S37°26'01"W	50°50'00"
C2	88.00	65.00	52.24	81.43	N50°48'10"E	77°34'19"


"I, the undersigned hereby certify that this topography indicated by 6", 1', or 2' contours, and elevations shown hereon represent an actual field survey made by me on the 16th day of Sept, 2003 and that the elevations were taken at appropriate intervals and that as of that date they existed as indicated hereon."

Name Huang, Jia Reg. No. 86343

Grading Plan Approved

By 6514 Date 9/26/03

EXISTING UTILITIES NOTE:
THE SIZE AND LOCATION, BOTH HORIZONTAL AND VERTICAL
OF THE UNDERGROUND UTILITIES SHOWN HEREON, HAVE BEEN
OBTAINED BY A SEARCH OF AVAILABLE RECORDS.
VERIFICATION BY FIELD OBSERVATION HAS BEEN CONDUCTED
WHERE PRACTICAL, HOWEVER, BABCOCK, JONES AND ASSOCIATES
INC. DOES NOT GUARANTEE THE COMPLETENESS NOR ACCURACY
THEREOF.

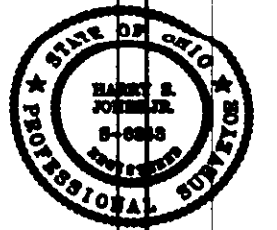[illegible]**bj**

BABCOCK, JONES AND ASSOCIATES, INC
CIVIL ENGINEERS - SURVEYORS - LAND PLANNERS
PAINESVILLE OHIO 44077

DATE	9/16/03
DESIGN BY	HJ
DRAWN BY	NS
APPROVED BY	HJ

SITE PLAN
FOR
SHAMROCK CONSTRUCTION

CONCORD TOWNSHIP LAKE COUNTY STATE OF OHIO

SCALE	1"=30'
JOB NO.	98-185-24
SHEET	OF
1	1