


1"=20'

"I, the undersigned hereby certify that the size and location, both horizontal and vertical of the underground utilities shown hereon, have been obtained by a search of available records. Verification by field observation has been conducted where practical. However, Babcock, Jones and Associates, Inc. does not guarantee the completeness nor accuracy thereof."

Harry Jones #6343
Name Harry Jones #6343 Reg. No.

CURVE TABLE						
C	RVE	LENGTH	RADIUS	TANGENT CHORD	BEARING	DELTA
1	C1	65.03	65.00	35.53	S161°40'W	57°19'22"

BM - TOP OF FIRE HYDRANT
ELEV - 1075.35

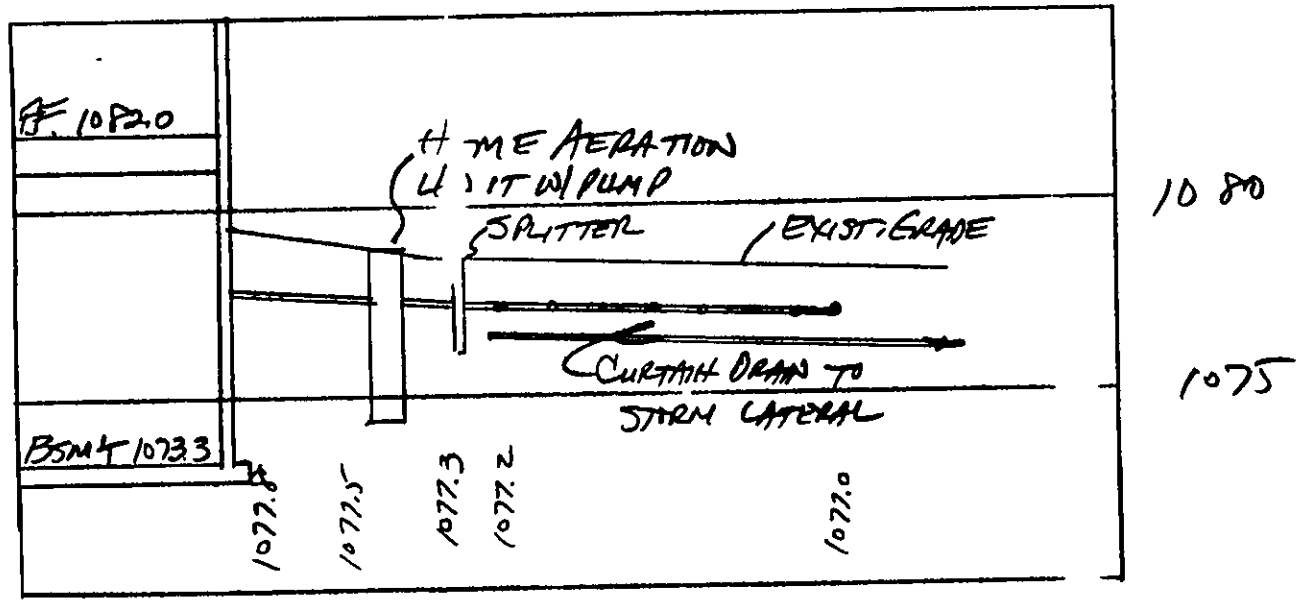

HYDRAULIC PROFILE
HORIZ: 1"=30' VERT: 1"=5'

Great Plan Approved as shown and/or noted
JAMES R. GILLS, P.E.
Lake County Engineer
By *[Signature]* Date 1/17/2003

NOTE: TEMPORARY SEEDING REQUIRED IN DISTURBED AREAS

CONCORD TOWNSHIP ZONING OFFICE
ZONING PERMIT # 0103-10878
ISSUED Jan. 16, 2003
SUBJECT TO APPROVAL BY:
 Lake Co. Sanitary Engineer
 Lake Co. Eng. Dept.
 Lake Co. Planning Comm.
 Lake Co. Building Dept.
 Lake Co. Soil & Water Cons. Dist.

REVIEWED AND ACCEPTED
LAKE COUNTY GENERAL HEALTH DISTRICT
Date 1-13-03 BY *[Signature]*

SEWAGE DISPOSAL PERMIT MUST BE OBTAINED BY A LAKE COUNTY LICENSED INSTALLER BEFORE INSTALLATION IS STARTED

REV. NO.	DESCRIPTION	DATE	BY	CHK'D

bj BABCOCK, JONES AND ASSOCIATES, INC
CIVIL ENGINEERS - SURVEYORS - LAND PLANNERS
PAINESVILLE OHIO 44077

DATE 1/8/03
DESIGN BY H.J.
DRAWN BY B.P.
APPROVED BY H.J.

CONCORD TOWNSHIP
SITE PLAN FOR SHAMROCK
COUNTY OF LAKE STATE OF OHIO



SCALE 1"=30'
JOB NO 98-185-22
SHEET 1 OF 1