
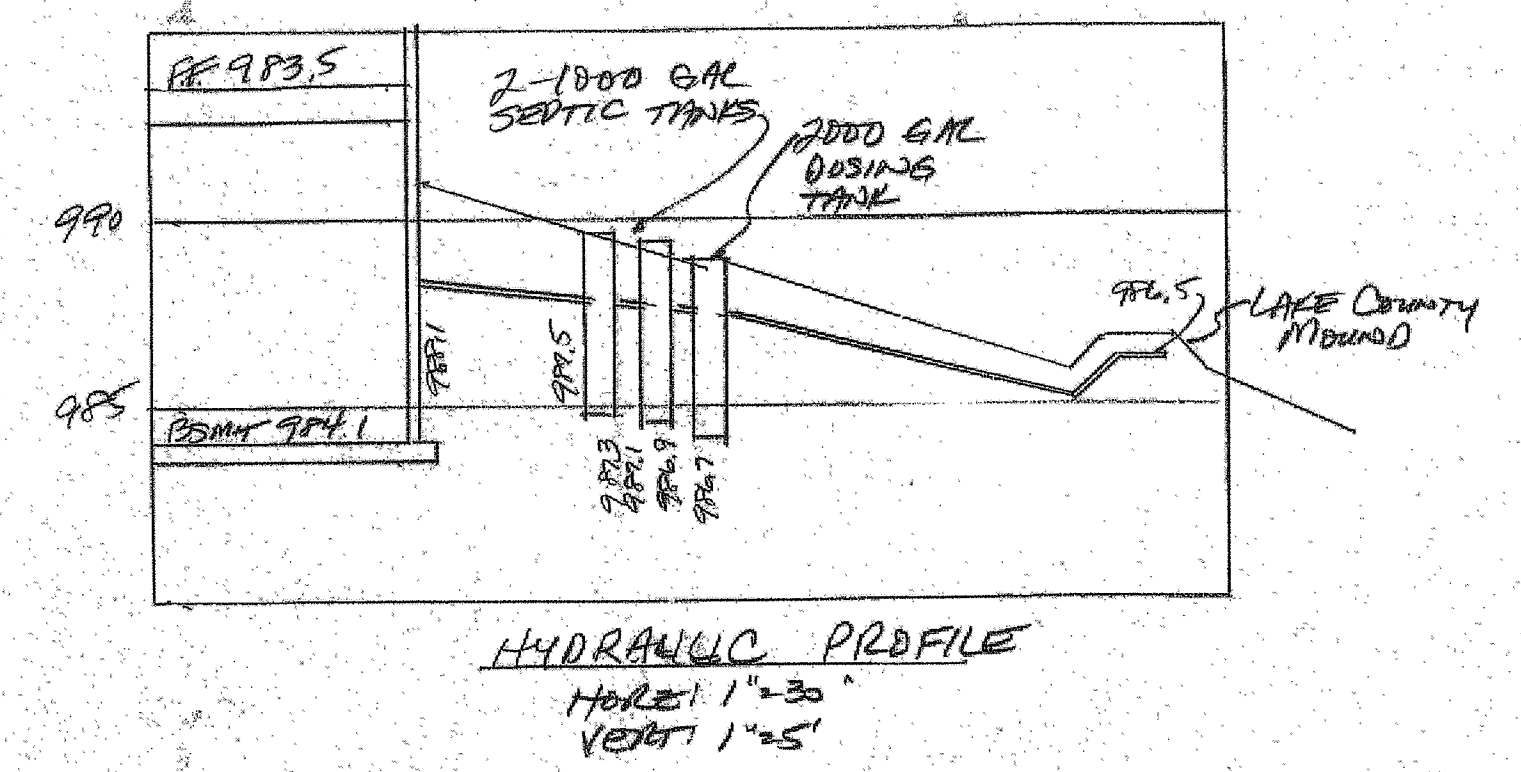


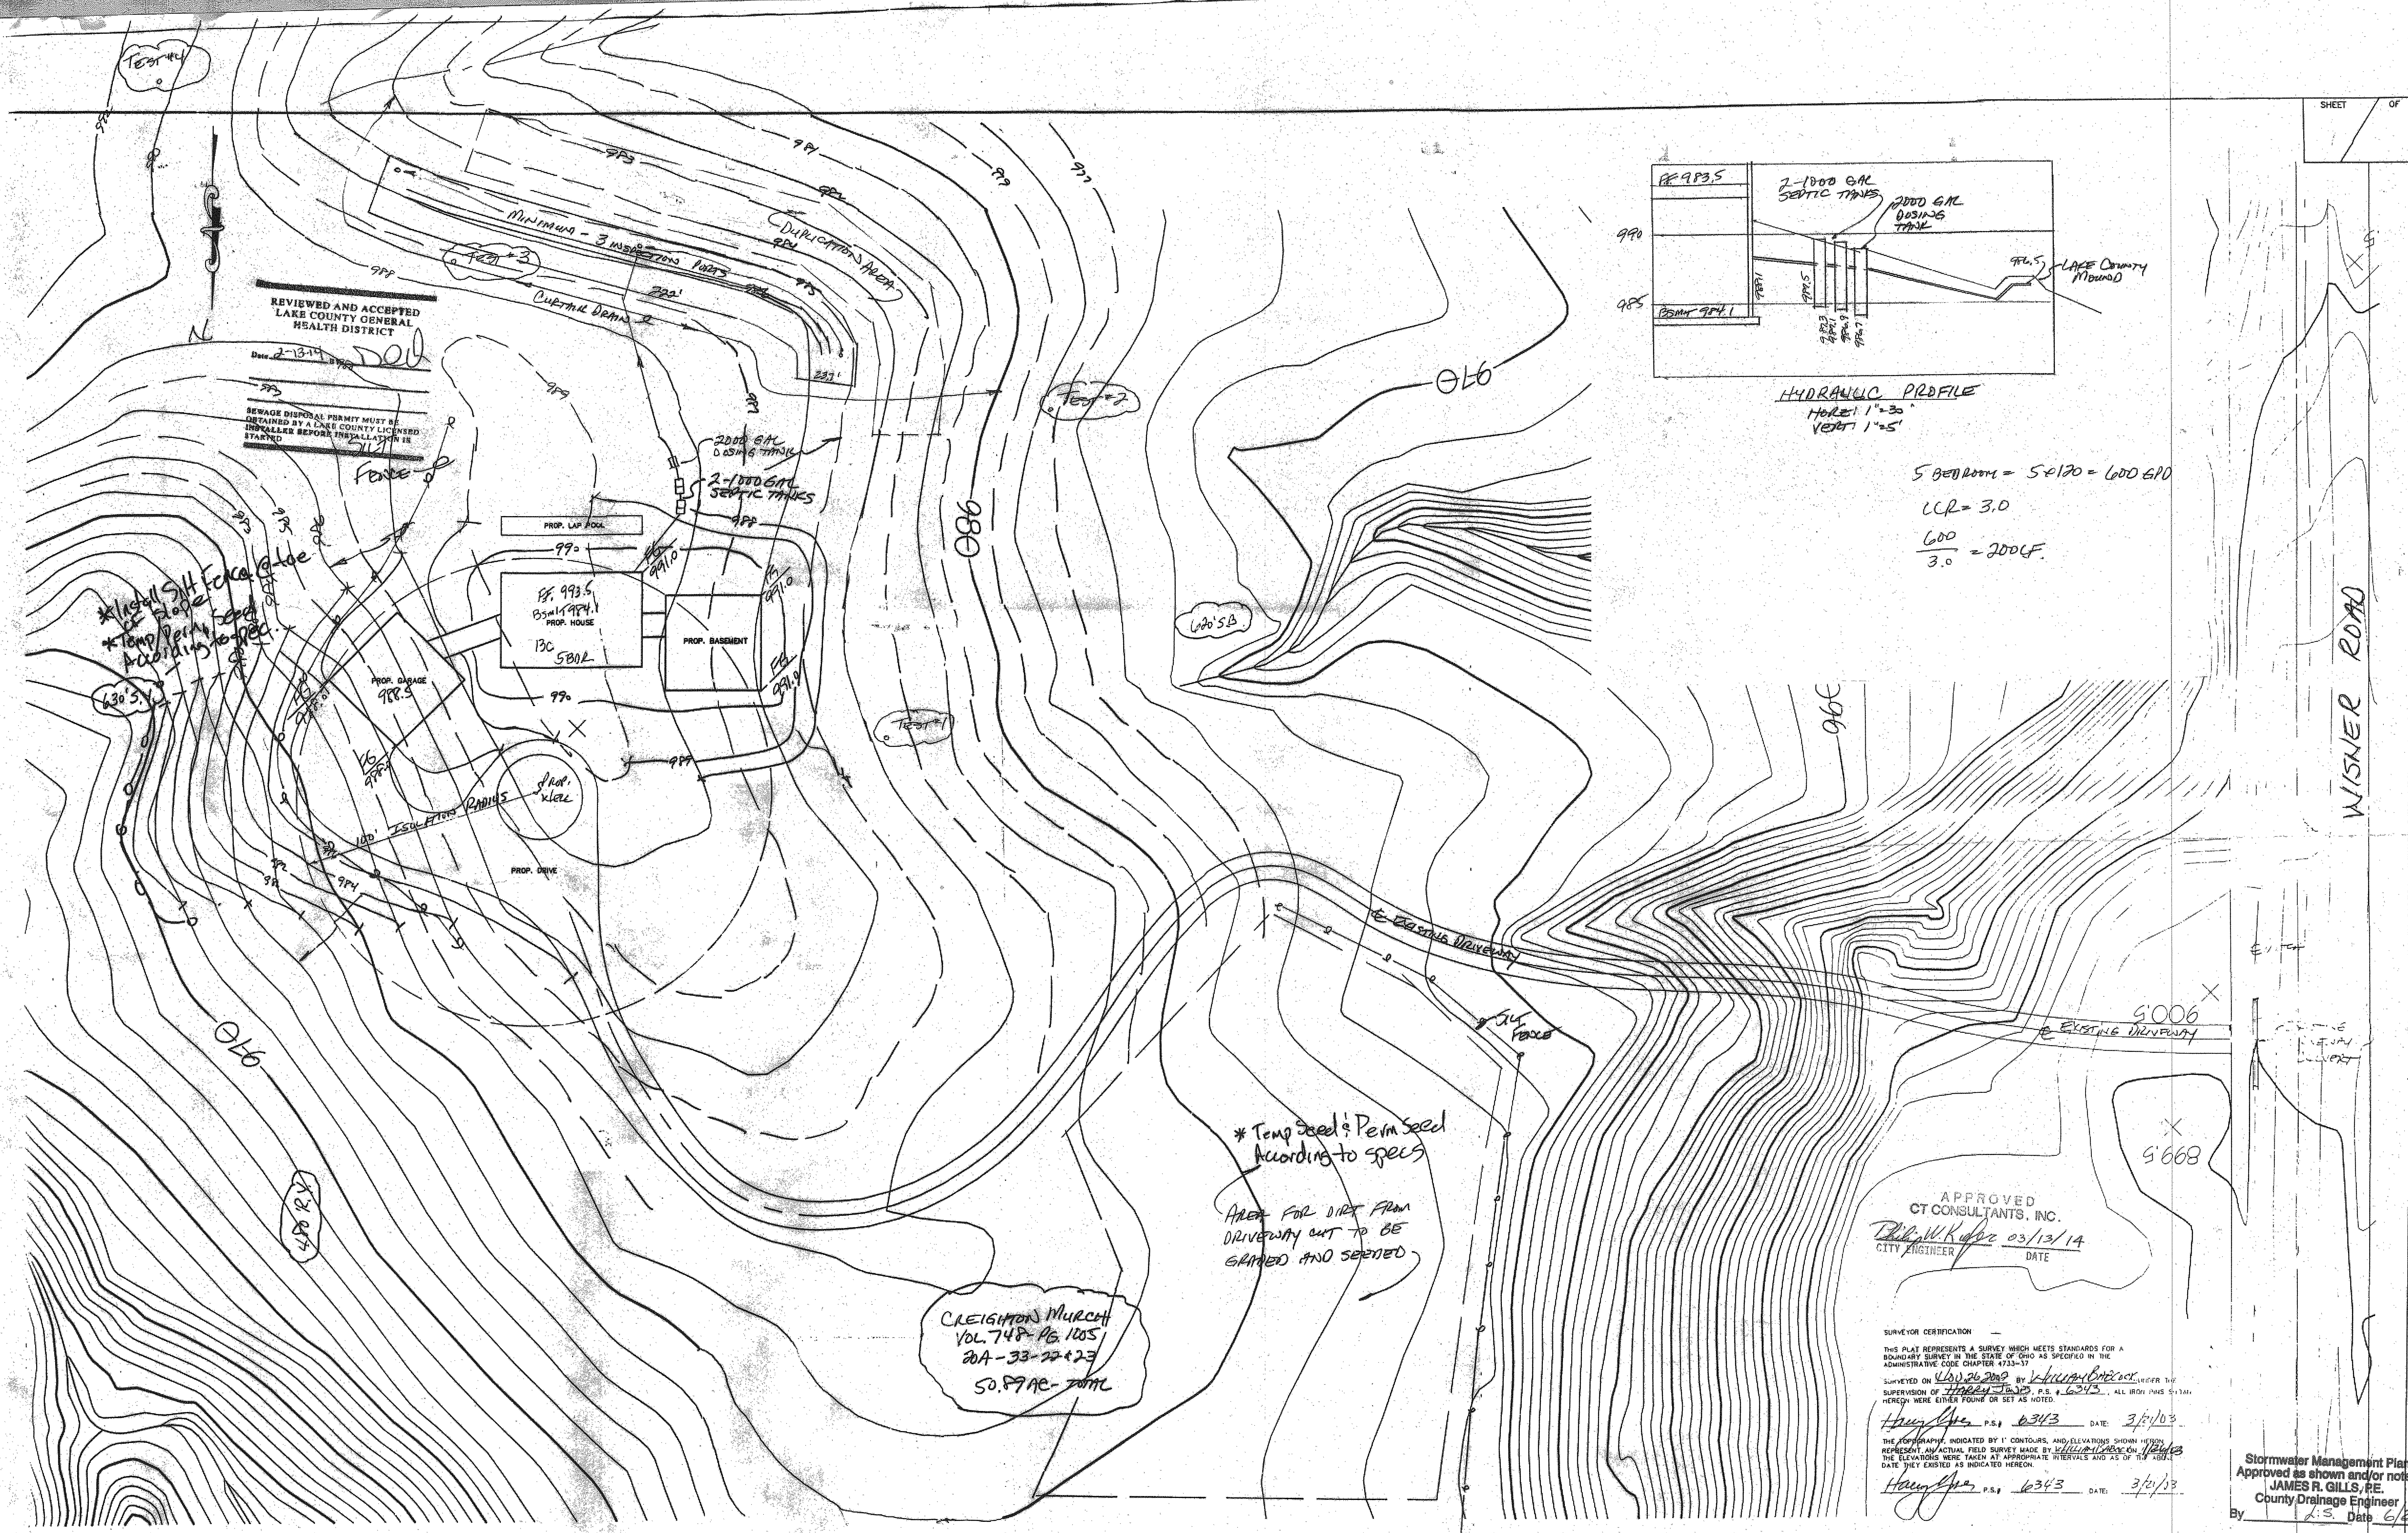

$5 \text{ BED ROOM} = 5 \times 120 = 600 \text{ GPD}$
 $\text{LCR} = 3.0$
 $\frac{600}{3.0} = 200 \text{ CF}$

APPROVED
 CT CONSULTANTS, INC.
 DATE 03/13/14
 CITY ENGINEER

SURVEYOR CERTIFICATION
 THIS PLAT REPRESENTS A SURVEY WHICH MEETS STANDARDS FOR A
 BOUNDARY SURVEY IN THE STATE OF OHIO AS SPECIFIED IN THE
 ADMINISTRATIVE CODE CHAPTER 4733-37
 SURVEYED ON 11/01/2013 BY J. H. GILLIS, P.E. UNDER THE
 SUPERVISION OF JAMES R. GILLIS, P.E. ALL IRON PINS 5/16\"/>

Stormwater Management Plan
 Approved as shown and/or noted
 JAMES R. GILLIS, P.E.
 County Drainage Engineer
 By J.S. Date 6/16/2014

NO.	DESCRIPTION	DATE	BY	CHK'D
1	ADDED SEPTIC DETAILS	3-20-03	HJ	HJ
2	ADDED 1' CONTOUR LINES FOR SEPTIC	3-29-03	HJ	HJ
3	REVISED SEPTIC SYSTEM TO MOUND	8-20-13	HJ	HJ

Jones Surveying, LLC
 ENGINEERS - SURVEYORS - PLANNERS
 1924 MENTOR AVE., PAINESVILLE, OHIO 440-357-1811
 440-357-9173 (FAX) hjonessurveying@yahoo.com

DATE	JULY 2002
DESIGN BY	H.J.
DRAWN BY	B.P.
APPROVED BY	H.J.

SITE PLAN
 FOR
 CREIGHTON MURCH
 10639 WISNER ROAD 20A-33-23
 CITY OF KIRTLAND COUNTY OF LAKE STATE OF OHIO

SCALE	1"=30'
JOB NO	02-047
SHEET	1
OF	4