


MURCH-SMITH
SITE PLAN
CITY OF KIRTLAND - LAKE COUNTY - STATE OF OHIO


INDEX OF DRAWINGS

TITLE PAGE	1
HOUSE GRADING PLAN	2
OVERALL PLAN	3
SEPTIC PLAN	4

PROJECT
LOCATION

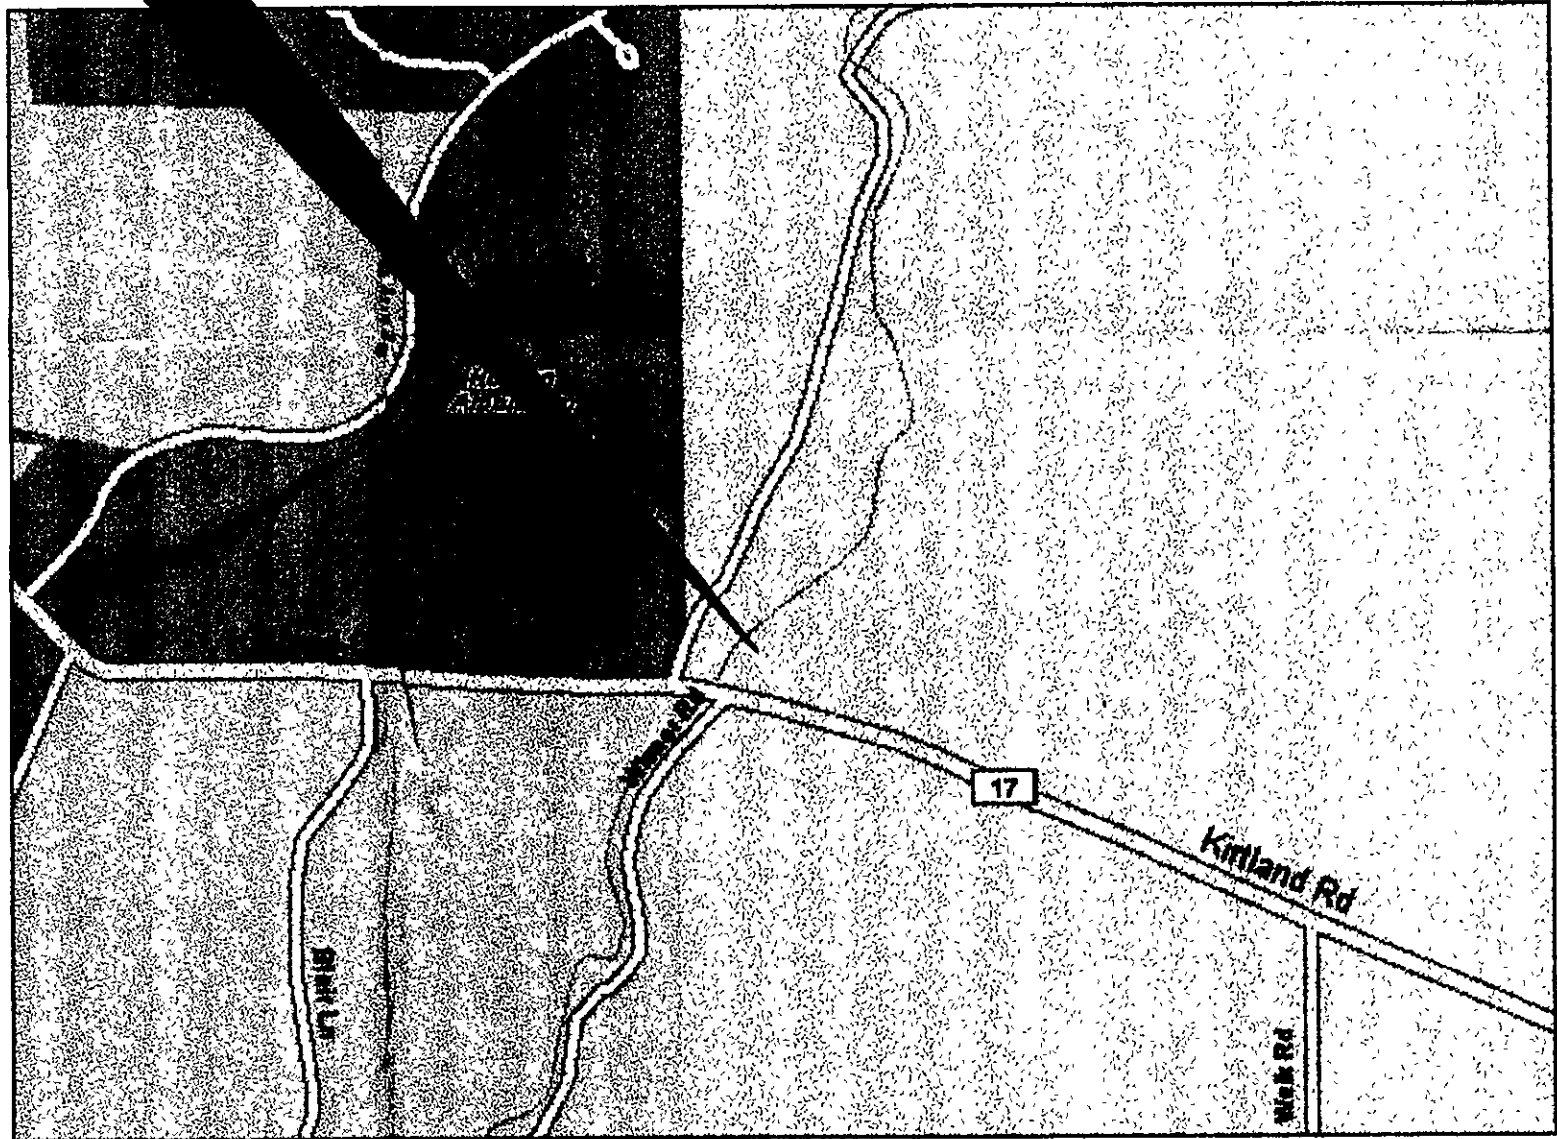

VICINITY MAP
NO SCALE

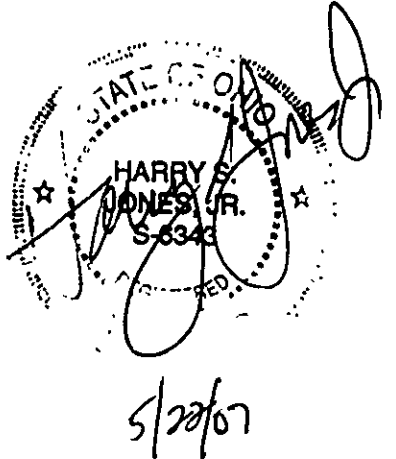

Stormwater Management Plan
Approved as shown and/or noted
JAMES R. GILLS, P.E.
County Drainage Engineer
By LS Date 6/4/07

EXISTING UTILITIES NOTE:
THE SIZE AND LOCATION, BOTH HORIZONTAL AND VERTICAL,
OF THE UNDERGROUND UTILITIES SHOWN HEREON, HAVE BEEN
OBTAINED BY A SEARCH OF AVAILABLE RECORDS.
VERIFICATION BY FIELD OBSERVATION HAS BEEN CONDUCTED
WHERE PRACTICAL, HOWEVER, BABCOCK, JONES AND ASSOCIATES
INC. DOES NOT GUARANTEE THE COMPLETENESS NOR ACCURACY
THEREOF.

REV NO.	DESCRIPTION	DATE	BY	CHK'D

COVER PAGE



BABCOCK, JONES AND ASSOCIATES, INC
CIVIL ENGINEERS - SURVEYORS - LAND PLANNERS
1924 MENTOR AVE - PAINESVILLE - OHIO 44077
PHONE 1-440-357-1811 FAX 1-440-357-9173

DATE	MAY 2007
DESIGN BY	H.J.
DRAWN BY	J.D.
APPROVED BY	H.J.
CREW CHIEF	W.B.

SITE PLAN SET
FOR
MURCH-SMITH

CITY OF KIRTLAND WISNER ROAD LAKE COUNTY STATE OF OHIO

SCALE	NONE
JOB NO	02-047
SHEET	OF
1	4