


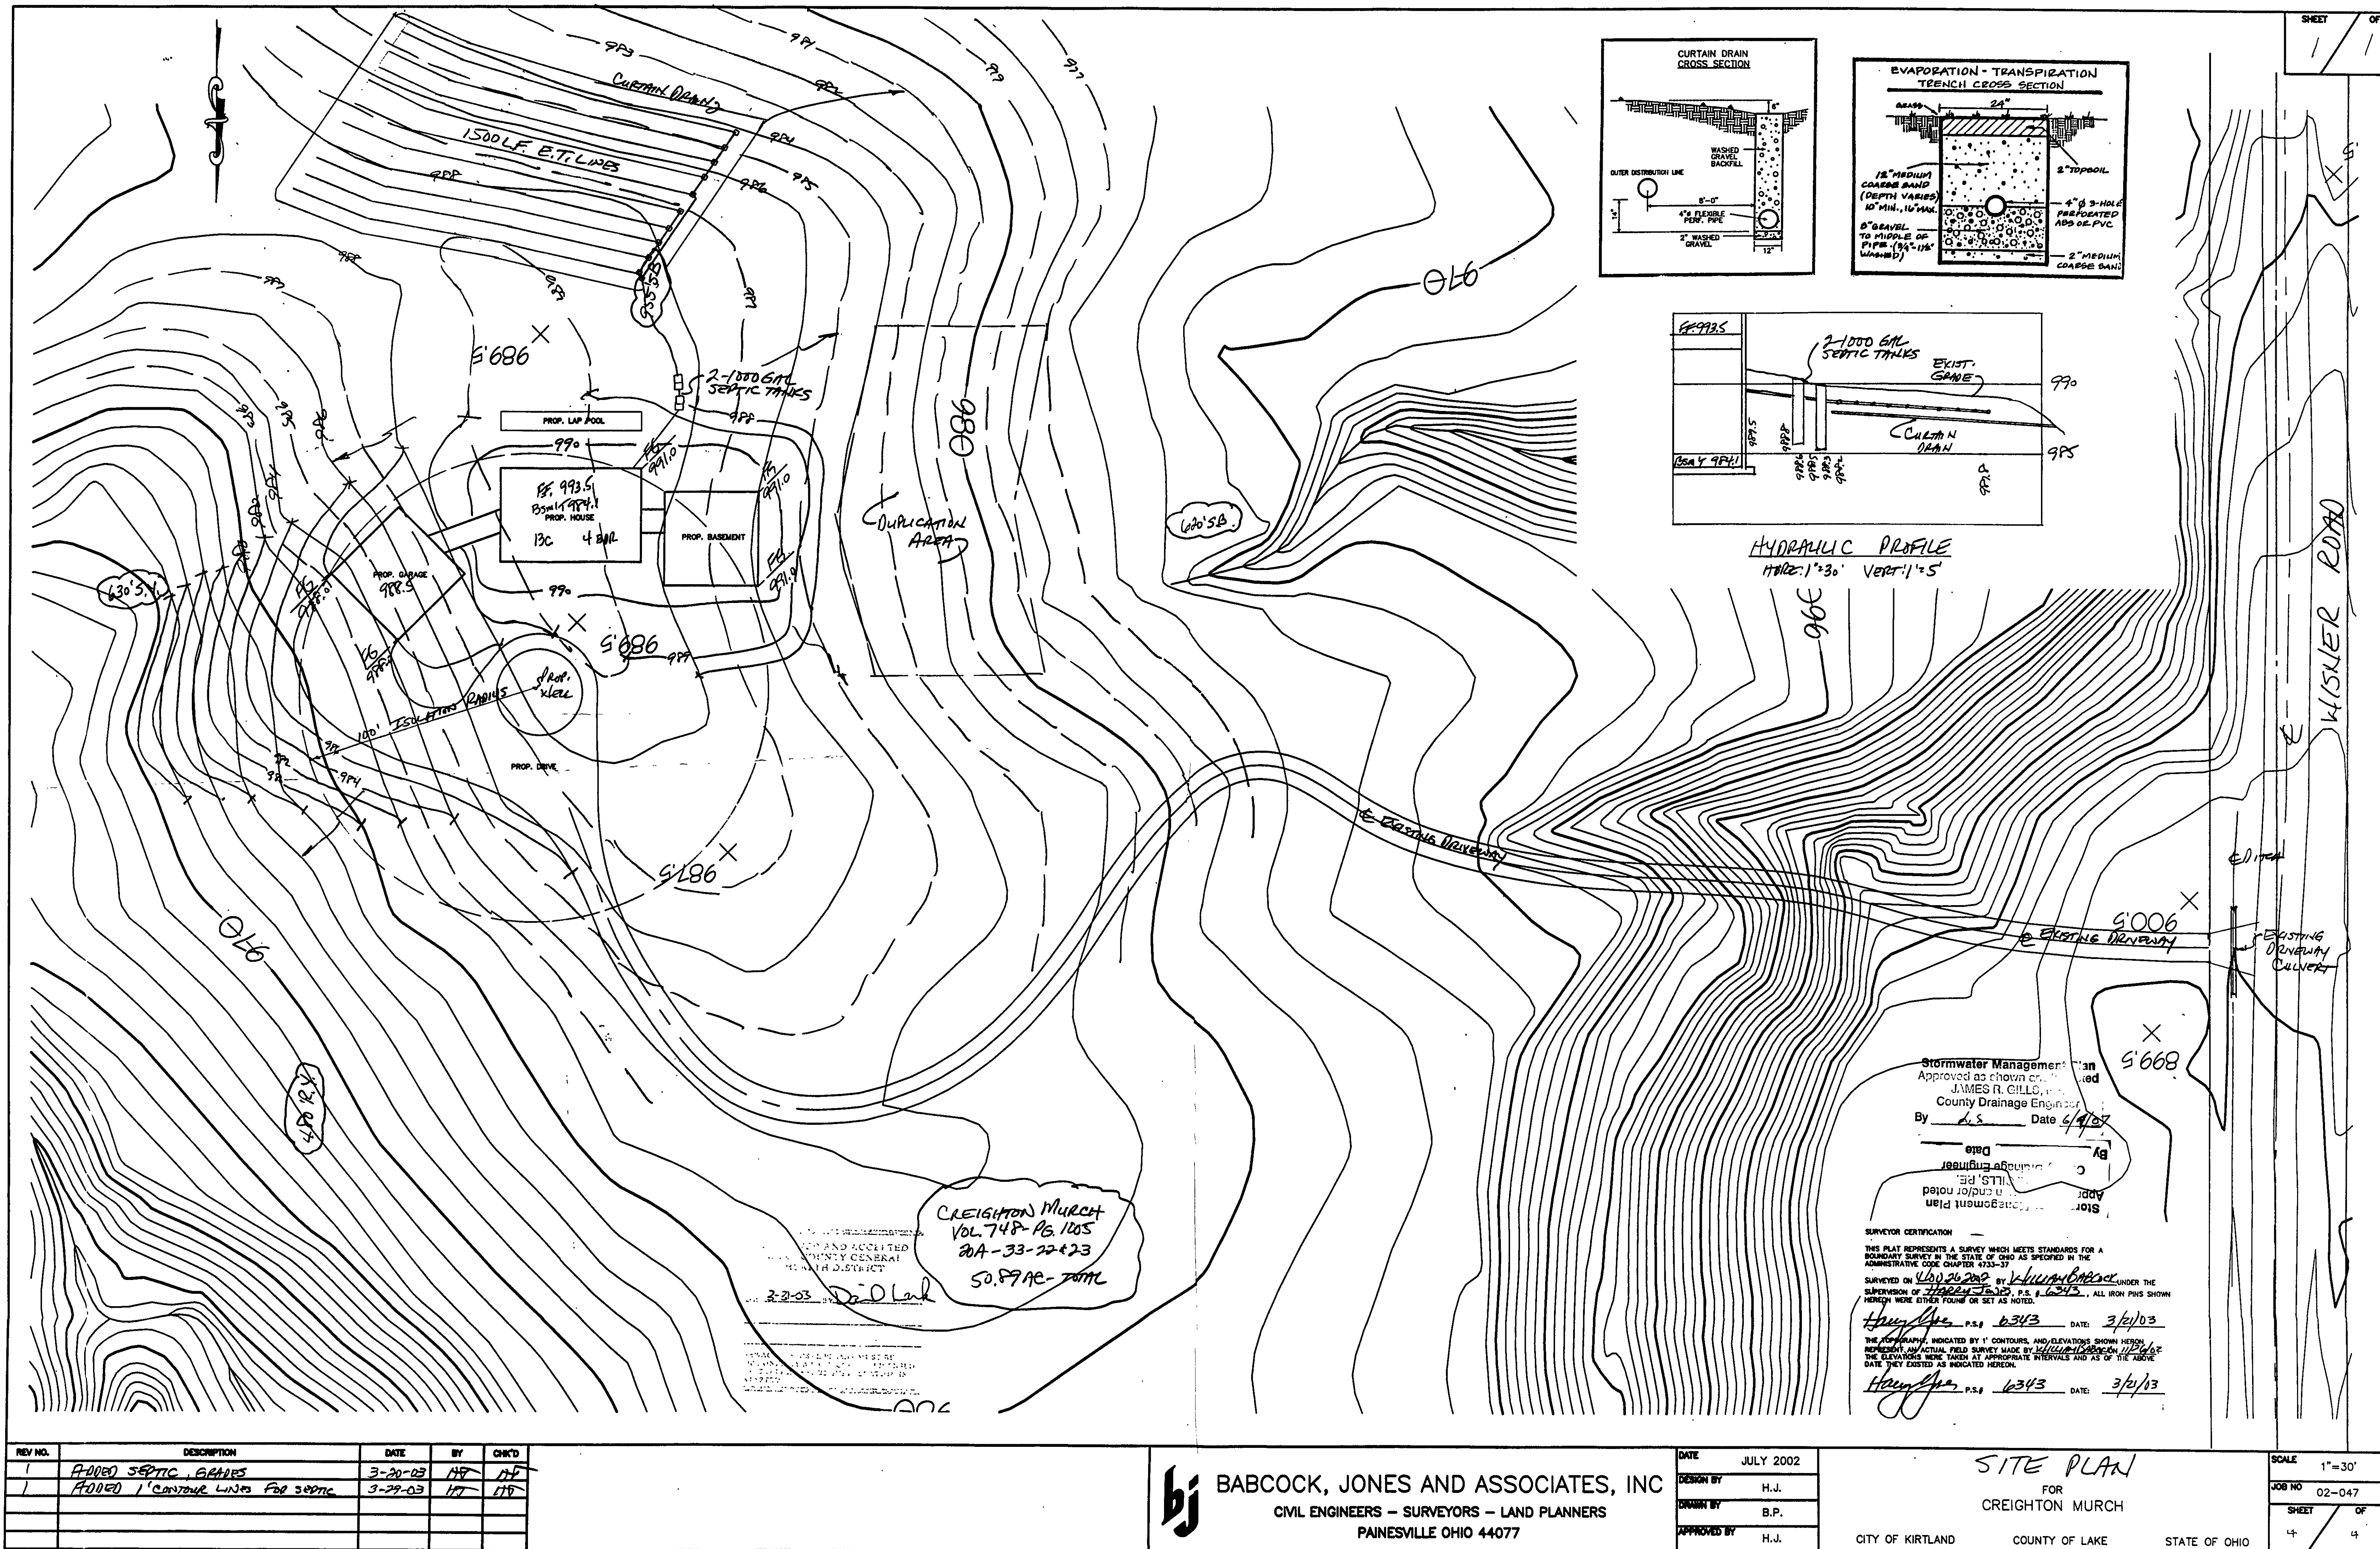

REV. NO.	DESCRIPTION	DATE	BY	CHK'D
1	ADDED SEPTIC, GRAPES	3-20-03	HJ	HJ
1	ADDED 1' CONTOUR LINES FOR SEPTIC	3-29-03	HJ	HJ



BABCOCK, JONES AND ASSOCIATES, INC
CIVIL ENGINEERS - SURVEYORS - LAND PLANNERS
PAINESVILLE OHIO 44077

DATE	JULY 2002
DESIGN BY	H.J.
DRAWN BY	B.P.
APPROVED BY	H.J.

SITE PLAN
FOR
CREIGHTON MURCH
CITY OF KIRTLAND COUNTY OF LAKE STATE OF OHIO

SCALE	1"=30'
JOB NO	02-047
SHEET	OF
4	4