

SITE PLAN

LEEDY TOWNSHIP, LAKE COUNTY, OHIO

For: MEADOW COUNTRY CO. 259-3403

CLIENT OWNER

ADDRESS STREET CITY ZIP

SECTION	VOL. - NO.	DATE	THICK	SCALE
1	25	1/22	1/2	1/2
2	26	7/26-14	1/2	1/2
3	27	7/26-14	1/2	1/2
4	28	7/26-14	1/2	1/2
5	29	7/26-14	1/2	1/2

LEGEND

SANITARY MANHOLE	---○---	WATER VALVE (GAS)	---○---
STORM MANHOLE	---●---	WATER METER (GAS)	---○---
MULTI OR CATCH BASIN	---○---	AS BUILT ELEVATION	---
HYDRANT	---○---	INDICATES	---
EXISTING CONTOURS	---	DIRECTION OF	---
PROPOSED CONTOUR	---	SURFACE DRAINAGE	---
EXIST. ELEV.	---		
PROG. ELEV.	---		

REMARKS

ALL BOUNDARY DATA SHOWN WAS OBTAINED FROM (PERS. RECORDED) SUBDIVISION PLAT OR OTHER PUBLIC RECORDS. LOCATIONS AS SHOWN OF ADJACENT WELLS AND SEPTIC TANKS OBTAINED FROM LAKE COUNTY HEALTH DEPARTMENT.

DESIGN CERTIFICATION

THIS PLAN WAS PREPARED BY ME, AND IS CORRECT TO THE BEST OF MY KNOWLEDGE AND BELIEF.

NAME THOMAS P. GILLES, P.E. SURVEYOR REGISTRATION NO. 357-1811

CHECK LIST

NO. OF SEPTIC TANKS	NO. OF SEPTIC TANKS	NO. OF SEPTIC TANKS	NO. OF SEPTIC TANKS	NO. OF SEPTIC TANKS
1	2	3	4	5
1	2	3	4	5
1	2	3	4	5
1	2	3	4	5

PLAN PREPARED BY:

BABCOCK • JONES & ASSOCIATES, INC.

FAIRBANKS, OHIO

NO.	DATE	BY	SCALE	DATE	PHONE NO.
1	1/22	THOMAS P. GILLES	1" = 40'	1/22	357-1811
2	7/26	THOMAS P. GILLES	1" = 40'	7/26	357-1811
3	7/26	THOMAS P. GILLES	1" = 40'	7/26	357-1811
4	7/26	THOMAS P. GILLES	1" = 40'	7/26	357-1811
5	7/26	THOMAS P. GILLES	1" = 40'	7/26	357-1811

"AS BUILT" CERTIFICATION

I, HEREBY CERTIFY THAT THE CIRCLED GRADES ARE EXISTING FINISH GRADES CHECKED IN THE FIELD ON 19 AND ARE CORRECT TO THE BEST OF MY KNOWLEDGE AND BELIEF.

REGISTERED SURVEYOR

REG. NO.

TEMP. BENCHMARK: TOP OF 1/2" DIA. CONCRETE TIE ROD, ELEV. = 100.00

LOW YIELD WATER FIXTURES REQUIRED ON ALL:

- Shower Head
- Toilet

1st Floor F.F. Per Approved Site Plan

1st Floor F.F. Per "As-Built" Site Plan




As Shown and/or noted as shown and/or noted

THOMAS P. GILLES, P.E.
Lake County Engineer

By 6/11 Date 4/26/93


WILLIAM L. ASHLEY, JR. P.E. DRIVE

N

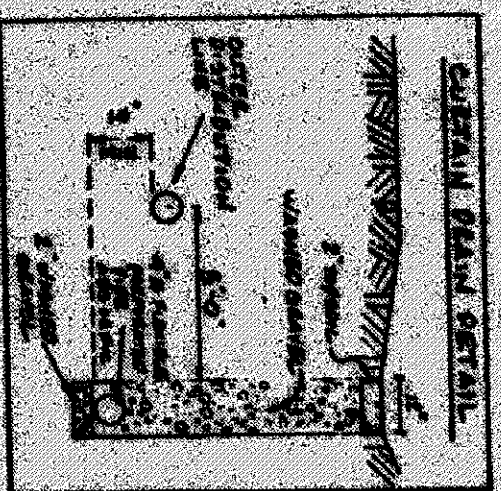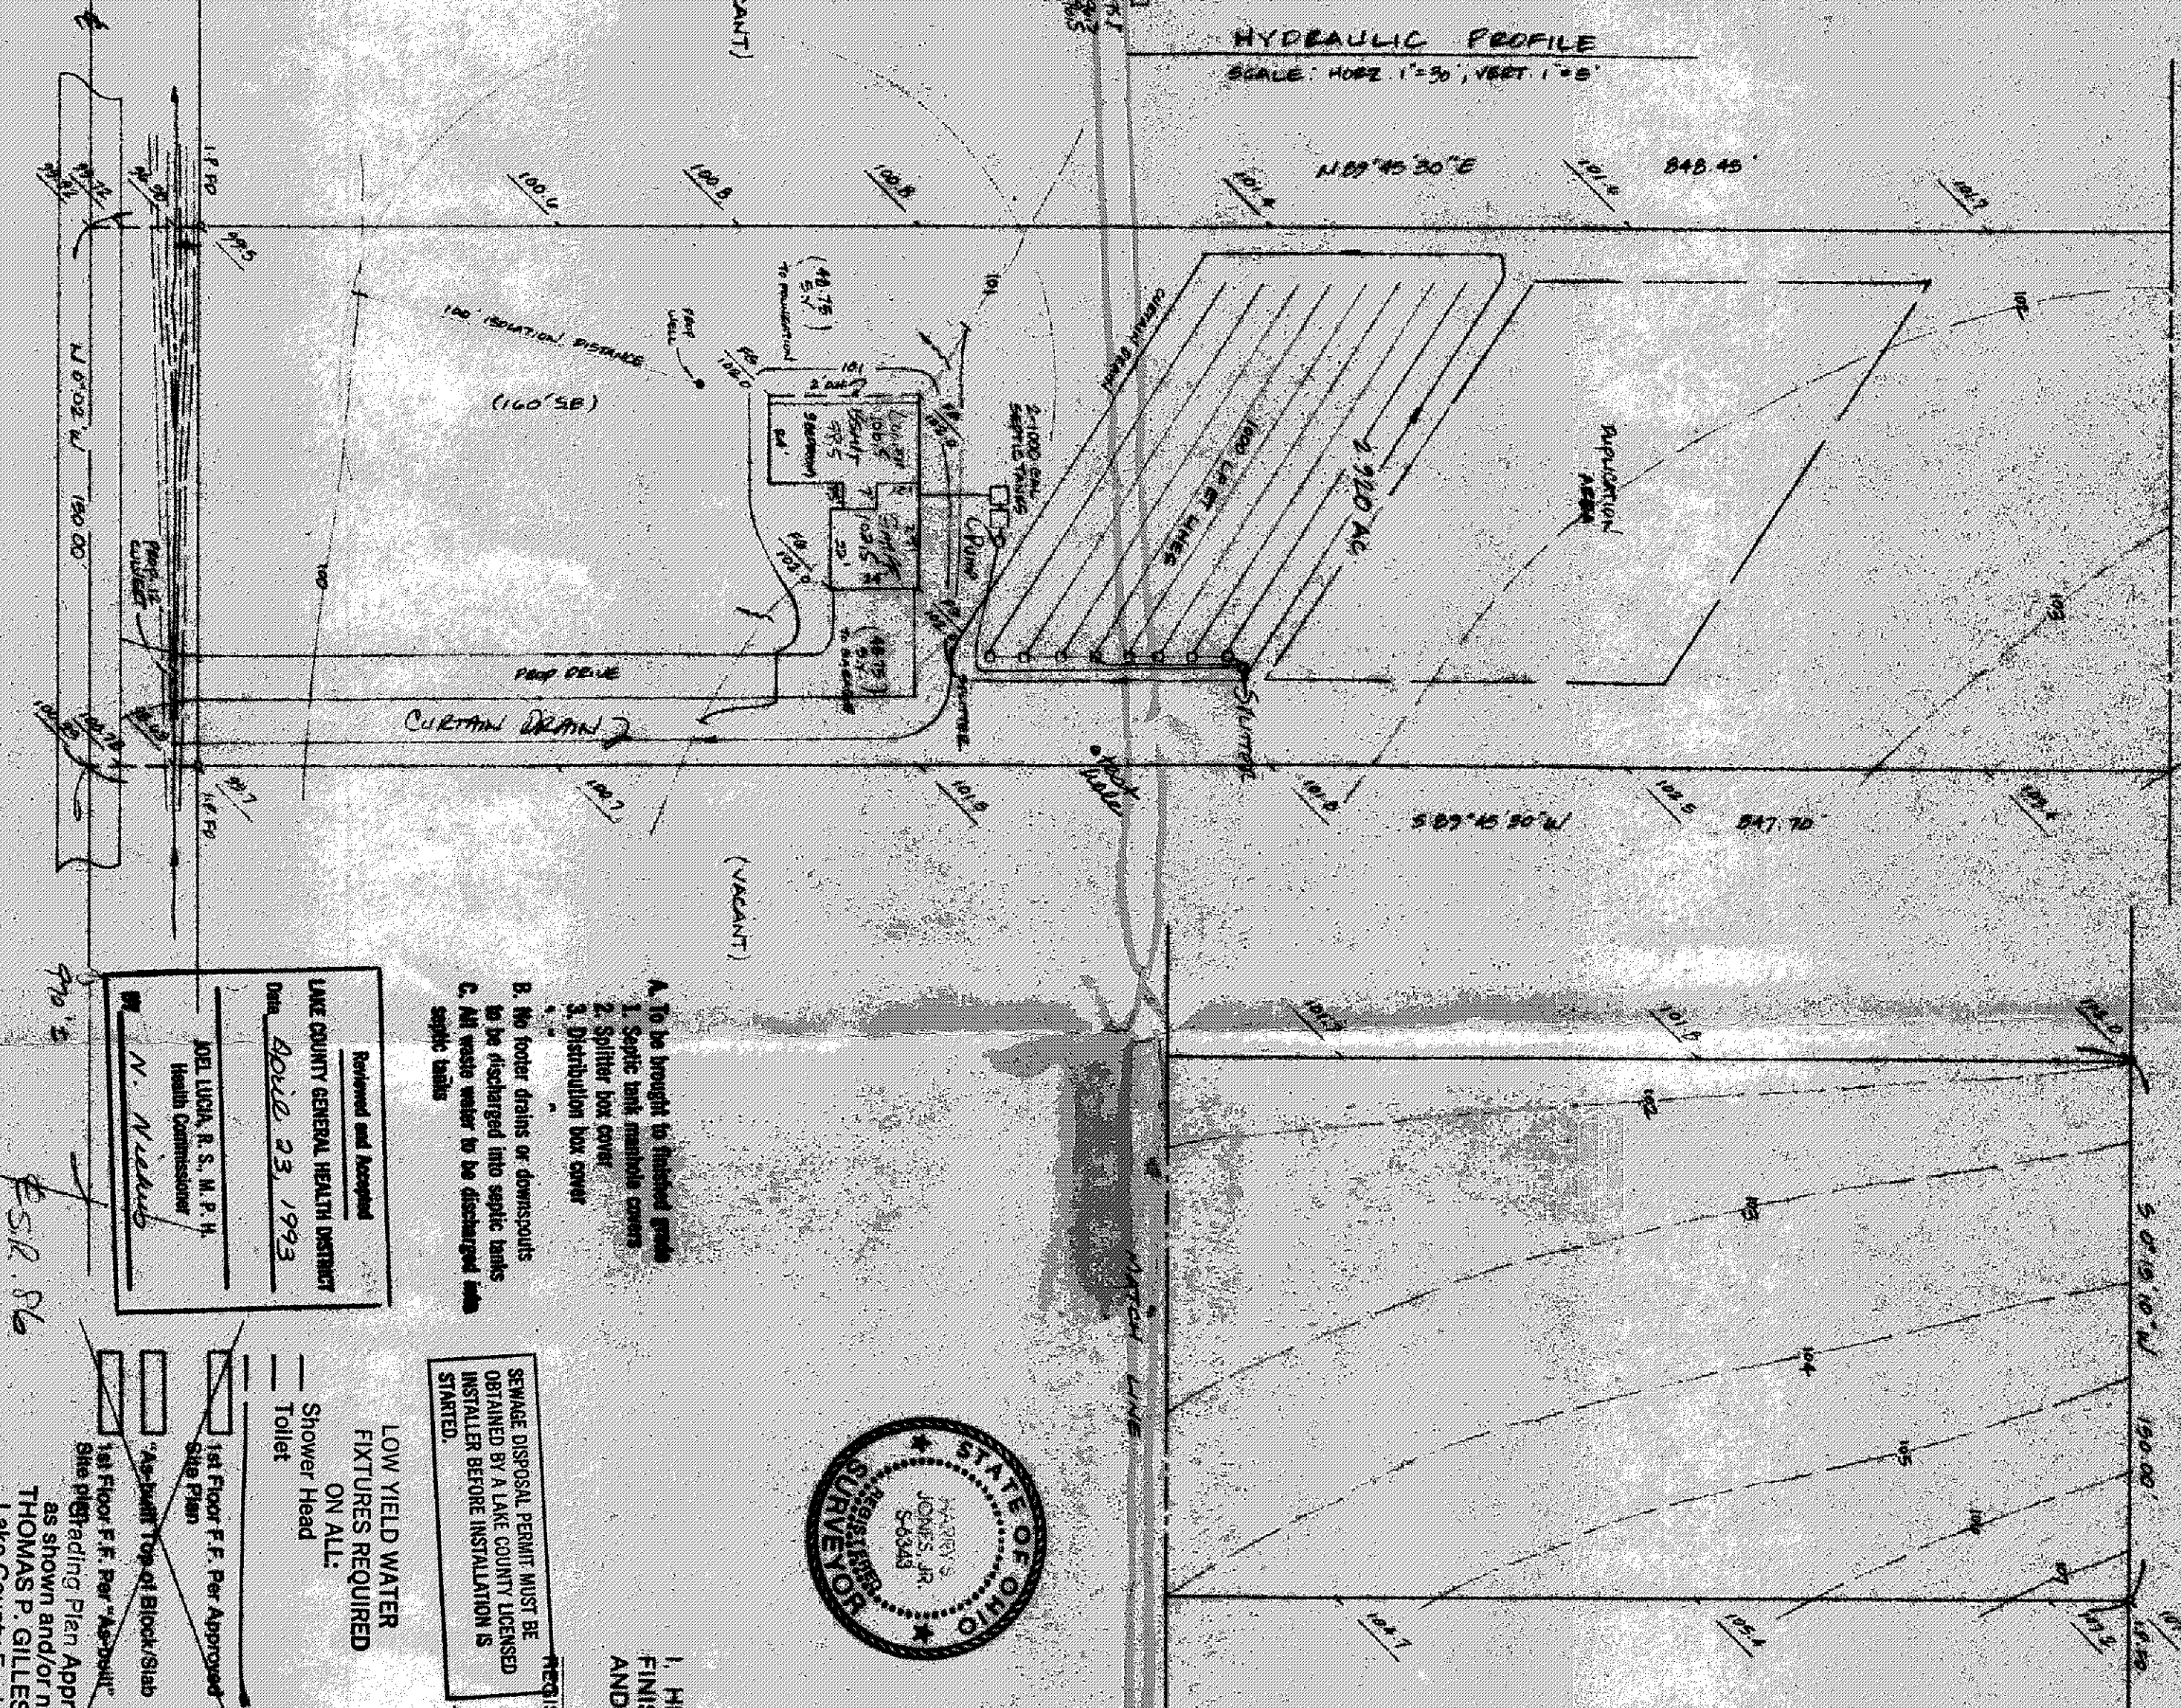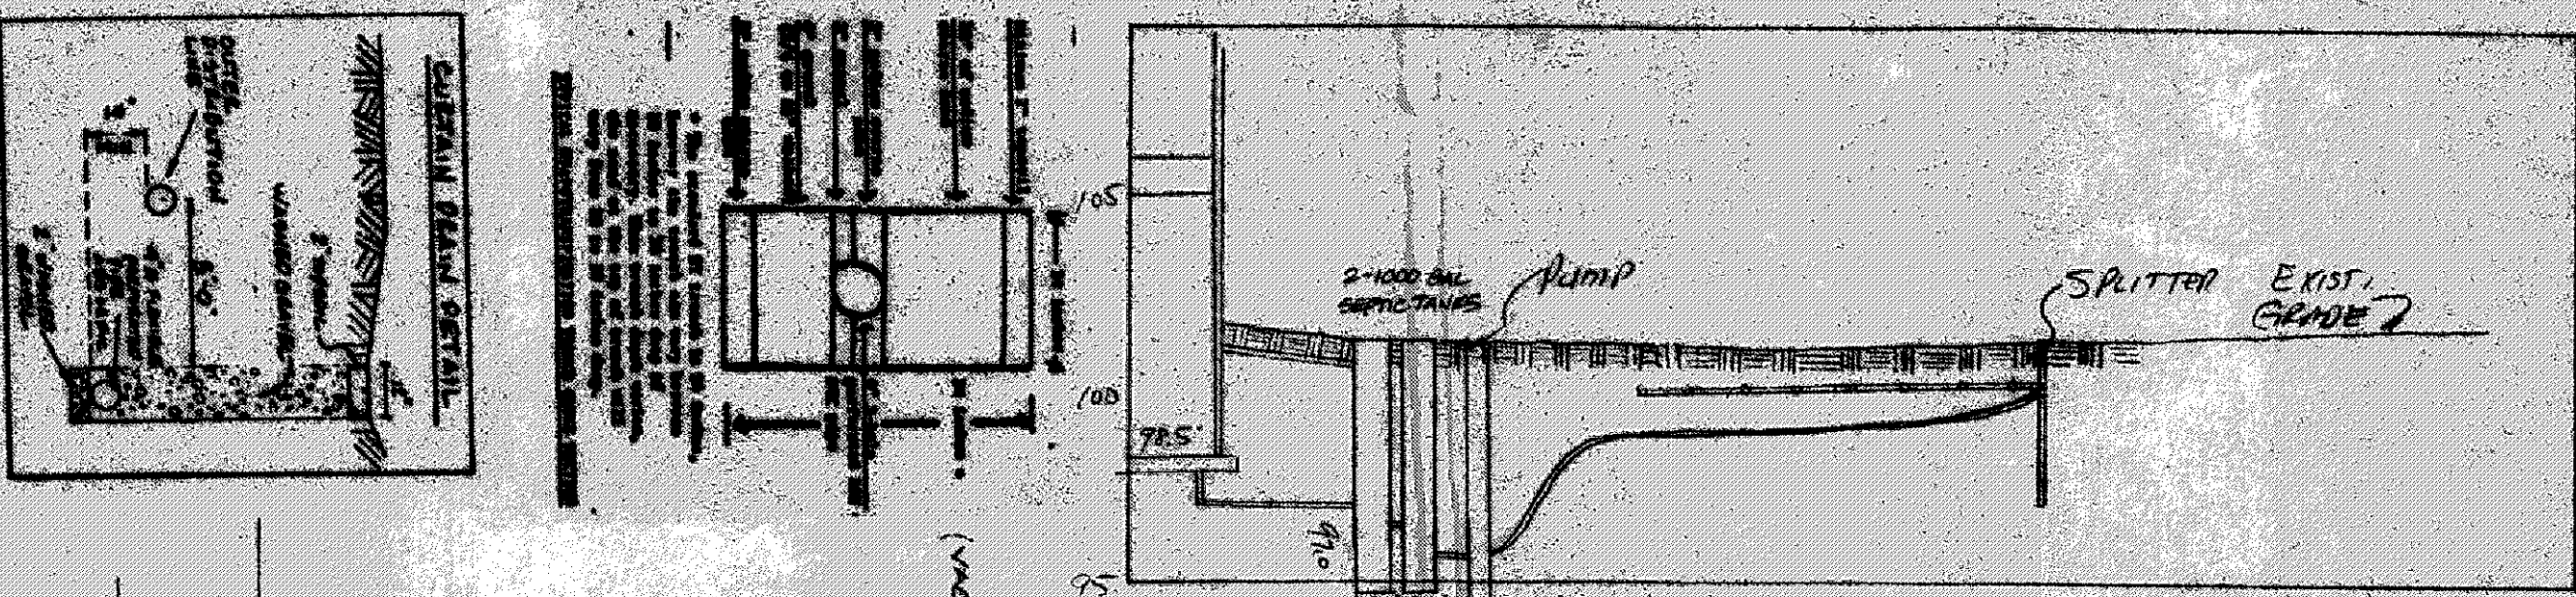

Reviewed and Accepted
LAKE COUNTY GENERAL HEALTH DISTRICT
Date APRIL 23, 1993
JOEL LUCIA, R. S. M. P. H.
Health Commissioner

- To be brought to finished grade
 - Septic tank manhole covers
 - Splitter box cover
 - Distribution box cover
- No footer drains or downspouts to be discharged into septic tanks
 - All waste water to be discharged into septic tanks

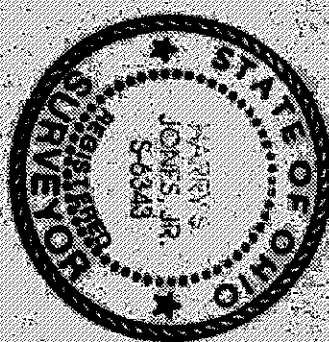

1. The undersigned hereby certify that this topography indicated by 6", 1" or 2" contours, and elevations shown hereon represent an actual field survey made by me on the 19th day of April, 1993 and that the elevations were taken at appropriate intervals and that as of that date they existed as indicated hereon.

THOMAS P. GILLES, P.E.
Lake County Engineer
Reg. No. 357-1811