
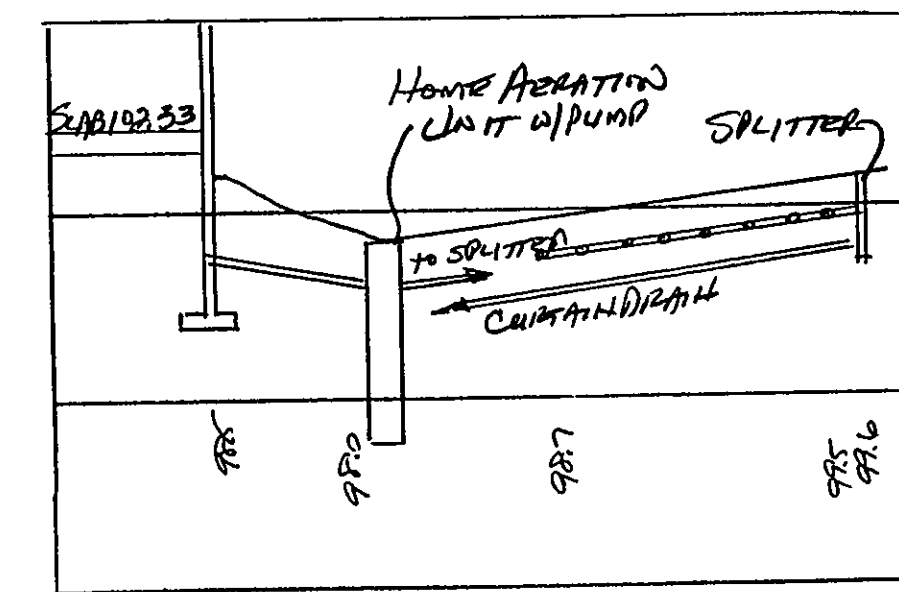
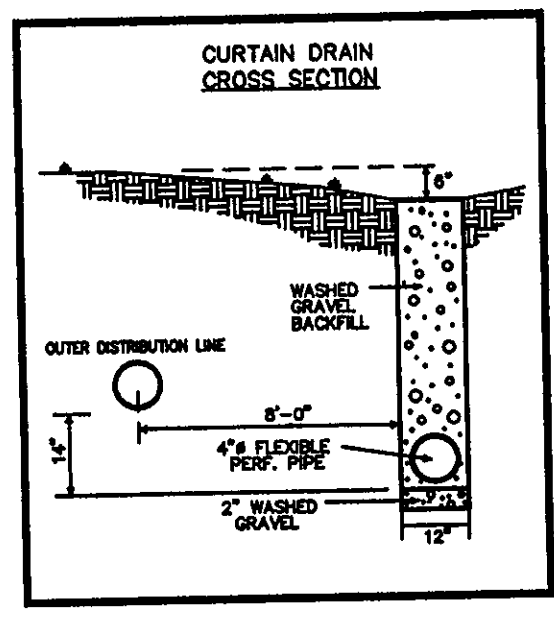


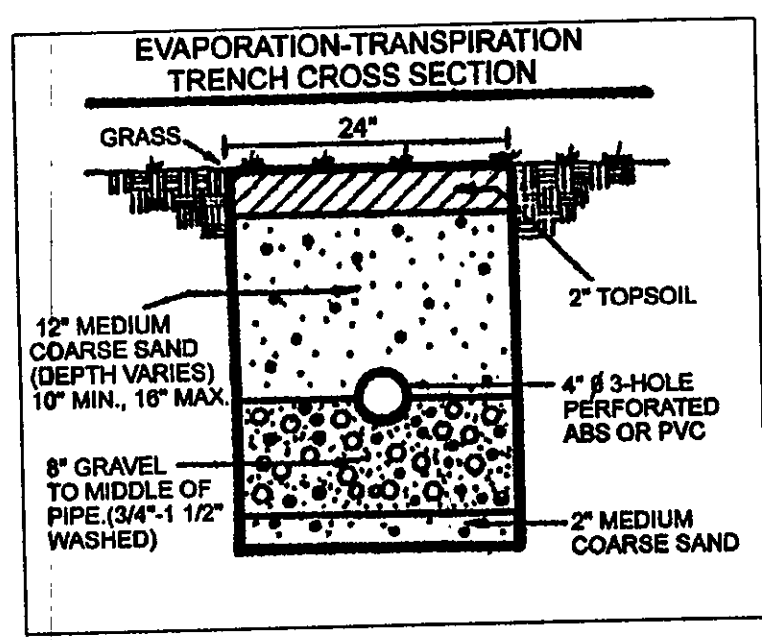

REVIEWED AND ACCEPTED
LAKE COUNTY GENERAL
HEALTH DISTRICT

DATE 9-4-02
JAMES R. GILLS, P.E.

SEWAGE DISPOSAL PERMIT MUST BE
OBTAINED BY A LAKE COUNTY LICENSED
INSTALLER BEFORE INSTALLATION IS
STARTED.

GEORGE LASSNICK, JR.
#200230228
7A-50-31

HYDRAULIC PROFILE
HORIZ: 1"=30' VERT: 1"=5'

N 89°54'30" W 580.80'

GEORGE LASSNICK, JR.
#200230228
7A-50-32

N 89°54'30" W 580.80'

GEORGE LASSNICK, JR.
#200230228
7A-50-33

HITTWASGA


LLR - 29
BSR - 0.6

TEST HOLE
#2
w/ rock

N 89°54'30" W 493.97'

7A-50-30

7A-50-4

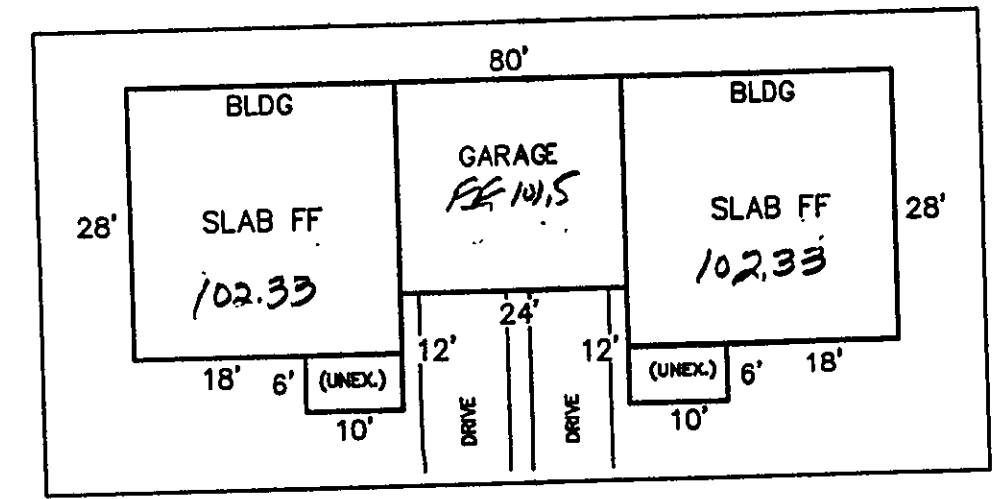

"I, the undersigned hereby certify that this topography indicated by 6", 1" or 2" contours, and elevations shown hereon represent an actual field survey made by me on the 21st day of May, 2002, and that the elevations were taken at appropriate intervals and that as of that date they existed as indicated hereon."

Name: James R. Gills, P.E. Reg. No. 6343

TM-TOP OF IRON PIN
ELEV=101.01

EXISTING UTILITIES NOTE:
THE SIZE AND LOCATION, BOTH HORIZONTAL AND VERTICAL OF THE UNDERGROUND UTILITIES SHOWN HEREON, HAVE BEEN OBTAINED BY A SEARCH OF AVAILABLE RECORDS. VERIFICATION BY FIELD OBSERVATION HAS BEEN CONDUCTED WHERE PRACTICAL. HOWEVER, BABCOCK, JONES AND ASSOCIATES, INC. DOES NOT GUARANTEE THE COMPLETENESS NOR ACCURACY THEREOF.

Grading Plan Approved
as shown and/or noted
JAMES R. GILLS, P.E.
Lake County Engineer


By: JRG Date: 9/17/02

BRAKEMAN ROAD 60'

address 7470 7472

panel C
S/L 2

REV. NO.	DESCRIPTION	DATE	BY	CHK'D
1	120,580 SEPTIC	7-13-02	HR	HR
2	REVISED SEPTIC	8-15-02	HR	HR

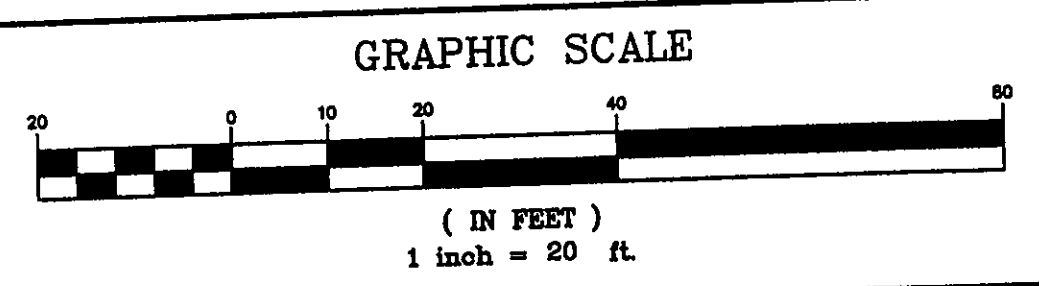

bj BABCOCK, JONES AND ASSOCIATES, INC
CIVIL ENGINEERS - SURVEYORS - LAND PLANNERS
PAINESVILLE OHIO 44077

DATE 7/15/02
DESIGN BY HR
DRAWN BY B.P.
APPROVED BY HR

SITE PLAN
FOR
GEORGE LASSNICK
LEROY TOWNSHIP LAKE COUNTY OHIO

SCALE 1"=20'
JOB NO 02-018-C
SHEET 1 OF 2