


LOW YIELD WATER
FIXTURES REQUIRED
ON ALL:
Shower Head
Toilet

Reviewed and Accepted
LAKE COUNTY GENERAL HEALTH DISTRICT
Date 2-8-88
JOEL LUCHA, R.S., M.P.H.
Health Commissioner
BY John C. Skoneczny

2-Bedroom

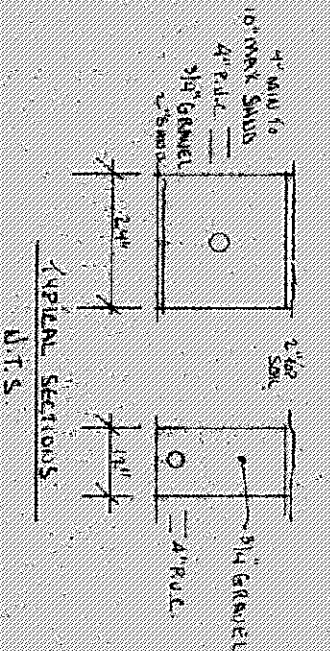

- A. To be brought to finished grade
1. Septic tank manhole covers
 2. Splitter box cover
 3. Distribution box cover
- B. No footer drains or downspouts to be discharged into septic tanks
- C. All waste water to be discharged into septic tanks


SEWAGE DISPOSAL PERMIT MUST BE OBTAINED BY A LAKE COUNTY LICENSED INSTALLER BEFORE INSTALLATION IS STARTED.

Grading Plan Approved
as shown and/or noted
THOMAS R. GILLES, P.E.
Lake County Engineer

BY THP Date 2.8.88

For installation of Septic only.
No Proposed structure shown.

I CERTIFY THAT THIS PLAN
WAS PREPARED BY ME AND
IS CORRECT TO THE BEST OF
MY KNOWLEDGE AND BELIEF
John C. Skoneczny
REG. SURVEYOR #53840
JOHN C. SKONECZNY
7733 VERMONT DR.
PAINESVILLE, OHIO 44077
PH. 352-7742

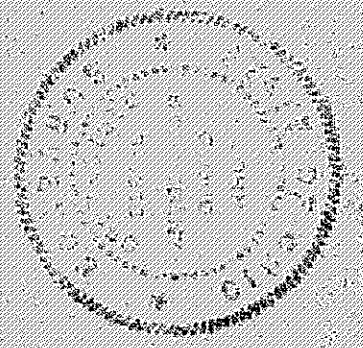

SITE PLAN FOR:
BROWER CONTRACTING, INC.

SCALE: 1"=50'
DATE: FEB 88
DESIGNED BY: J.C.S.
DRAWN BY: J.C.S.
CHECKED BY: J.C.S.
APPROVED BY: J.C.S.

JOHNSHIP OF LEADY COUNTY OF LAKE STATE OF OHIO
P.P.# 7A-10-26

