

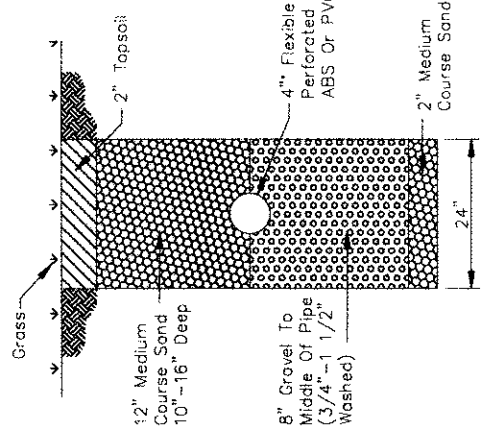
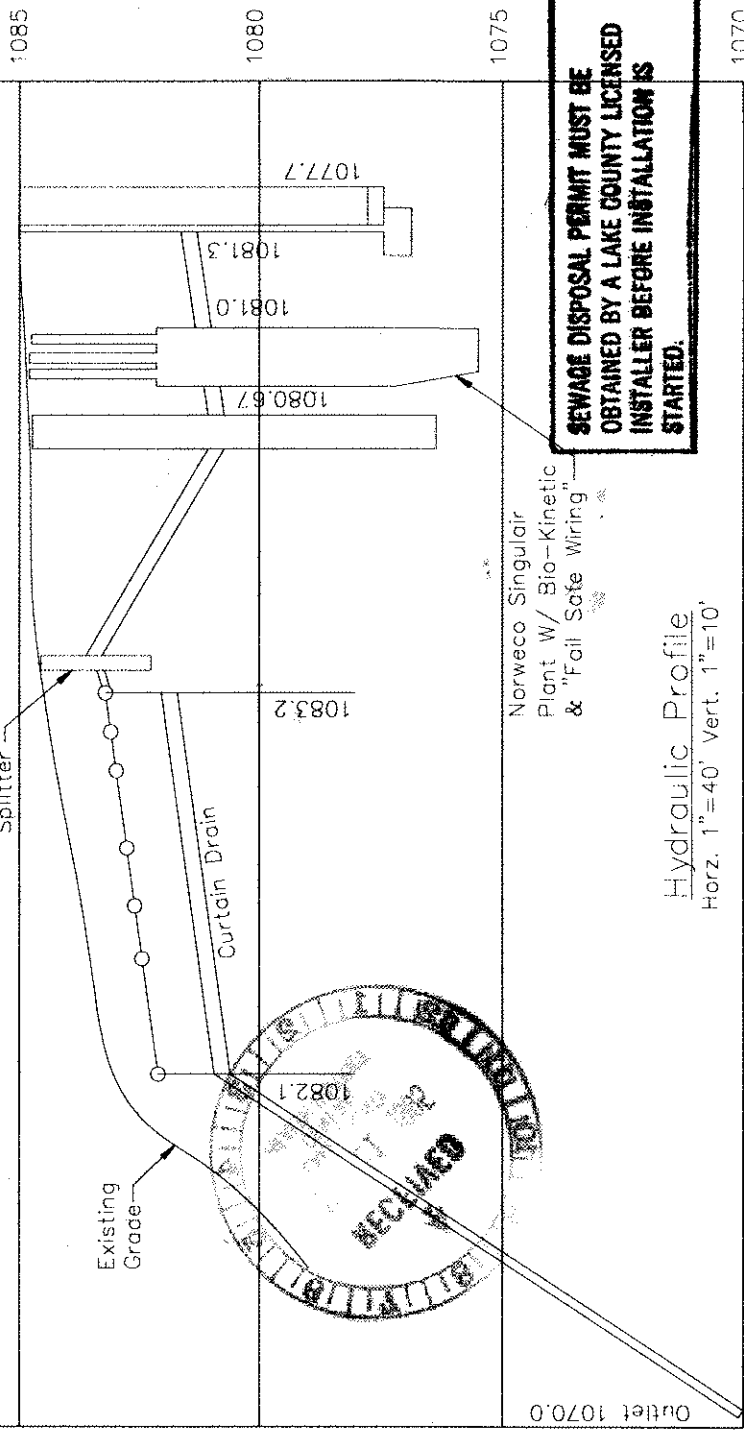
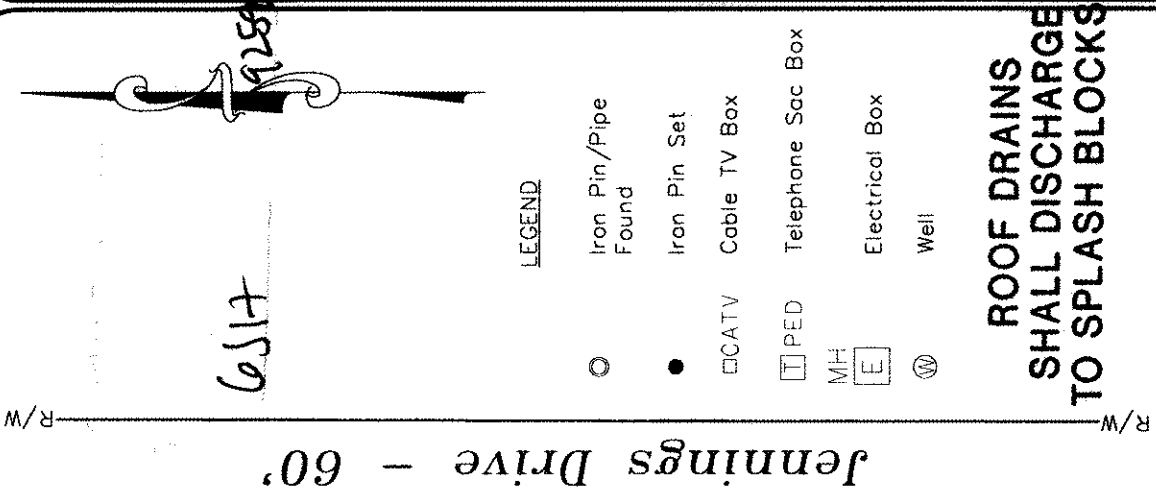


EVAPORATION-TRANSPIRATION
TRENCH CROSS-SECTION

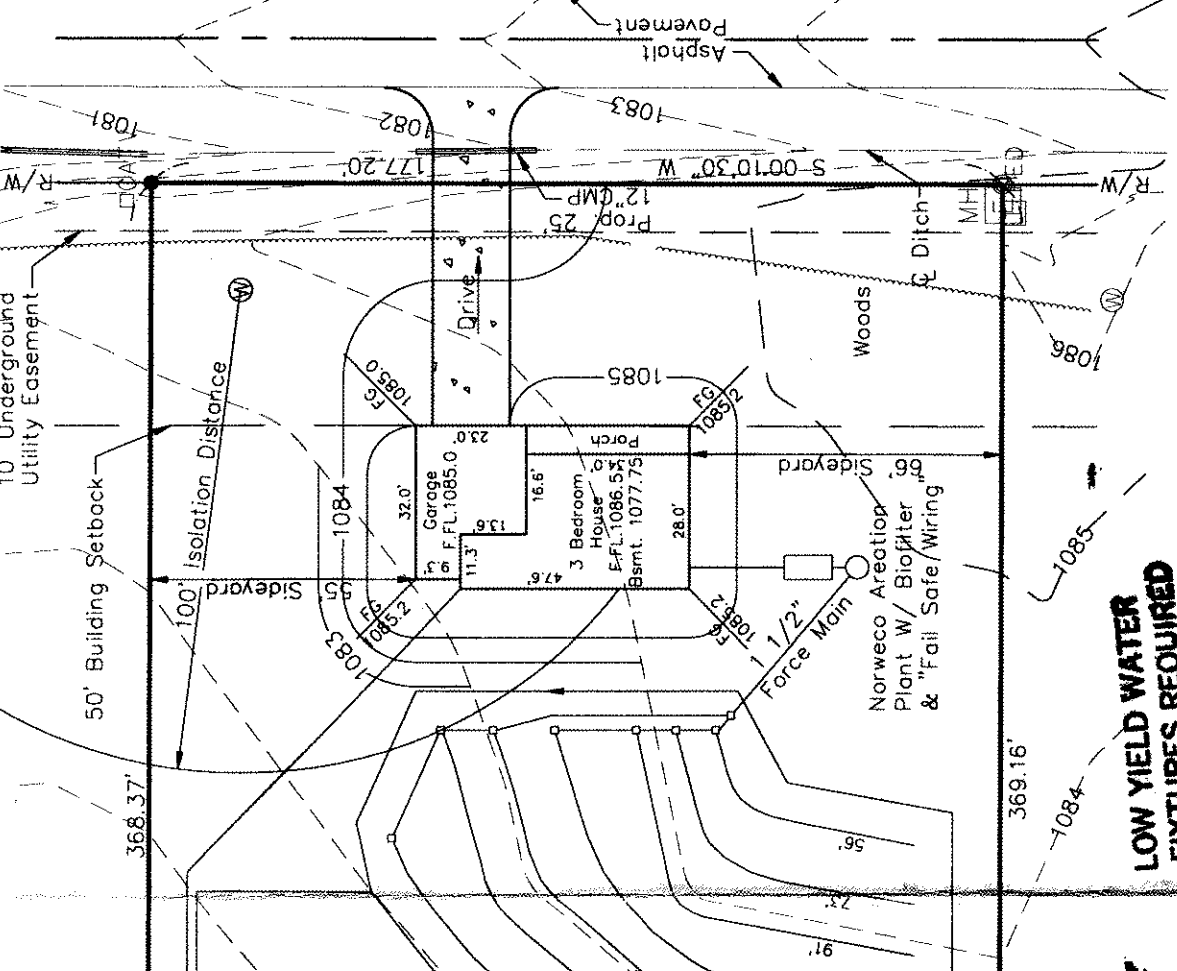


Reviewed and Accepted
LAKE COUNTY GENERAL HEALTH DISTRICT
Date 9-21-95
May need to revise plumbing
so as to meet code too deep
JOEL LUCIA, R. S., M. P. H.
Health Commissioner
BY J. Lindberg

Doris Lipman
Vol. 775 - Pg. 1164

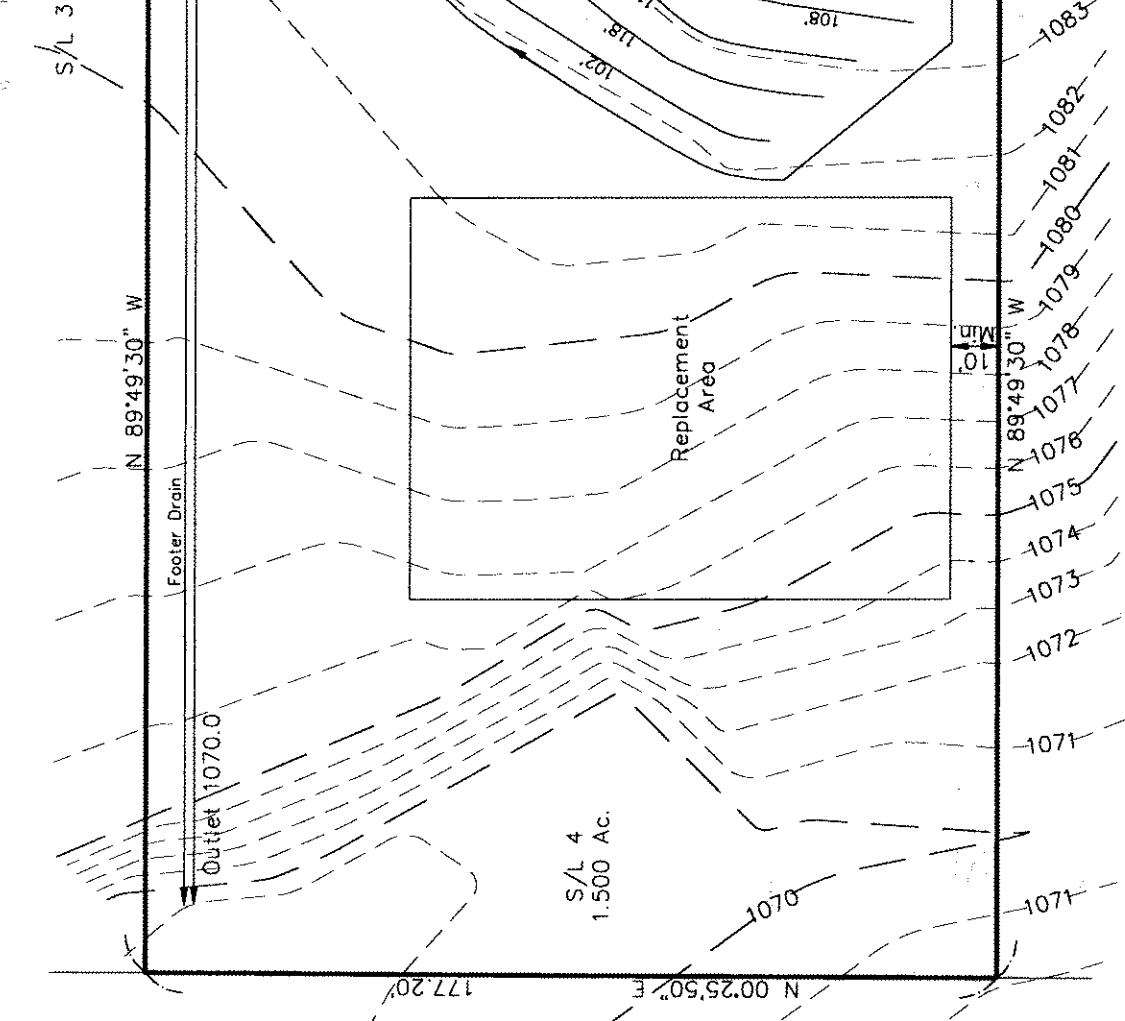

- LOW YIELD WATER
FIXTURES REQUIRED
ON ALL:**
- Shower Head
 - Toilet
- APPROVED**
- BY *James B. Lip* DATE *9/20/95*
- LDC INC.**
- SEWAGE DISPOSAL PERMIT MUST BE
OBTAINED BY A LAKE COUNTY LICENSED
INSTALLER BEFORE INSTALLATION IS
STARTED.**

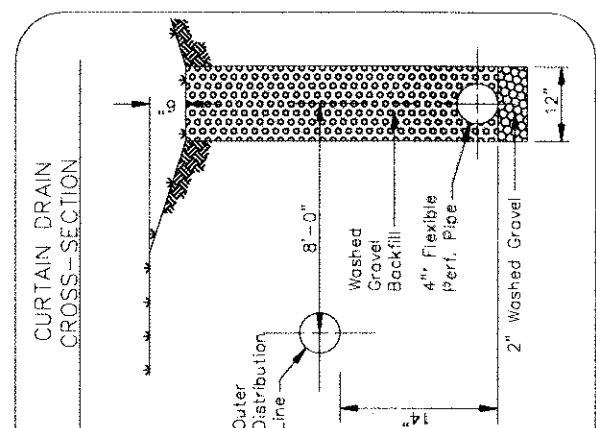

Topography information depicted hereon is based on an actual field survey conducted in Sept., 1995 by Foresight Engineering Group, Inc.

**Foresight Engineering Group
Engineers & Surveyors**
216 286-1010
216 286-1034 fax
216 Center Street, Unit F
Chardon, Ohio 44024

REVISIONS:	
SCALE: 1"=40'	Vert. NONE
FILE NAME:	E:\MCC19501\TOP0
DATE:	September, 1995

McCullough Builders
Eagle Brook Subdivision S/L 4
Leroy Twp. - Geauga County - Ohio
Site Plan