



EVAPORATION - TRANSPIRATION TRENCH CROSS SECTION

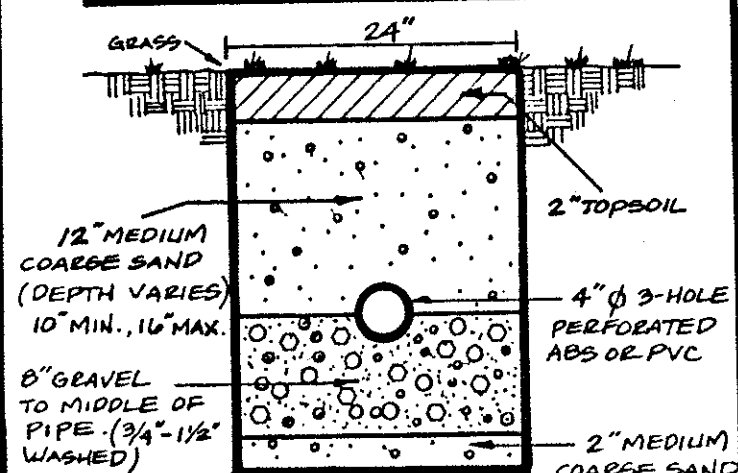

CURTAIN DRAIN CROSS SECTION

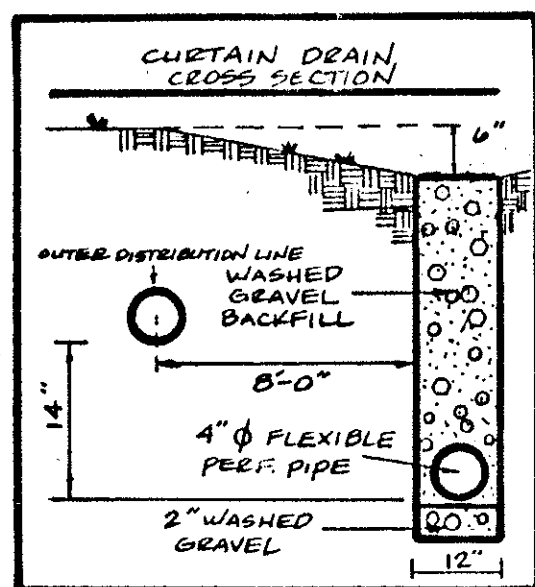

HYDRAULIC PROFILE
HORIZ: 1" = 30' VERT: 1" = 2.5'

S/L 22
(VACANT)

S/L 20
(VACANT)

Proposed
septic
Area

Proposed
septic
Area

SEWAGE DISPOSAL PERMIT MUST BE
OBTAINED BY A LAKE COUNTY LICENSED
INSTALLER BEFORE INSTALLATION IS
STARTED.

LOW YIELD WATER
FIXTURES REQUIRED
ON ALL:

- Shower Head
- Toilet

SITE PLAN

LEROY TOWNSHIP, LAKE COUNTY, OHIO

for: PETER BRUGMANN 354-4049

CLIENT OWNER
10114 CANDLESTICK LAKE PAINESVILLE
ADDRESS STREET CITY ZIP

EAGLE BROOK SUB. No. 2
SUBDIVISION 26.13 NAME
21 VOL. 100 PG. 100
SUBLOT NO. JENNINGS DR STREET

LOT TRACT
VOLUME PAGE
PERM. PARCEL NO. STREET

LEGEND

SANITARY MANHOLE	-----○	WATER VALVE (GAS)	-----#
STORM MANHOLE	-----●	WATER METER (GAS)	-----#
INLET OR CATCH BASIN	-----■	AS BUILT ELEVATION	100.0
HYDRANT	-----◇	INDICATES	DIRECTION OF
EXISTING CONTOURS	-----	SURFACE DRAINAGE	
PROPOSED CONTOURS	-----		
EXIST. ELEV.	100.0	PROP. ELEV.	100.0

REMARKS

ALL BOUNDARY DATA SHOWN WAS OBTAINED FROM (DEEDS, RECORDED
SUBDIVISION PLAT OR OTHER PUBLIC RECORDS)

LOCATIONS AS SHOWN OF ADJACENT WELLS AND SEPTIC TANKS OBTAINED FROM
LAKE COUNTY HEALTH DEPARTMENT

DESIGN CERTIFICATION

THIS PLAT WAS PREPARED BY ME, AND IS CORRECT
TO THE BEST OF MY KNOWLEDGE AND BELIEF.

NAME Harry S. Jones, Jr. SURVEYOR REGISTRATION NO. 6343

CHECK LIST

NO. OF BEDROOMS	WATER MAIN SIZE, LOCATION
DIMENSIONS	SAN. SEWER SIZE % GR. LOC.
BEARINGS	SAN. MH. CAST. ELEV. INV. ELEV.
TIE TO NEAREST STREET	SAN. CONN. SIZE, LOC. DEPTH
SUBLOT NO. PARCEL NO.	STORM SEWER SIZE % GR. LOC.
SURROUNDING OWNERS	STORM MH. CAST. ELEV. INV. ELEV.
BLDG. DIMENSIONS FIN. GR.	PAVT TYPE GRADE CURBS
BLDG. TIES FL'R. GRADES	GAS LINE LOC. SIZE PRESSURE
APRON TYPE WIDTH THICKNESS	SEPTIC TANK LOCATION & DUPLICATION AREA
SIDEWALK TYPE WIDTH THICKNESS	WELL LOCATION
CULVERT TYPE DIA. LENGTH	ISOLATION RADIUS FROM WELL
ROCK OUTCROPPINGS	

PLAN PREPARED BY:

BABCOCK • JONES & ASSOCIATES, INC.
PAINESVILLE, OHIO

NO.	DATE	BY
1	4/3/96	HT
2	4/4/96	HT
3	8/19/96	HT
4	8/30/96	HT
5	9/6/96	HT

DRAWN BY	SCALE 1" = 30'	PHONE NO.
CHK'D.	DATE 3/30/96	357-1811
CREW CHIEF	APP'D. HT	DRAWING NO.
		95-027-21

"AS BUILT" CERTIFICATION

I, HEREBY CERTIFY THAT THE CIRCLED GRADES ARE EXISTING
FINISH GRADES CHECKED IN THE FIELD ON _____, 19____
AND ARE CORRECT TO THE BEST OF MY KNOWLEDGE AND BELIEF.

REGISTERED SURVEYOR

REG. NO.

- To be brought to finished grade
1. Septic tank manhole covers
2. Splitter box cover
3. Distribution box cover
- No footer drains or downspouts
to be discharged into septic tanks
- All waste water to be discharged into
septic tanks

Reviewed and Accepted
LAKE COUNTY GENERAL HEALTH DISTRICT
Date 9-6-96
Limited room for signature
JOEL LUCIA, R. S., M. P. H.
Health Commissioner
BY J. Lindsay

"I, the undersigned hereby certify that
the topography indicated by 6", 1" or 2"
contours, and elevations shown hereon
are an actual field survey made by
me on the 25th day of March, 1996
that the elevations were taken at
adequate intervals and that as of that
date they existed as indicated hereon."

9-11-96
15" MIN.
CULVERT

JENNINGS
ROAD-60'

R. R. R.