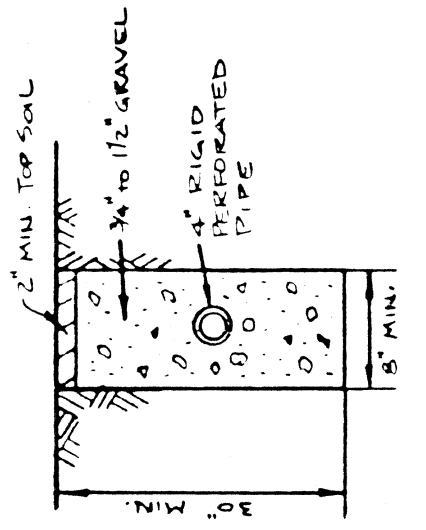
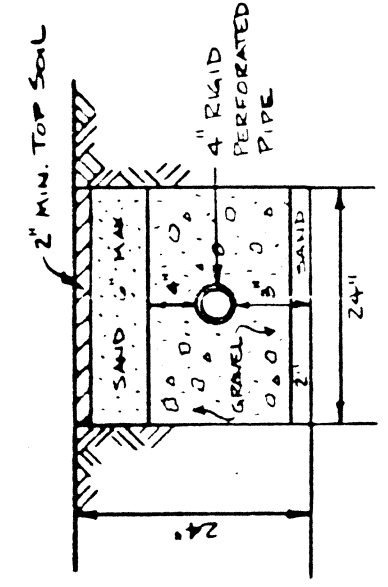


STAGS, INC.


N

EVAPOTRANSPIRATION TRENCH DETAIL
NO SCALE

[illegible]

CURTAIN DRAIN TRENCH DETAIL
No SCALE

No scale

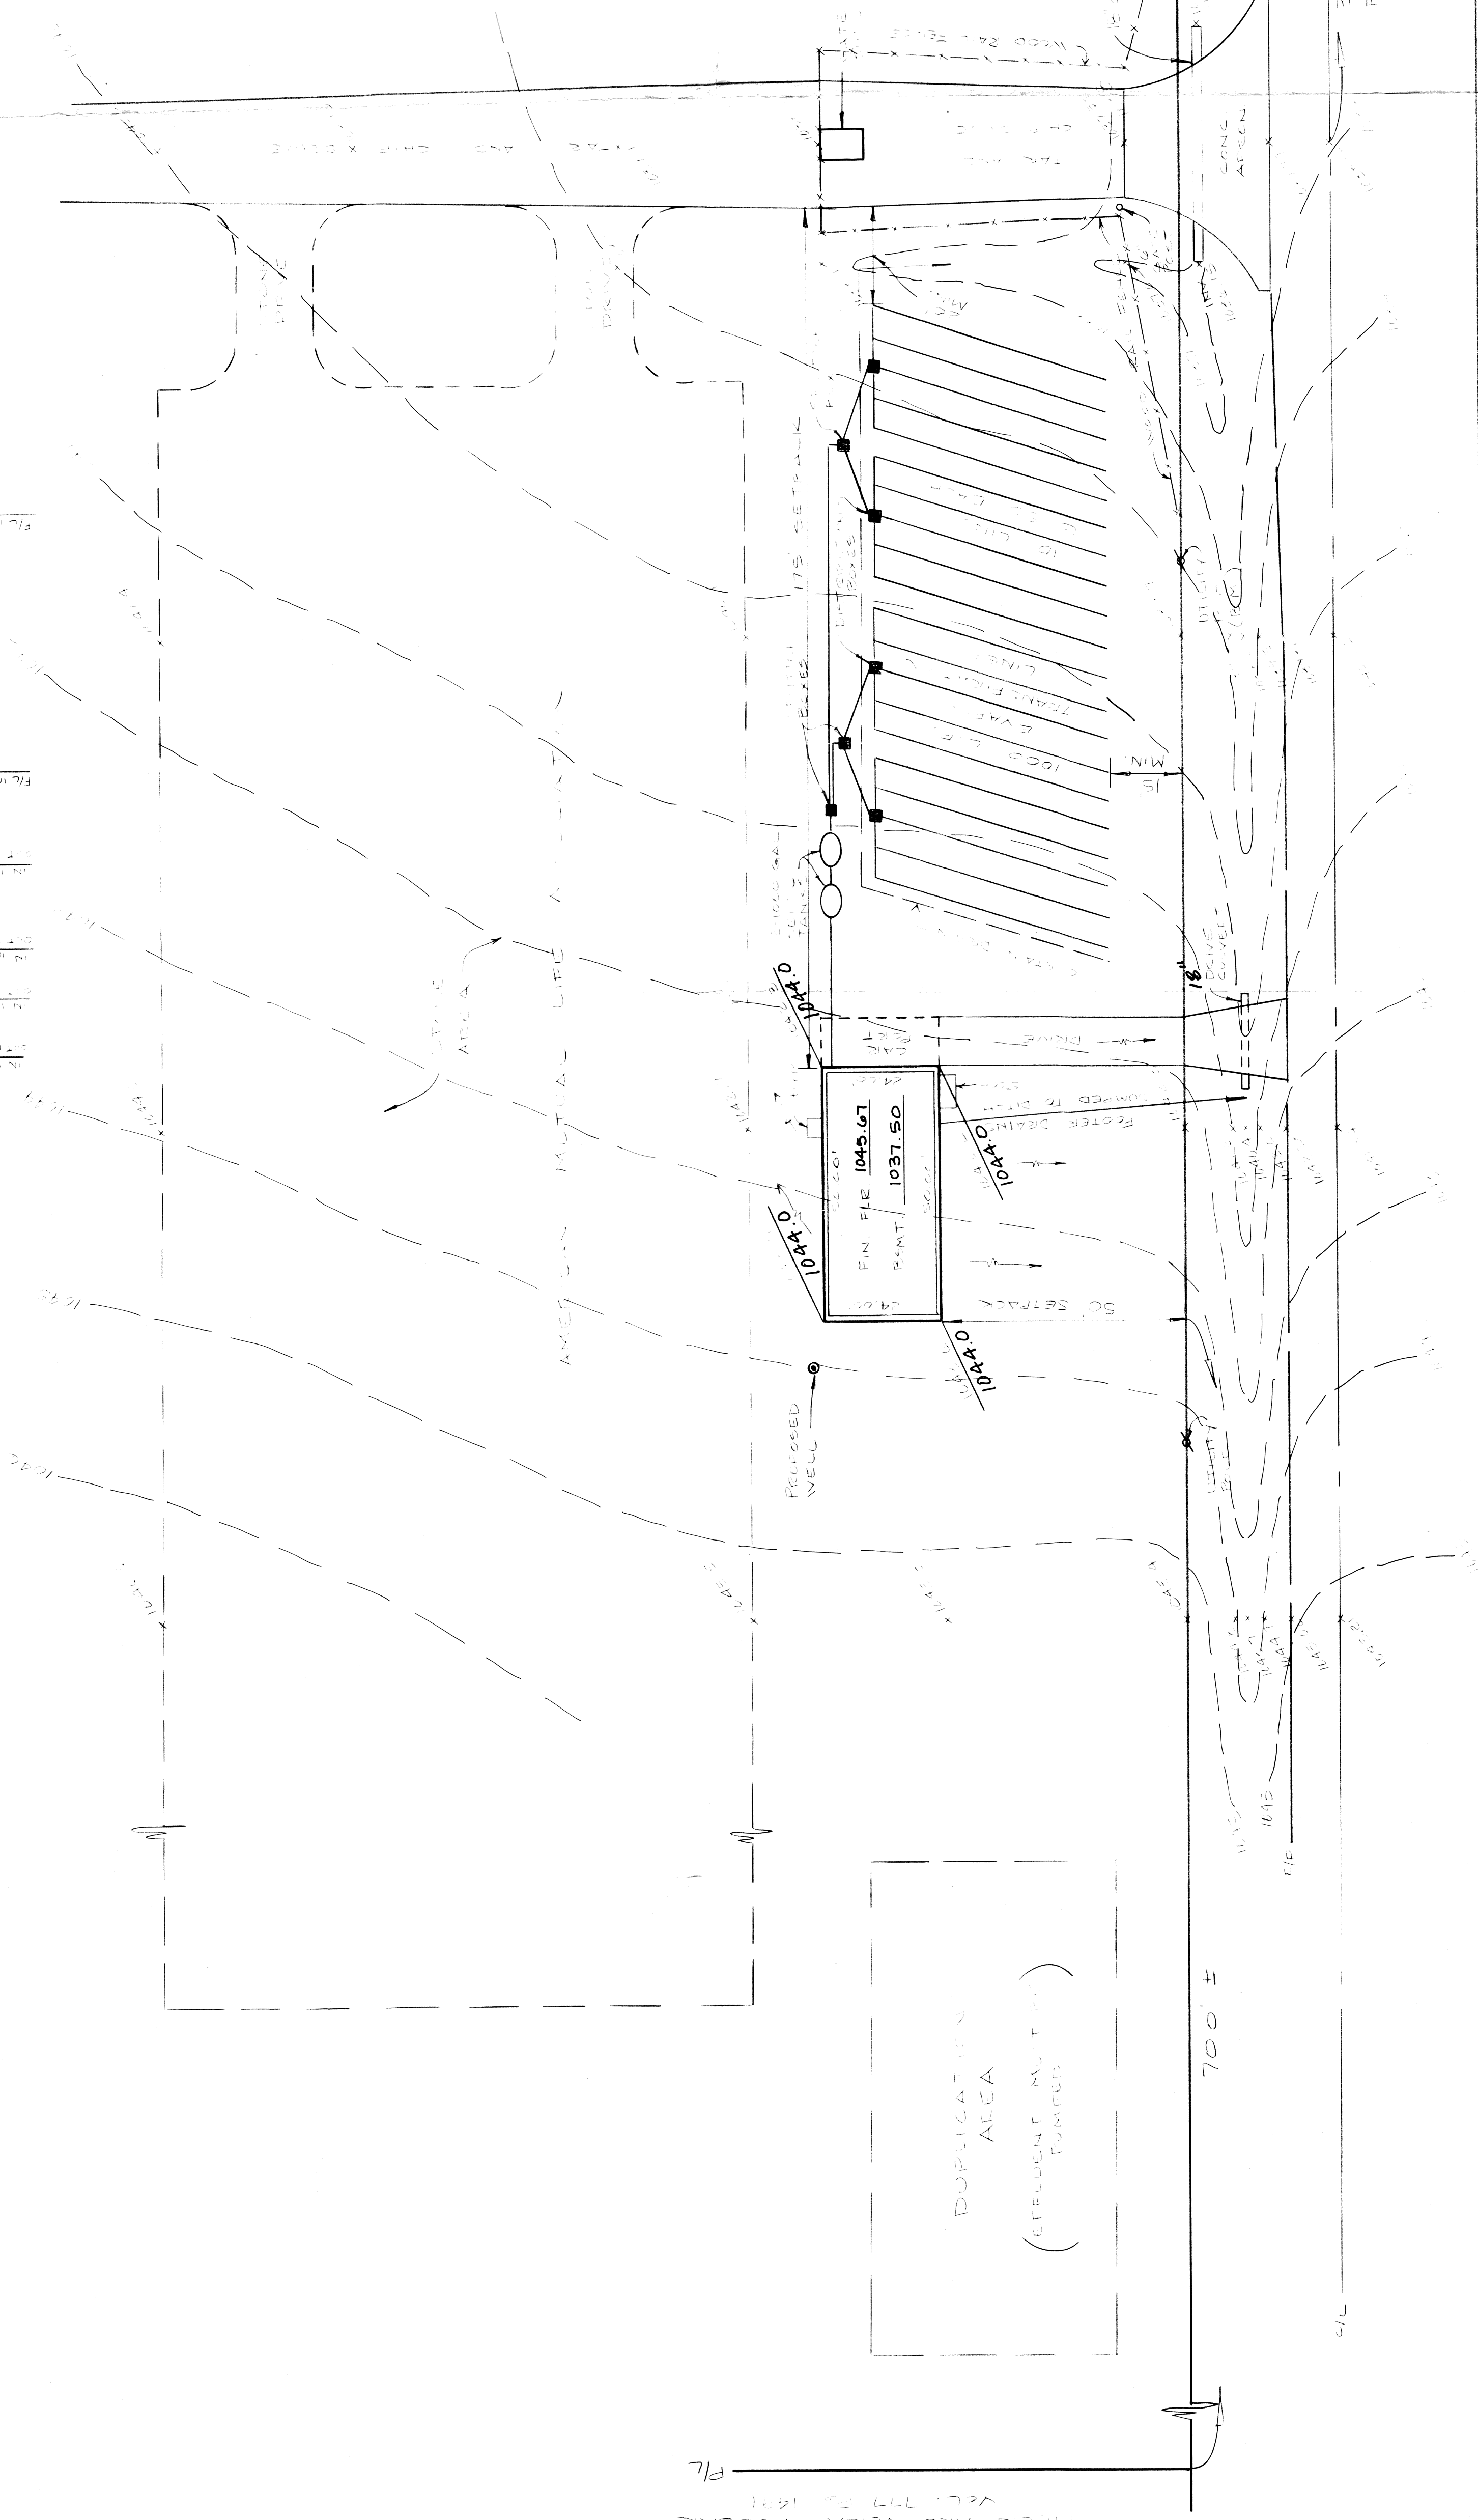

PRC 40

P.R. IN 1974

Grading Plan Approved
as shown and/or noted
THOMAS P. GILLES, P.E.
Lake County Engineer

By Date 12-11

PLAN SITE

FOR CONDO 2 CONSTRUCTION

1	2	3	100
---	---	---	---	---	---	---	---	---	----	----	-----

DATE 6-23-86
DRAWN BY: RLS
CHECKED BY: _____
APPROVED BY: _____
552 PG 600
FB No. _____

CERTIFICATION

THIS PLAT WAS PREPARED BY ME
AND IS CORRECT TO THE BEST OF
MY KNOWLEDGE AND BELIEF

Frederick P. Hines

REG. SURVEYOR NC

[illegible]

COLPETZER-THOMAS, INC.
AN ENGINEERING GROUP

WILLOUGHBY • MENTOR • NORTH CANTON • STEUBENVILLE • LORAIN

SCALES	
HOR. 1" = 20'	
VERT. AS SHOWN	
CONTRACT NO.	
86-478	
SHEET NO.	OF
1	1

7431-71