

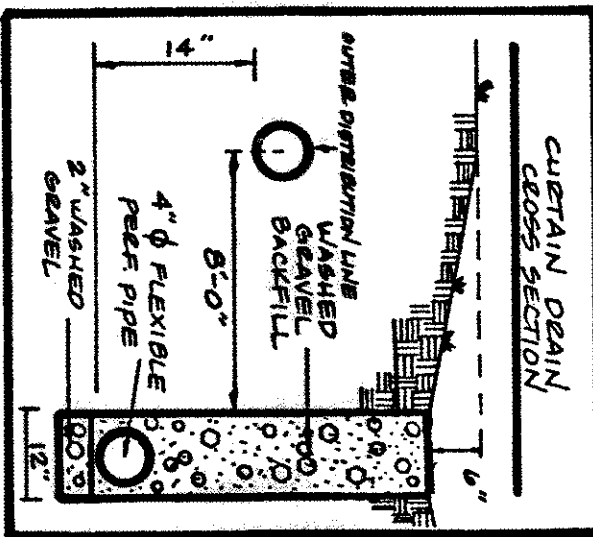
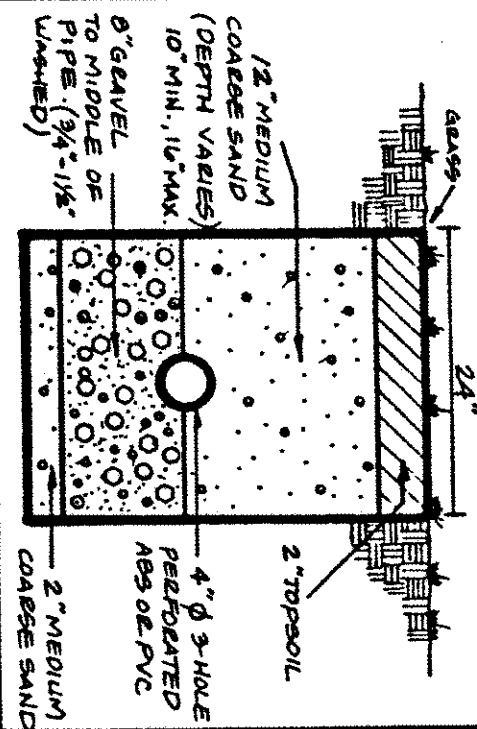


EVAPORATION - TRANSPIRATION
TRENCH CROSS SECTION

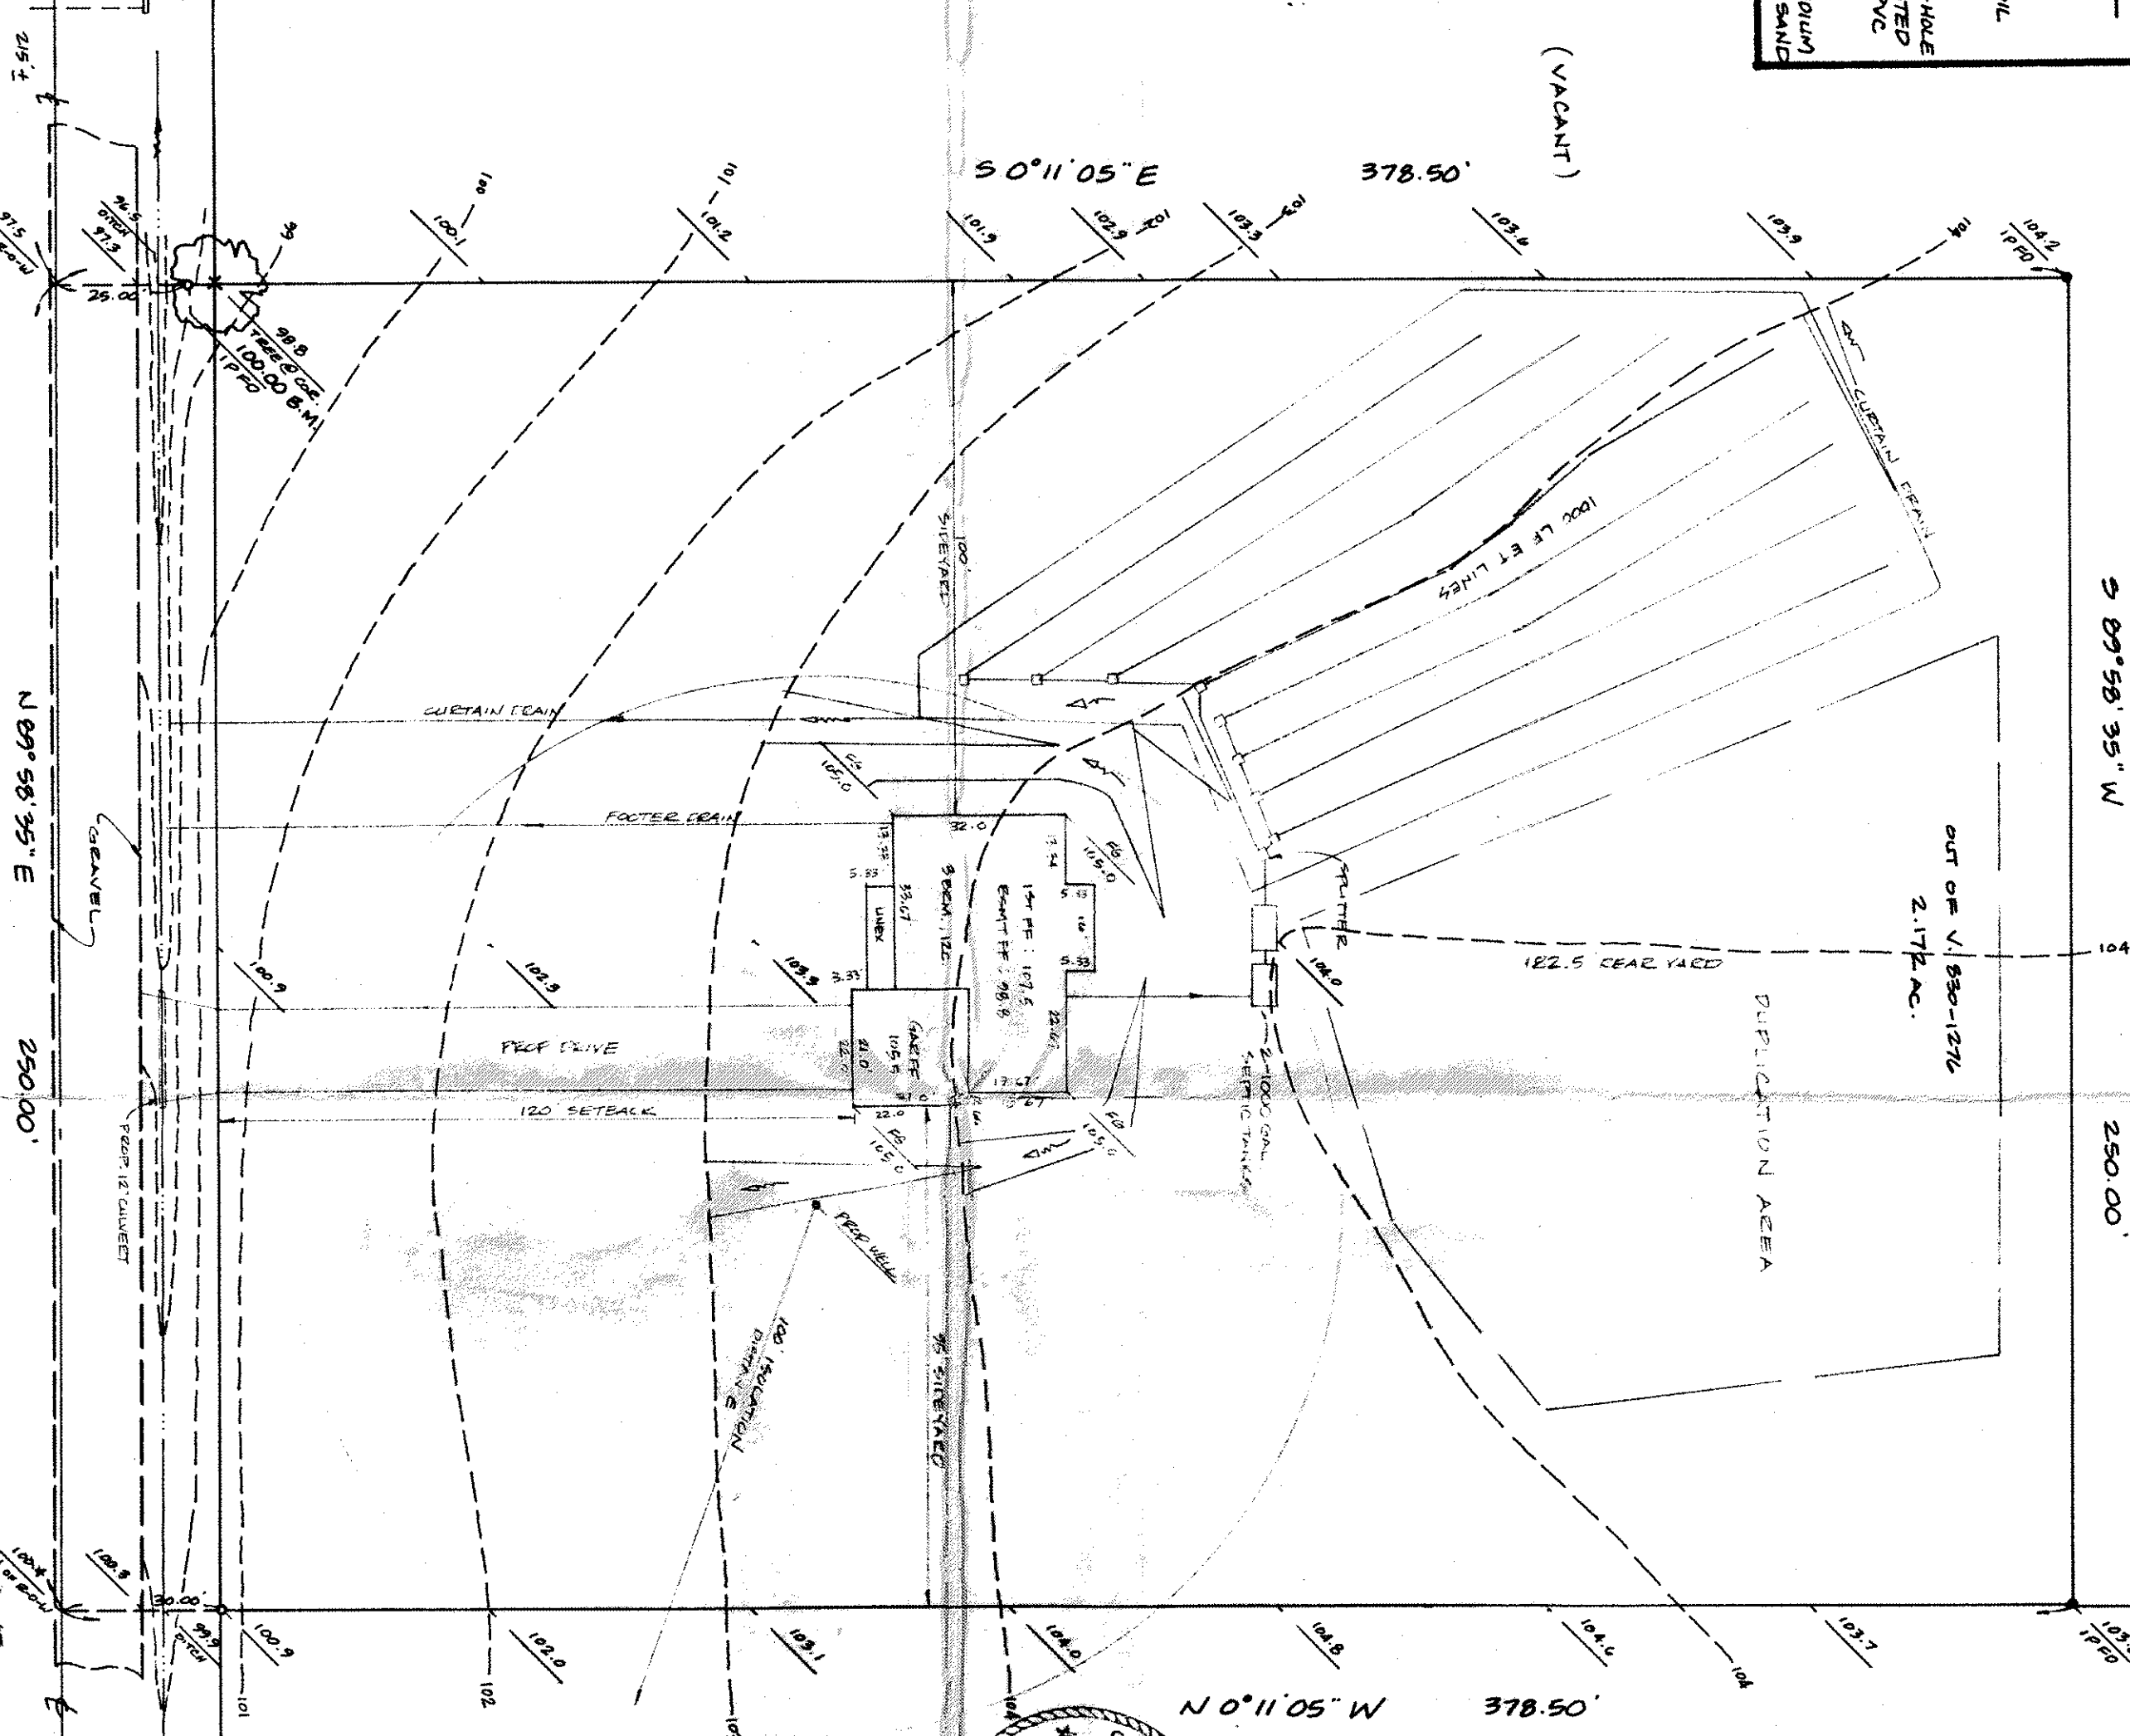

HYDRAULIC PROFILE
HORZ. 1"=30', VERT. 1"=5'

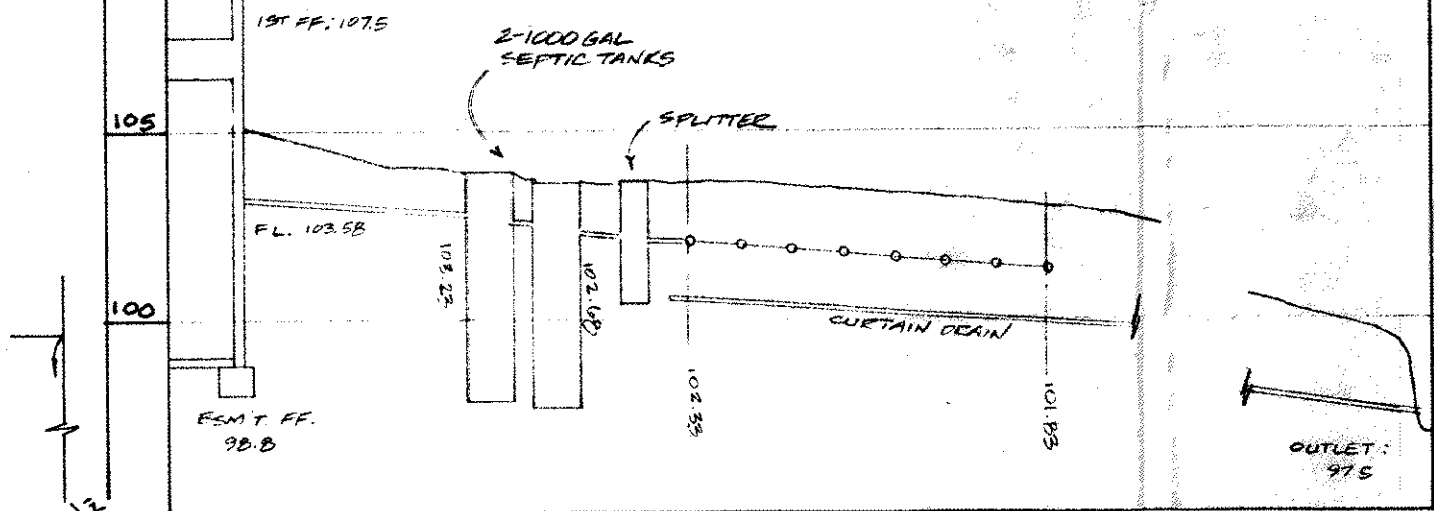

DENNIS HEDDER
V. 630-1276
(VACANT)

S 89°58'35\"/>

250.00'

SITE PLAN

LEROT TOWNSHIP, LAKE COUNTY, OHIO

for: NAUGHTON BUILDERS, INC.

9254 CHEERYSTONE, WESTER, OH 44090

SUBDIVISION	NAME	LOT	TRACT
VOL. - PG.		SUR OF 632	1276
SUBLOT NO.	STREET	VOLUME	PAGE
		PERM. PARCEL NO.	1280 / CENTER STREET

LEGEND

SANITARY MANHOLE	---	WATER VALVE (GAS)	---
STORM MANHOLE	---	WATER METER (GAS)	---
INLET OR CATCH BASIN	---	AS BUILT ELEVATION	---
HYDRANT	---	INDICATES DIRECTION OF SURFACE DRAINAGE	---
EXISTING CONTOURS	---		
PROPOSED CONTOURS	---		
EXIST. ELEV.	100.0	PROP. ELEV.	100.0

REMARKS

ALL BOUNDARY DATA SHOWN WAS OBTAINED FROM (DEEDS, RECORDED SUBDIVISION PLAT OR OTHER PUBLIC RECORDS)
LOCATIONS AS SHOWN OF ADJACENT WELLS AND SEPTIC TANKS OBTAINED FROM LAKE COUNTY HEALTH DEPARTMENT

DESIGN CERTIFICATION

THIS PLAT WAS PREPARED BY ME, AND IS CORRECT TO THE BEST OF MY KNOWLEDGE AND BELIEF.

NAME SURVEYOR REGISTRATION NO.

CHECK LIST

NO.	DATE	BY	REVISIONS
1			
2			
3			
4			
5			
6			

PLAN PREPARED BY:

BABCOCK • JONES & ASSOCIATES, INC.

PAINESVILLE, OHIO

DRAWN BY	SCALE	PHONE NO.
CHK'D.	DATE	357-1811
CREW	APP'D.	DRAWING NO.
CHIEF		75-148

"AS BUILT" CERTIFICATION

I, HEREBY CERTIFY THAT THE CIRCLED GRADES ARE EXISTING FINISH GRADES CHECKED IN THE FIELD ON 19____, AND ARE CORRECT TO THE BEST OF MY KNOWLEDGE AND BELIEF.

REGISTERED SURVEYOR

REG. NO.

Reviewed and Accepted

LAKE COUNTY GENERAL HEALTH DISTRICT

Date 6-20-95

JOEL LUCIA, R. S. M. P. H.

Health Commissioner

BY J. Lucia

- LOW YIELD WATER FIXTURES REQUIRED ON ALL:
1. Septic tank manhole covers
 2. Splitter box cover
 3. Distribution box cover

- A. To be brought to finished grade
- B. No footer drains or downspouts to be discharged into septic tanks
- C. All waste water to be discharged into septic tanks

Name Reg. No.

SEWAGE DISPOSAL PERMIT MUST BE OBTAINED BY A LAKE COUNTY LICENSED INSTALLER BEFORE INSTALLATION IS STARTED.

THOMAS R. GILLES, P.E.
Lake County Engineer

62695

LEROT CENTER ROAD

160'