
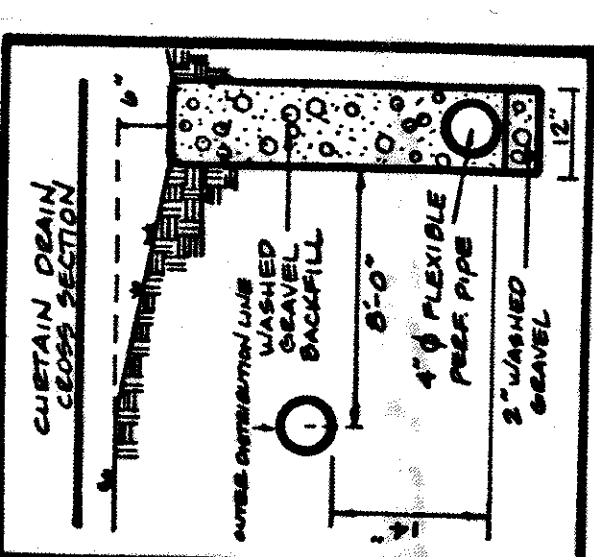
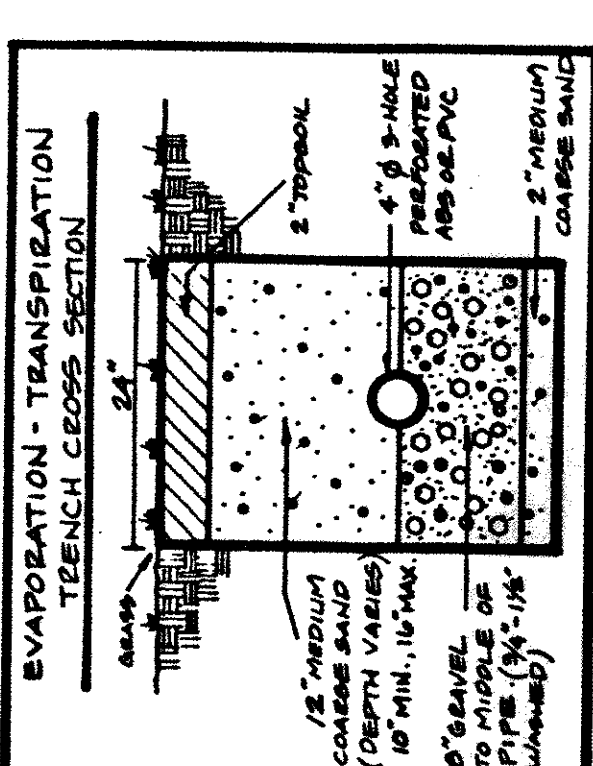


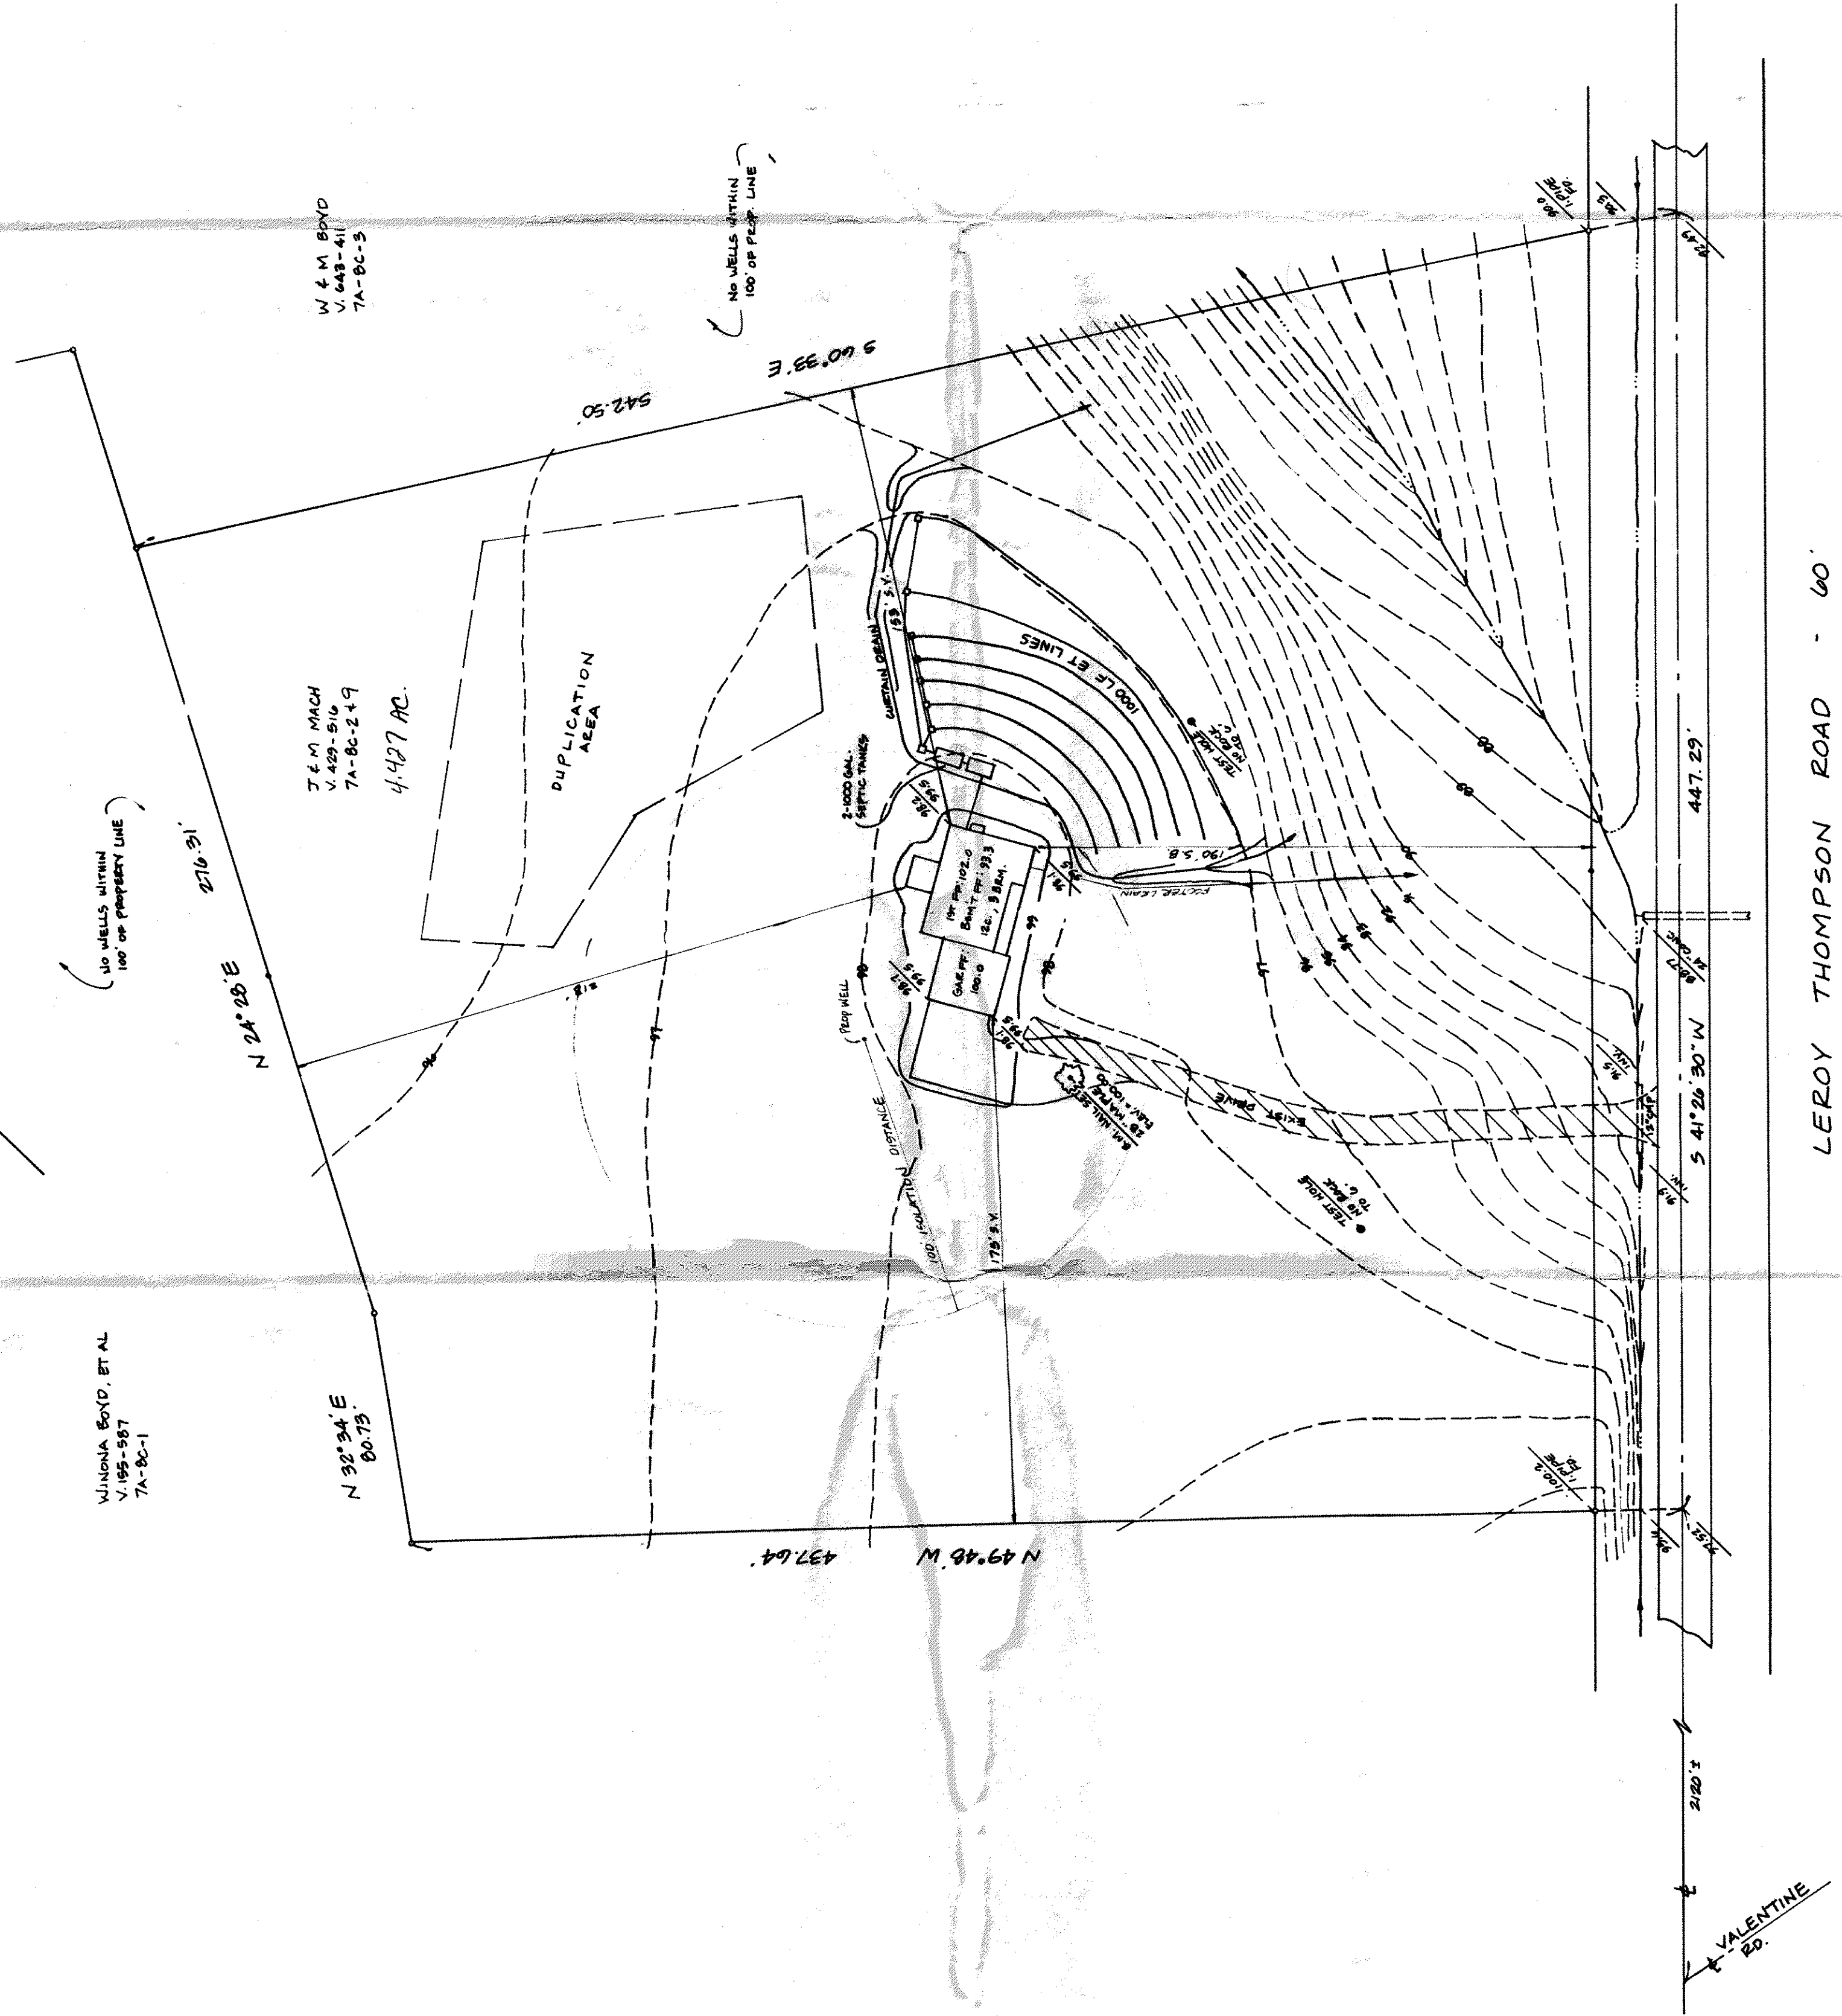

SEWAGE DISPOSAL PERMIT MUST BE OBTAINED BY A LAKE COUNTY LICENSED INSTALLER BEFORE INSTALLATION IS STARTED.

A. To be brought to finished grade
1. Septic tank manhole covers
2. Splitter box cover
3. Distribution box cover

B. No footer drains or downspouts
to be discharged into septic tanks

C. All waste water to be discharged into
septic tanks




"I, the undersigned hereby certify that the topography indicated by 6", 1" or 2" contours, and elevations shown herein represent an actual field survey made by me on the 20 day of April, 1945 and that the elevations were taken at appropriate intervals and that as of that date they existed as indicated herein."

William Chabak P.S. 1551

Page No. _____

**LOW YIELD WATER
FIXTURES REQUIRED
ON ALL:
Lower Head
Toilet**

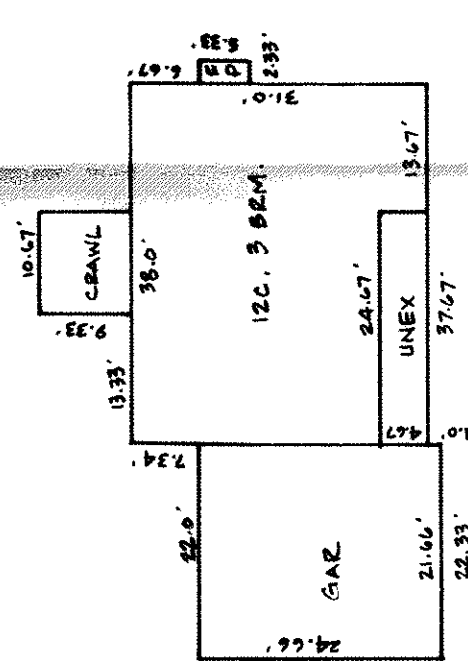

FOUNDATION DIMENSIONS

Reviewed and Accepted _____
LAKE COUNTY GENERAL HEALTH DISTRICT

 Date 5-4-95

JOEL LUCIA, R. S., M. P. H.
 Health Commissioner

 BY J. Lucia

HYDRAULIC PROFILE

REV. NO.	DESCRIPTION	DATE	BY	CHK'D
1	LEWISDA PROPERTY LINES	4-22-95	HT	HT

SITE PLAN
FOR
NAUGHTON BUILDERS



BABCOCK, JONES AND ASSOCIATES, INC
CIVIL ENGINEERS - SURVEYORS - LAND PLANNERS
PAINESVILLE OHIO 44077

DATE 4/21/95
DESIGN BY
DRAWN BY *JB*
APPROVED BY

P.P. # 7A-8C-2 & 9
 , VOL. 429-516
 LAKE COUNTY OHIO
 LEROY TOWNSHIP

SCALE	1" = 40'
JOB NO	935-074
SHEET	OF
	1 1

REV. NO.	DESCRIPTION	DATE	BY	CHK'D
1	LEWISDA PROPERTY LINES	4-22-95	HT	HT

SITE PLAN
FOR
NAUGHTON BUILDERS



BABCOCK, JONES AND ASSOCIATES, INC
CIVIL ENGINEERS - SURVEYORS - LAND PLANNERS
PAINESVILLE OHIO 44077

DATE 4/21/95
DESIGN BY
DRAWN BY *JB*
APPROVED BY