


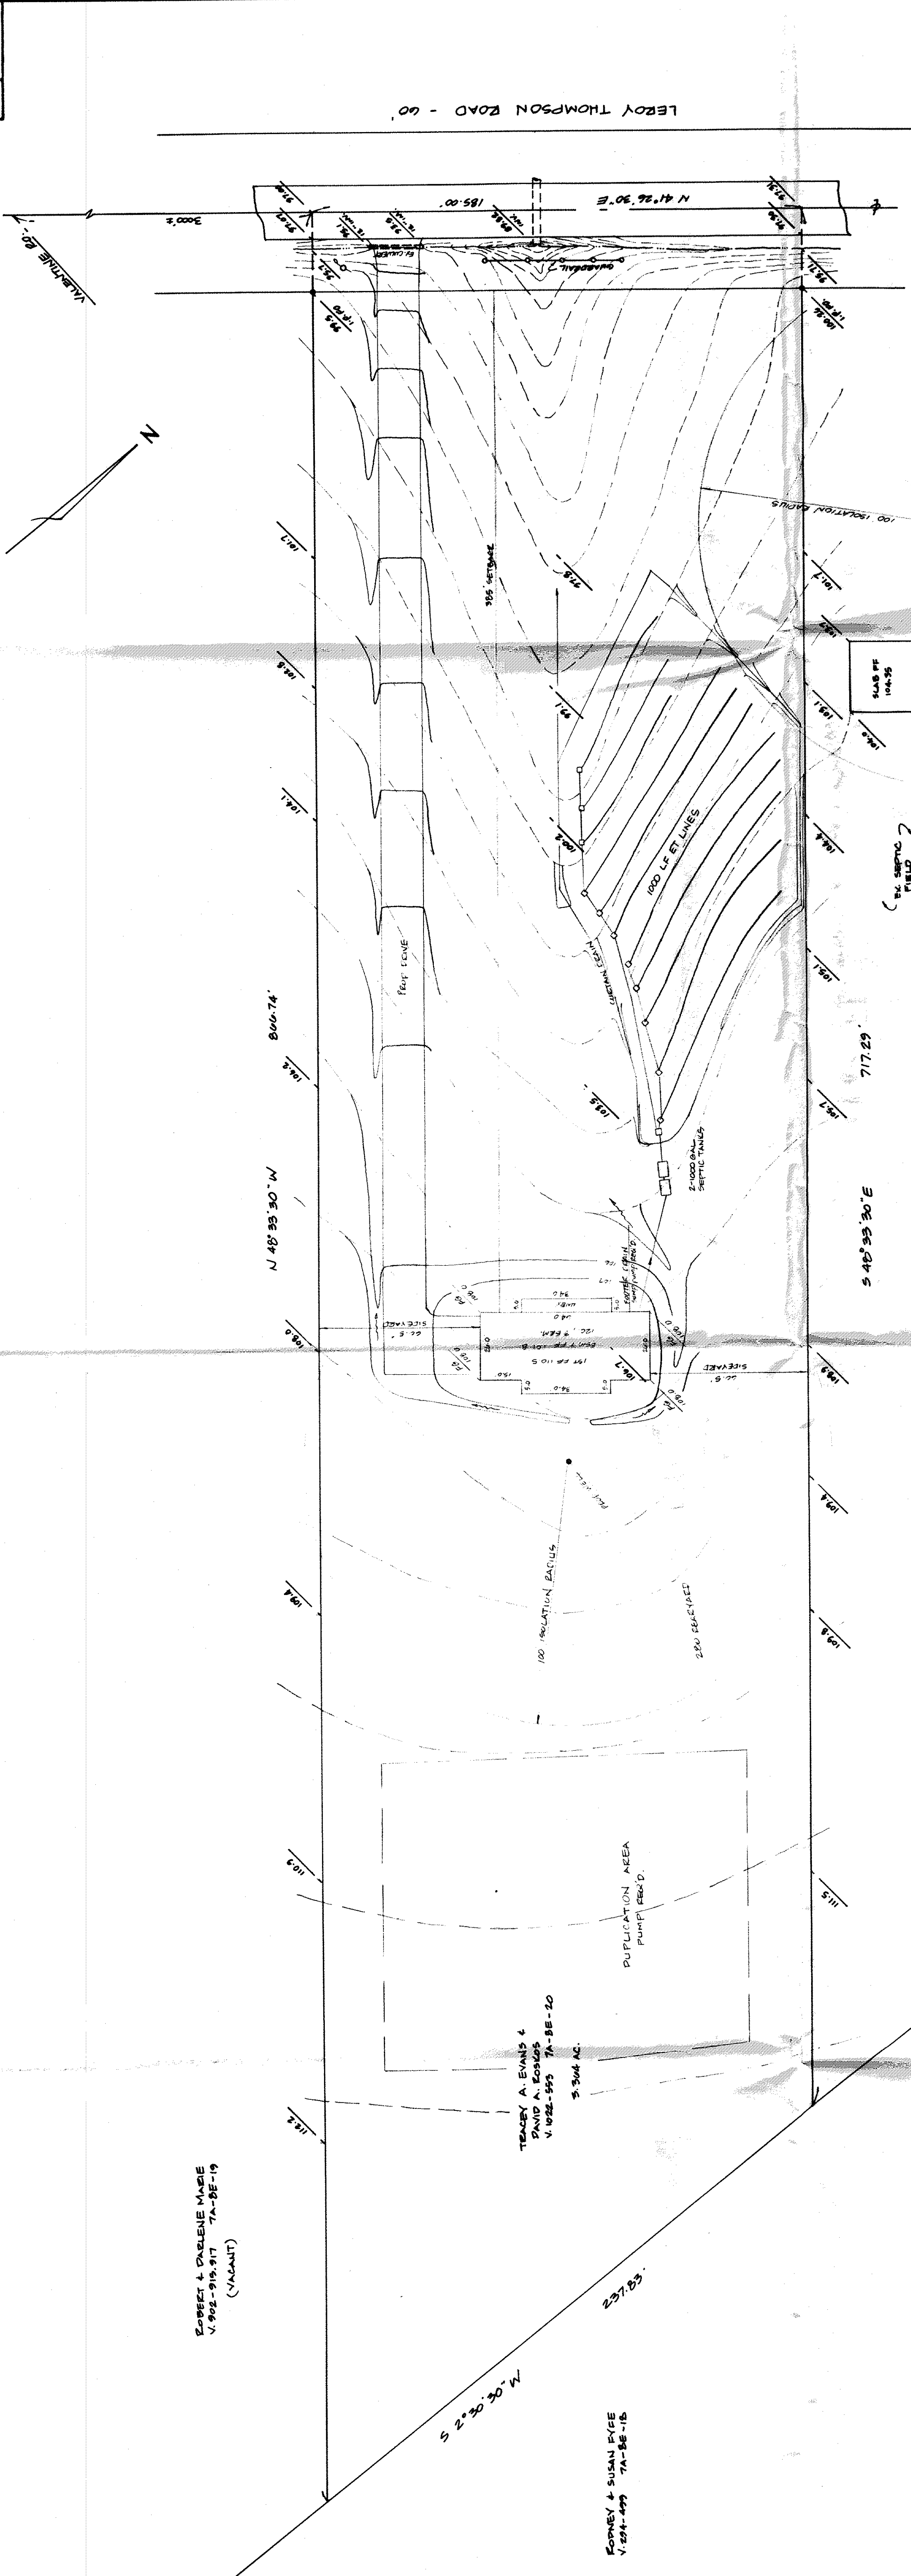

Grading Plan Approved
as shown and/or noted
THOMAS P. GILLES, P.E.
Lake County Engineer


By 6514 Date 5/26/15

**LOW YIELD WATER
FIXTURES REQUIRED
ON ALL:
Shower Head**

**SEWAGE DISPOSAL PERMIT MUST BE
OBTAINED BY A LAKE COUNTY LICENSED
INSTALLER BEFORE INSTALLATION IS
STARTED.**

"I, the undersigned hereby certify that the topography indicated by 6", 1" or 2" contours, and elevations shown hereon represent an actual field survey made by me on the 17th day of May, 1971, and that the elevations were taken at appropriate intervals and that as of that date they existed as indicated hereon."

Name Henry J. Jones Reg. No. 40343

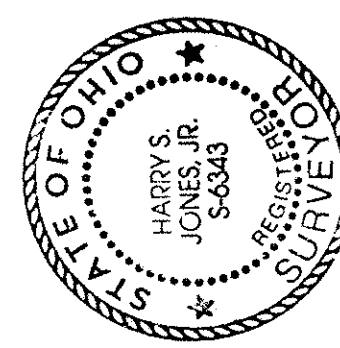

A. To be brought to finished grade
 1. Septic tank manhole covers
 2. Splitter box cover
 3. Distribution box cover

B. No footer drains or downspouts to be discharged into septic tanks

C. All waste water to be discharged septic tanks


Reviewed and Accepted

JAKE COUNTY GENERAL HEALTH DISTRICT

Date 5-25-95

JOEL LUCIA, R. S., M. P. H.
Health Commissioner

BY J. Lucia

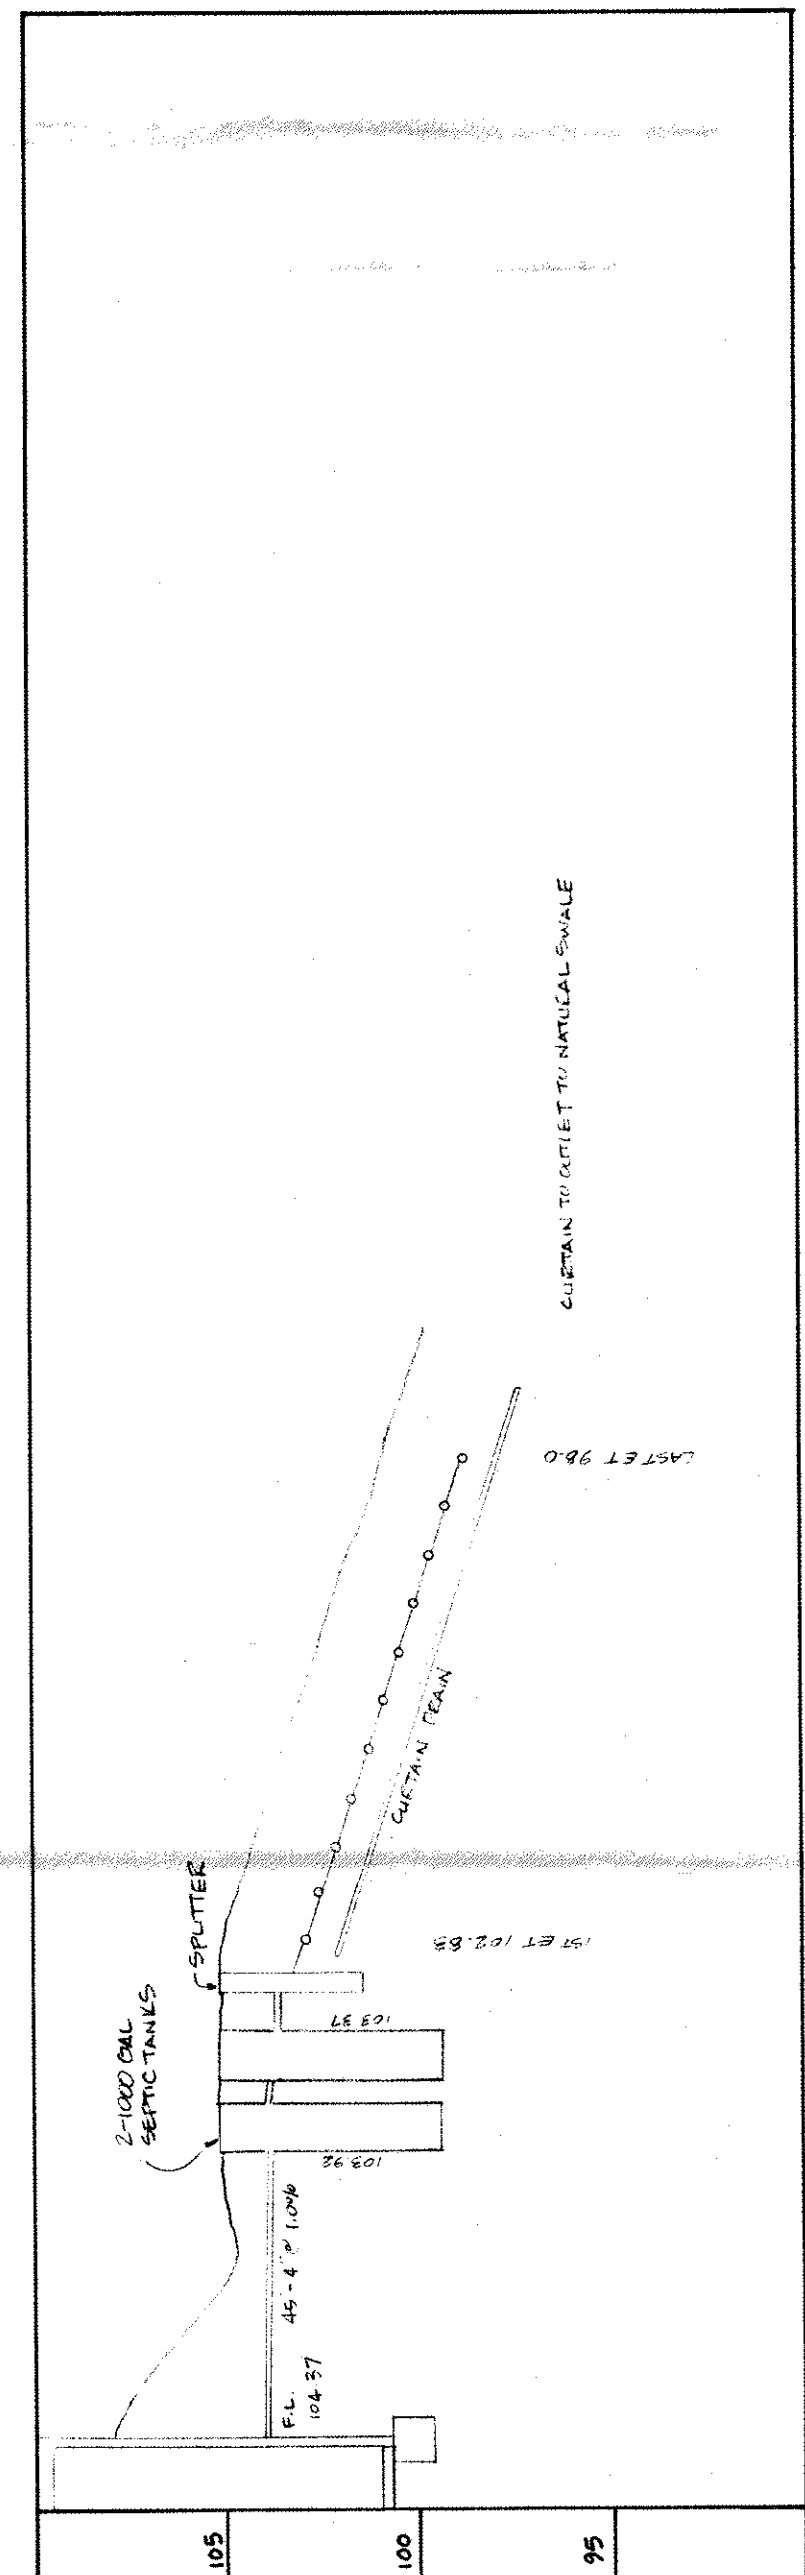

HYDRAULIC PROFILE

1. BABCOCK, JONES AND ASSOCIATES, INC.
CIVIL ENGINEERS - SURVEYORS - LAND PLANNERS
PAINESVILLE OHIO 44077

SITE PLAN
FOR
DAVID ROSKOS

DATE	DESIGN BY	DRAWN BY	APPROVED BY	SCALE
MAY 1995	HA	HA	HA	1"=30'
Bj BABCOCK, JONES AND ASSOCIATES, INC. CIVIL ENGINEERS - SURVEYORS - LAND PLANNERS PAINESVILLE OHIO 44077				JOB NO. 99-110 SHEET 1 OF 1
SITE PLAN FOR DAVID ROSKOS				KNOWN AS BEING PART OF LOT 31, LEROY TWP. P.P. # 7A-8E-20 Vol. 1022 - P. 553 LEROY TOWNSHIP LAKE COUNTY OHIO
REV. NO.	DESCRIPTION	DATE	BY	CHKD