

SITE PLAN

Leroy Twp, Lake COUNTY, OHIO

for: ADDOLARATE SHELLEY
411 SHELLEY ST. LAKESIDE, OHIO
ADDRESS STREET CITY ZIP

Subdivision 2-13 NAME
VOL. 15, P. 114
SUBLOT NO. 11 STREET
LOT VOLUME PERM. PARCEL NO. TRACT PAGE STREET

LEGEND

SANITARY MANHOLE
STORM MANHOLE
INLET OR CATCH BASIN
HYDRANT
EXISTING CONTOURS
PROPOSED CONTOURS
EXIST. ELEV. 100.0
PROP. ELEV. 100.0

WATER VALVE (GAS)
WATER METER (GAS)
AS BUILT ELEVATION
INDICATES DIRECTION OF SURFACE DRAINAGE

REMARKS

ALL BOUNDARY DATA SHOWN WAS OBTAINED FROM IDEOS, RECORDED SUBDIVISION PLAT OR OTHER PUBLIC RECORDS.
LOCATIONS AS SHOWN OF ADJACENT WELLS AND SEPTIC TANKS OBTAINED FROM LAKE COUNTY HEALTH DEPARTMENT

DESIGN CERTIFICATION

THIS PLAN WAS PREPARED BY ME, AND IS CORRECT TO THE BEST OF MY KNOWLEDGE AND BELIEF.

NAME SURVEYOR REGISTRATION NO.

CHECK LIST

NO. OF BEDROOMS
DIMENSIONS
BEARINGS
TIE TO NEAREST STREET
SUBLOT NO. PARCEL NO.
SURROUNDING OWNERS GR.
BLDG. DIMENSIONS IN GR.
BLDG. TIES TO GRADES
ADJACENT PROPERTY
SEPTIC TANK LOCATION & DIMENSIONS
CULVERT TYPE DIA. LENGTH
ROCK OUTCROPPINGS

WATER MAIN SIZE, LOCATION
SAN. SEWER SIZE & GR. LOC.
SAN. MH. CAST. ELEV. INV. ELEV.
SAN. CONN. SIZE, LOC. DEPTH
STORM SEWER SIZE & GR. LOC.
STORM MH. CAST. ELEV. INV. ELEV.
PAV. TYPE GRADE CURBS
GAS LINE LOC. SIZE PRESSURE
SEPTIC TANK LOCATION & DIMENSIONS
WELL LOCATION
ISOLATION RADII FROM WELL

PLAN PREPARED BY:

BABCOCK • JONES & ASSOCIATES, INC.
PAINESVILLE, OHIO

NO.	DATE	BY	REVISIONS
1			
2			
3			
4			
5			


DRAWN BY: DATE: 4/23/84 SCALE: 1" = 30'
CHKD. DATE: 4/23/84 DRAWING NO. 357-1811
CREW: CHIEF: APPROV. DATE: 4/23/84

"AS BUILT" CERTIFICATION

HEREBY CERTIFY THAT THE CIRCLED GRADES ARE EXISTING FINISH GRADES CHECKED IN THE FIELD ON 19
AND ARE CORRECT TO THE BEST OF MY KNOWLEDGE AND BELIEF

REGISTERED SURVEYOR

DEPT. NO.

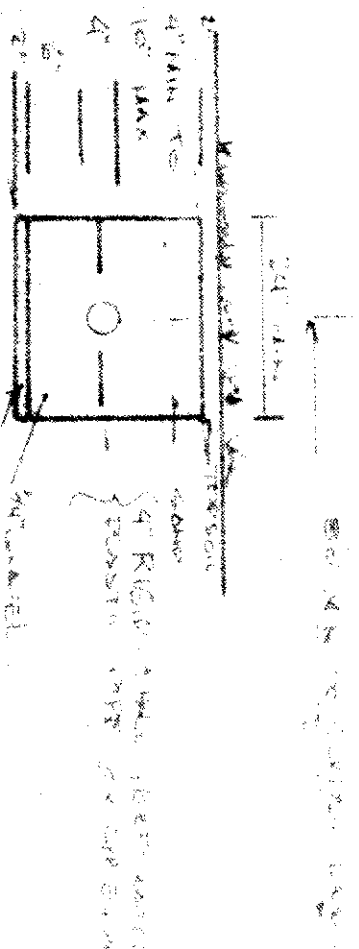

EVAPO-TRANSPIRATION TRENCH

INSPECTION NO. 1
DATE: 4/23/84
BY: [Signature]
COURTNEY DRAWM

Grading Plan Approved as shown and/or noted
THOMAS P. GILLES, P.E.
Lake County Engineer
Date: 2 May 84

SEWAGE DISPOSAL PERMIT MUST BE OBTAINED BY A LAKE COUNTY LICENSED INSTALLER BEFORE INSTALLATION IS STARTED.

Reviewed and Accepted
LAKE COUNTY GENERAL HEALTH DISTRICT
Date: 4/23/84
JOEL LUCIA, R.S., M.P.H.
Health Commissioner

LEROY TOWNSHIP
Zoning Approved
Date: 4-30-84
[Signature]
Zoning Inspector

