
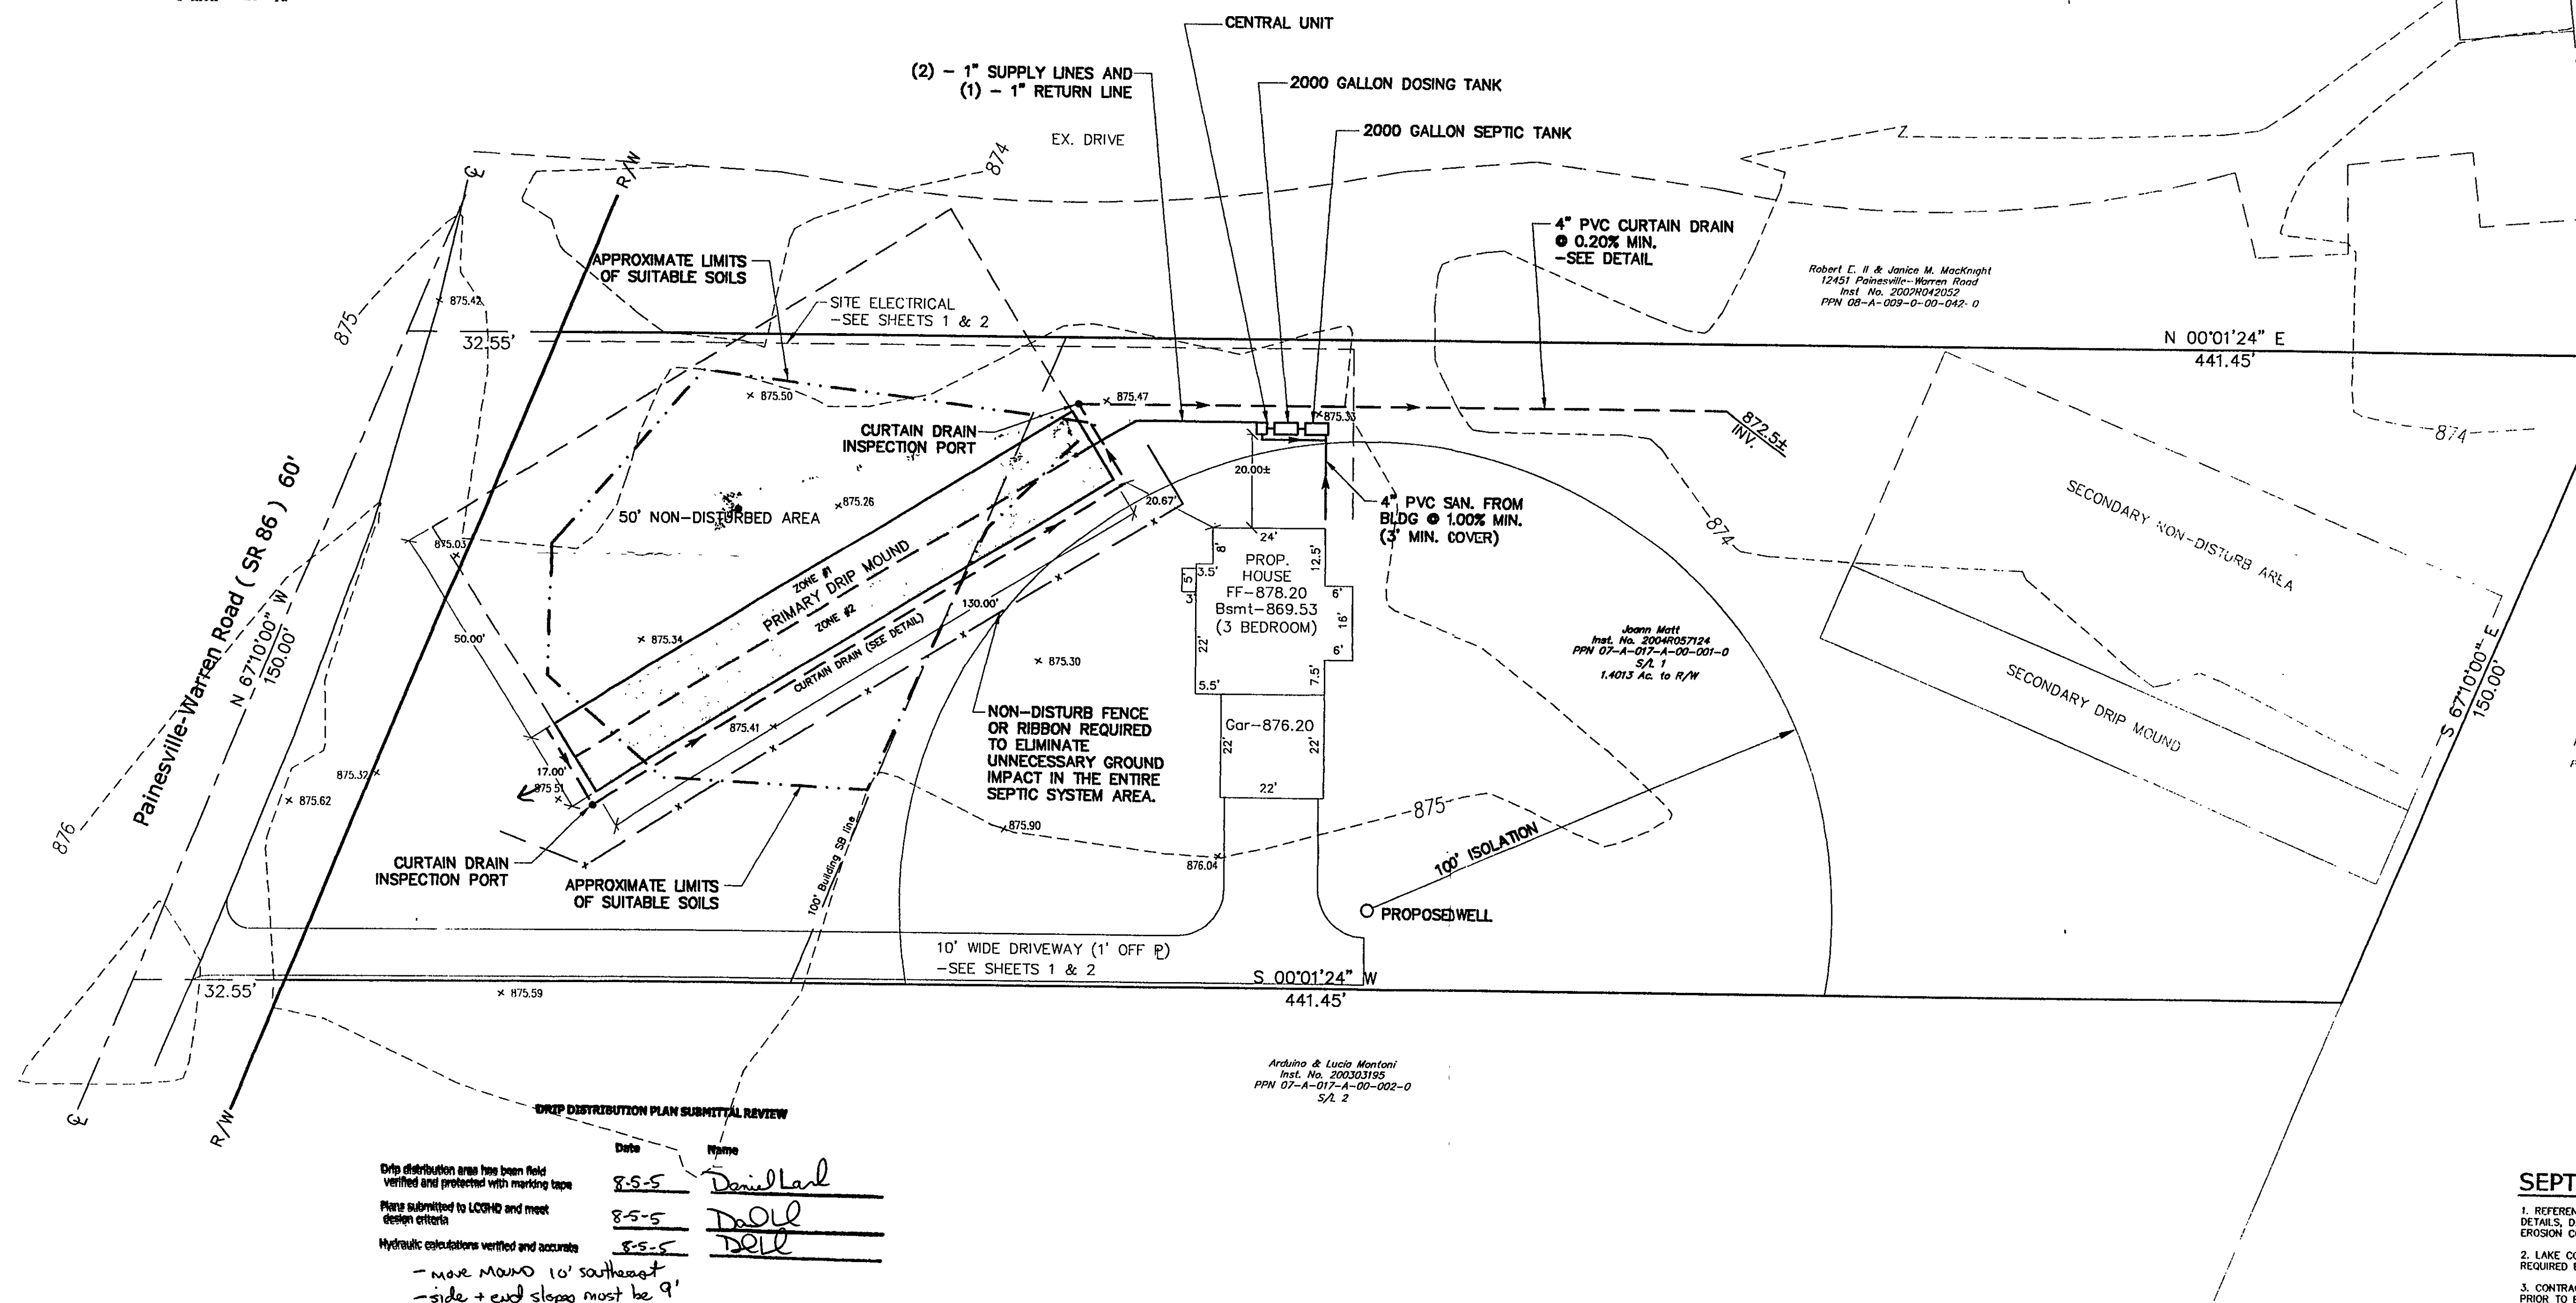


GRAPHIC SCALE

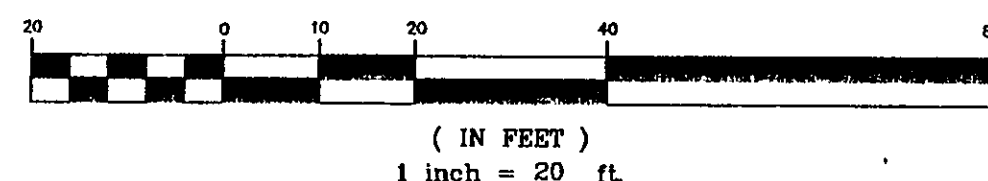


Date	Name
8-5-5	Donnell
8-5-5	Donnell
8-5-5	Donnell

Drp distribution area has been field verified and protected with marking tape
Plans submitted to LCHD and meet design criteria
Hydraulic calculations verified and accurate
- move mound 10' southeast
- side + end slopes must be 9'

- SEPTIC DESIGN NOTES**
- REFERENCE SHEETS 1 & 2 FOR ALL NON-SEPTIC RELATED DIMENSIONS, DETAILS, DATA, ETC. THIS INCLUDES SURVEY, LAYOUT, GRADING & EROSION CONTROL, & OTHER UTILITY DATA.
 - LAKE COUNTY HEALTH DEPARTMENT APPROVAL & INSPECTION ARE REQUIRED BY THE SEPTIC CONTRACTOR PRIOR TO CONSTRUCTION.
 - CONTRACTOR IS TO VERIFY THE GRADES IN THE SEPTIC SYSTEM AREA PRIOR TO BASAL AREA PREPARATION.

SEPTIC DESIGN
CERTIFICATION

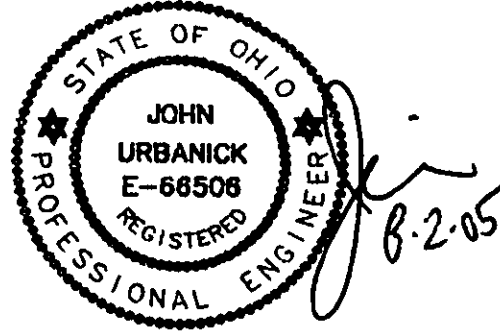

Greenland Consulting, Inc.

7757 Auburn Road Unit #9 Concord, OH 44077
Phone: (440) 352-1794 Fax: (440) 352-1796
E-Mail: green-land@sbcglobal.net



Rev. No.	Description	Date	By	Check
1.	REVISED AS PER LAKE COUNTY HEALTH DEPARTMENT	8/2/05	BKG	JTU

P.P.N. 7A-17A-001
Leroy Twp. ~ Lake County ~ Ohio

Drawn by: JML
Filename: 05-055\siteplan
Checked By:
Approved By:
Date: 8/02/05

Septic System
Plan

Scale:	Sheet No	Of
HORIZ: 1" = 20' VERT: 1" = N/A	3	4