
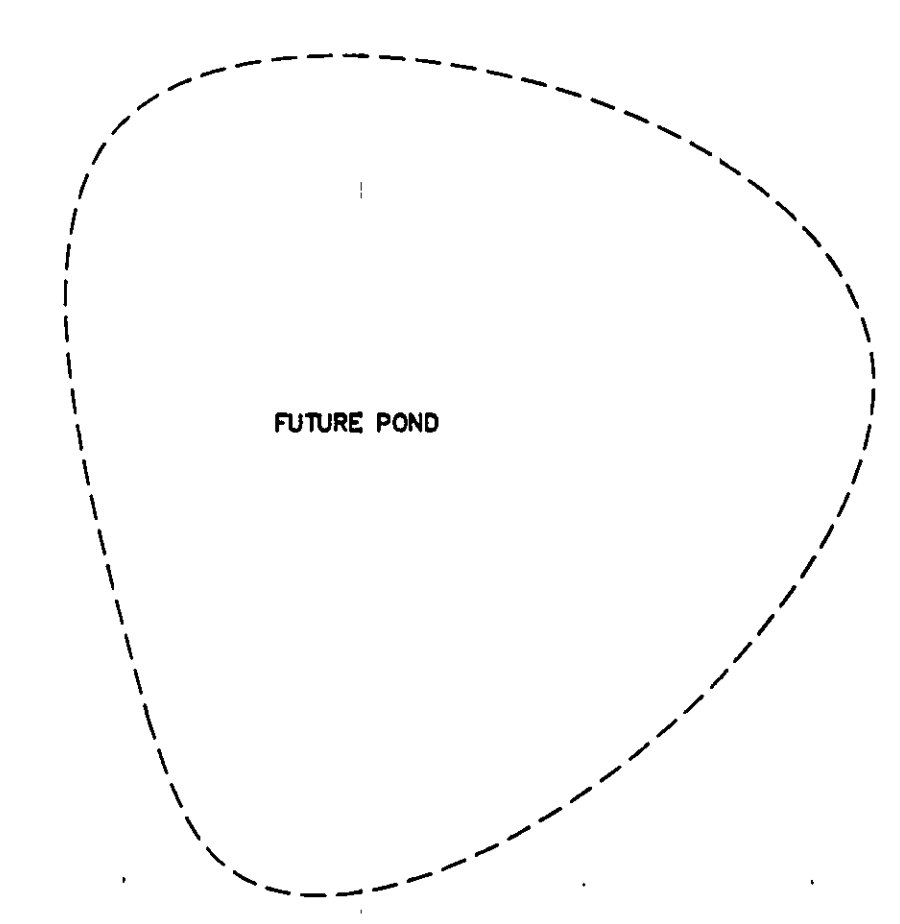
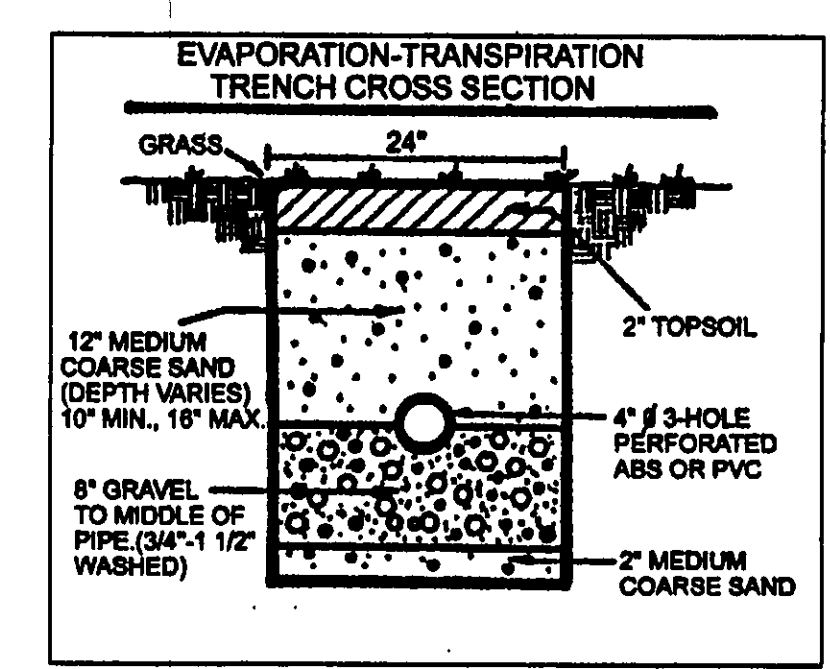


LARRY & DIANA MEER
VOL. 1174- PG 803
7A-1J-3

REVIEWED AND ACCEPTED
LAKE COUNTY GENERAL
HEALTH DISTRICT

5-3-02
Gerald B. Norris

SEWAGE DISPOSAL PERMIT MUST BE
OBTAINED BY A LAKE COUNTY LICENSED
INSTALLER BEFORE INSTALLATION IS
STARTED.

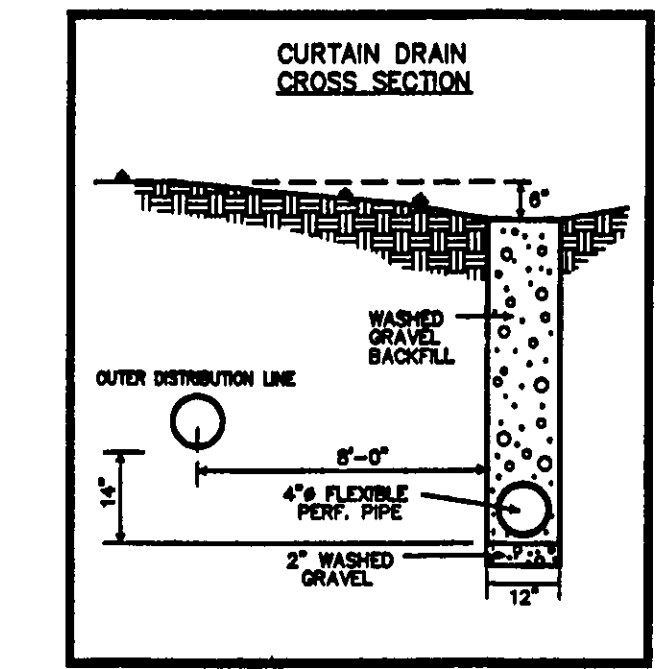

30.00'
PROP. GREENHOUSE
FF.


24.00'
PROP. GREENHOUSE
FF.

24.00'
PROP. GREENHOUSE
FF.

100.00'
PROP. BARN
FF.

7A-1J-1
23.7858 AC.

VITANTONIO, INC.
AN OHIO CORP.
VOL. 351- PG 371

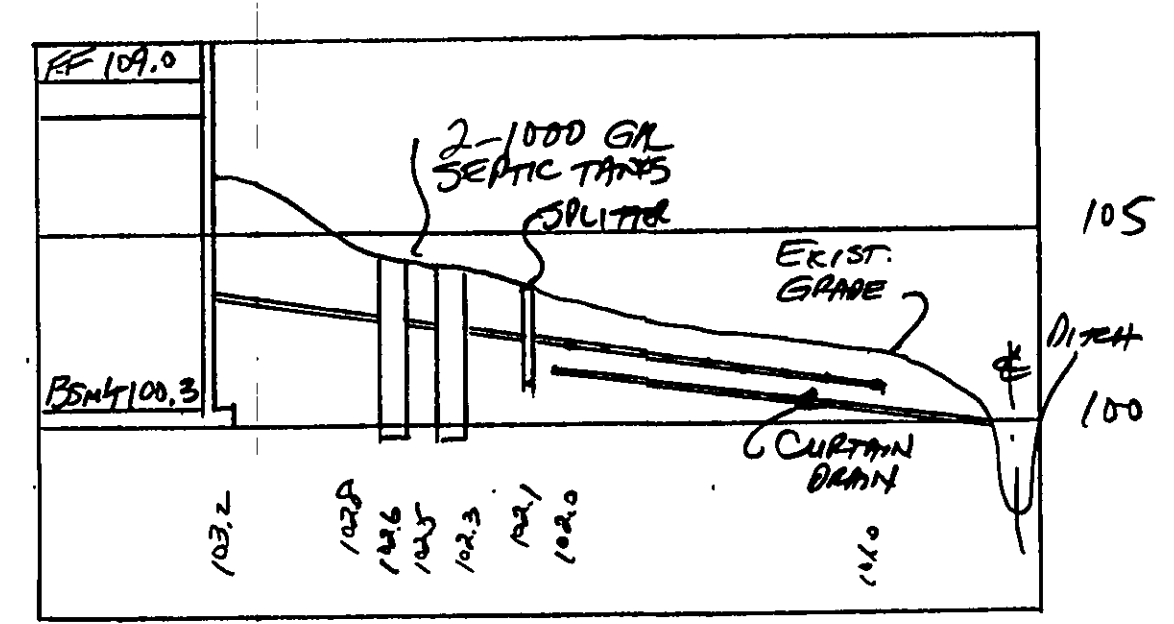

HYDRAULIC PROFILE
HORIZ. 1"=30' VERT. 1"=5'

DIST. BARN



NANCY & KELLY HAWLEY
VOL. 1122- PG 1148

DIST. HOUSE
72.107.50

Grading Plan Approved
as shown and/or noted
JAMES R. GILLS, P.E.
Lake County Engineer

"I, the undersigned hereby certify that
the topography indicated by 8', 1' or 2'
contours, and elevations shown hereon
represent an actual field survey made by
me on the 12 day of April, 2002
and that the elevations were taken at
appropriate intervals and that as of that
date they existed as indicated hereon."

Name: James R. Gills Reg. No. 6343

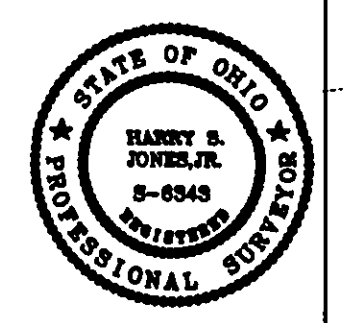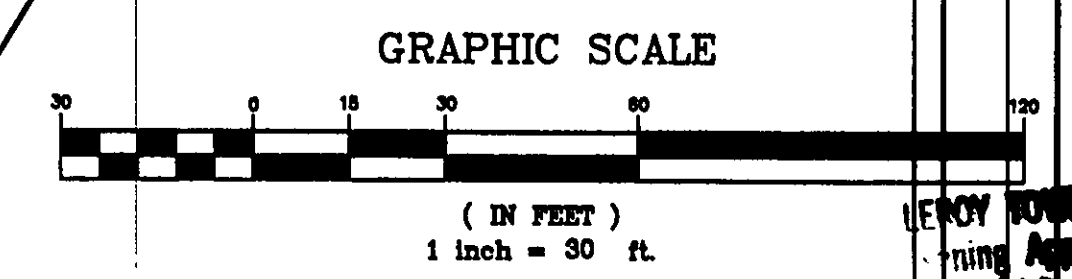

REV. NO.	DESCRIPTION	DATE	BY	CHK'D
1	DRIVE AND BARN REVISION	4/24/02	M.M.	H.J.

bj EABCOCK, JONES AND ASSOCIATES, INC
CIVIL ENGINEERS - SURVEYORS - LAND PLANNERS
PAINESVILLE OHIO 44077

DATE 4/23/02
DESIGN BY H.J.
DRAWN BY M.M.
APPROVED BY H.J.

SITE PLAN
FOR
SUE BLAKELEY
PARCEL B OF 7A-1J-1
LEROY TOWNSHIP
LAKE COUNTY

SCALE 1"=30'
JOB NO. 01-165-B
SHEET 1 OF 1