


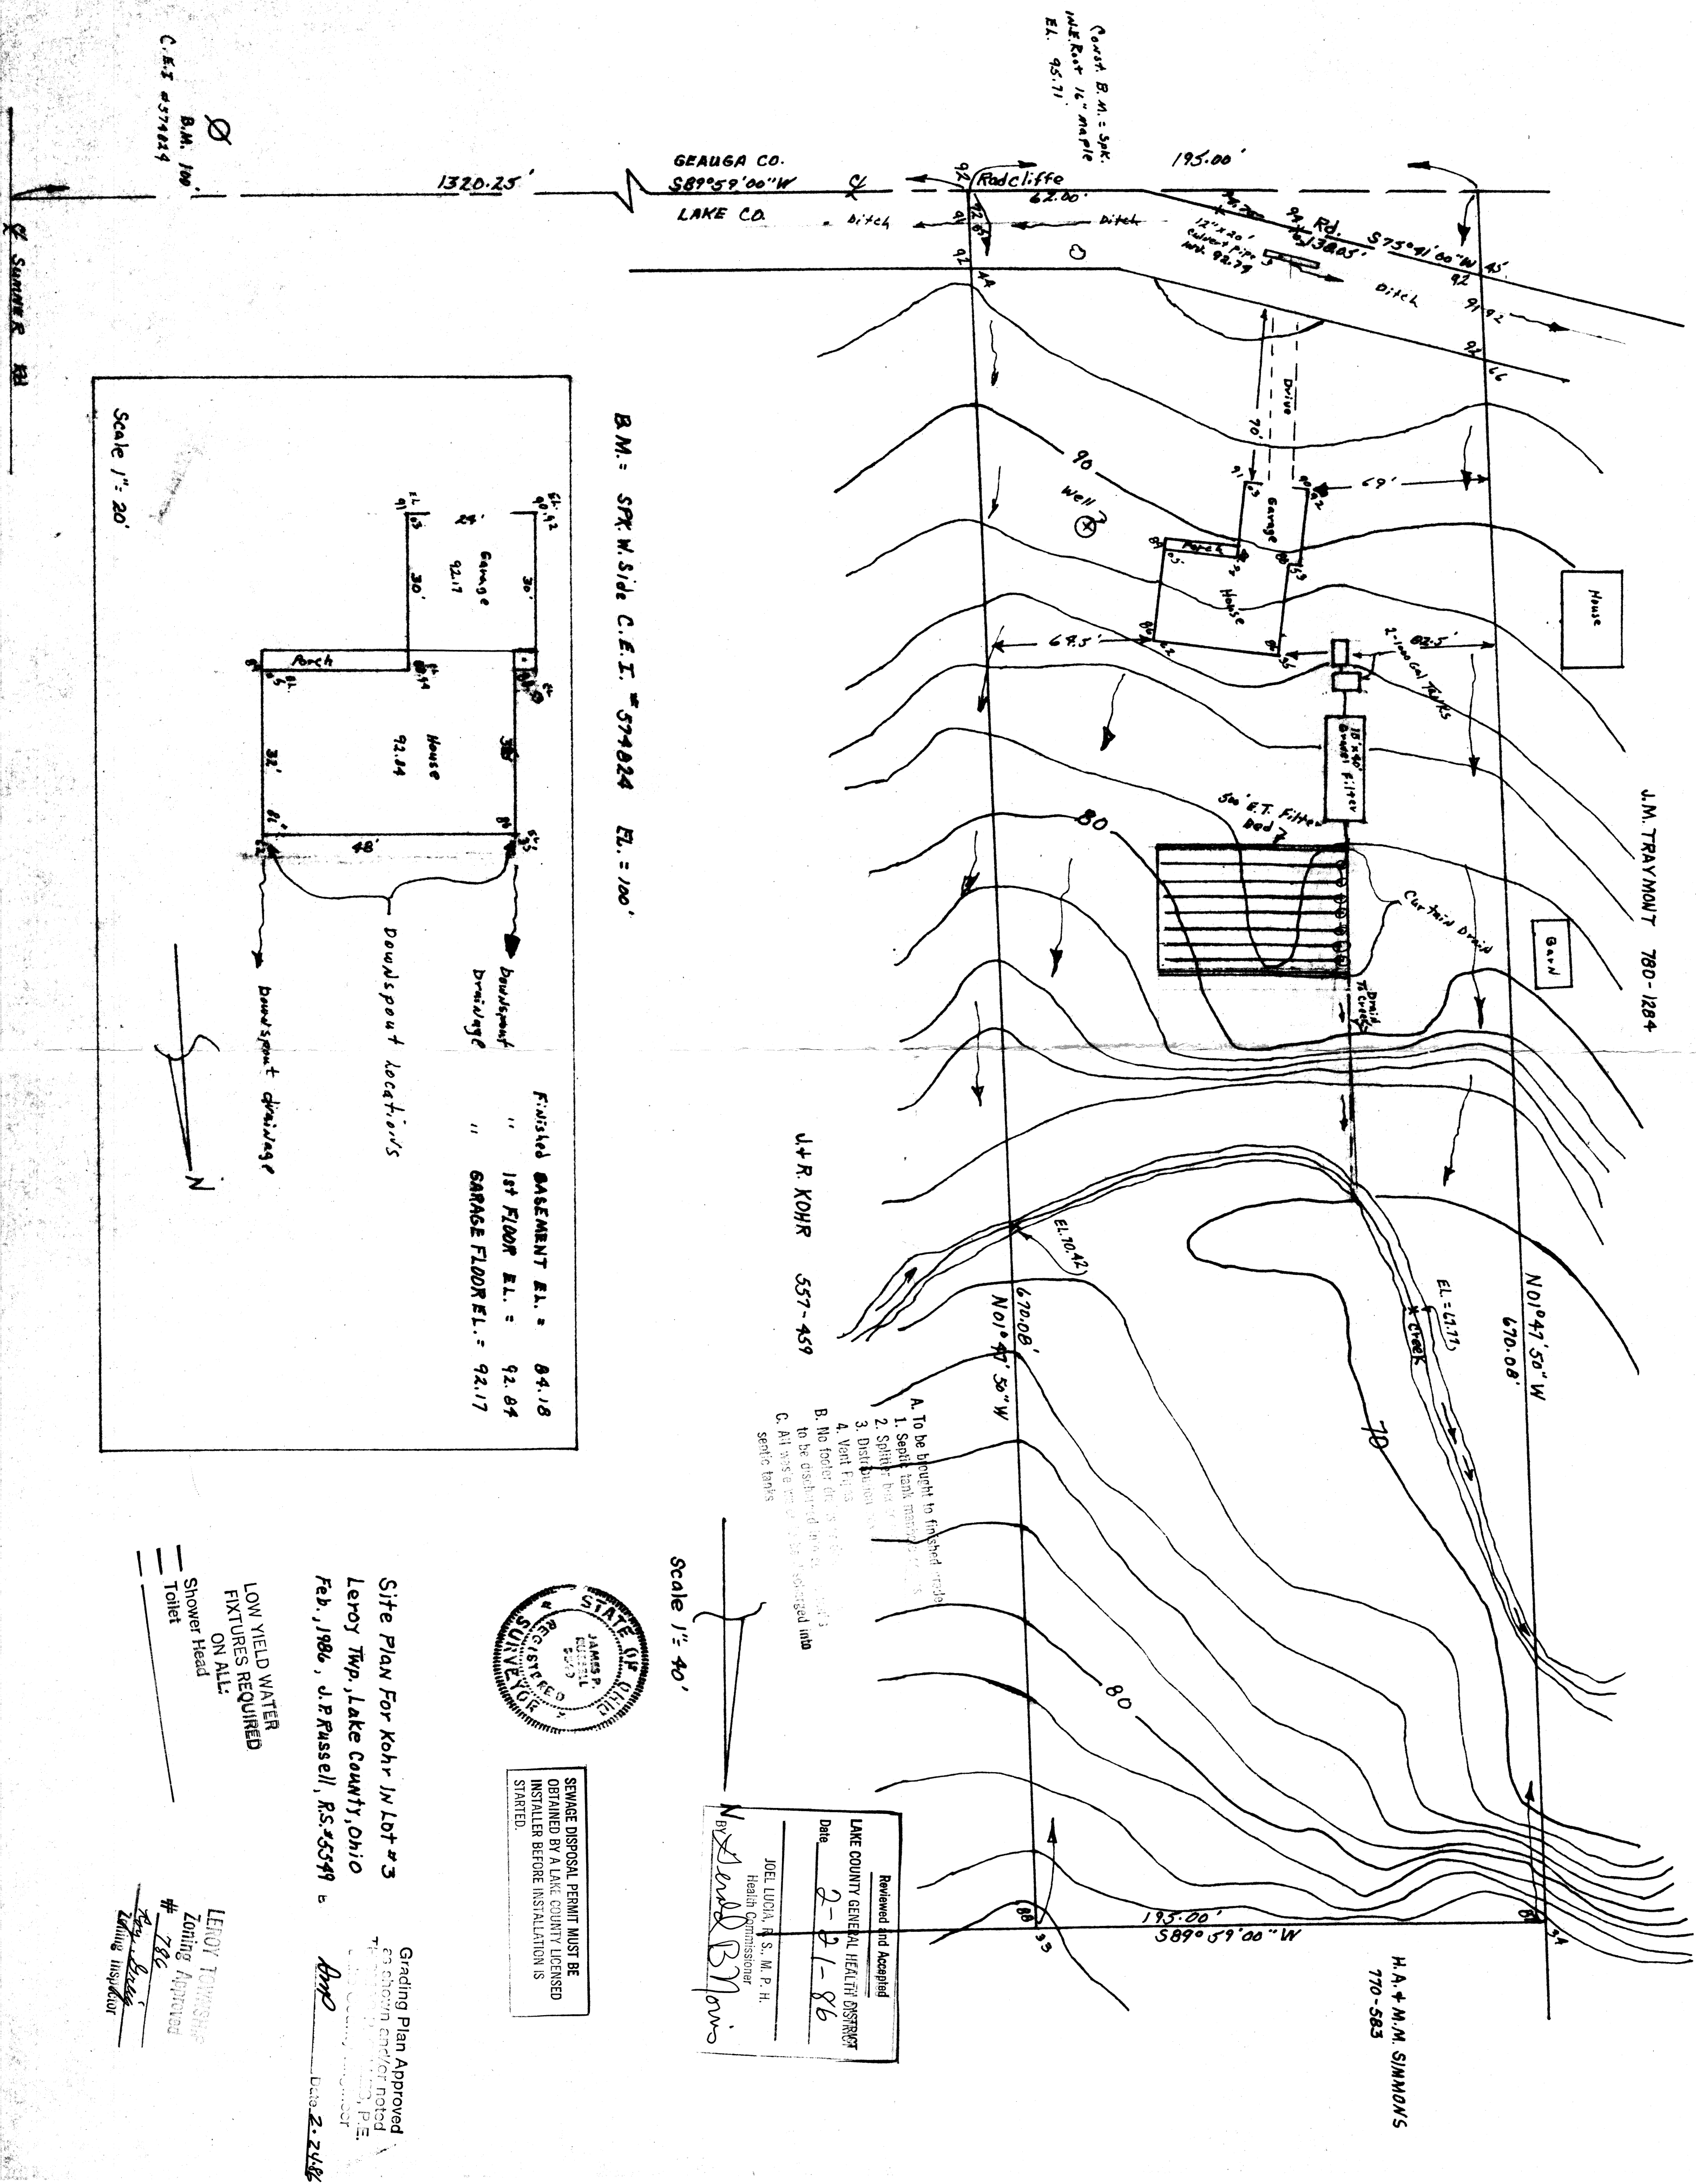

Ø
B.M. 100
C.E.T. #574024

Const. B. M. = Spk.
int. Root 16" maple
E.L. 95.71

GEAUGA CO.
S89°59'00"W
LAKE CO.

B.M. = SPR. W. Side C.E.I. # 574024 EL. = 100'

J.M. TRAYMONT 780-1284

344N

N 01° 47' 50" W

670.08'

EL. = 61.71

H.A. & M.M. SIMMONS
770-583

U. & R. KOHR 557-459

- A. To be brought to finished mode
1. Septic tank marked "A"
2. Splitter box
3. Distribution box
4. Vent Piping
- B. No floor drain to be installed to be discharged into
- C. At waste water to be discharged into septic tanks

Scale 1" = 40'

Reviewed and Accepted _____
 LAKE COUNTY GENERAL HEALTH DISTRICT
 Date 2-21-86

JOEL LUKA, R. S., M. P. H.
 Health Commissioner

N
 By Endel B. Novak

A circular seal with a serrated edge. The outer ring contains the text "STATE OF OHIO" at the top and "DEPARTMENT OF PUBLIC SAFETY" at the bottom. Inside the ring, the words "REGISTERED" and "SURVIVOR" are written vertically on the left and right sides, respectively. In the center, the text "JAMES P. HOGAN" is written above the year "1990".

SEWAGE DISPOSAL PERMIT MUST BE OBTAINED BY A LAKE COUNTY LICENSED INSTALLER BEFORE INSTALLATION IS STARTED.

Site Plan For Kohr In Lot #3
Leroy Twp, Lake County, Ohio
Feb., 1986, J.R. Russell, R.S. #5549

Grading Plan Approved
as shown and/or noted
T. J. & D. J. HARRIS, P.E.
Civil Engineering, Inc.
Date 2.24.88 THP

**LOW YIELD WATER
FIXTURES REQUIRED
ON ALL:
Shower Head
Toilet**

LEROY TOWNSHIP
 Zoning Approved
 # 786
Ray. B. B. B.
 Zoning Inspector