


PROFILE
NO SCALE

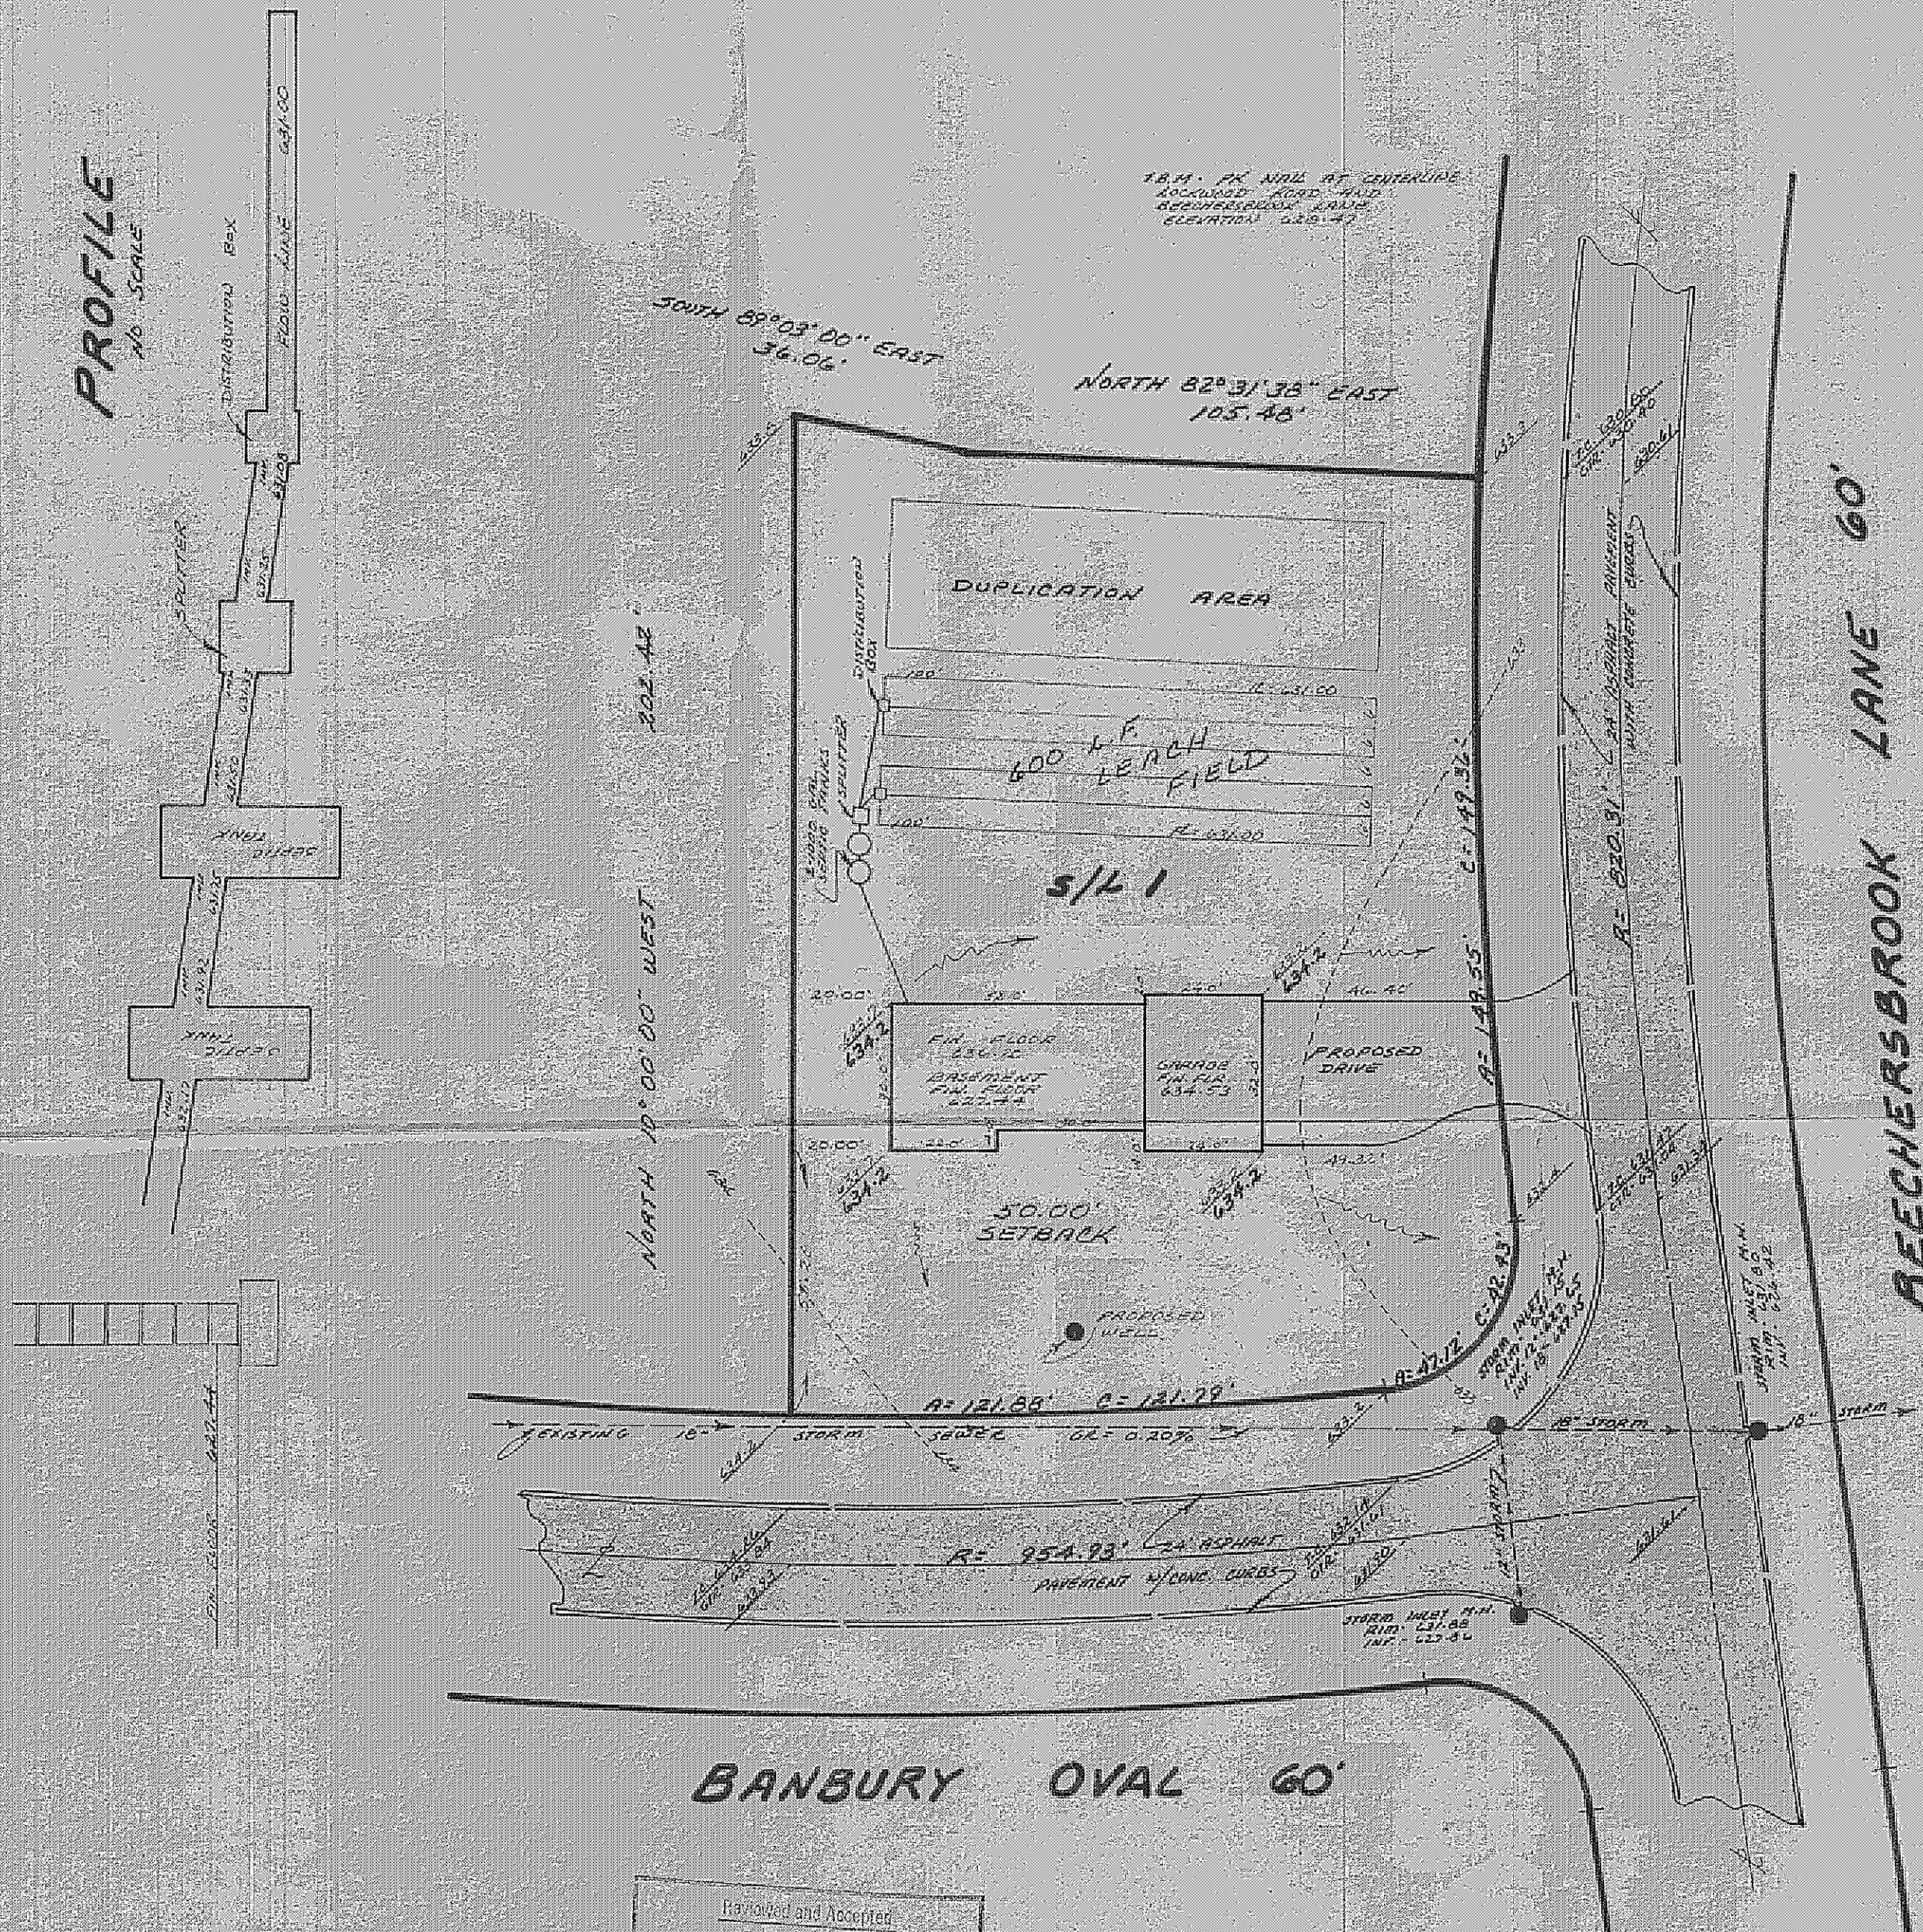

SITE PLAN

MADISON TOWNSHIP LAKE COUNTY, OHIO

for: **ANDY GULYAS**
CLIENT OWNER

ADDRESS STREET CITY ZIP

COBBLESTONE FARMS		LOT	TRACT
SUBDIVISION	NAME		
VOL. - PG.		VOLUME	PAGE
SUBLOT NO.	BEECHERSBROOK STREET	PERM. PARCEL NO.	STREET

LEGEND

SANITARY MANHOLE	1	WATER VALVE (GAS)	1
STORM MANHOLE	2	WATER METER (GAS)	1
INLET OR CATCH BASIN	3	AS BUILT ELEVATION	100.0
HYDRANT	4	INDICATES DIRECTION OF SURFACE DRAINAGE	100.0
EXISTING CONTOURS			
PROPOSED CONTOURS			
EXIST. ELEV.	100.0	PROP. ELEV.	100.0

REMARKS

ALL BOUNDARY DATA SHOWN WAS OBTAINED FROM (DEEDS, RECORDED SUBDIVISION PLAT OR OTHER PUBLIC RECORDS)
LOCATIONS AS SHOWN OF ADJACENT WELLS AND SEPTIC TANKS OBTAINED FROM LAKE COUNTY HEALTH DEPARTMENT

DESIGN CERTIFICATION

THIS PLAT WAS PREPARED BY ME, AND IS CORRECT TO THE BEST OF MY KNOWLEDGE AND BELIEF.
Edward W. Thomsen PS 6148
NAME SURVEYOR REGISTRATION NO.

CHECK LIST

NO. OF BEDROOMS	WATER MAIN SIZE, LOCATION
DIMENSIONS	SAN. SEWER SIZE % GR. LOC.
BEARINGS	SAN. MH. CAST ELEV. INV. ELEV.
TIE TO NEAREST STREET	SAN. CONN. SIZE, LOC. DEPTH
SUBLOT NO. PARCEL NO.	STORM SEWER SIZE % GR. LOC.
SURROUNDING OWNERS	STORM MH. CAST ELEV. INV. ELEV.
BLDG. DIMENSIONS FIN. GR.	PAV'T TYPE GRADE CURBS
BLDG. TIES F.T.B. GRADES	GAS LINE LOC. SIZE PRESSURE
APRON TYPE WIDTH THICKNESS	SEPTIC TANK LOCATION & DUPLICATION AREA
SIDEWALK TYPE WIDTH THICKNESS	WELL LOCATION
CULVERT TYPE DIA. LENGTH	ISOLATION RADIUS FROM WELL
ROCK OUTCROPPINGS	

REVISIONS

NO.	DATE	BY
1		
2		
3		
4		
5		

PLAN PREPARED BY:

DEBEVEC-SALO & ASSOCIATES, INC.
PAINESVILLE, OHIO

DRAWN BY	SCALE	PHONE NO.
CHK'D	DATE	DRAWING NO.
CREW CHIEF	APPRO.	

"AS BUILT" CERTIFICATION

I, HEREBY CERTIFY THAT THE CIRCLED GRADES ARE EXISTING FINISH GRADES CHECKED IN FIELD ON 19 BY SURVEYING AND ARE CORRECT TO THE BEST OF MY KNOWLEDGE AND BELIEF.

REGISTERED SURVEYOR REG. NO.

Reviewed and Accepted
LAKE COUNTY COMBINED GENERAL DISTRICT DEPARTMENT OF HEALTH
Date 4-14-77
FRED E. REUT, M.D.
Health Commissioner
By *[Signature]*

- A. To be brought to finished grade
1. Septic tank manhole covers
2. Splitter box cover
3. Distribution box cover
4. Vent Pipes
B. No footer drains or downspouts to be discharged into septic tanks
C. All waste water to be discharged into septic tanks

Grading Plan Approved as shown and/or noted
THOMAS P. GILLES, P.E.
Lake County Engineer
By *[Signature]* 4-15-77